
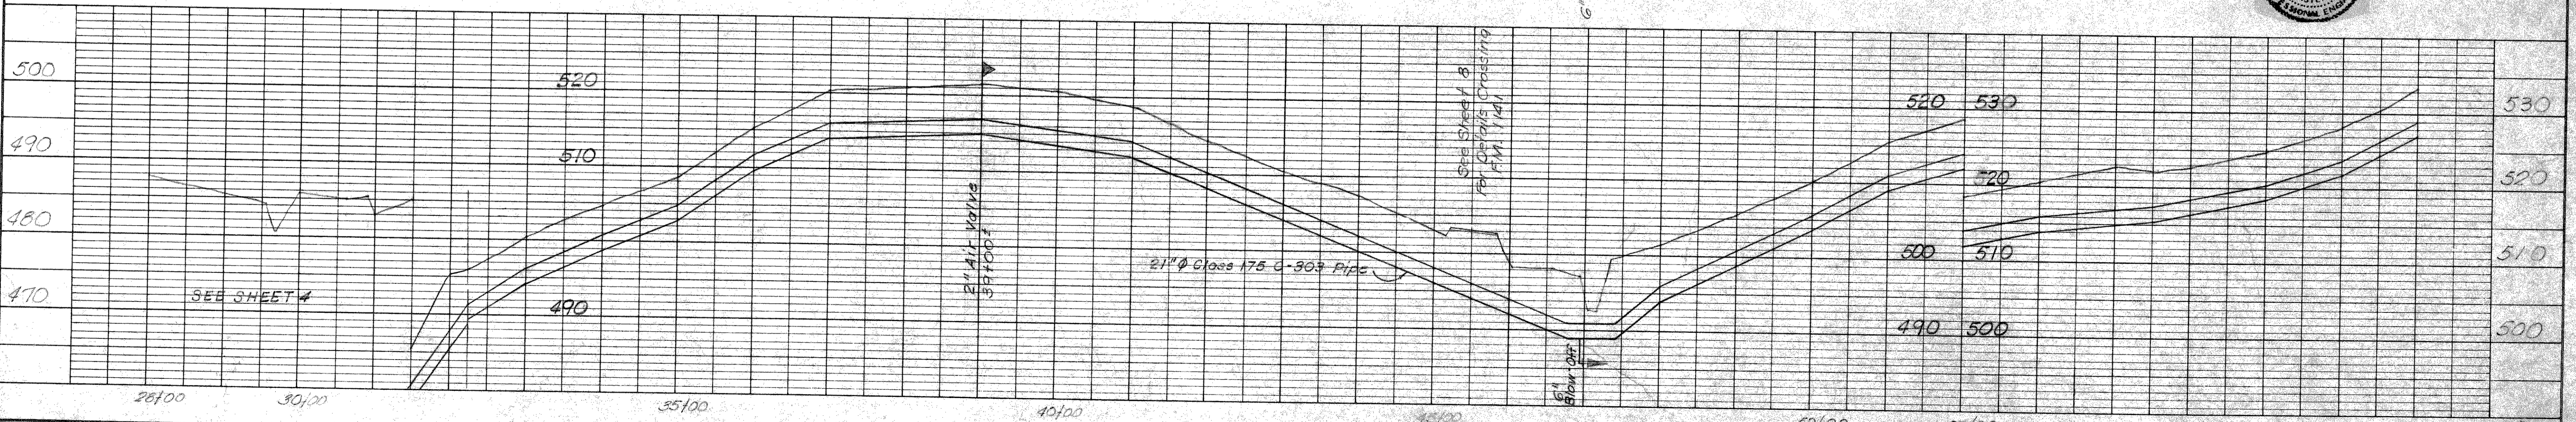
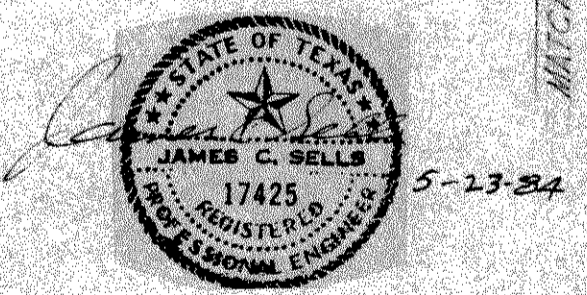
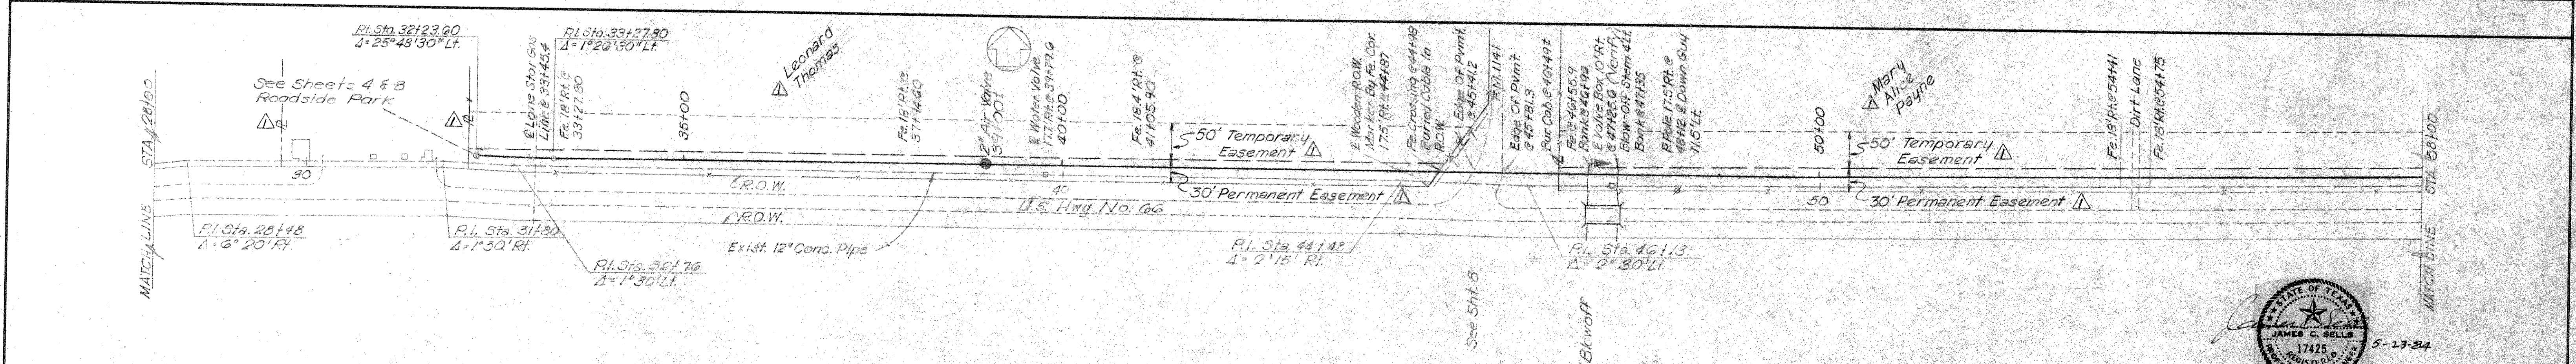


SEE SHEET 4
For Proposed 21" ϕ Pipeline

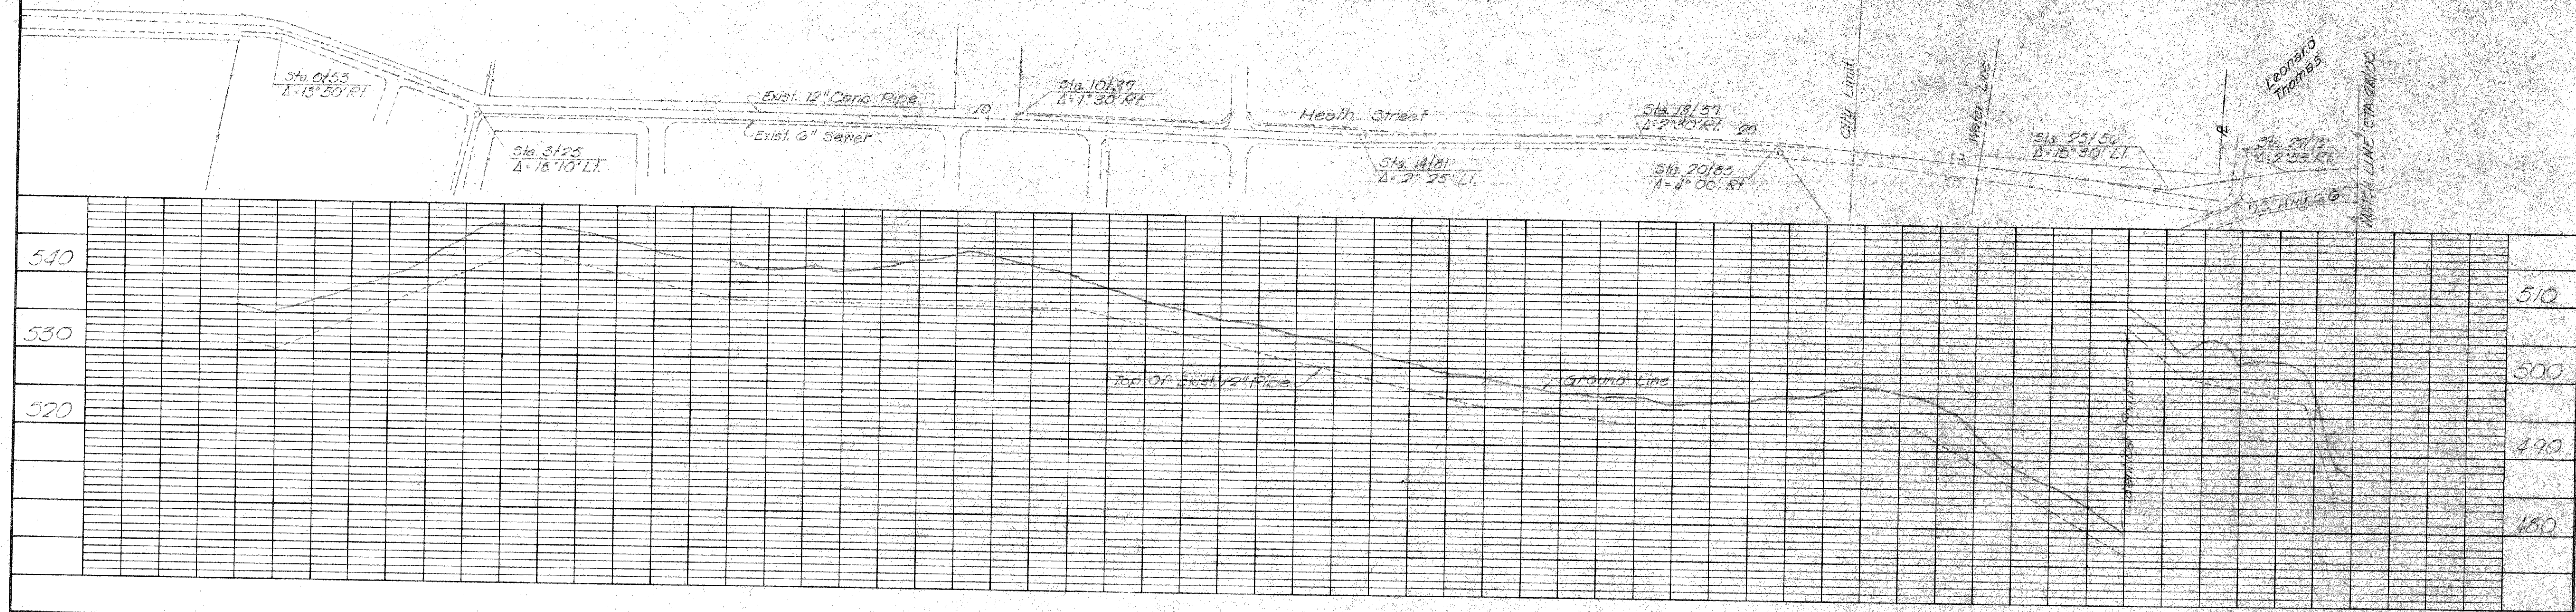

7-3-84 DATE	Add "L" Easement And Property Lines Added REVISION	DESIGNED JCS DRAWN DS TRACED YAR CHECKED	JOB NO. MTD 83099B DATE SCALE AS SHOWN	FREESE AND NICHOLS CONSULTING ENGINEERS FORT WORTH - AUSTIN, TEXAS	NORTH TEXAS MUNICIPAL WATER DISTRICT WATER TRANSMISSION SYSTEM	ROCKWALL STATION TO CASH PIPELINE PLAN AND PROFILE	SHEET 5 OF 11
----------------	---	--	--	--	---	---	------------------