




PLANT SITE
SCALE: 1" = 20'

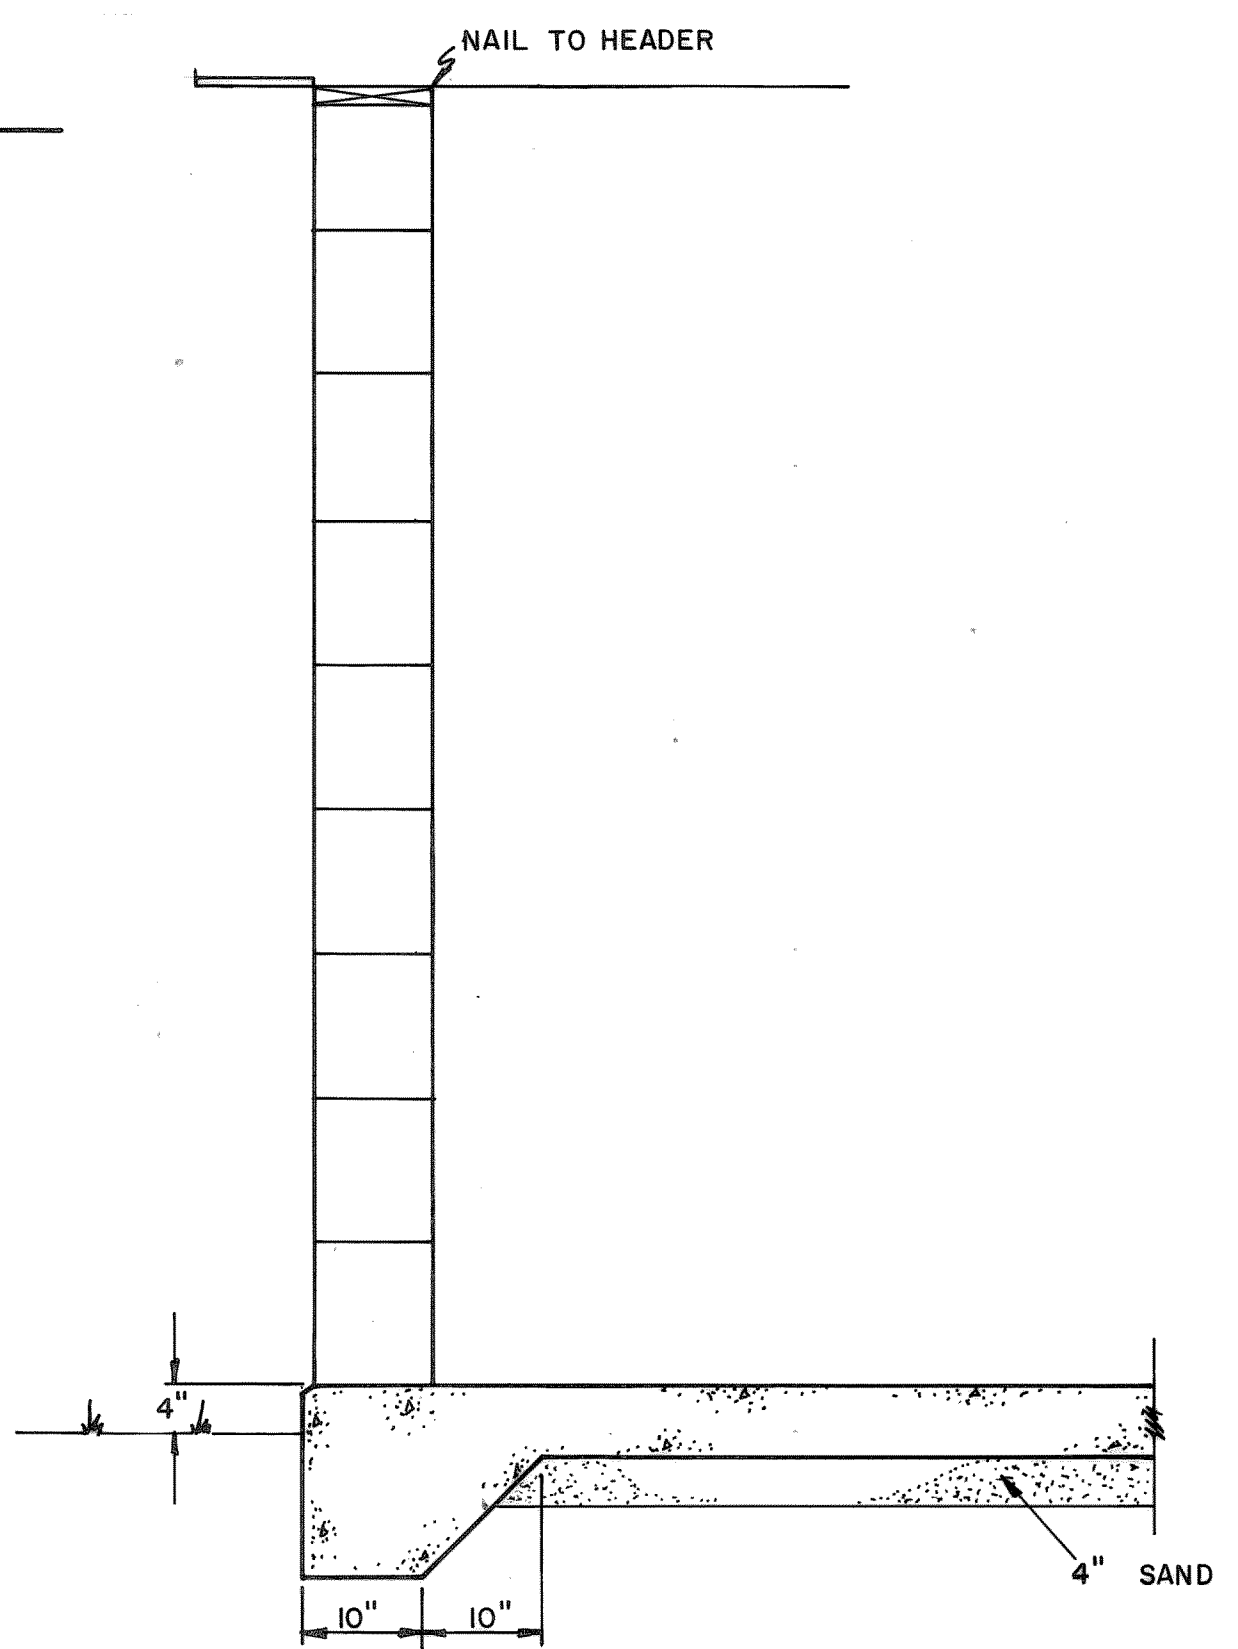


WALL SECTION 1
SCALE: 3/4" = 1'-0"

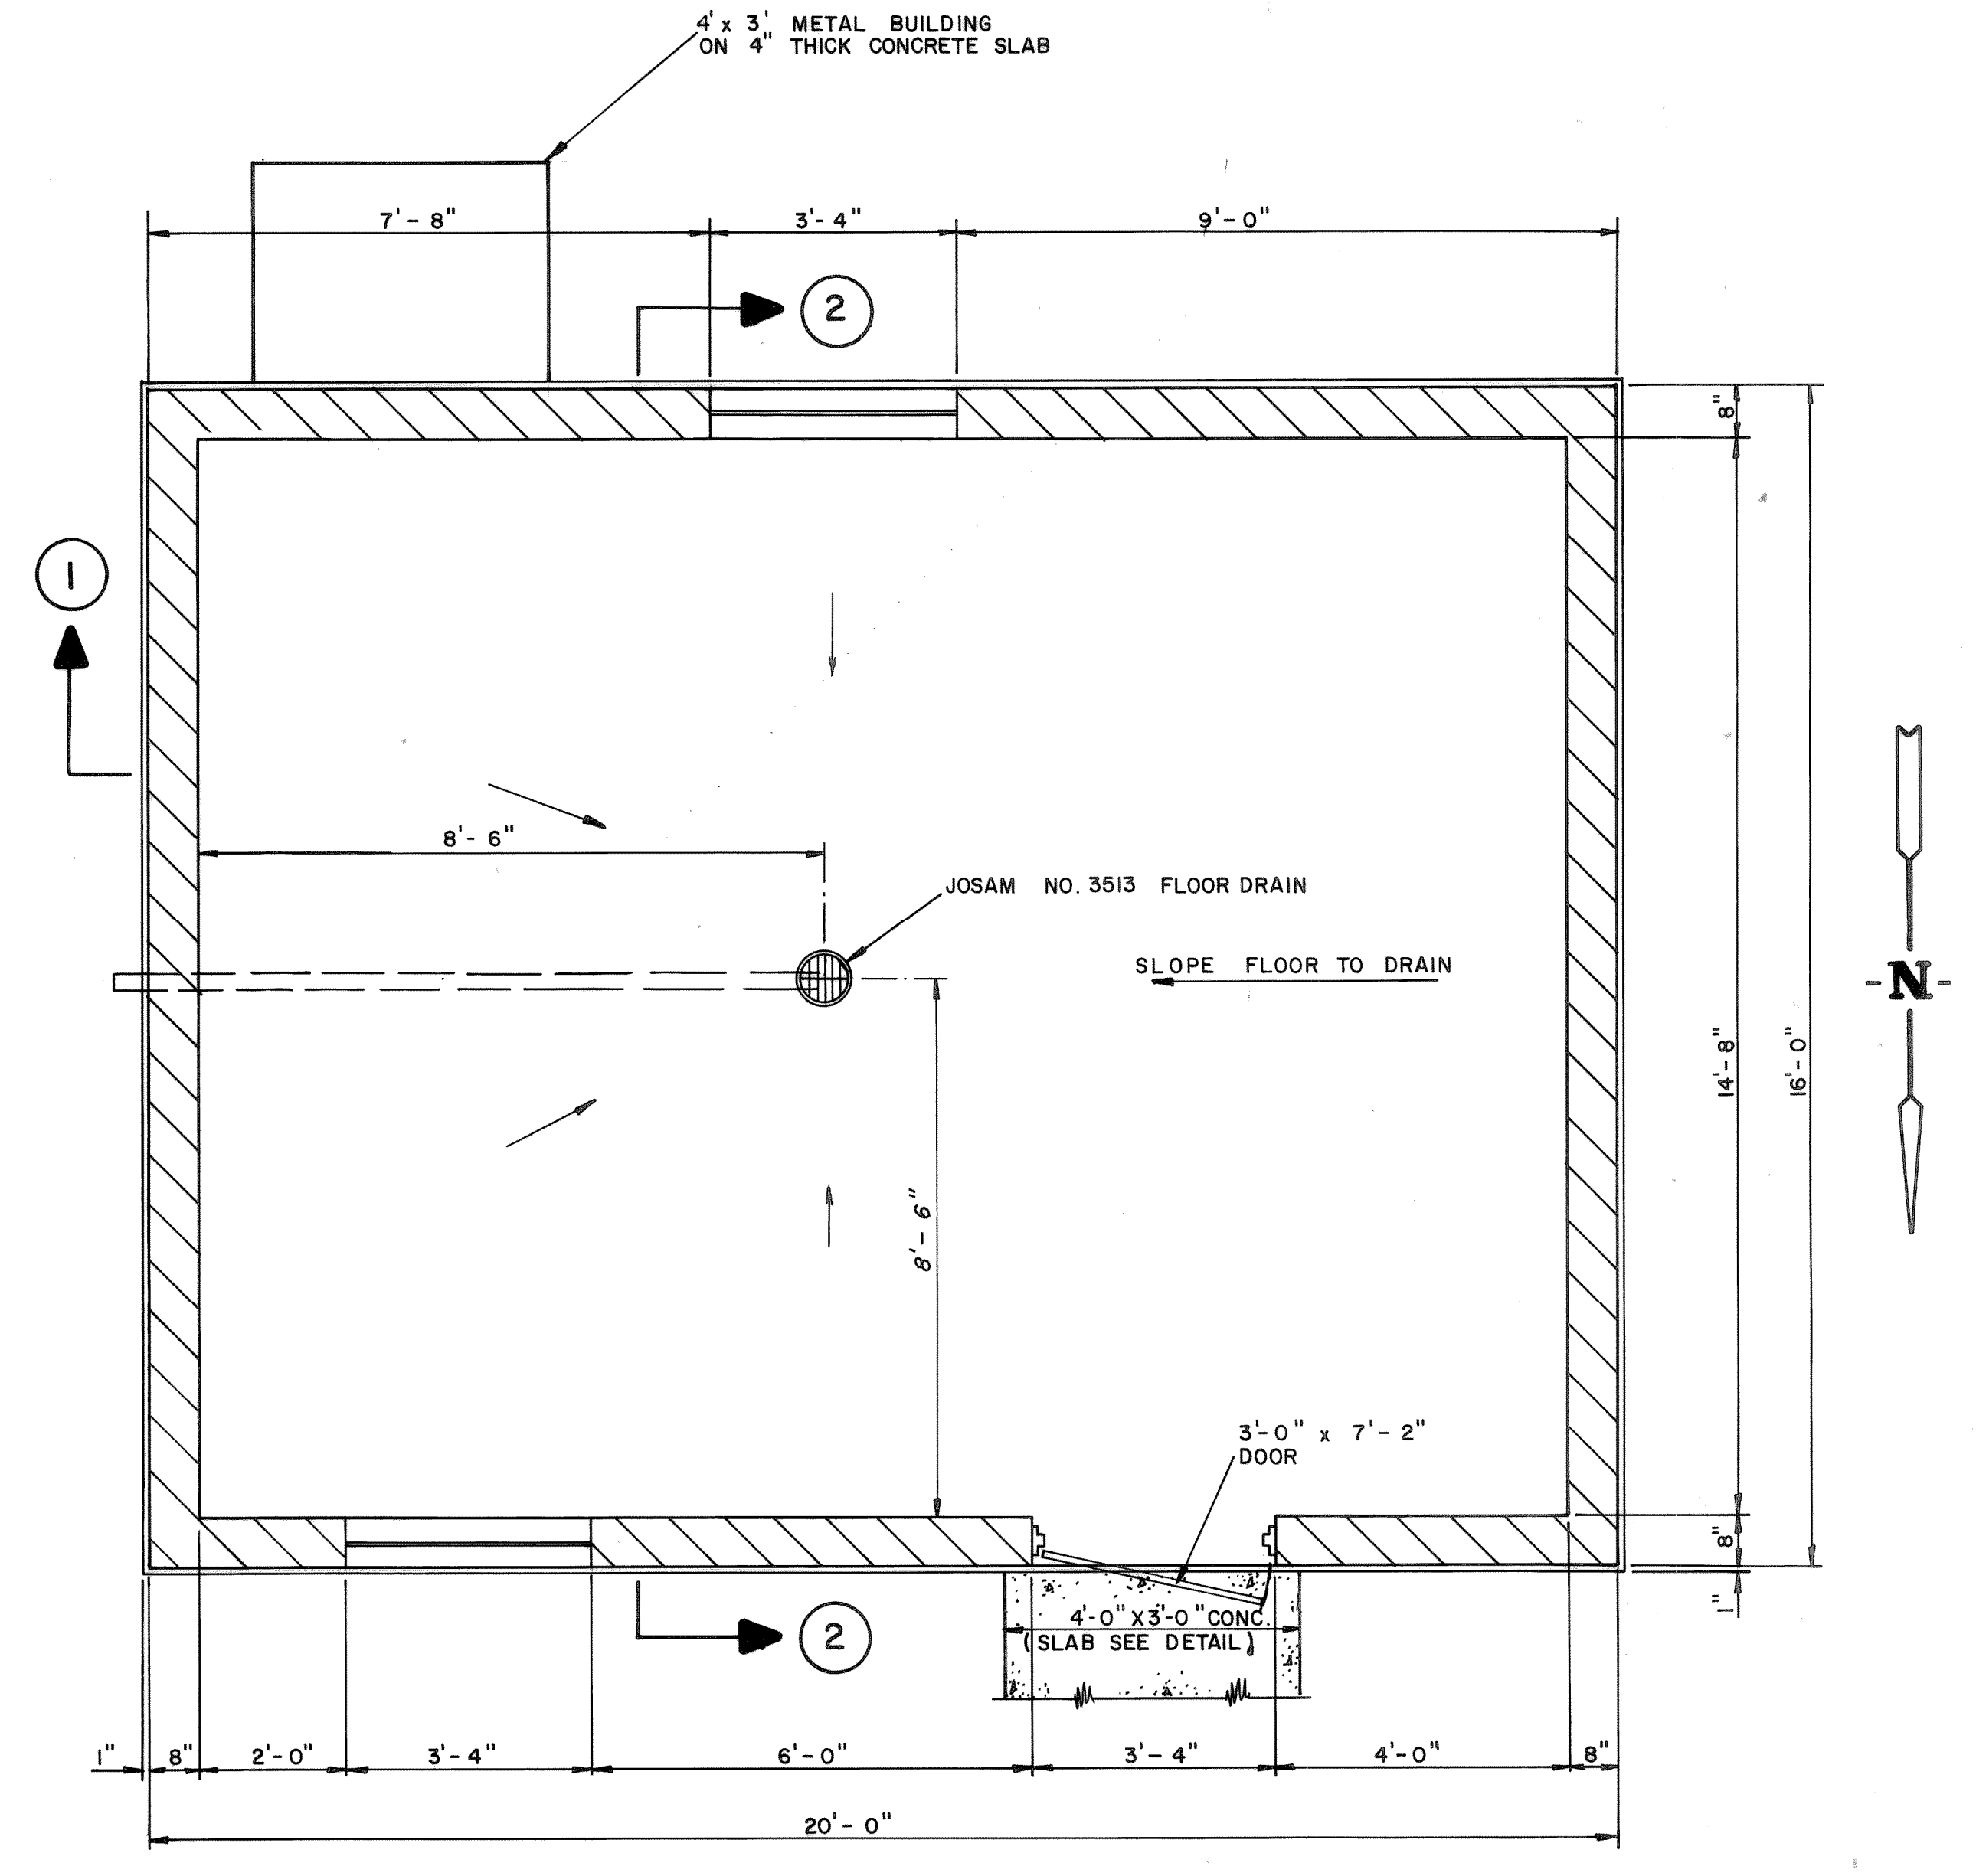


PUMP HOUSE PLAN
SCALE: 1/2" = 1'-0"

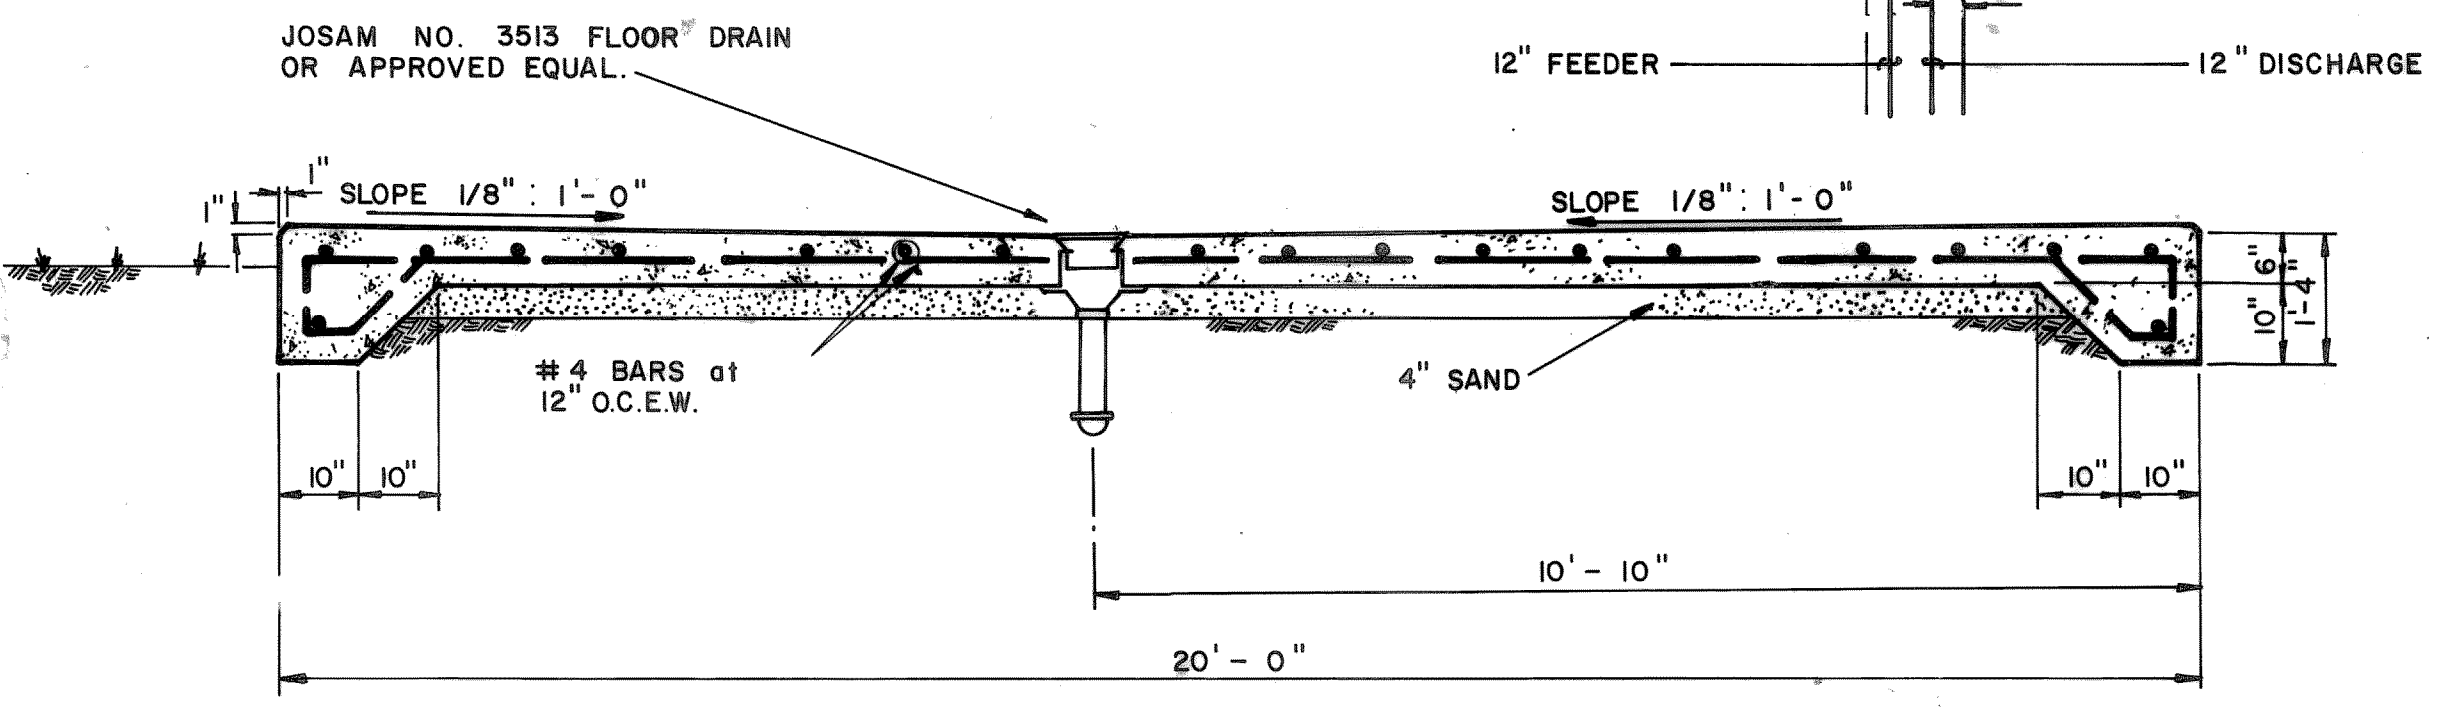


SECTION 2
SCALE: 1/2" = 1'-0"

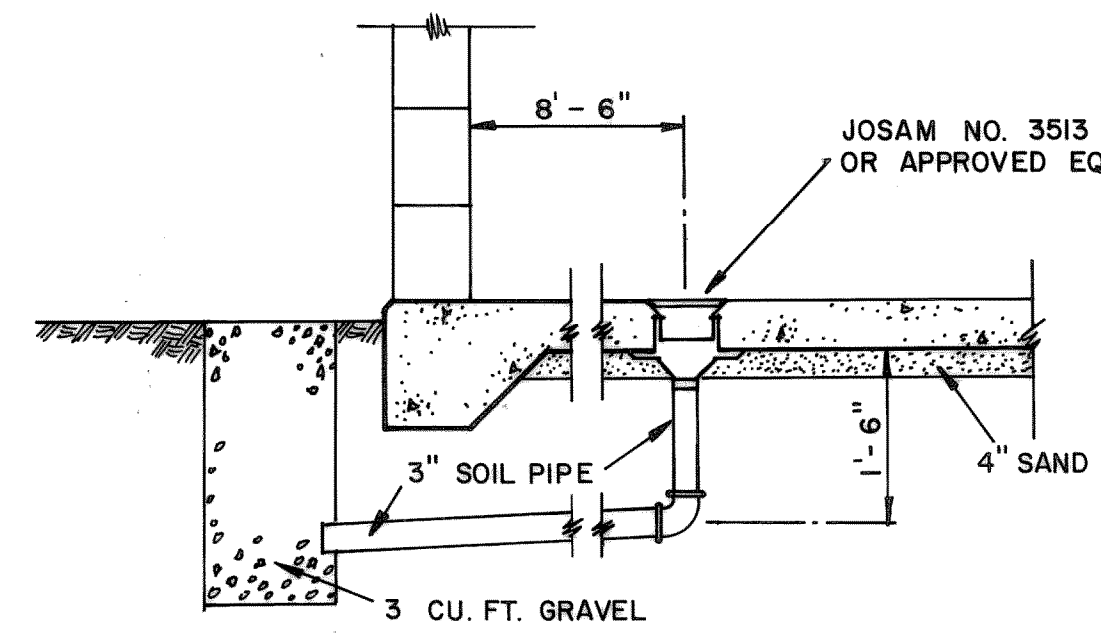

DRAIN DETAIL
SCALE: 1/2" = 1'-0"

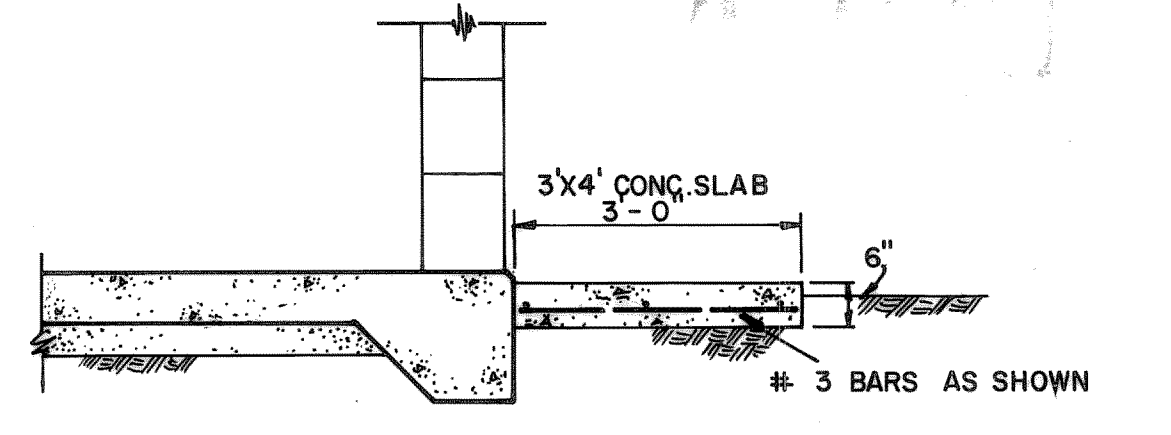

CONCRETE LANDING DETAIL
SCALE: 1/2" = 1'-0"

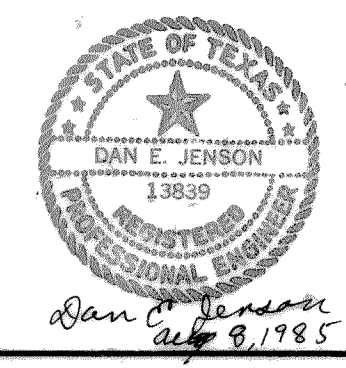

HAROLD L. EVANS
CONSULTING ENGINEER
2331 GUS THOMASSON RD. SUITE 102
DALLAS, TEXAS 75228
PHONE (214) 328-8133

SCALE	DATE	JOB NO.
AS SHOWN	8-8-85	78144

BLACKLAND WATER SUPPLY CORP.
WATER DISTRIBUTION CENTER
PUMP HOUSE DETAILS
ROCKWALL COUNTY, TEXAS

1-17-86	8" WTR. LINE ADDITION
9-16-85	REVISED (DESIGN REQUIREMENTS)