




PLAN

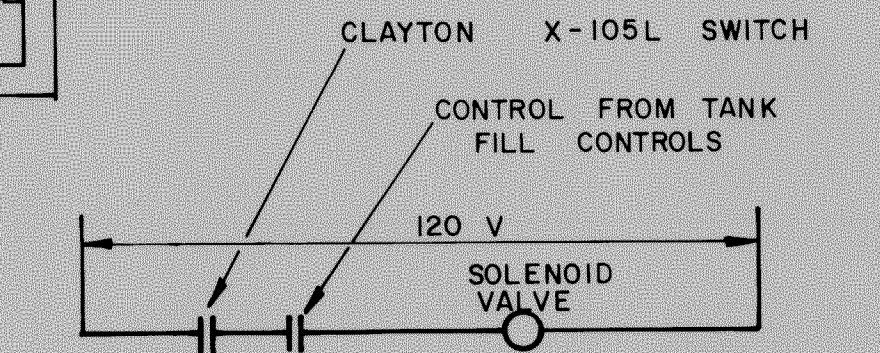


CHLORINE CONTROL SCHEMATIC

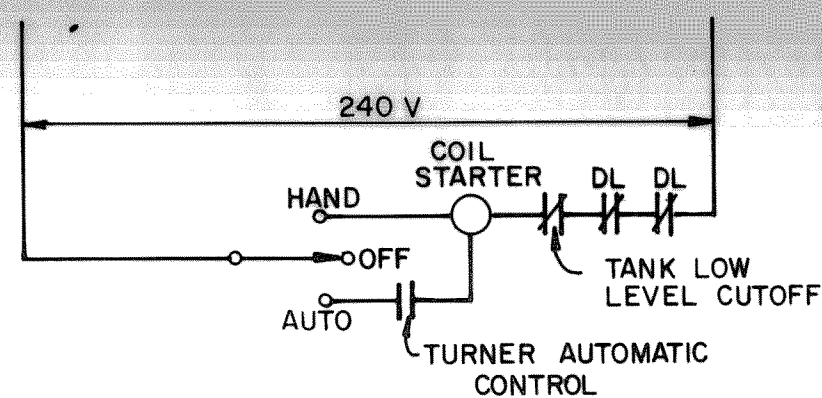

BOOSTER PUMP CONTROL SCHEMATIC

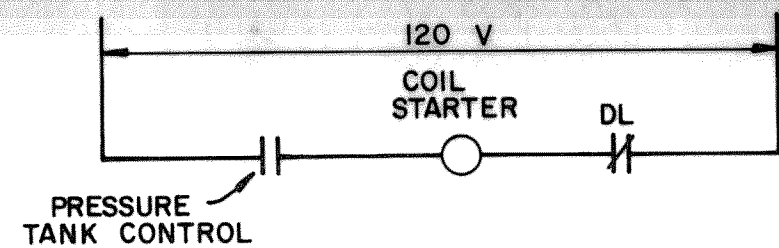

AIR COMPRESSOR CONTROL SCHEMATIC

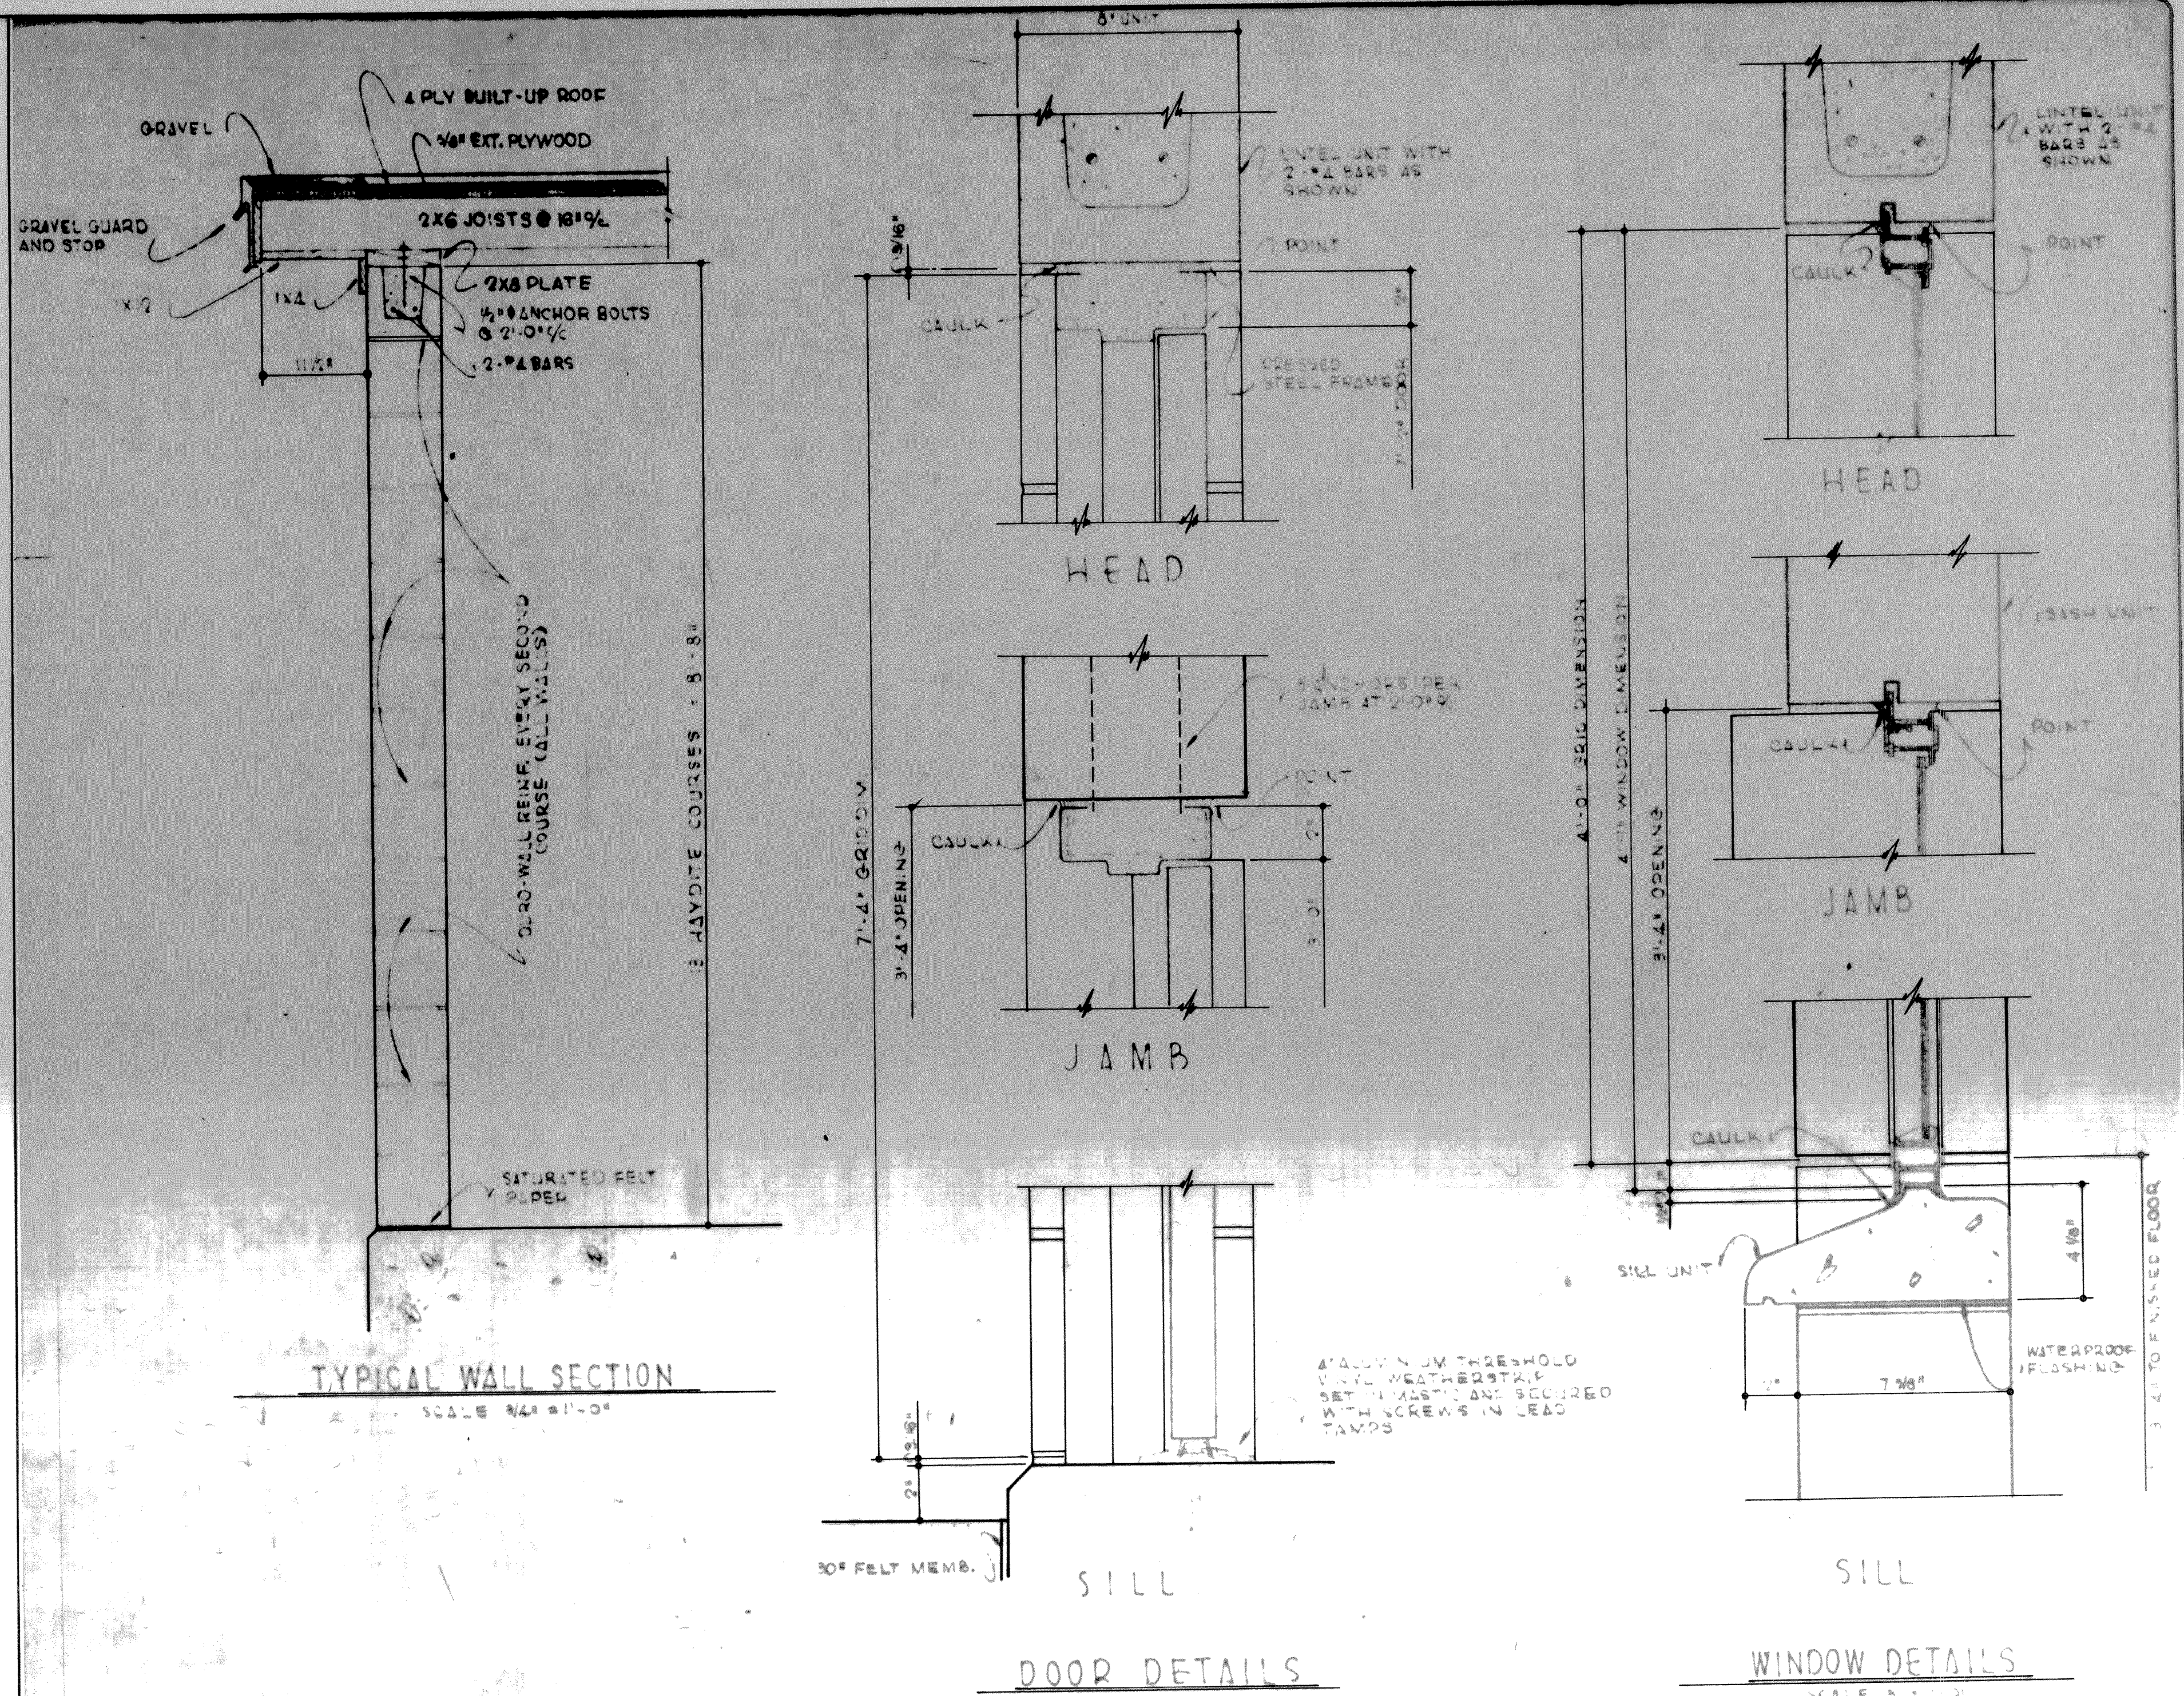


TYPICAL WALL SECTION

DOOR DETAILS


WINDOW DETAILS

NOTE: ALL 10" VENTILATORS SHALL BE BREIDERT TYPE L ON TYPE FR-4 BASE WITH INSECT SCREEN AND DAMPER OR APPROVED EQUAL

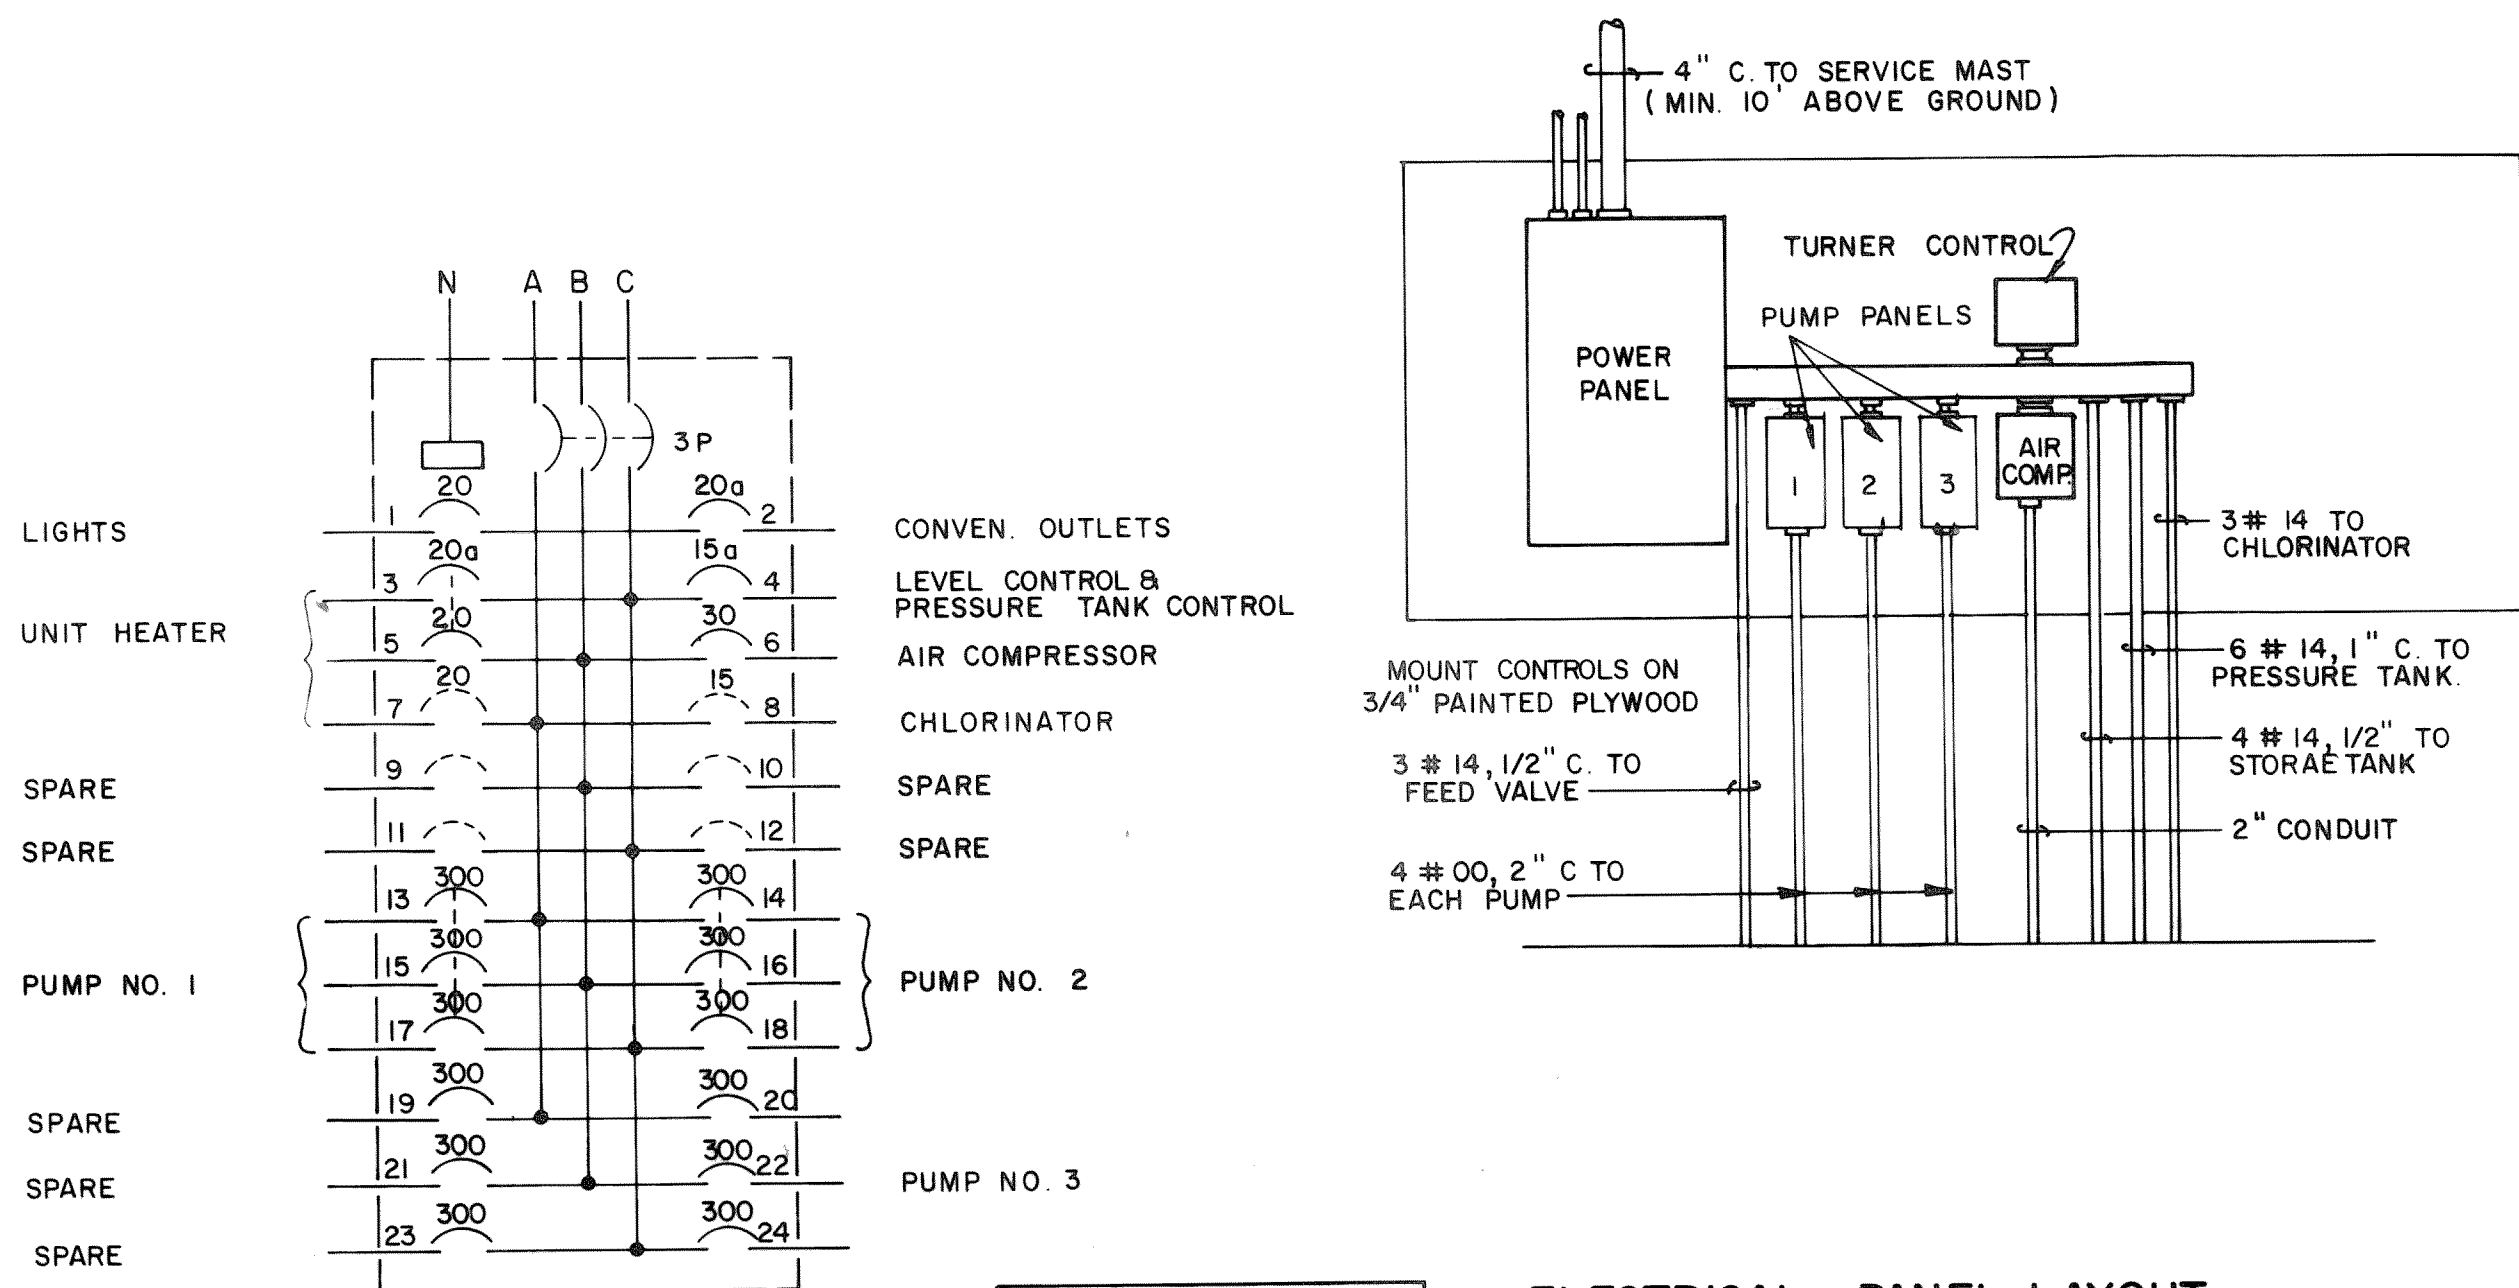


ELECTRICAL PANEL LAYOUT

ELECTRICAL DETAILS

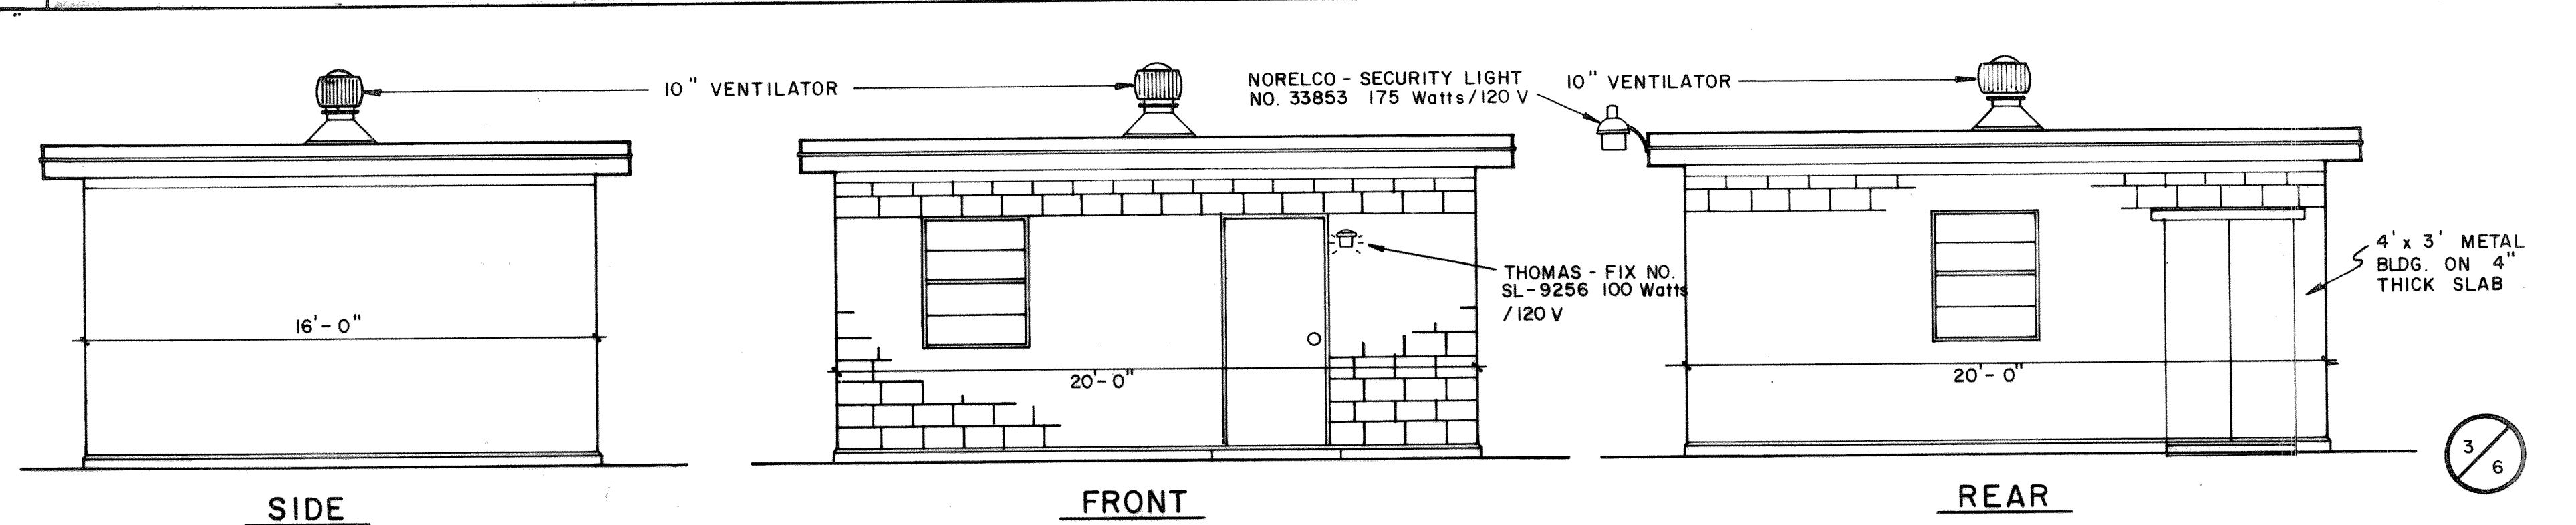

PUMP HOUSE ELEVATIONS

SCALE: 1/4"=1'-0"

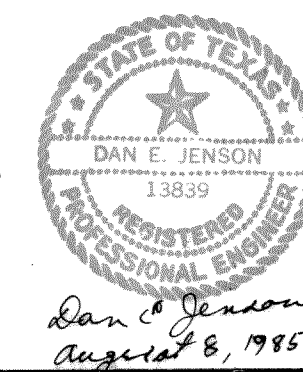

HAROLD L. EVANS
CONSULTING ENGINEER
2331 GUS THOMASSON RD. SUITE 102
DALLAS, TEXAS 75228
PHONE (214) 328-8133

BLACKLAND WATER SUPPLY CORP.
WATER DISTRIBUTION CENTER
ARCHITECTURAL & ELECTRICAL DETAILS
ROCKWALL COUNTY, TEXAS