

Scale: 1" = 40'

Pl. & P.C. of 24.84
41°52'50" Rt.

P.I. of 10
45°00'00" Lt.

Begin Section 2
0+00 Remove
Exist. 16" Plug And
Blanking

Exist. Valve Box

R.W. Andrews
4.979 A.C.
C 157 A.C.



Henry S. Miller Trustee
41.864 A.C.

R=1452.5
Δ=03°21'05"
L=211.71
T=106.04

R=1547.50'
Δ=07°25'19"
L=200.61'
T=100.45'

MATCH LINE STA. 5+00

MATCH LINE STA. 6+00

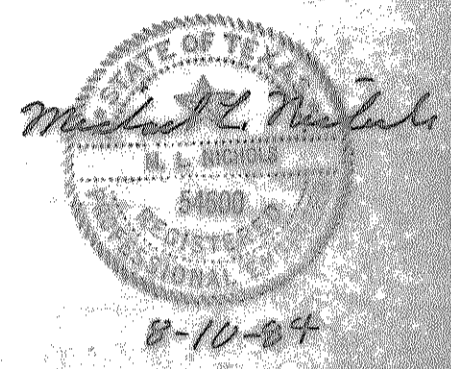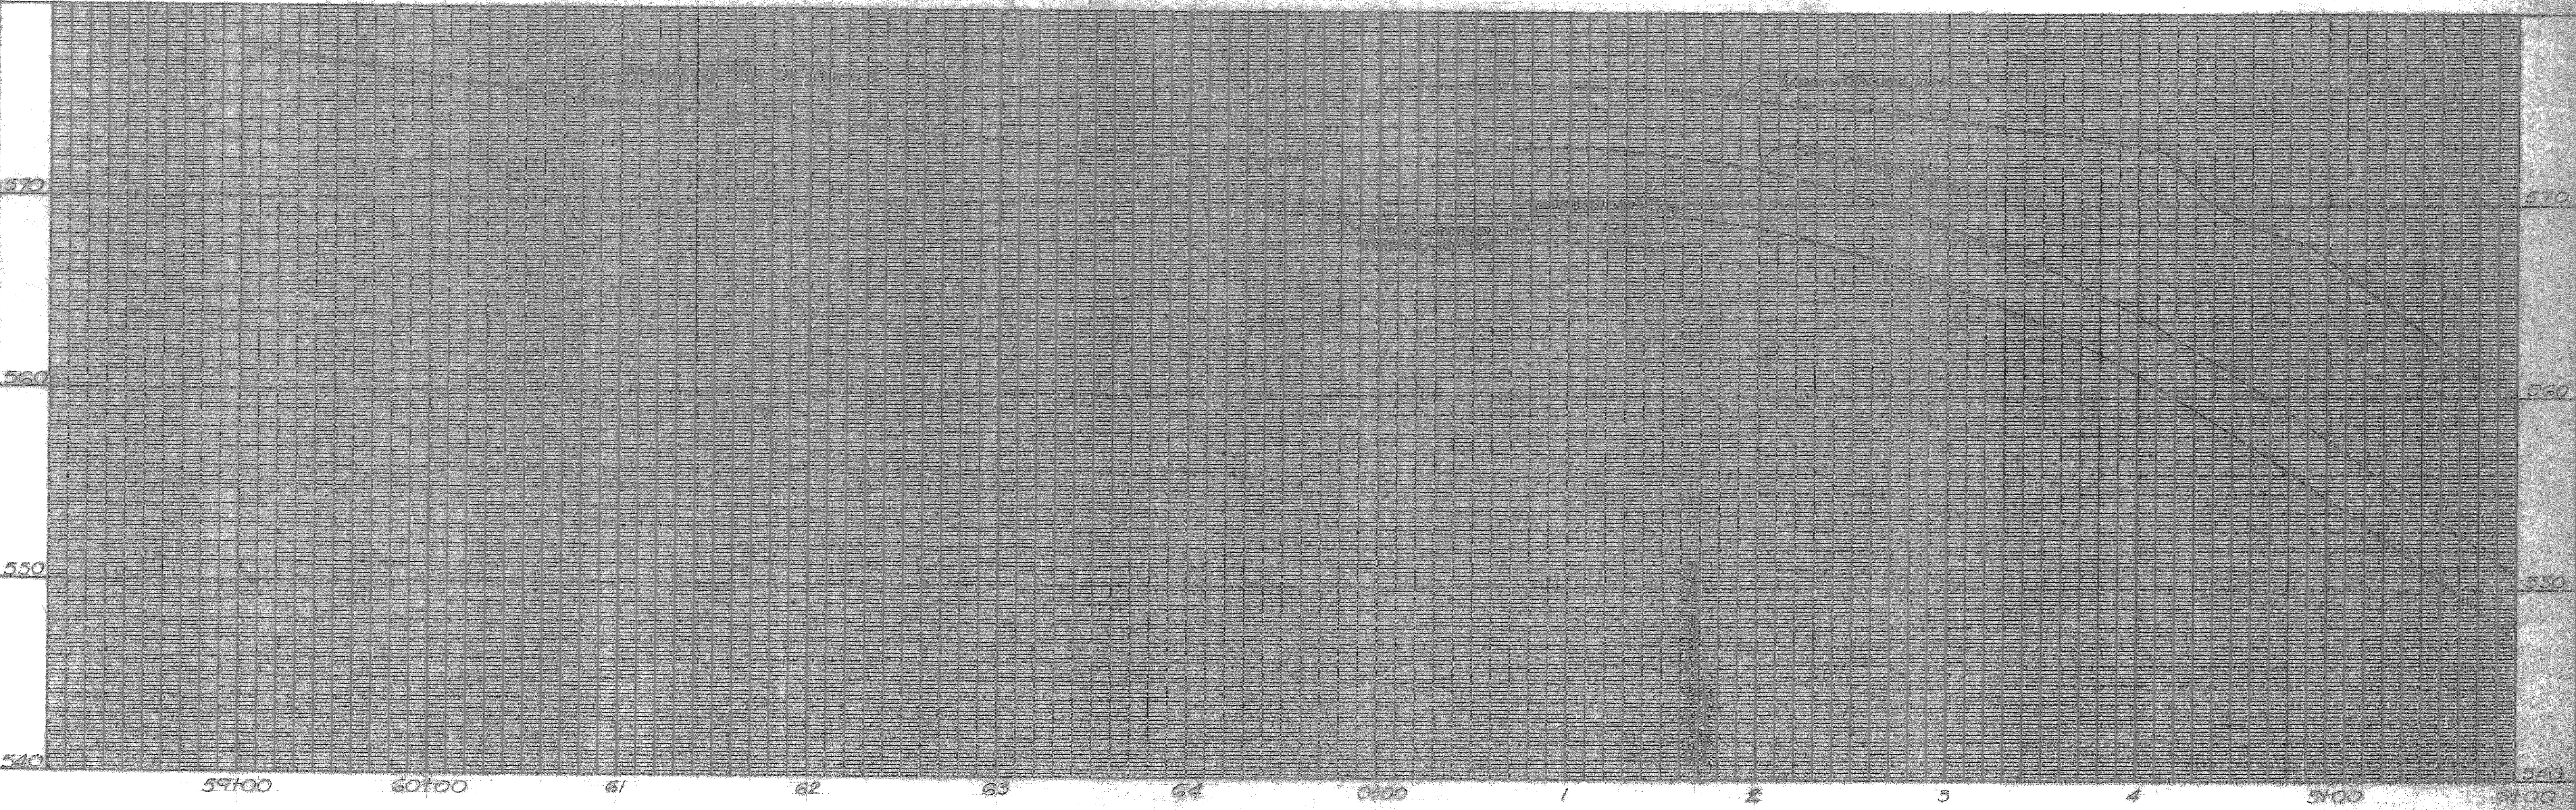

DESIGNED	MLN	JOB NO.	ROK 84063
DRAWN	MLN	DATE	
TRACED		SCALE	H=40' V=4'
CHECKED			

FRESE AND NICHOLS
CONSULTING ENGINEERS
FORT WORTH-AUSTIN, TEXAS

CITY OF ROCKWALL
16" FEEDER MAIN

PLAN AND PROFILE
STA. 0+00 TO STA. 6+00

SHEET
7 of 15