



These plans and related specifications were prepared for construction of this specific project only. Reuse of these documents is not permitted without written authorization of Birkhoff, Hendricks & Carter, L.L.P.

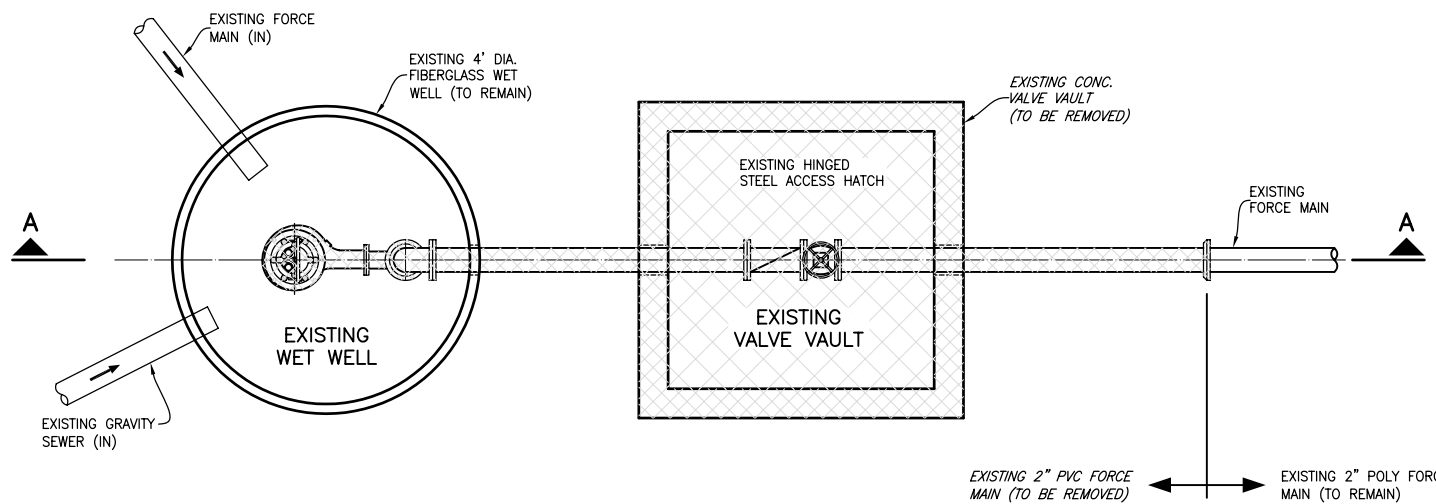

EXISTING PLAN VIEW
NOT TO SCALE

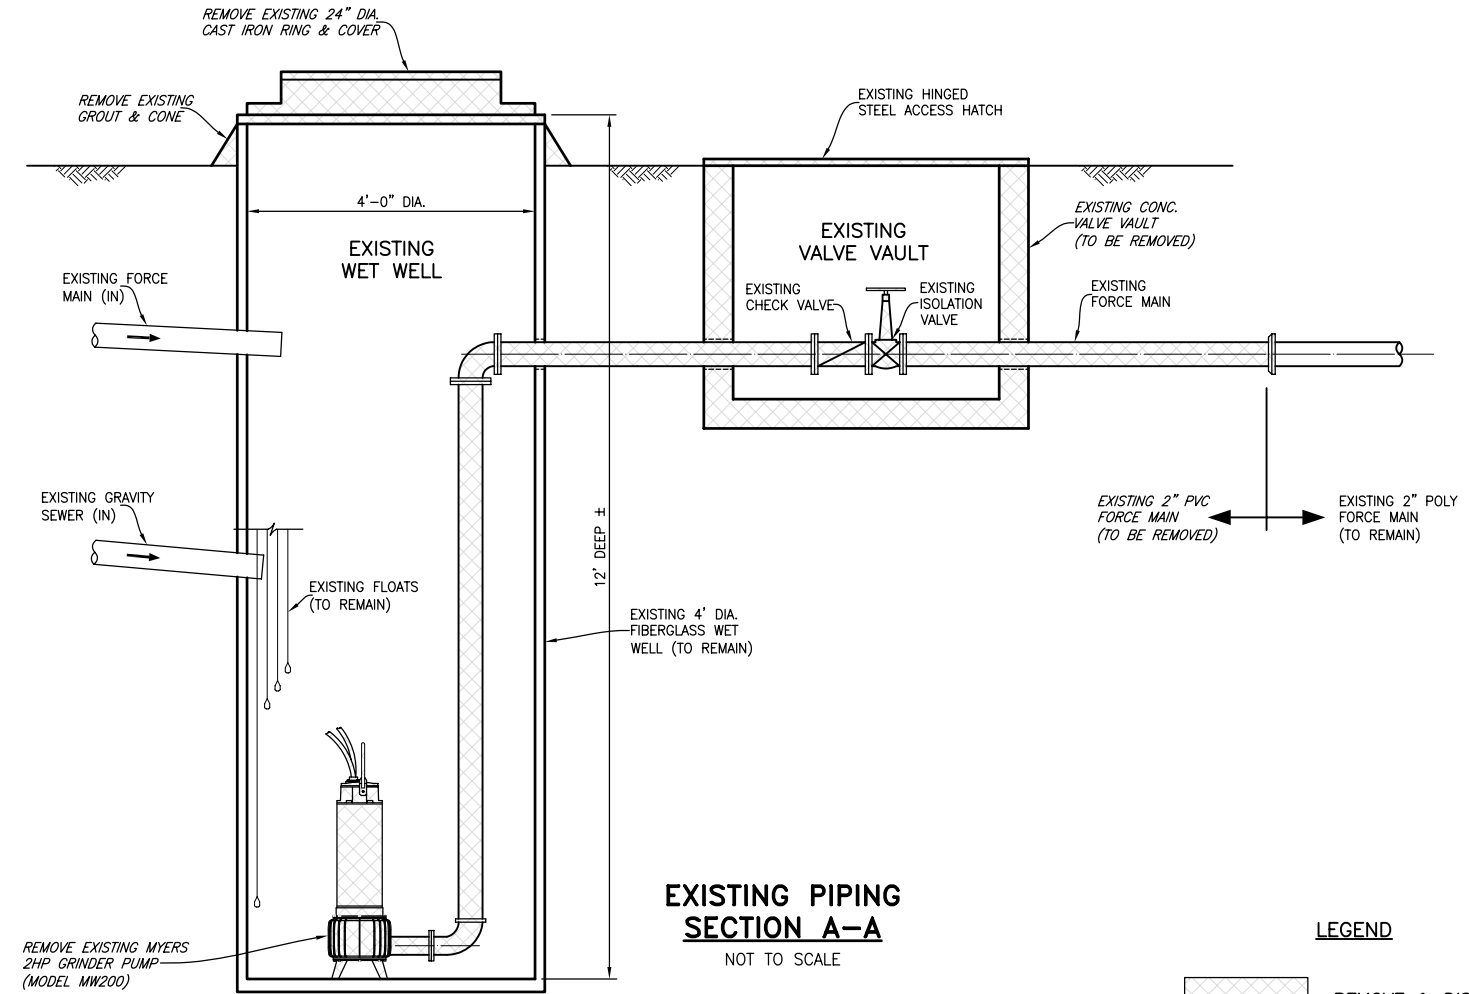


EXISTING PIPING SECTION A-A
NOT TO SCALE

LEGEND
 REMOVE & DISPOSE

NOTE:
 EXISTING CONTROL PANEL AND RADIO EQUIPMENT SHALL BE REMOVED AND DELIVERED TO THE CITY OF ROCKWALL SERVICE CENTER. PAYMENT SUBSIDIARY TO BID ITEM NO. 102.

This record drawing is a compilation of the sealed engineering drawing for this project; modified by addenda, change orders and information furnished by the contractor. The information shown on the record drawings that was provided by the contractor or others not associated with the design engineer cannot be verified for accuracy or completeness. This original sealed drawings are on file at the offices of Birkhoff, Hendricks & Carter, L.L.P.
 BY P.A.C. DATE 12/17/12

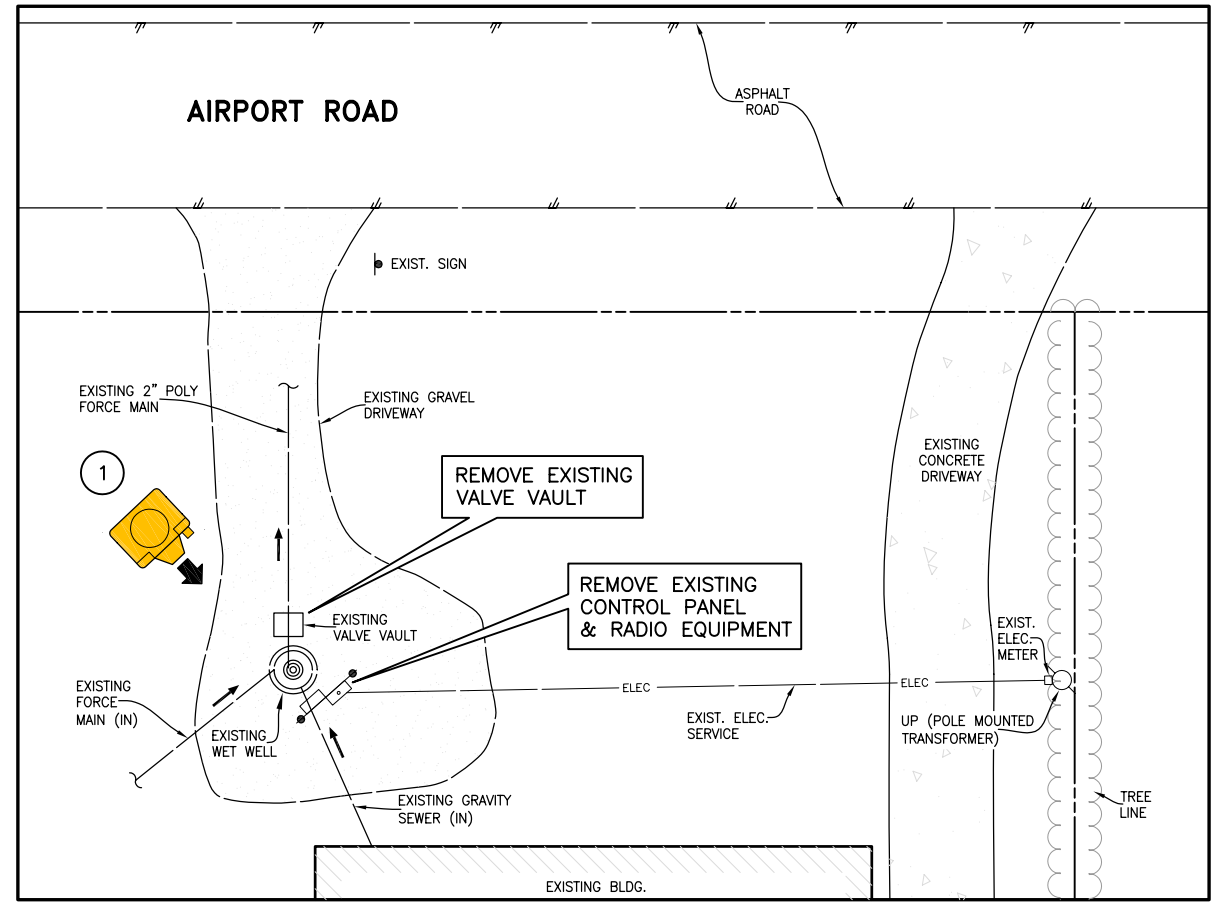


EXISTING SITE PLAN
NOT TO SCALE



PICTURE 1

BIRKHOFF, HENDRICKS & CARTER, L.L.P.
 PROFESSIONAL ENGINEERS
 Texas Firm F526
 11910 Greenville Ave., Suite 600
 Dallas, Texas 75243 (214) 361-7900

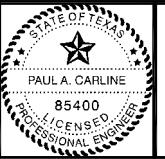

12/1/12

CITY OF ROCKWALL, TEXAS
 AIRPORT ROAD LIFT STATION IMPROVEMENTS
 DEMOLITION PLAN & SECTION

BHC
 PROJECT NO.
 4055-218
 DECEMBER 2010

SHEET NO.
2