


CITY OF ROCKWALL, TEXAS

CONSTRUCTION PLANS FOR

DALTON ROAD LIFT STATION, FORCE MAIN AND SANITARY SEWER

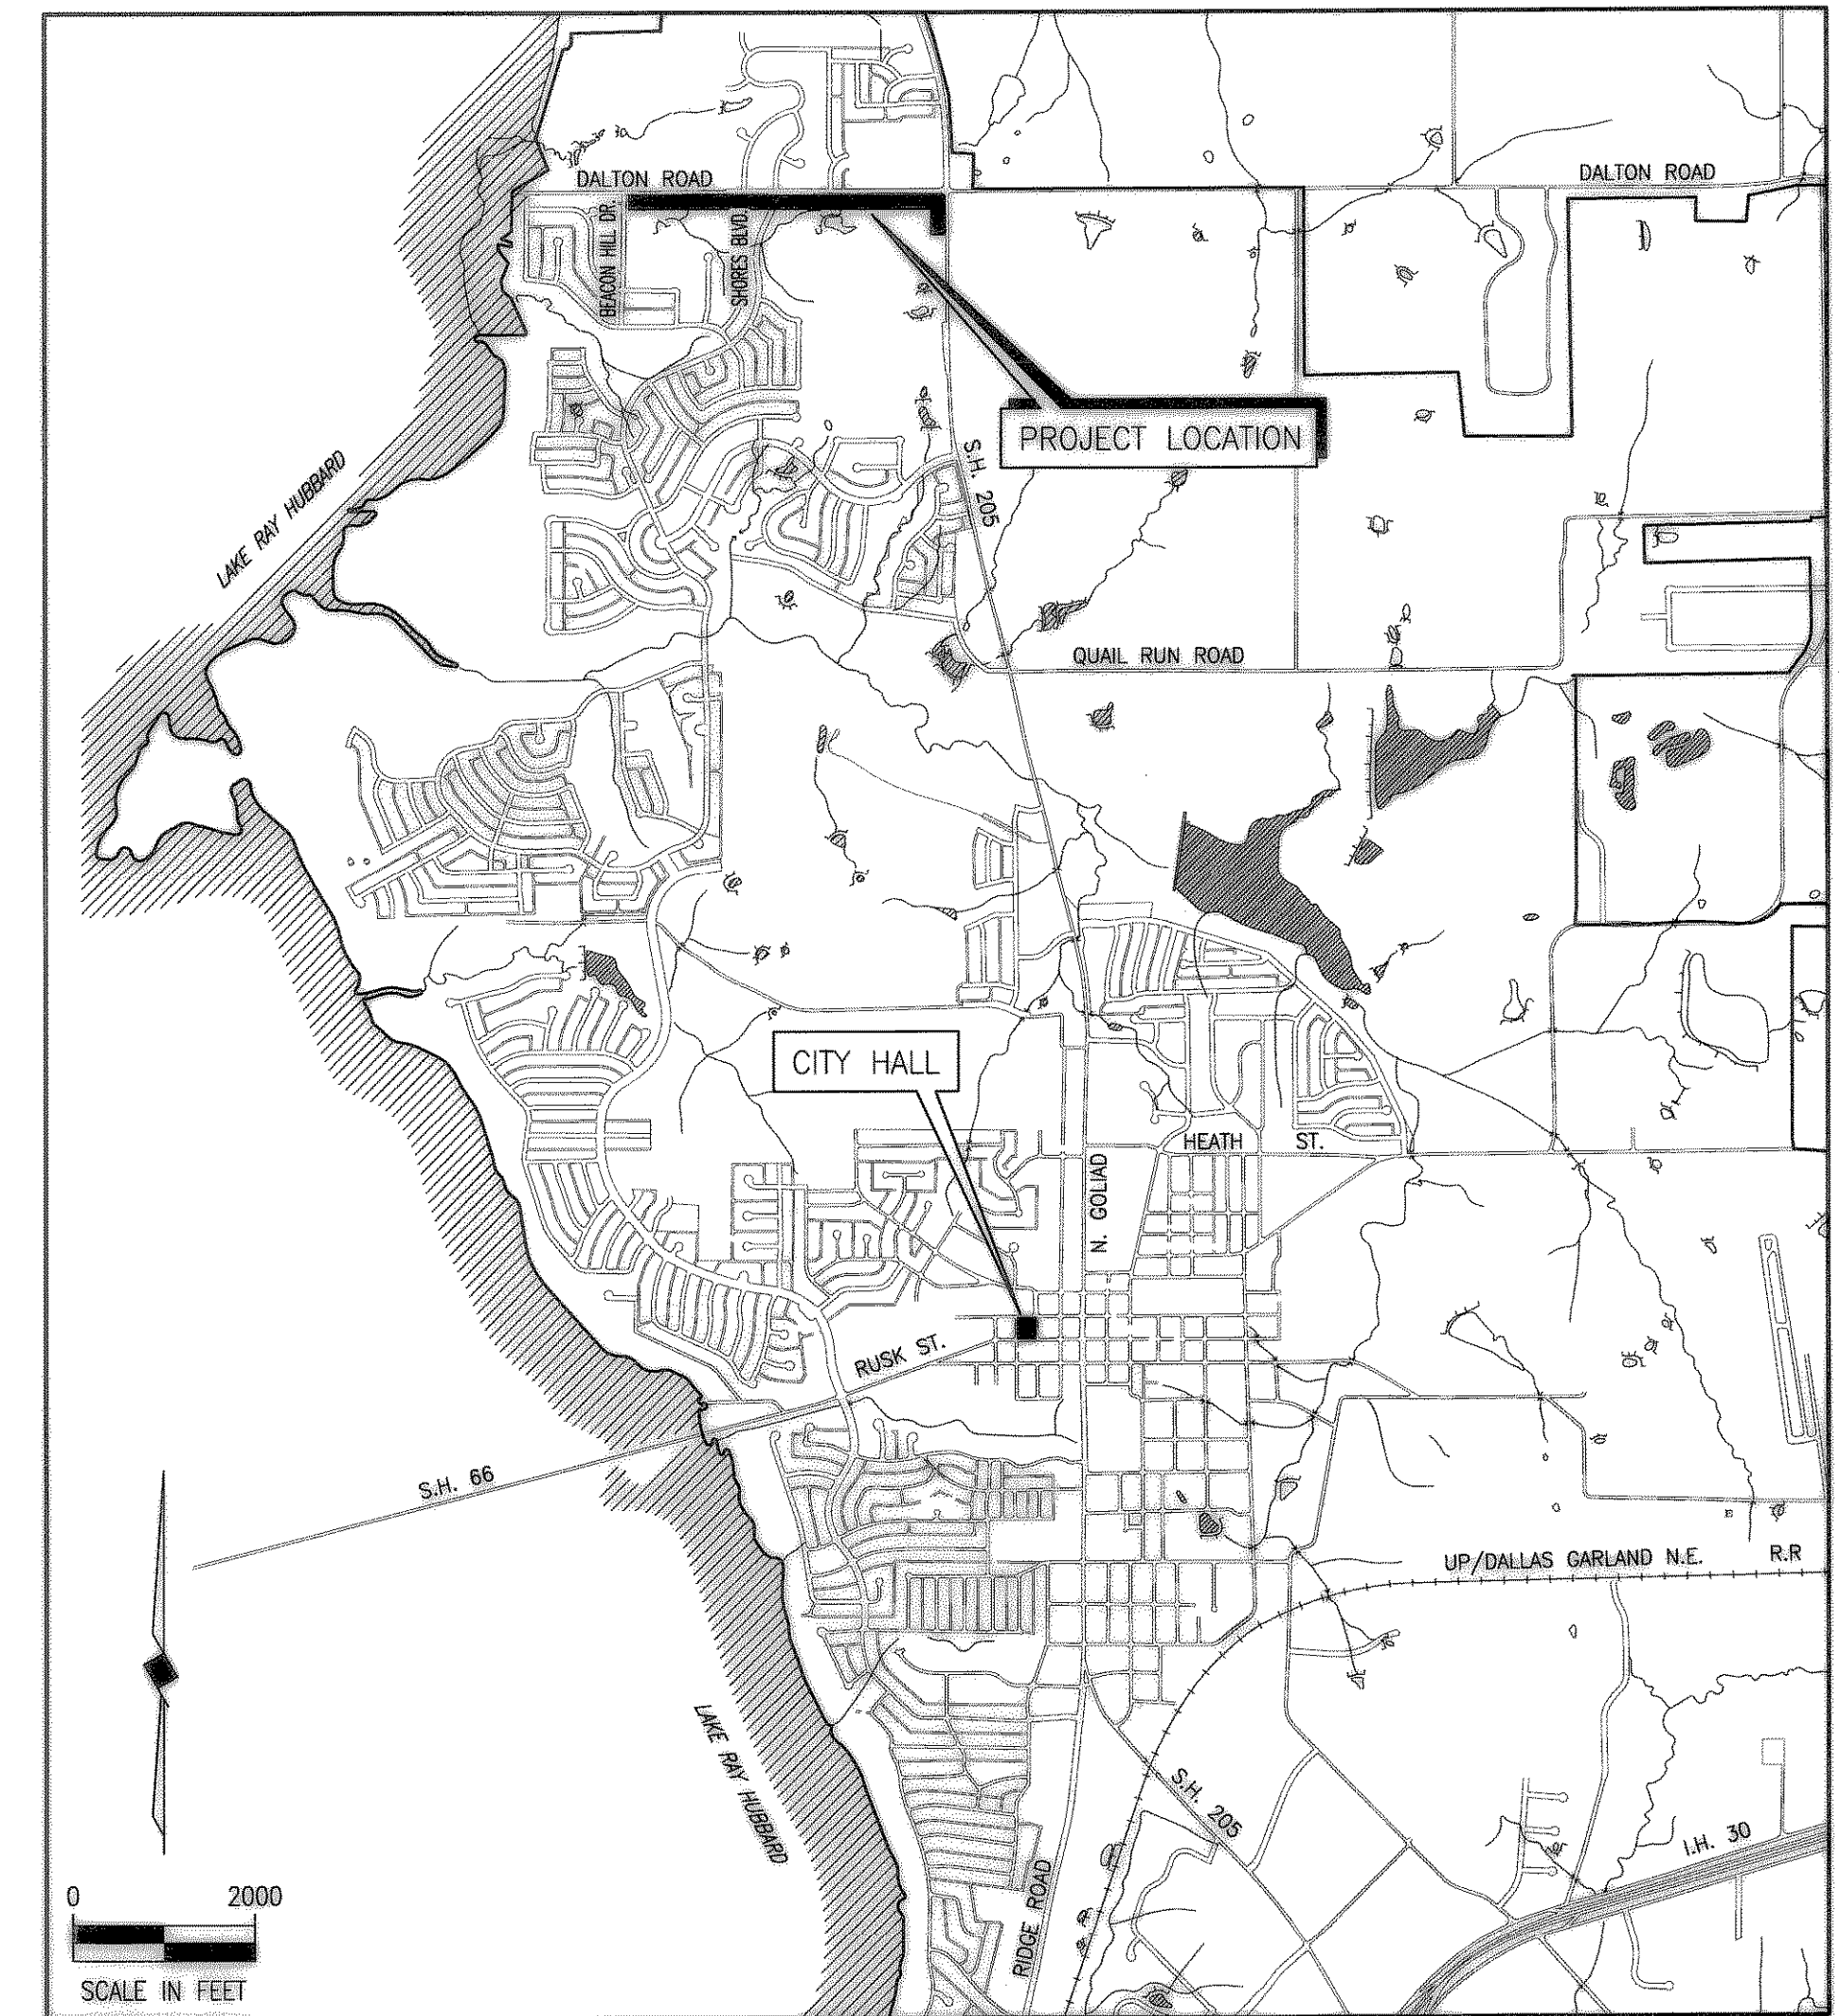

LOCATION MAP

SHEET INDEX

| <u>SHEET NO.</u> | <u>SHEET DESCRIPTION</u> |
|------------------|---|
| - | COVER SHEET AND LOCATION MAP |
| 1 | DALTON ROAD FORCE MAIN PLAN—PROFILE STA. 0+00 TO STA. 3+00 |
| 2 | DALTON ROAD FORCE MAIN PLAN—PROFILE STA. 3+00 TO STA. 8+00 |
| 3 | DALTON ROAD FORCE MAIN PLAN—PROFILE STA. 8+00 TO STA. 13+00 |
| 4 | DALTON ROAD FORCE MAIN PLAN—PROFILE STA. 13+00 TO STA. 18+00 |
| 5 | DALTON ROAD FORCE MAIN PLAN—PROFILE STA. 18+00 TO STA. 23+00 |
| 6 | DALTON ROAD FORCE MAIN PLAN—PROFILE STA. 23+00 TO STA. 28+00 |
| 7 | DALTON ROAD SANITARY SEWER PLAN—PROFILE STA. 28+00 TO STA. 33+00 |
| 8 | DALTON ROAD SANITARY SEWER PLAN—PROFILE STA. 33+00 TO STA. 34+46.62 |
| 9 | DALTON ROAD LIFT STATION SITE PLAN, SECTIONS & DETAILS |
| 10 | MISCELLANEOUS DETAILS |
| E1 | ELECTRICAL SITE PLAN |
| E2 | ONE LINE DIAGRAM & SCHEMATICS |
| E3 | ELECTRICAL SCHEMATICS & DIAGRAMS |
| E4 | ELECTRICAL DETAILS |
| S1 | STRUCTURAL PLANS & SECTIONS |

COUNCIL MEMBERS

KEN JONES, MAYOR
 BILL CECIL, MAYOR PRO-TEM
 BOB COTTI
 JOHN KING
 TERRY RAULSTON
 BILLY MORRIS
 RON COLESON

CITY MANAGER


JULIE COUCH

ASSISTANT CITY MANAGER

RICHARD R. CROWLEY

CITY ENGINEER

CHUCK TODD, P.E.

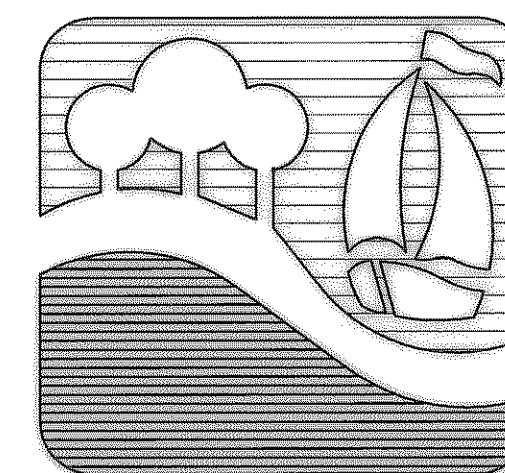

BIRKHOFF, HENDRICKS & CONWAY, L.L.P.
 CONSULTING ENGINEERS
 Dallas, Texas

REVISED TO CONFORM
 TO CONSTRUCTION RECORDS
 BY P.A.C. DATE 1/17/03

THESE DOCUMENTS ARE FOR
 BIDDING, CONSTRUCTION,
 AND PERMIT PURPOSES.

DATE: 12.11.01

DECEMBER, 2001

