



NOTES:
 1. POWER POLE DOES NOT EXIST. LOCATION SHOWN IS APPROXIMATE FOR FUTURE POLE BY TXU ELECTRIC CO.

ELECTRICAL SITE PLAN
 SCALE: 1"=20'-0"

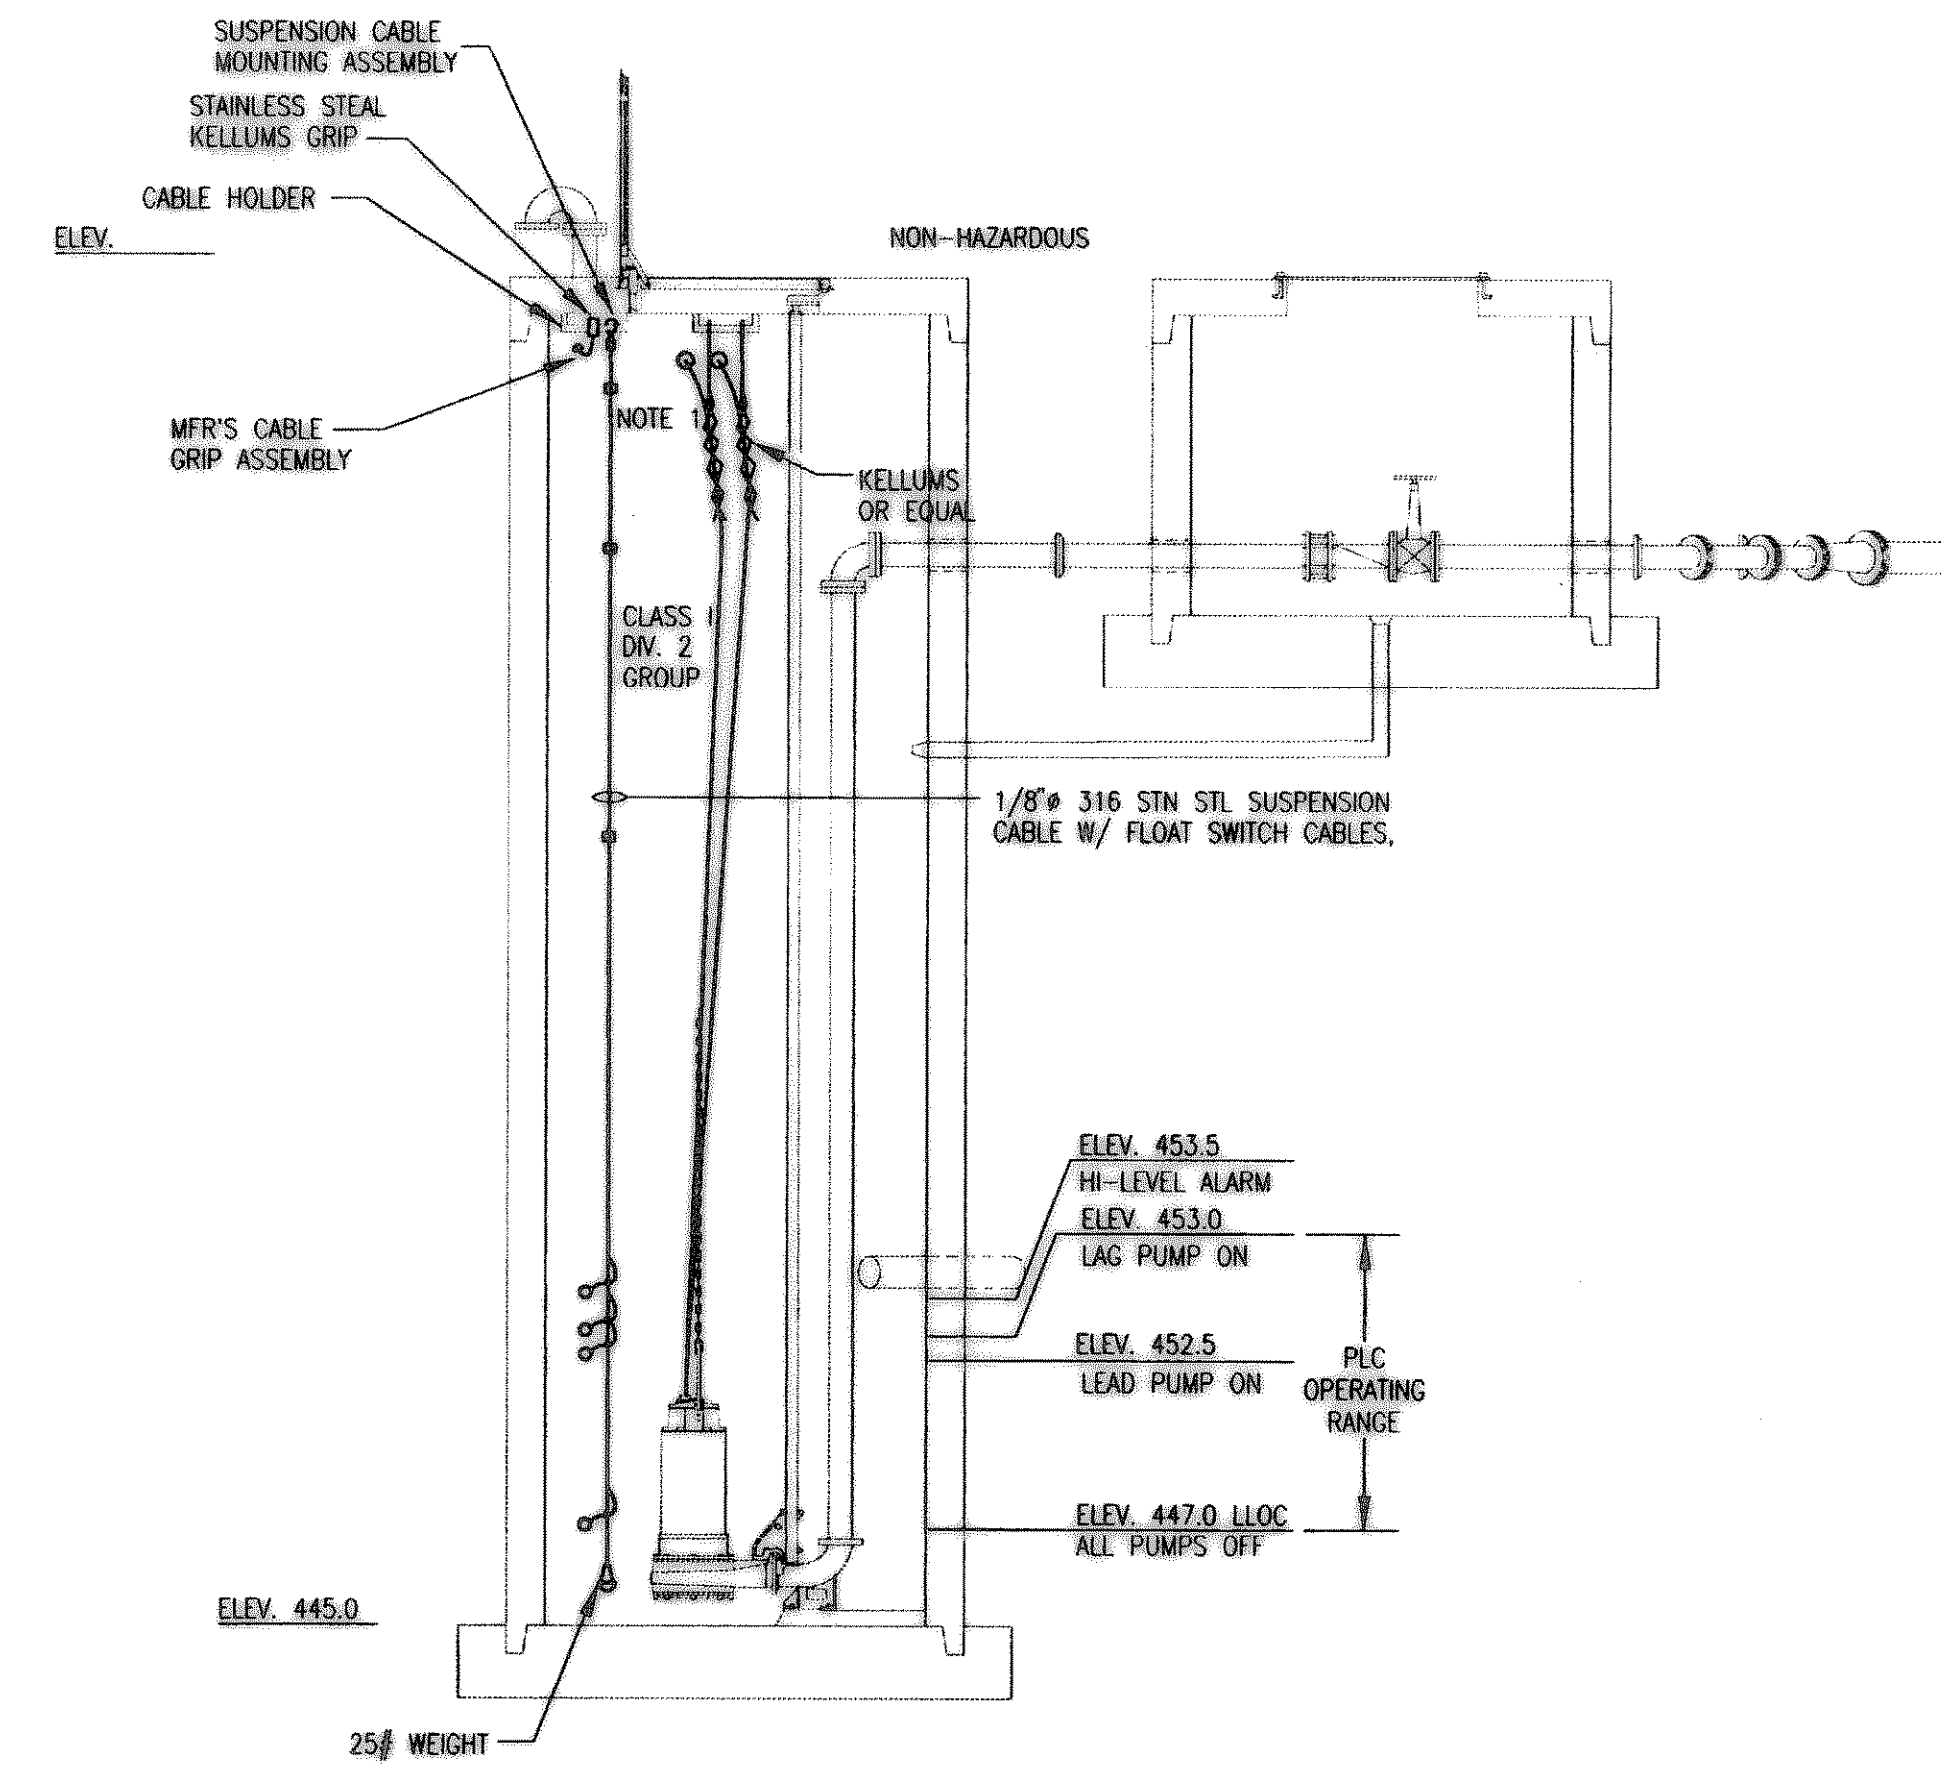


NOTES:
 1. SUPPORT CABLES FROM HANGER BAR WITH KELLUMS STANDARD DUTY UNIVERSAL EYE CABLE SUPPORT GRIPS.

01 LEVEL SWITCHES - DALTON ROAD
 NOT TO SCALE

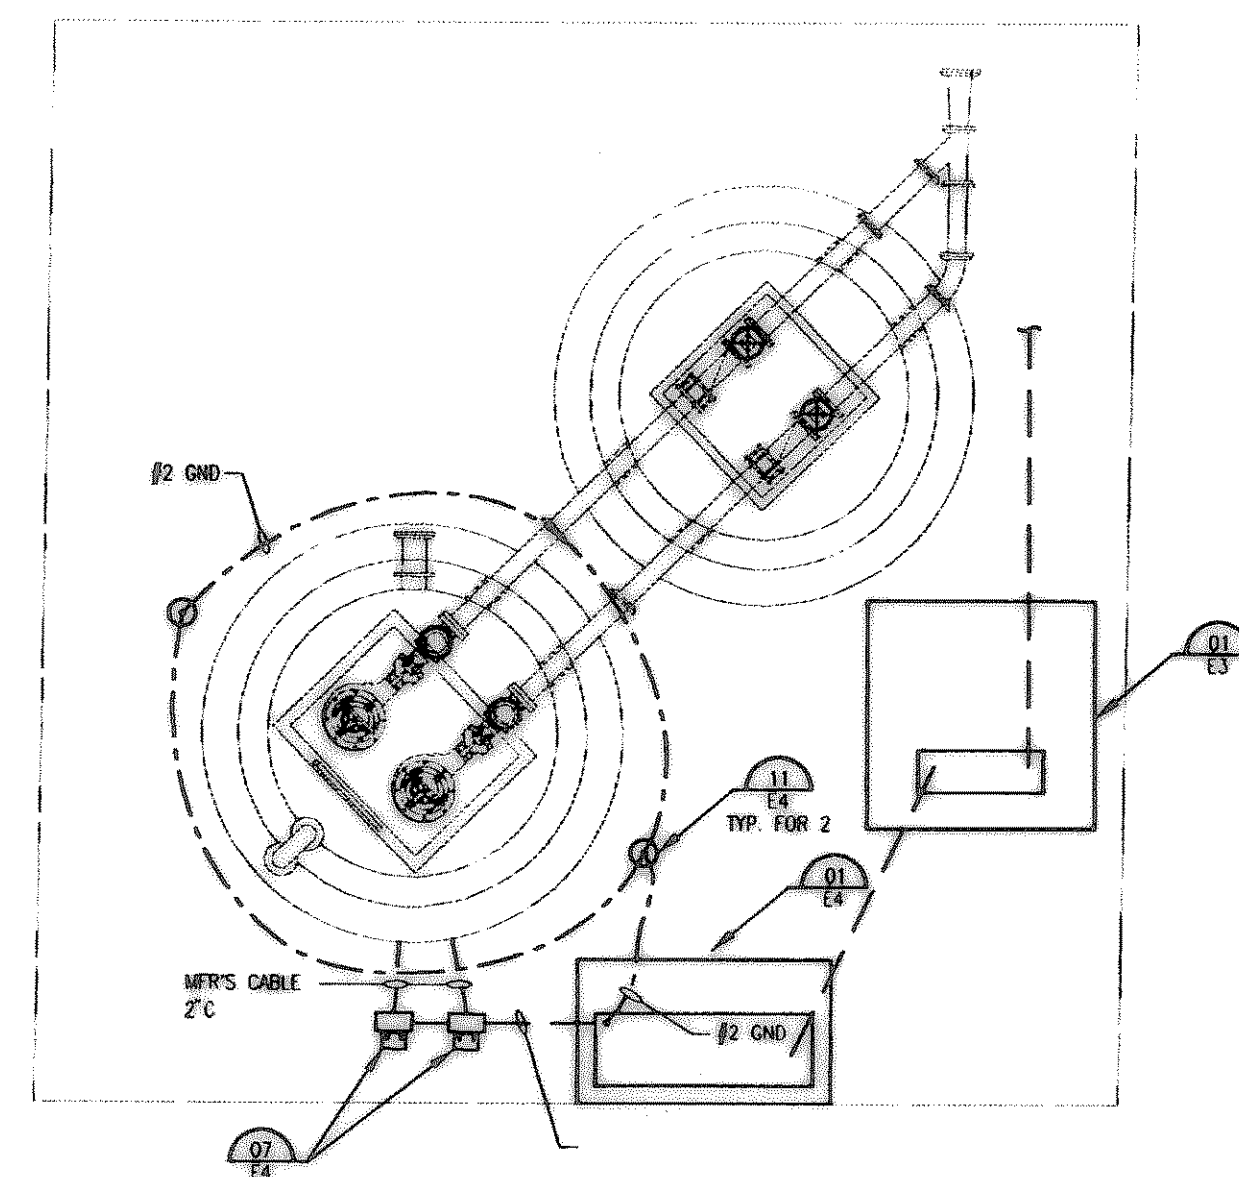

02 DALTON ROAD LIFT STATION PLAN
 NOT TO SCALE

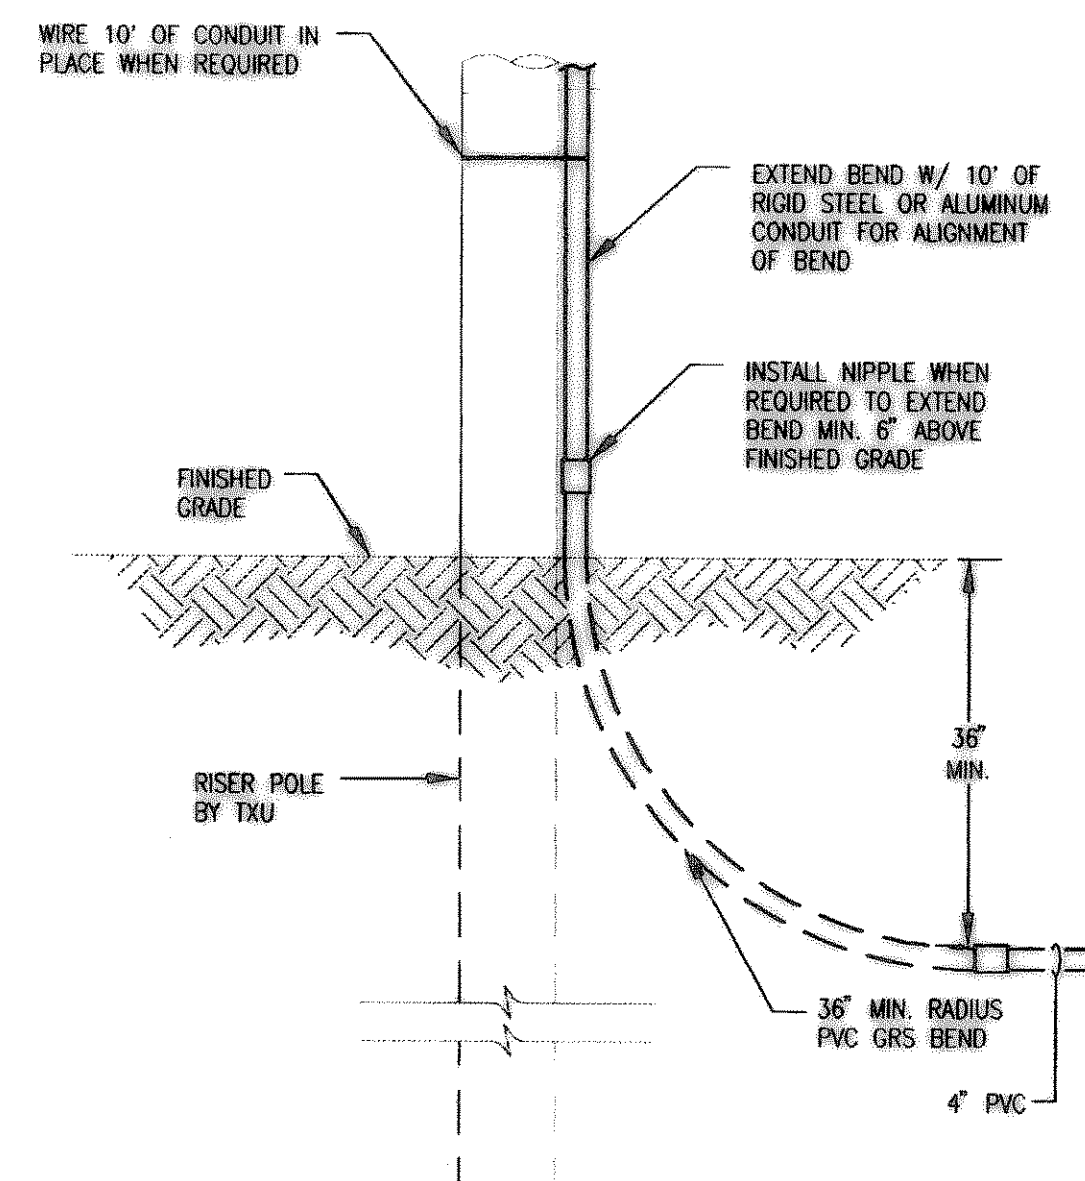

03 PRIMARY ELECTRICAL SERVICE POLE
 NOT TO SCALE

REVISED TO CONFORM TO CONSTRUCTION RECORDS
 BY [Signature] DATE 1/11/03

These plans and related specifications were prepared for construction of this specific project only. Reuse of these documents is not permitted without written authorization of Birkhoff, Hendricks, & Conway, L.L.P.

CITY OF ROCKWALL, TEXAS


**DALTON ROAD LIFT STATION
 ELECTRICAL SITE PLAN**

BIRKHOFF, HENDRICKS & CONWAY, L.L.P.
 CONSULTING ENGINEERS
 Dallas, Texas

DESIGNED BY: J.A.V.F. PROJECT: 2000-170 SHEET NO. E1
 DRAWN BY: R.E.B. DATE: DECEMBER 2001 OF 4 SHEETS

VERIFY SCALE

Bar is one inch on original drawing.
 0 1
 If not one inch on this sheet, adjust scale accordingly.

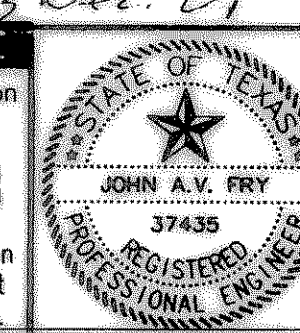

John A.V. Fry
 13 Dec. 01