



1 COURTHOUSE STAGE AREA PLAN - POWER - PHASE 2
SCALE: 1/8" = 1'-0"

**ELECTRICAL PLAN
GENERAL NOTES**

1. REFER DRAWING EL2.03 FOR ELECTRICAL SYMBOL LEGEND.
2. REFER DRAWING EL2.02 & EL2.03 FOR PANEL SCHEDULES.

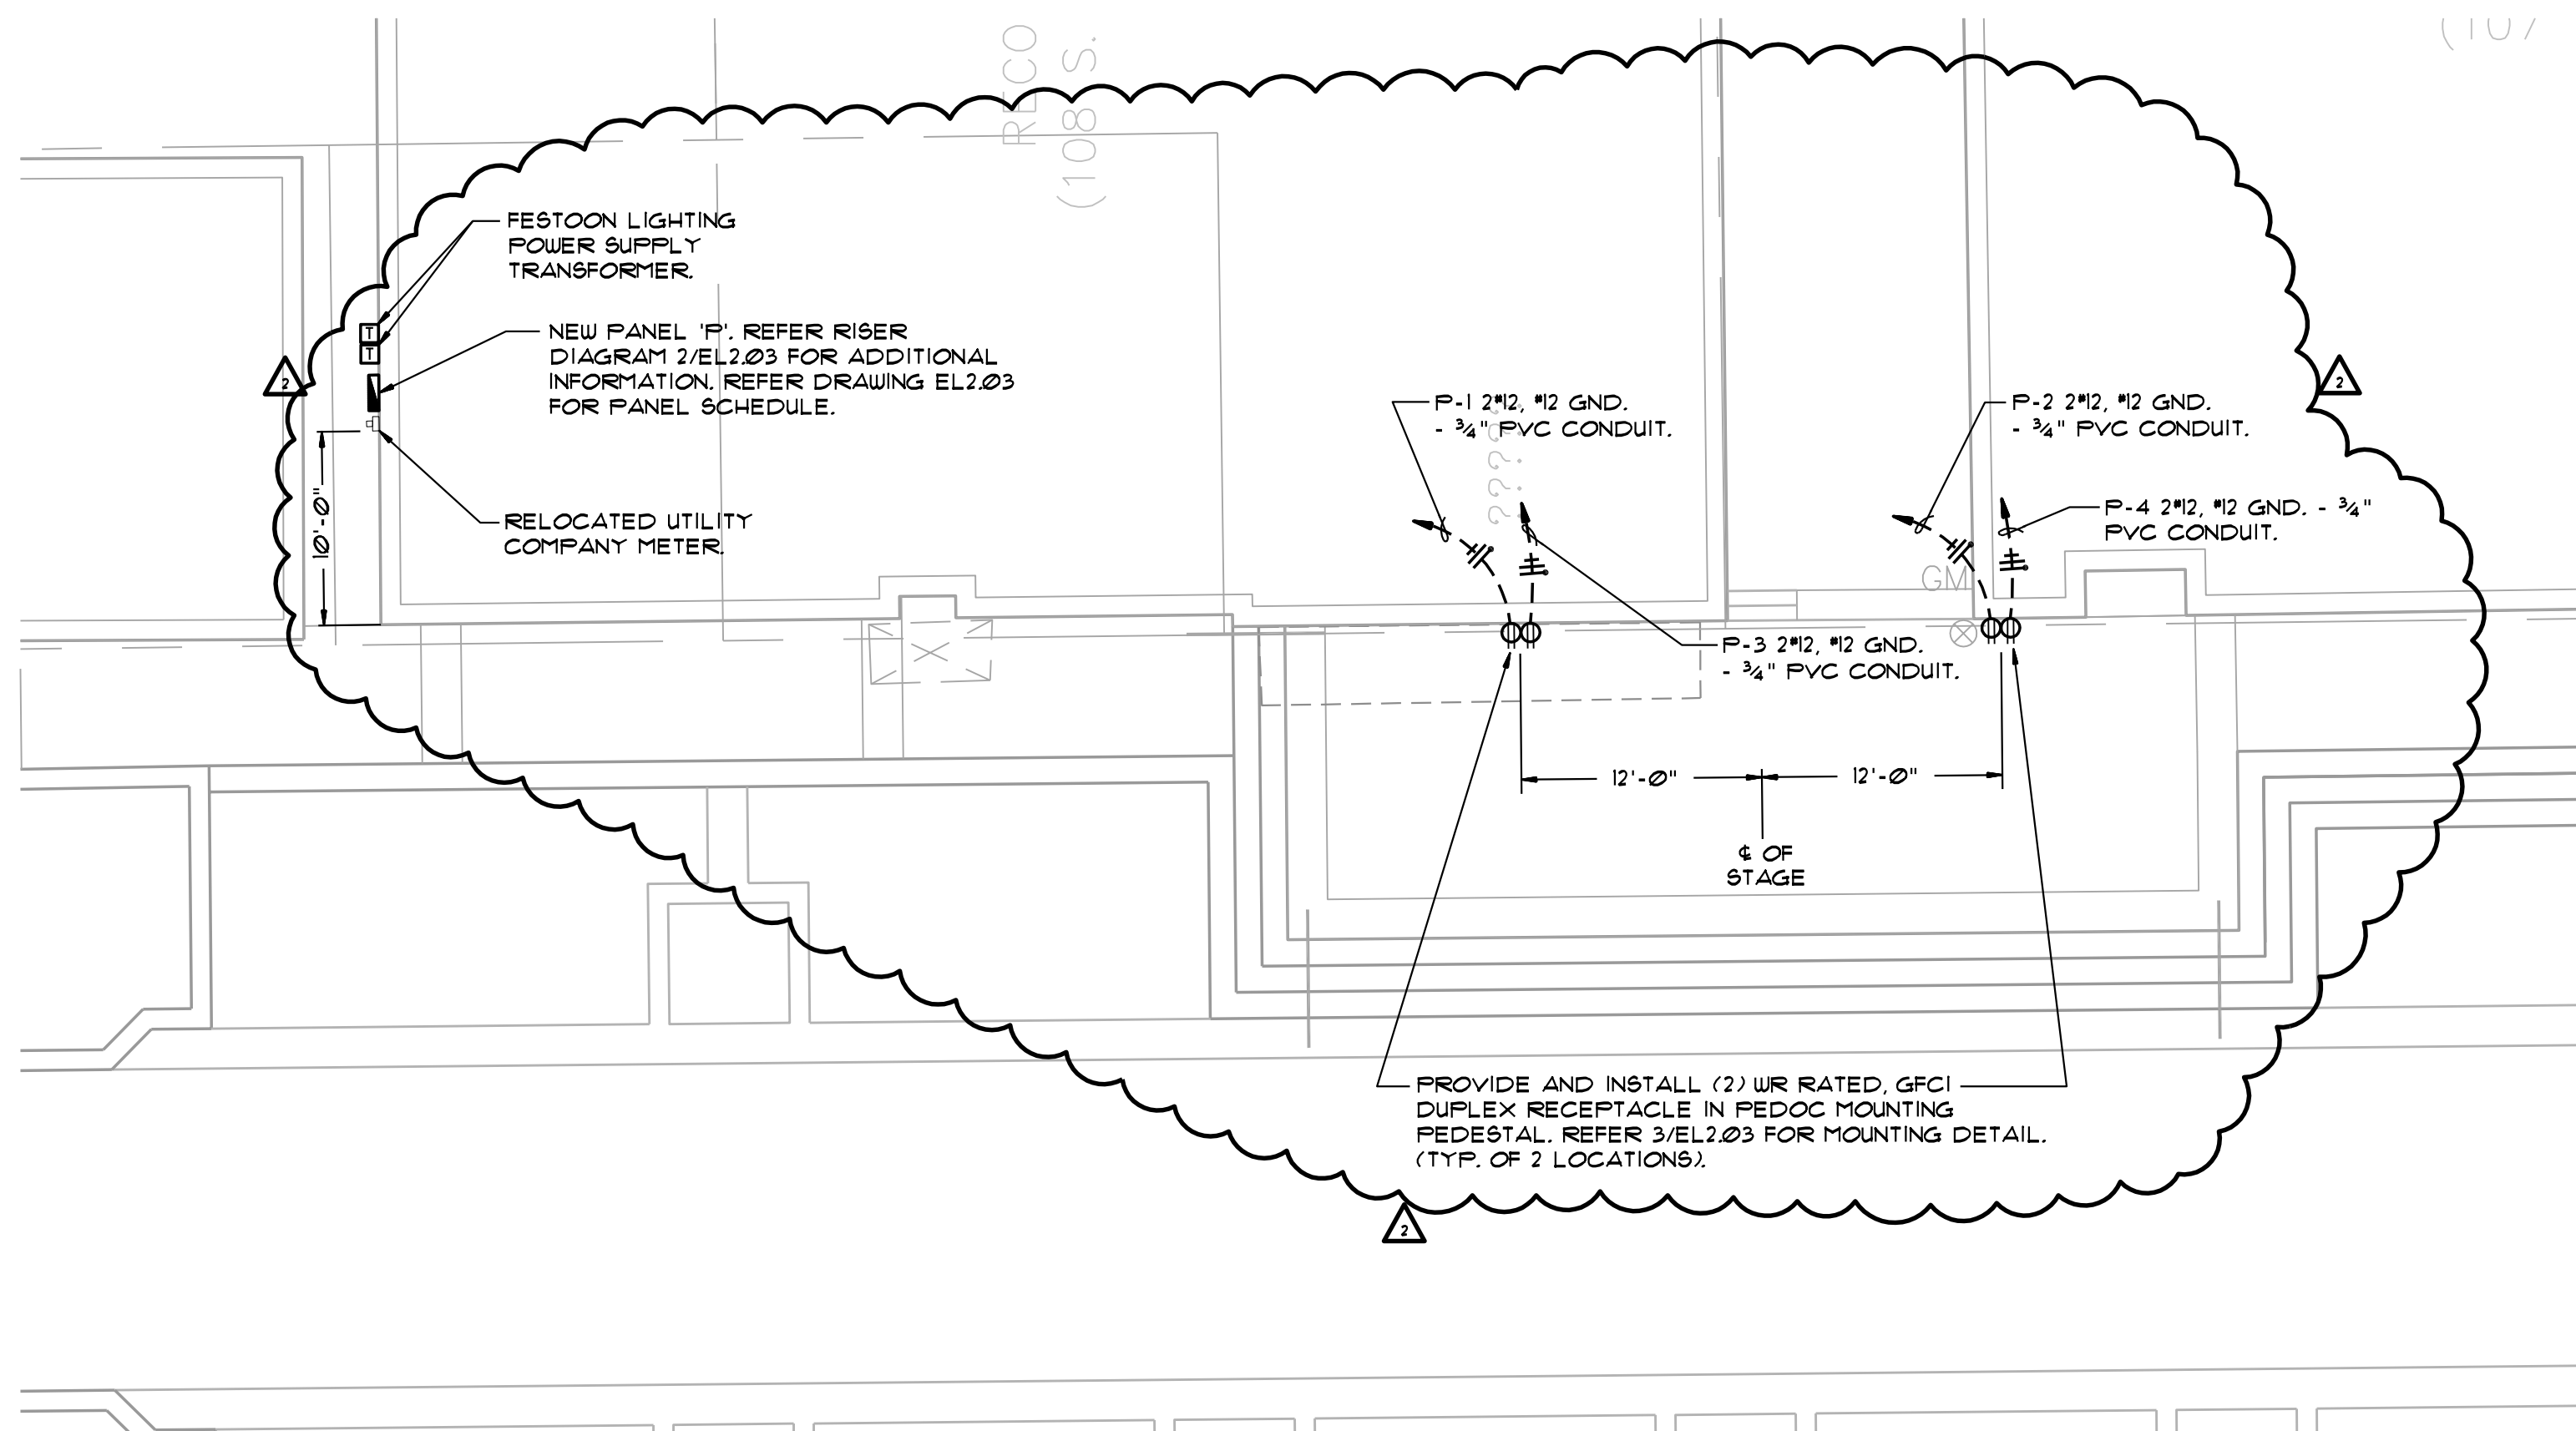

2 SAN JACINTO ST. PEDESTRIAN MALL PLAN - POWER - PHASE 2
SCALE: 1/8" = 1'-0"

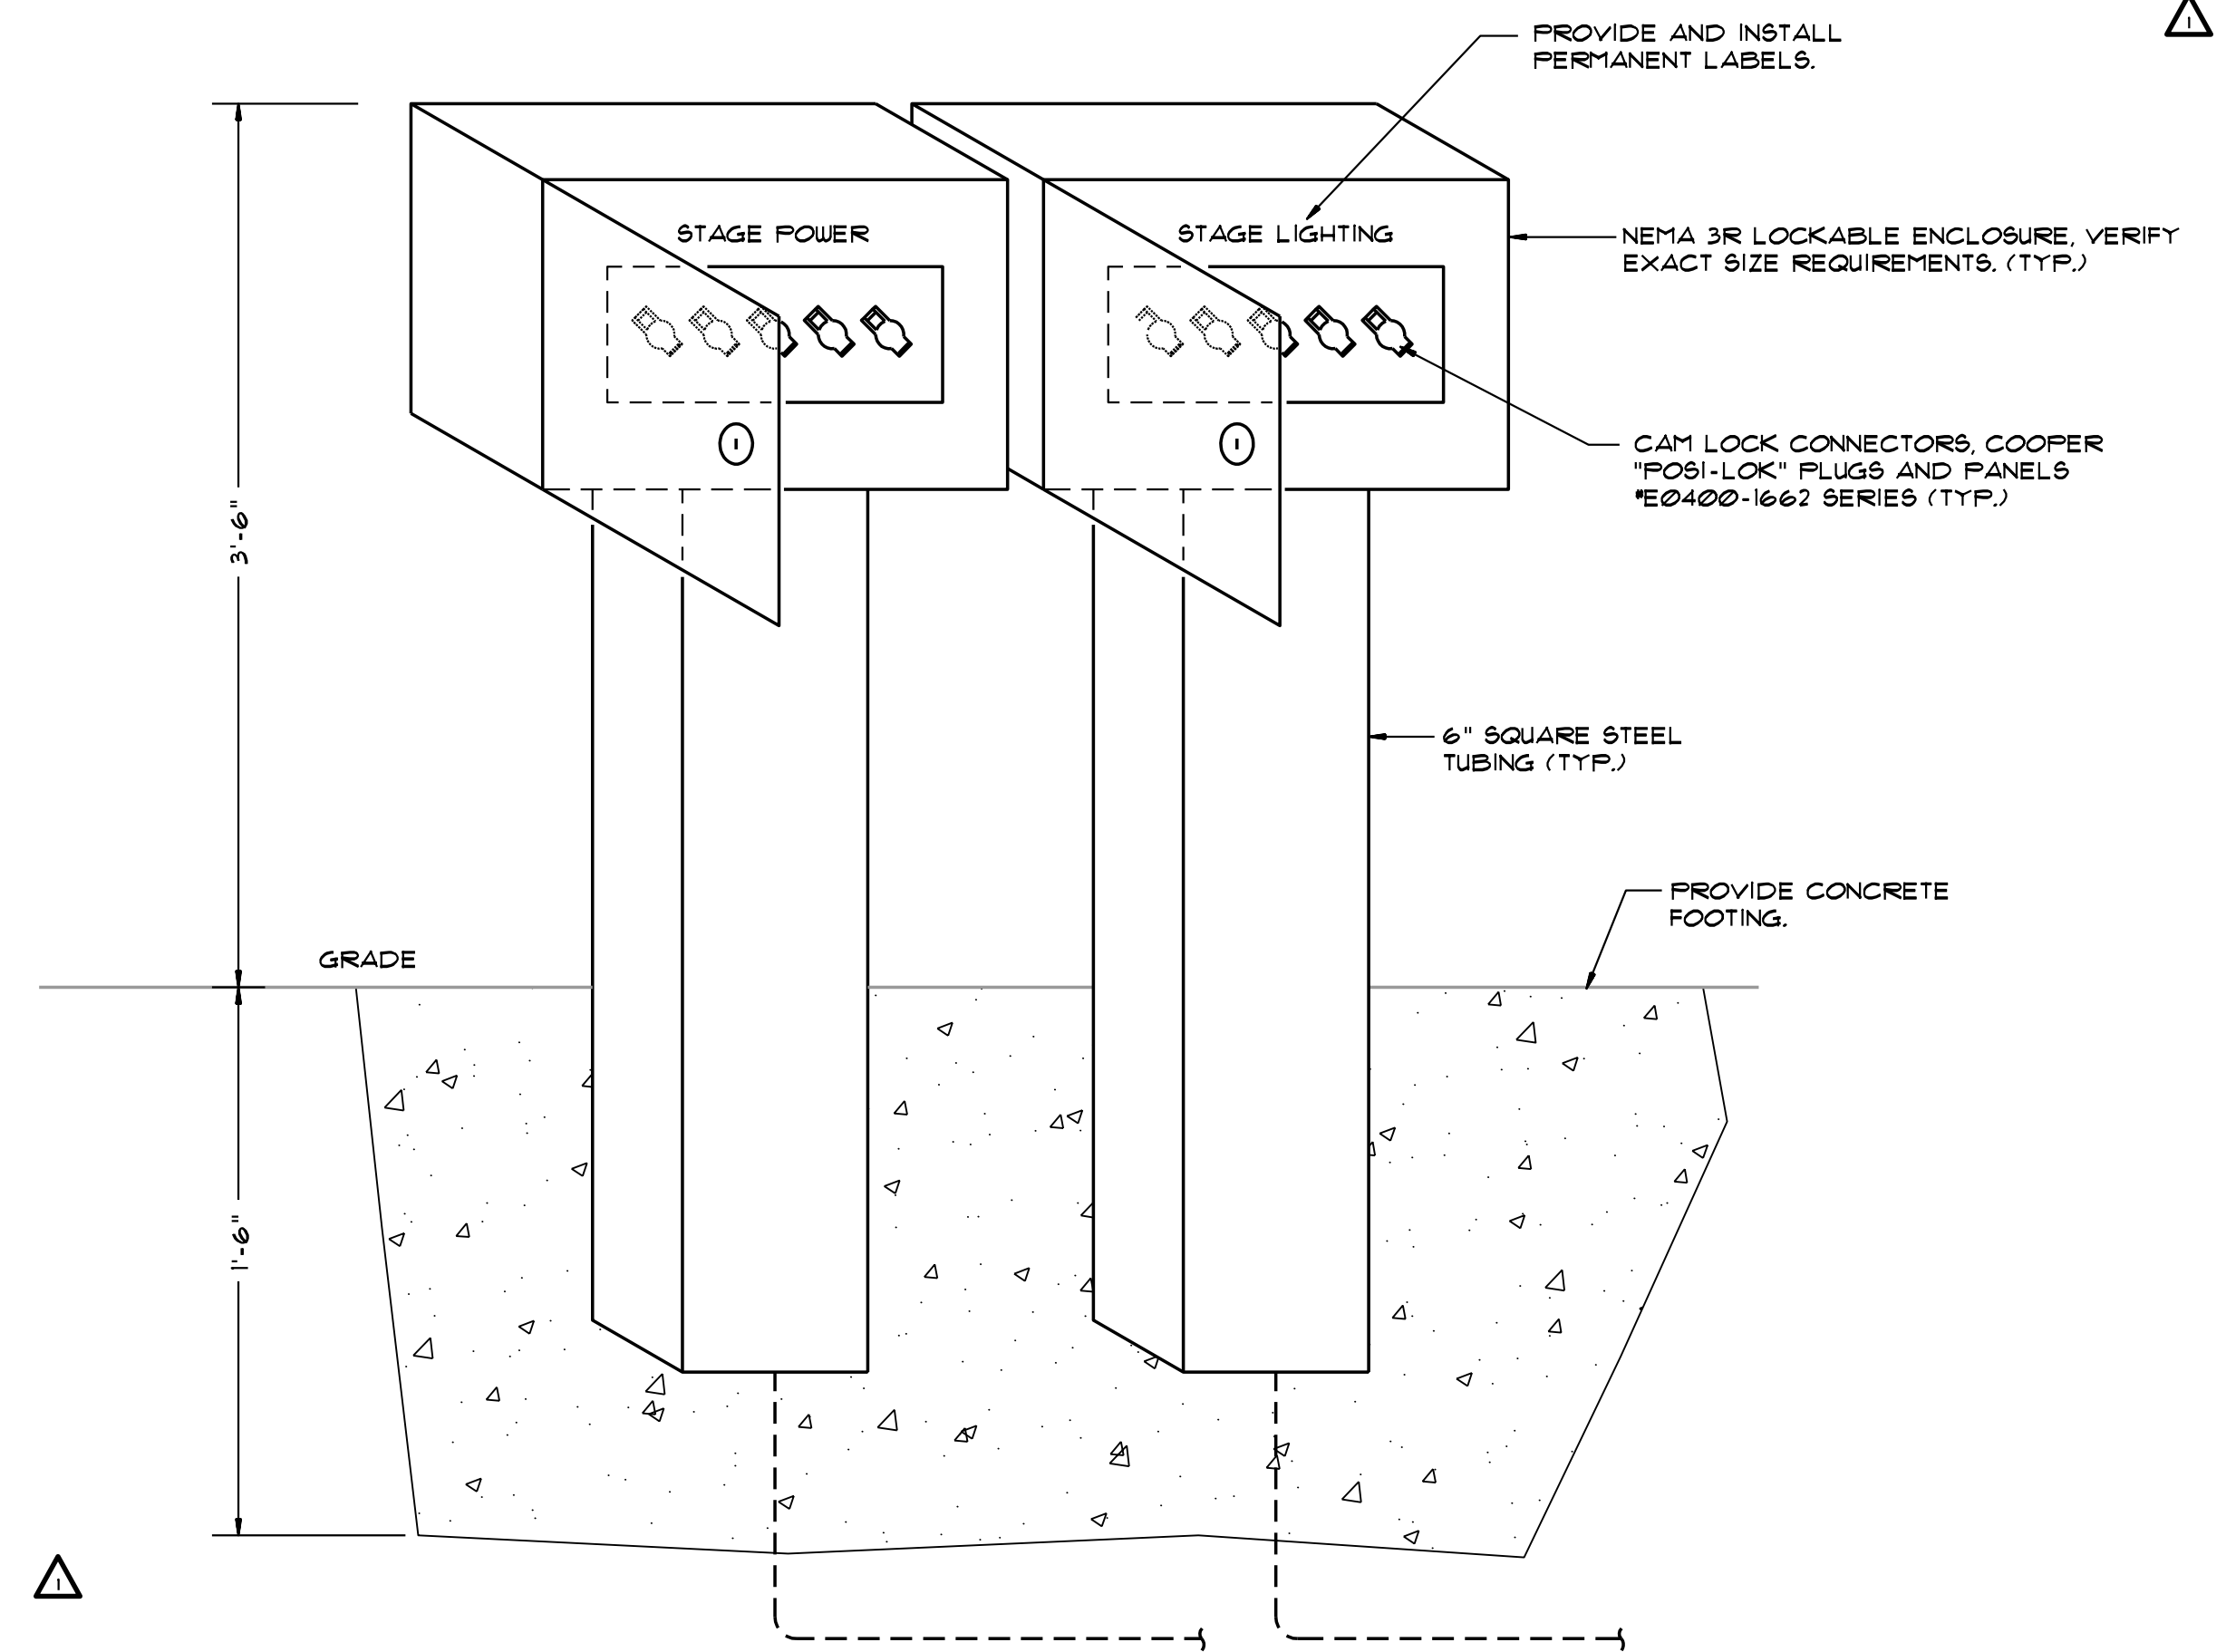

3 CAM LOCK ENCLOSURE DETAIL
SCALE: NONE

EA ENGINEERING ASSOCIATES
TX REG #F-4925
Ph: 940.427.8487 Fax: 940.427.8499
P.O. Box 167 Alford, TX 76225

la terra studio
Pacheco Koch
DALLAS • FORT WORTH • HOUSTON
EA ENGINEERING ASSOCIATES


Downtown Rockwall
Project # 2024 - renovation -
streetscape improvements
rockwall, texas

ROCKWALL
A City of Texas, Rockwall, TX

submittals / revisions

no.	date	detail
△	4/2/2014	Electrical Revisions
△	5/8/2014	Electrical Revisions

la terra studio, inc.
12024
its project number
02.26.2014
date
C.A.D.
drawn by
J.W.
checked by

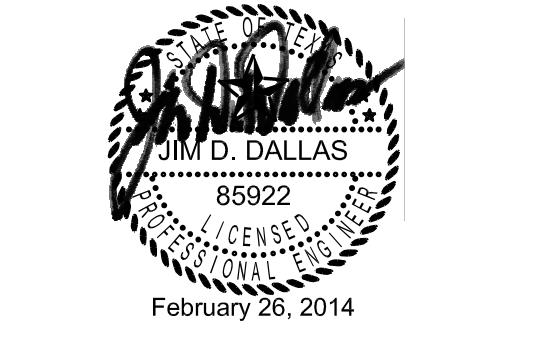

sheet title
Large Scale Elec. Plans - Phase 2
sheet number
EL2.01