



**1 COURTHOUSE STAGE AREA PLAN - POWER - PHASE 2**  
SCALE: 1/8" = 1'-0"

**ELECTRICAL PLAN  
GENERAL NOTES**

1. REFER DRAWING EL2.03 FOR ELECTRICAL SYMBOL LEGEND.
2. REFER DRAWING EL2.02 & EL2.03 FOR PANEL SCHEDULES.

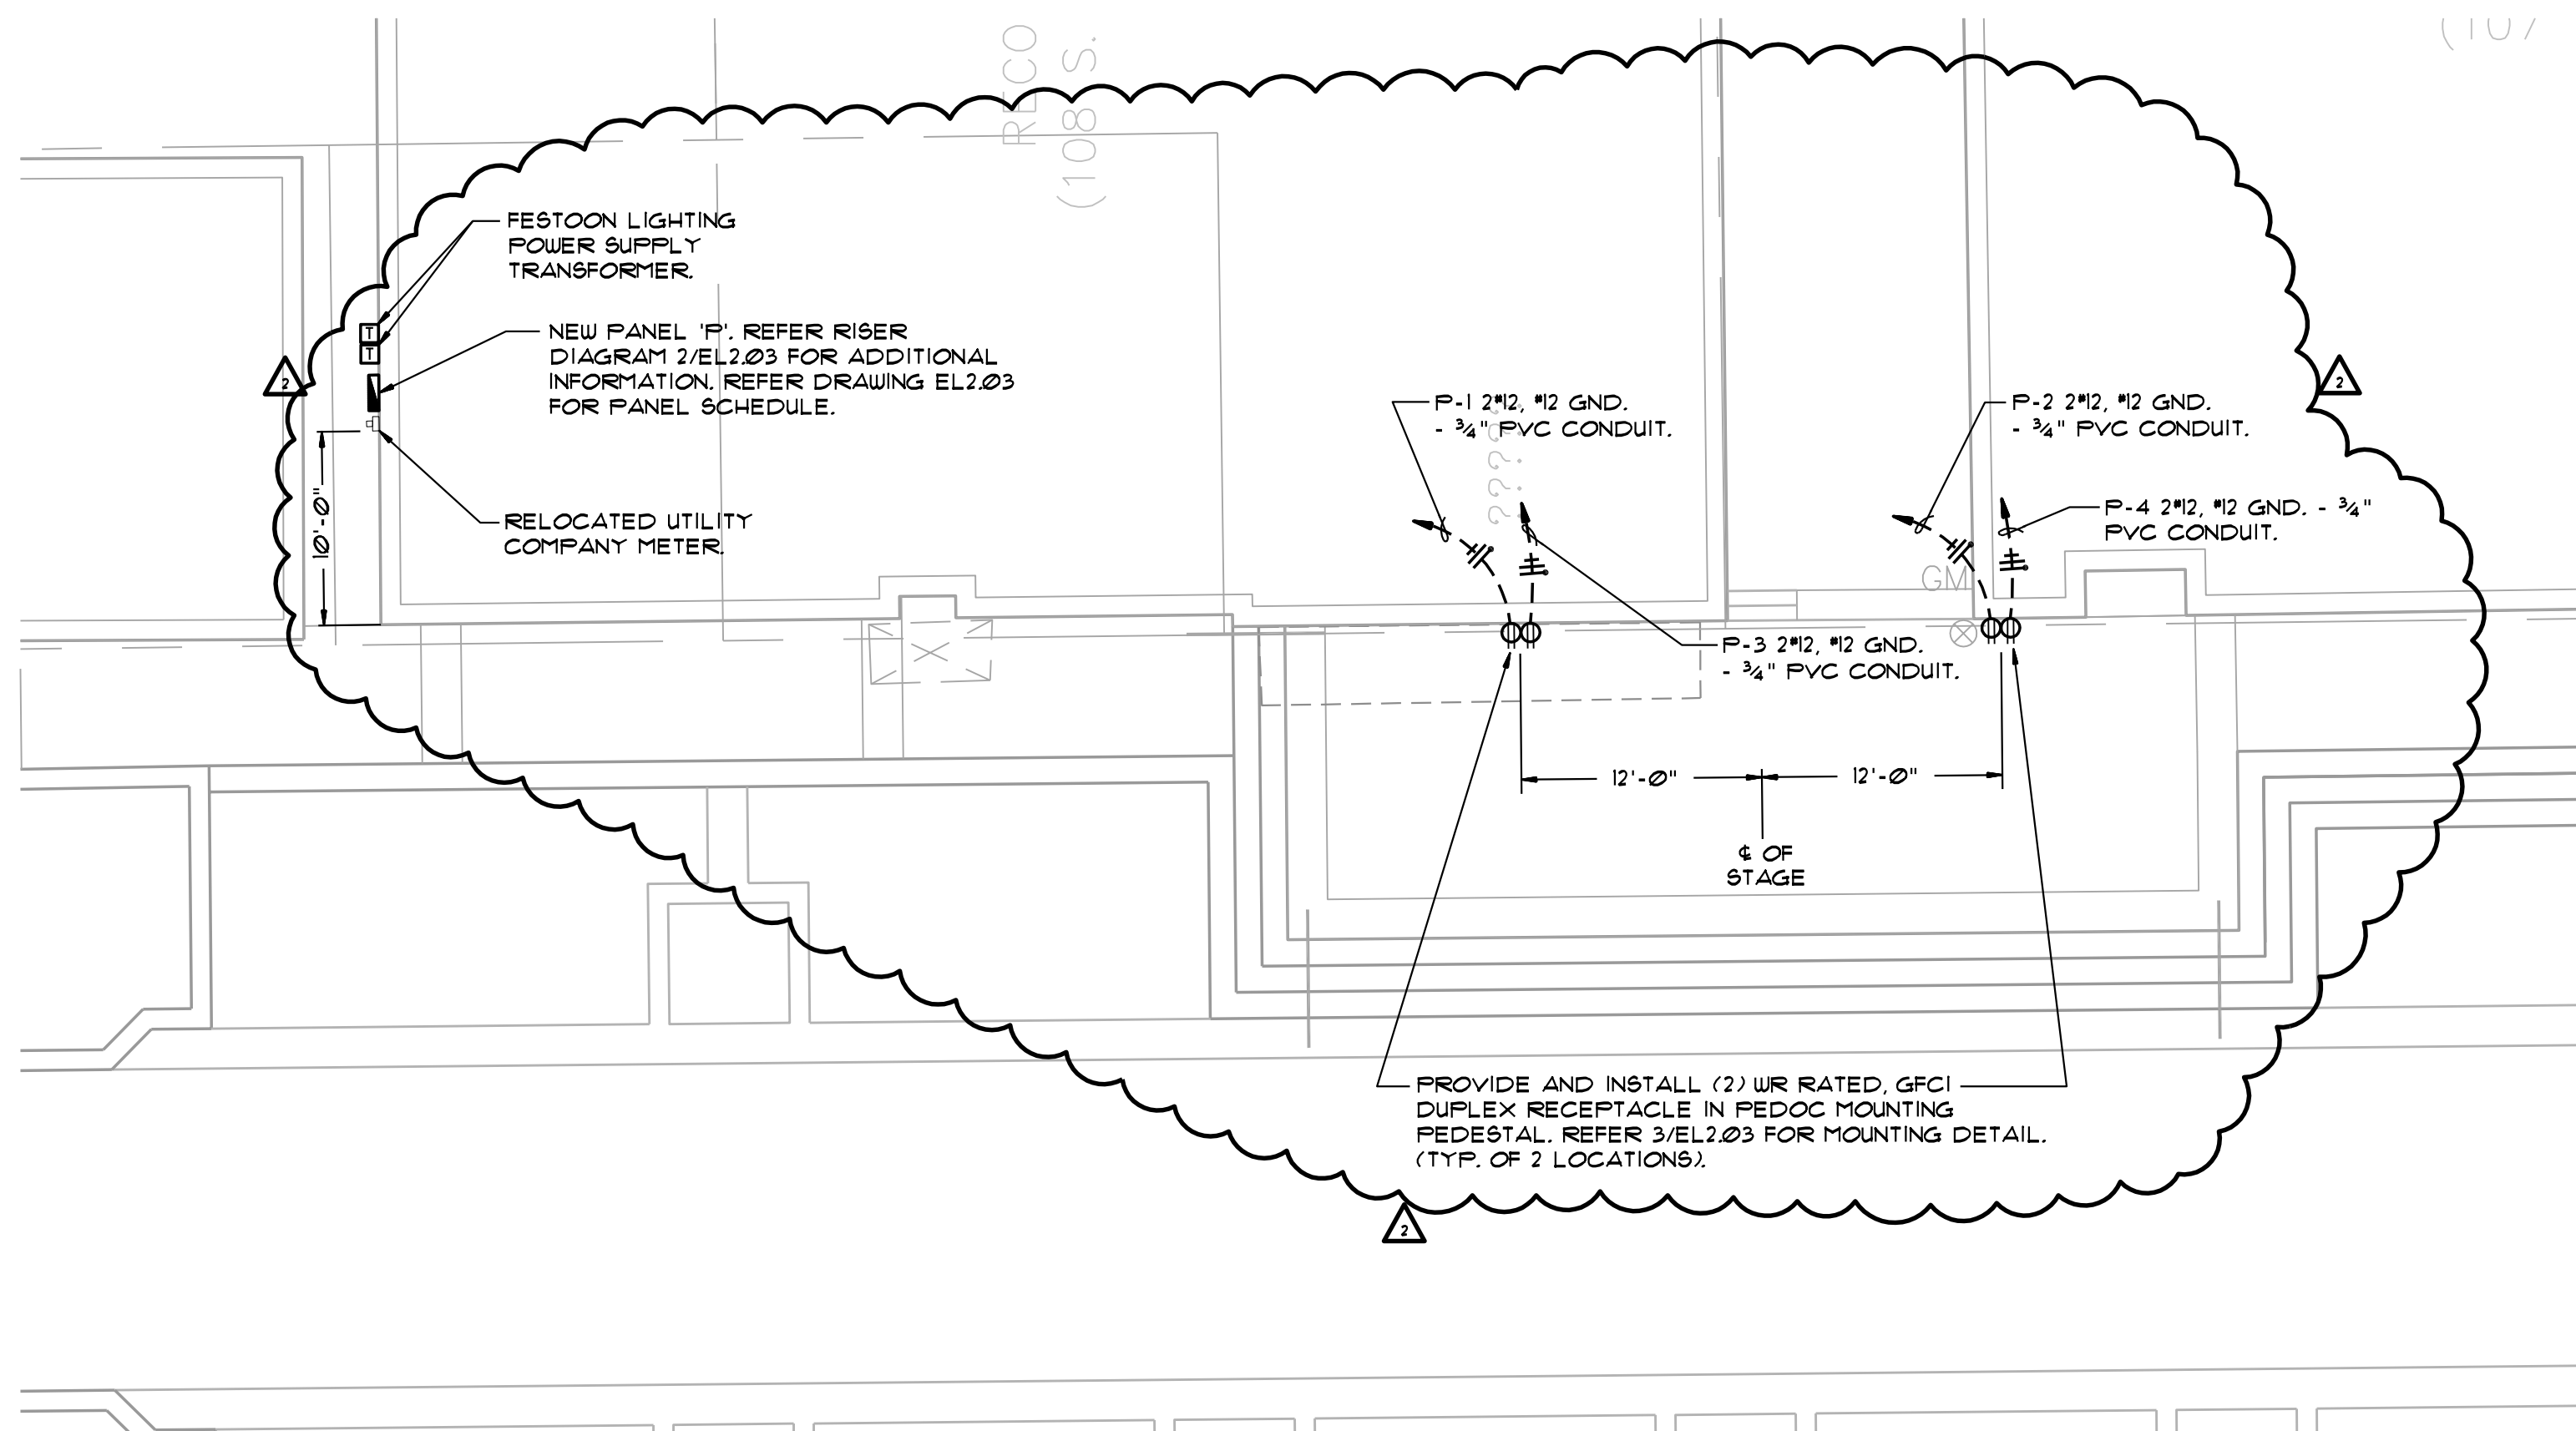

**2 SAN JACINTO ST. PEDESTRIAN MALL PLAN - POWER - PHASE 2**  
SCALE: 1/8" = 1'-0"

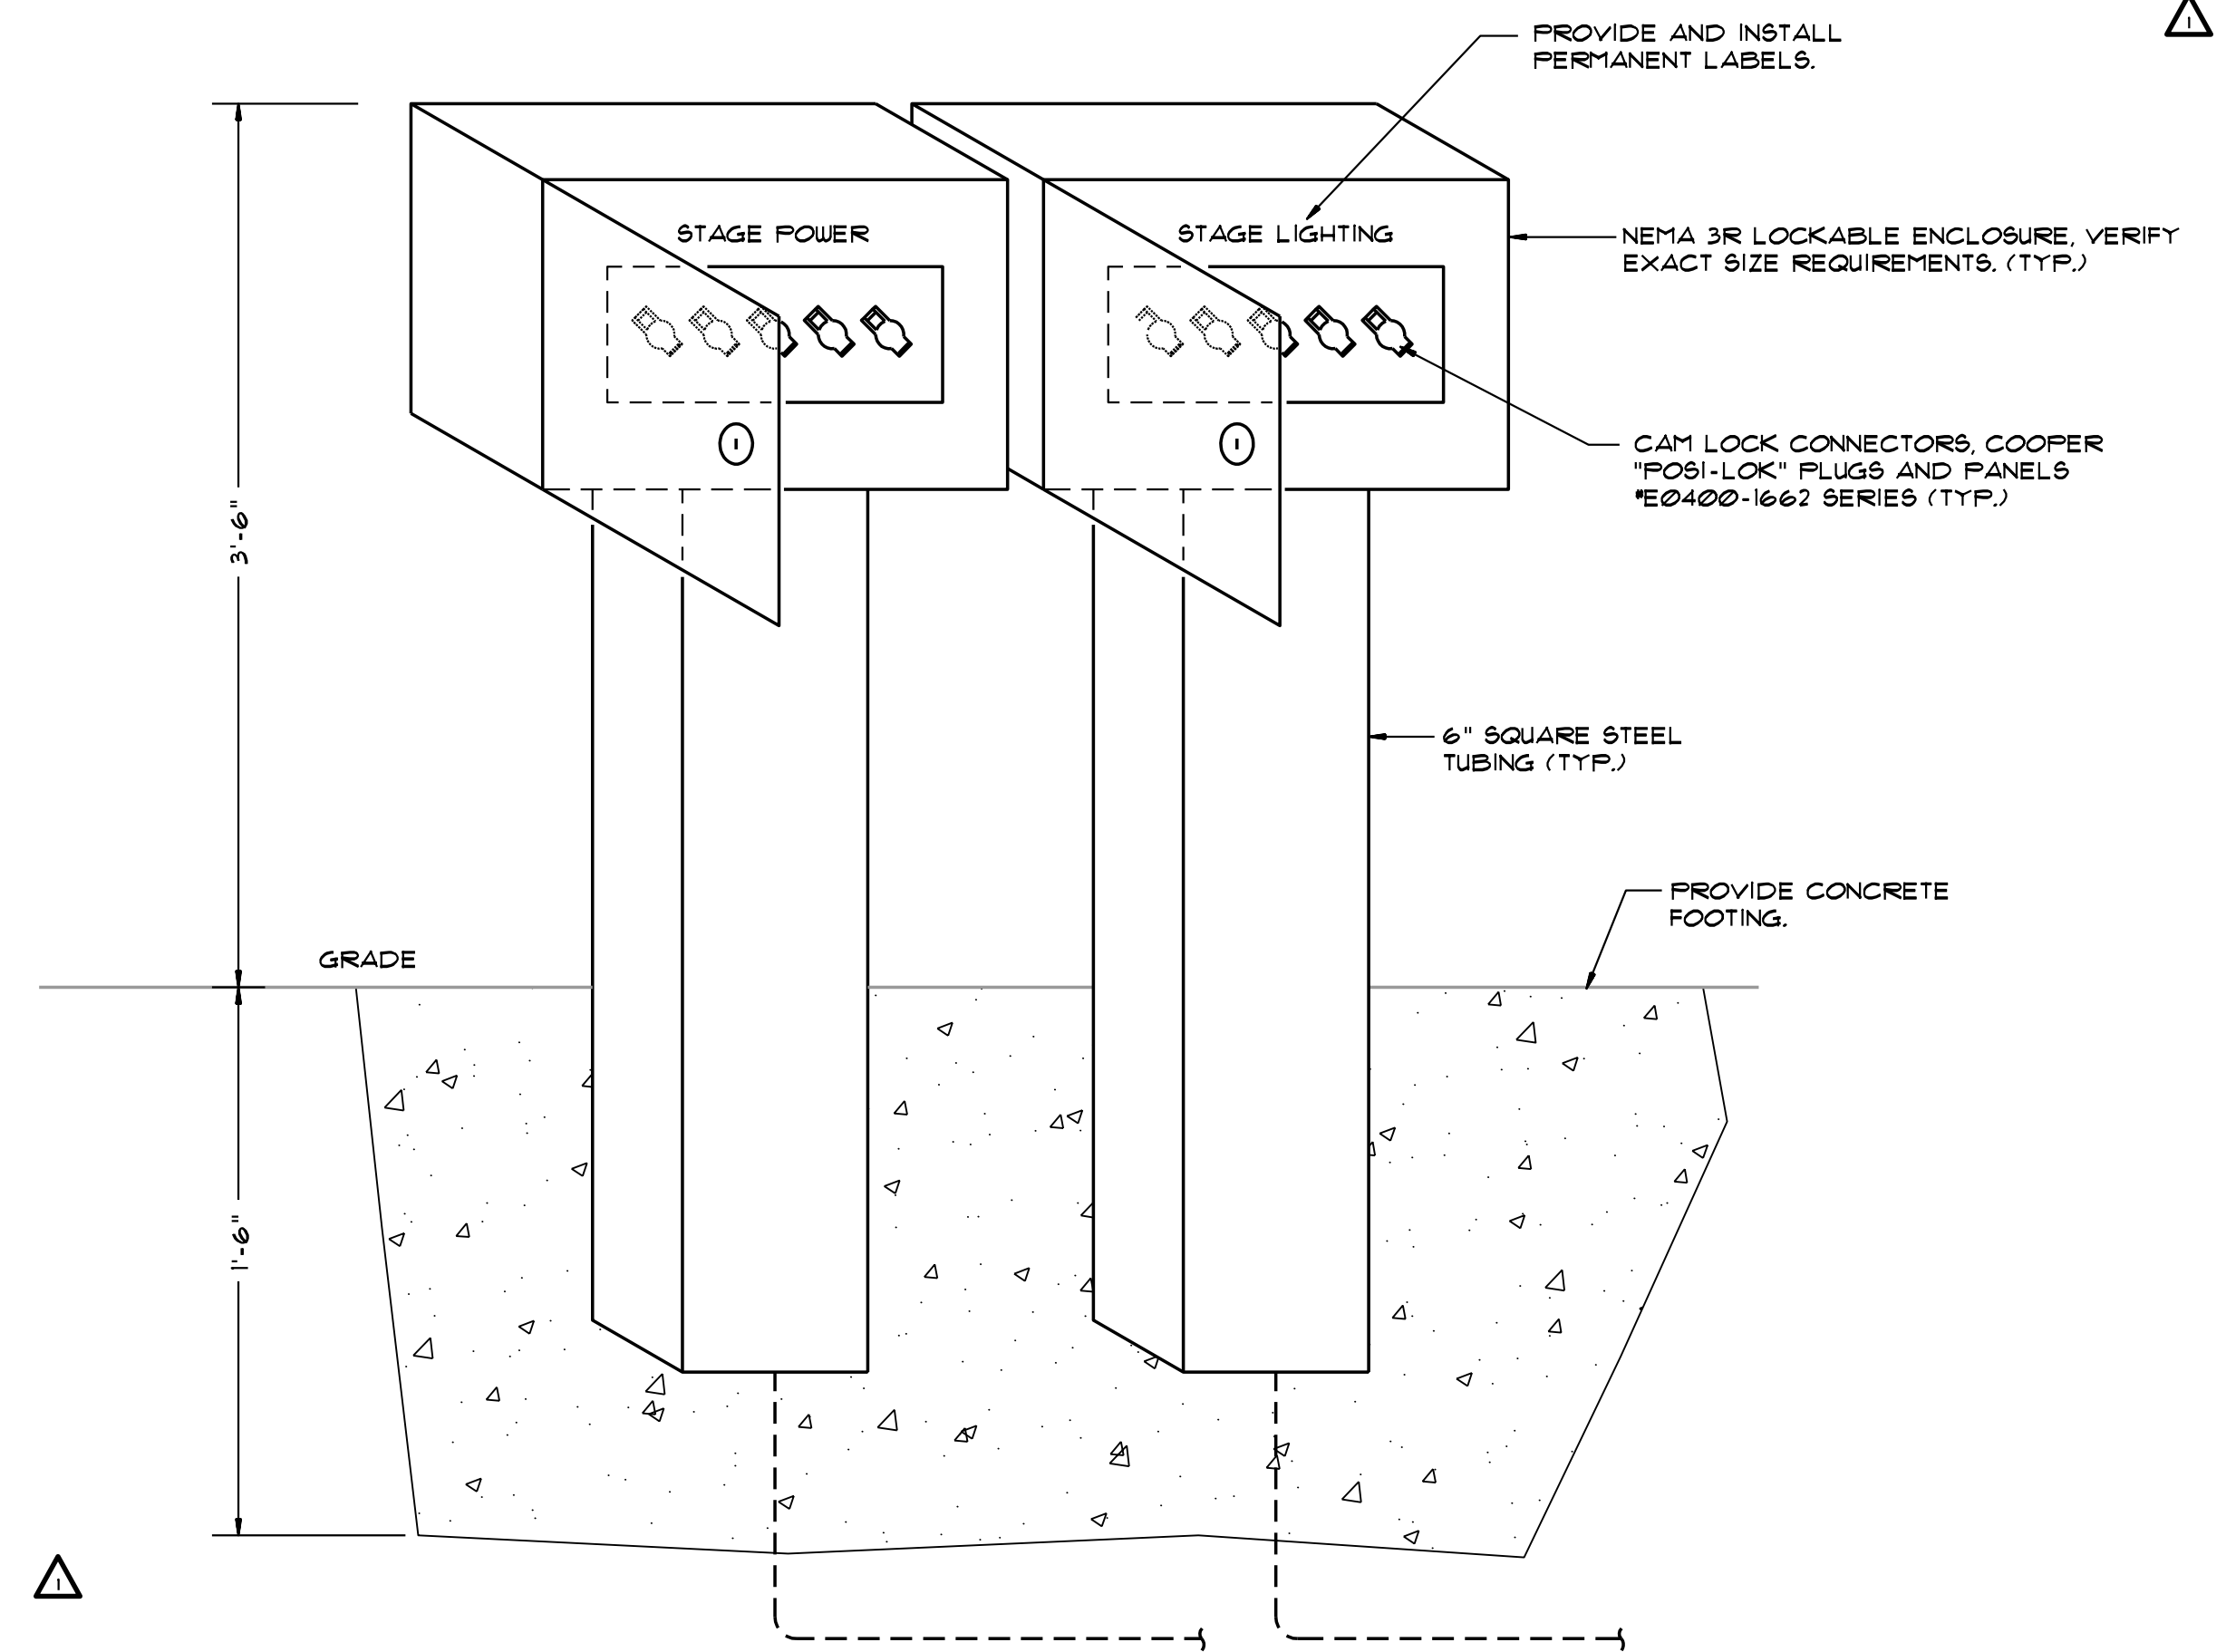

**3 CAM LOCK ENCLOSURE DETAIL**  
SCALE: NONE

**EA** ENGINEERING ASSOCIATES  
TX REG #F-4925  
Ph: 940.427.8487 Fax: 940.427.8499  
P.O. Box 167 Alford, TX 76225

submittals / revisions

no.	date	detail
4	4/2/2014	Electrical Revisions
5	5/8/2014	Electrical Revisions

la terra studio, inc.  
12024  
its project number  
02.26.2014  
date  
C.A.D.  
drawn by  
J.W.  
checked by

