


H:\PROJECTS\ROCKWALL\98192\SHEETS\98192-05.DWG
4/08/99 JULY

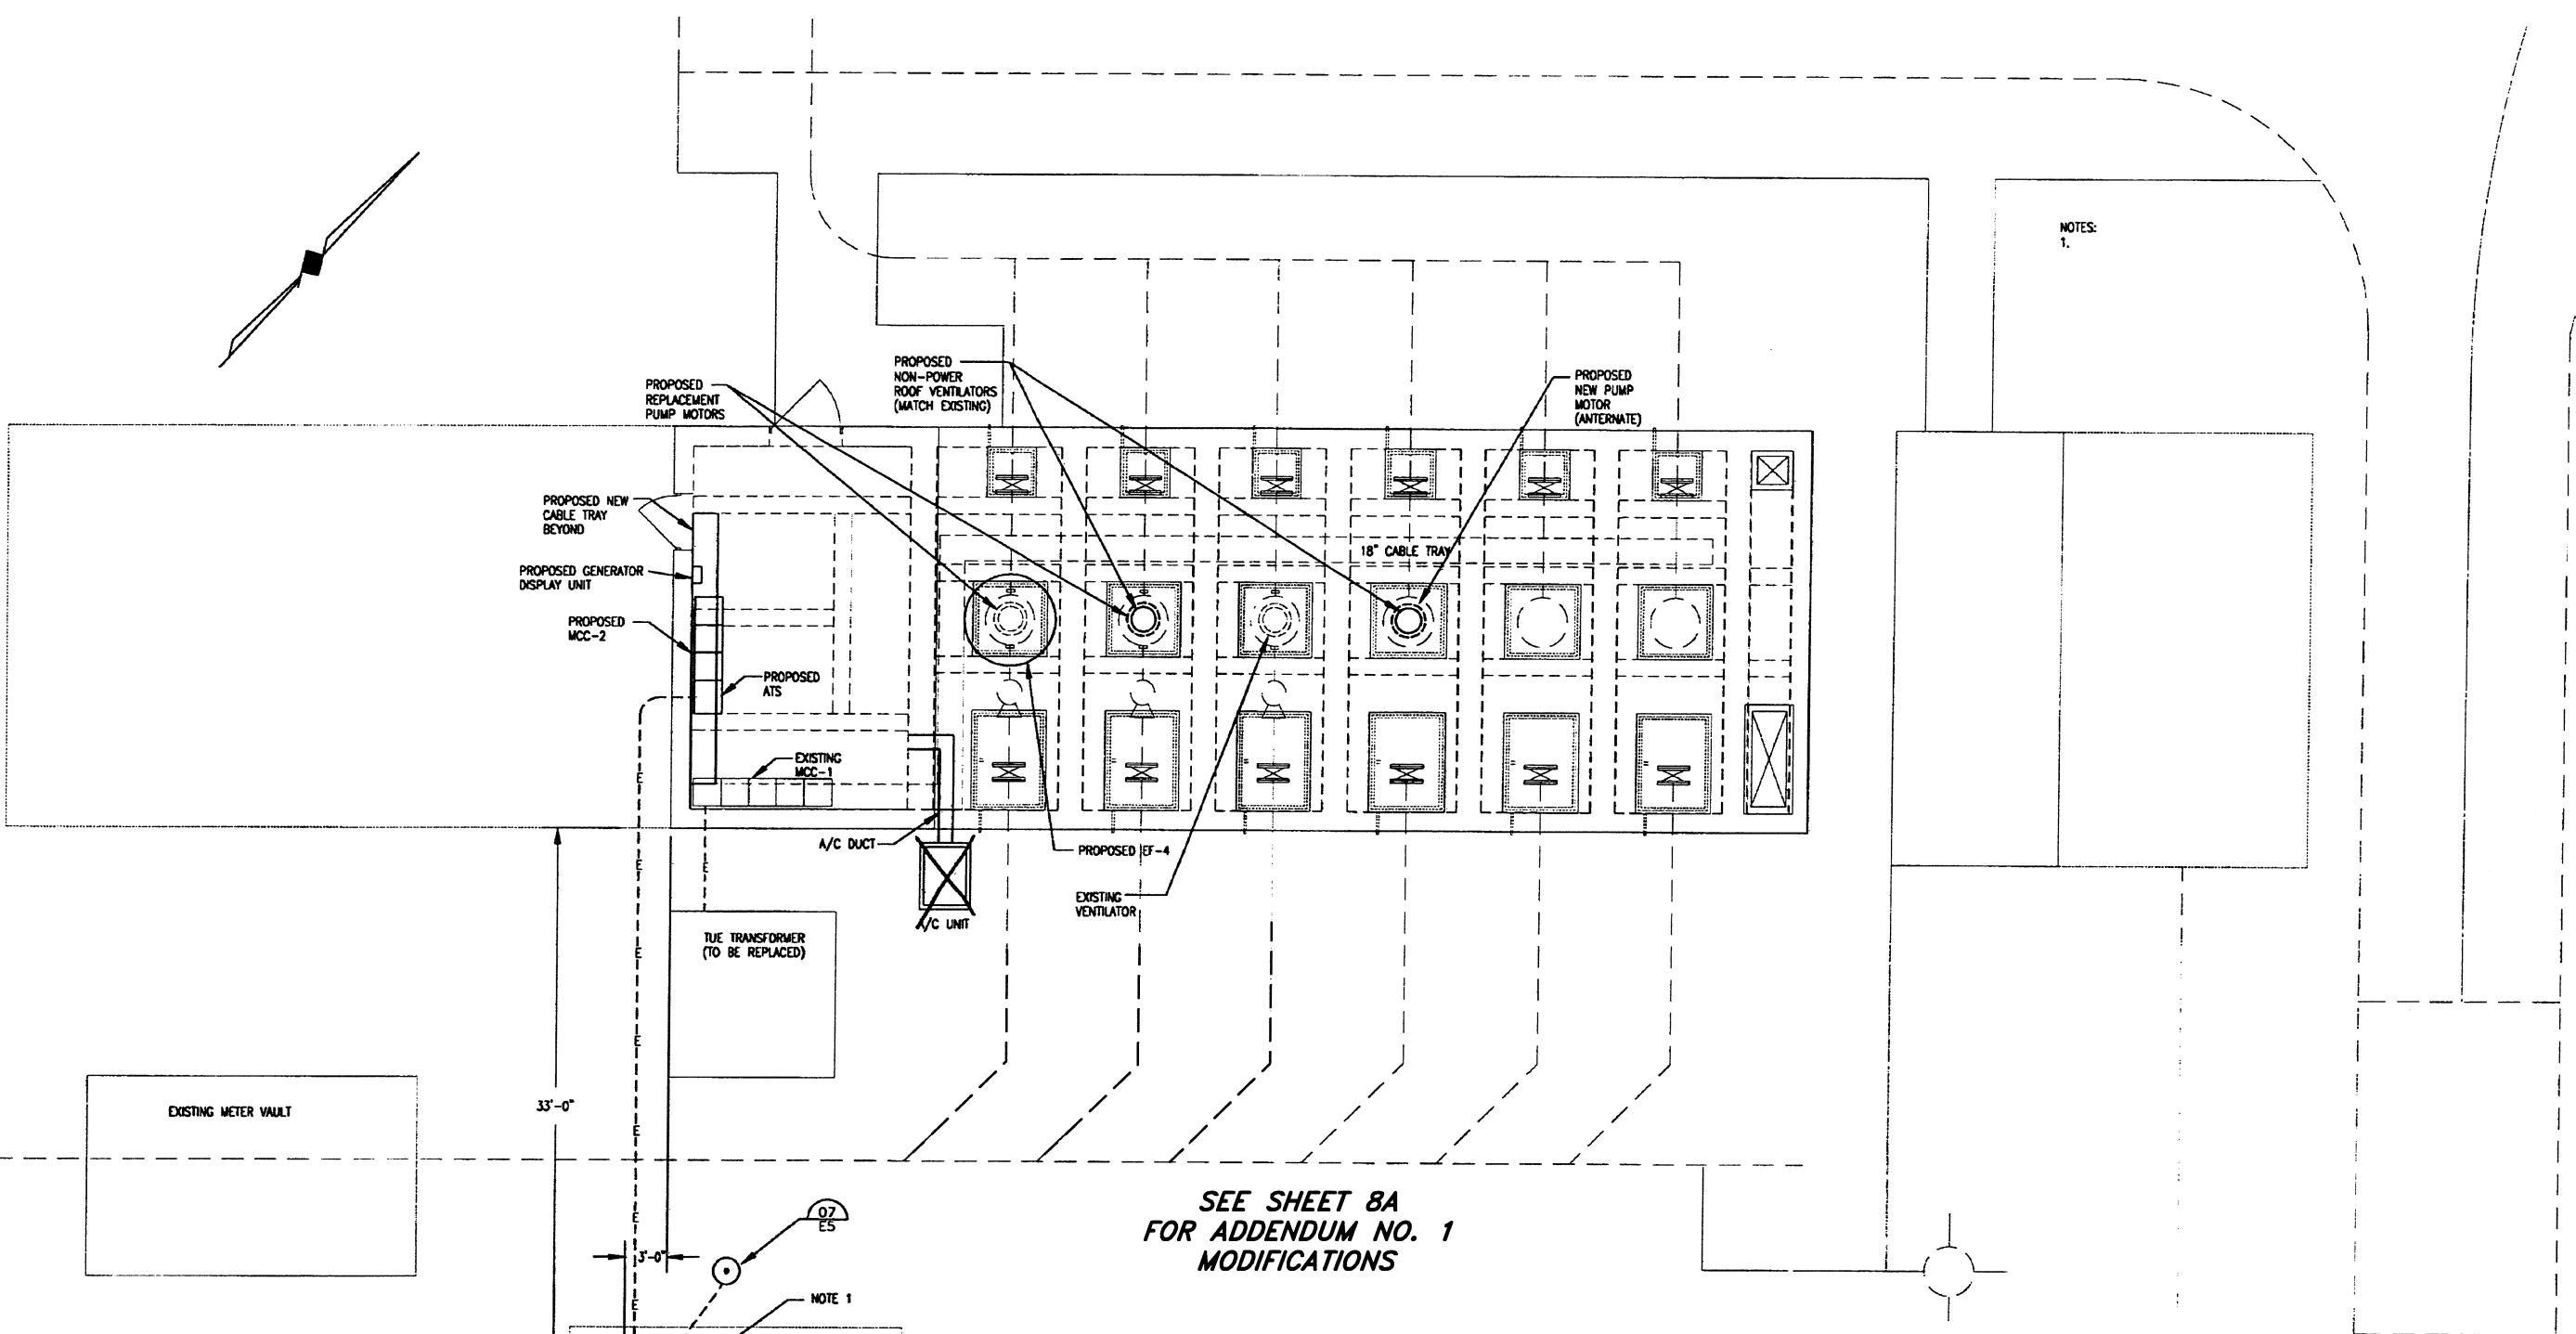

NOTES:
1.

SEE SHEET 8A
FOR ADDENDUM NO. 1
MODIFICATIONS

- NOTES:
1. GROUND GENERATOR FRAME WITH #4/0 AWG IN DUCT BANK. DO NOT GROUND GENERATOR NEUTRAL AT THE GENERATOR.
 2. OBTAIN MANUFACTURERS DRAWINGS AND ACCURATELY LOCATE VOIDS IN GENERATOR FOUNDATION FOR ALL CONDUIT STUBUPS.
 3. GROUND ROD TO GENERATOR WITH #4 AWG CONDUCTOR.

This record drawing is a compilation of the sealed engineering drawing for this project, modified by addenda, change orders and information furnished by the contractor. The information shown on the record drawings that was provided by the contractor or others not associated with the design engineer cannot be verified for accuracy or completeness. This original sealed drawings are on file at the offices of Birkhoff, Hendricks & Conway, L.L.P.

BY G.C.H. DATE 05/06/09

These plans and related specifications were prepared for construction of this specific project only. Reuse of these documents is not permitted without written authorization of Shimek, Jacobs & Finklea.

SITE PLAN
SCALE: 3/16"=1'-0"

John A. Fry
4-8-99



CITY OF ROCKWALL, TEXAS		
EASTSIDE PUMP STATION ELECTRICAL SITE PLAN		
SHIMEK, JACOBS & FINKLEA, L.L.P. CONSULTING ENGINEERS Dallas, Texas		
DESIGNED BY: J. A. FRY	PROJECT: 98 192	SHEET NO. 8
DRAWN BY: R. E. BRADY	DATE: APRIL 1999	OF 12 SHEETS