




PLotted BY: AQUARREZ ON 11/16/2008

Plot Style: 11x17D.ctb

Plot Scale: 1:40

H:\Projects\Rockwall\2004147\Line-D&E\Sheets\2004147-SS&E.dwg

Revised: 11/16/08 - AQUARREZ

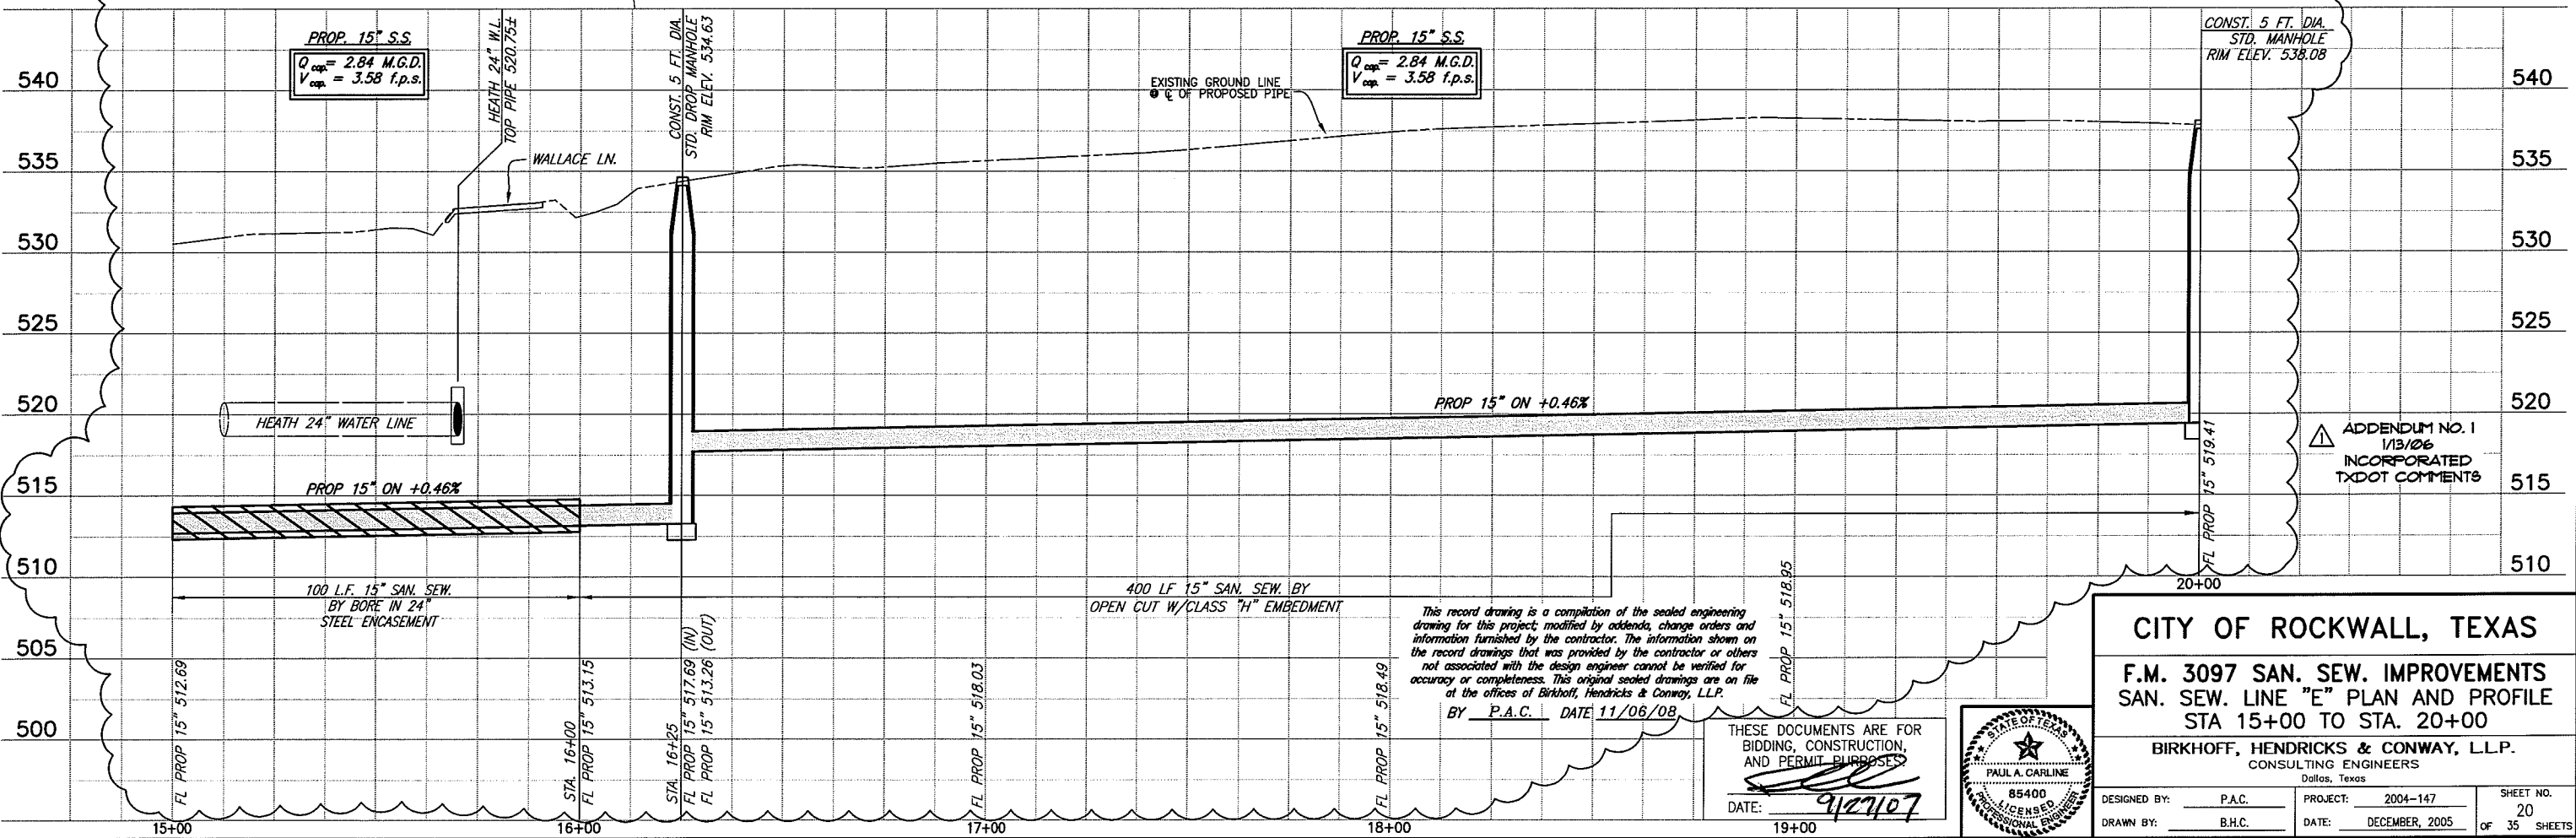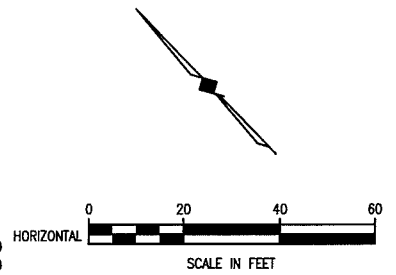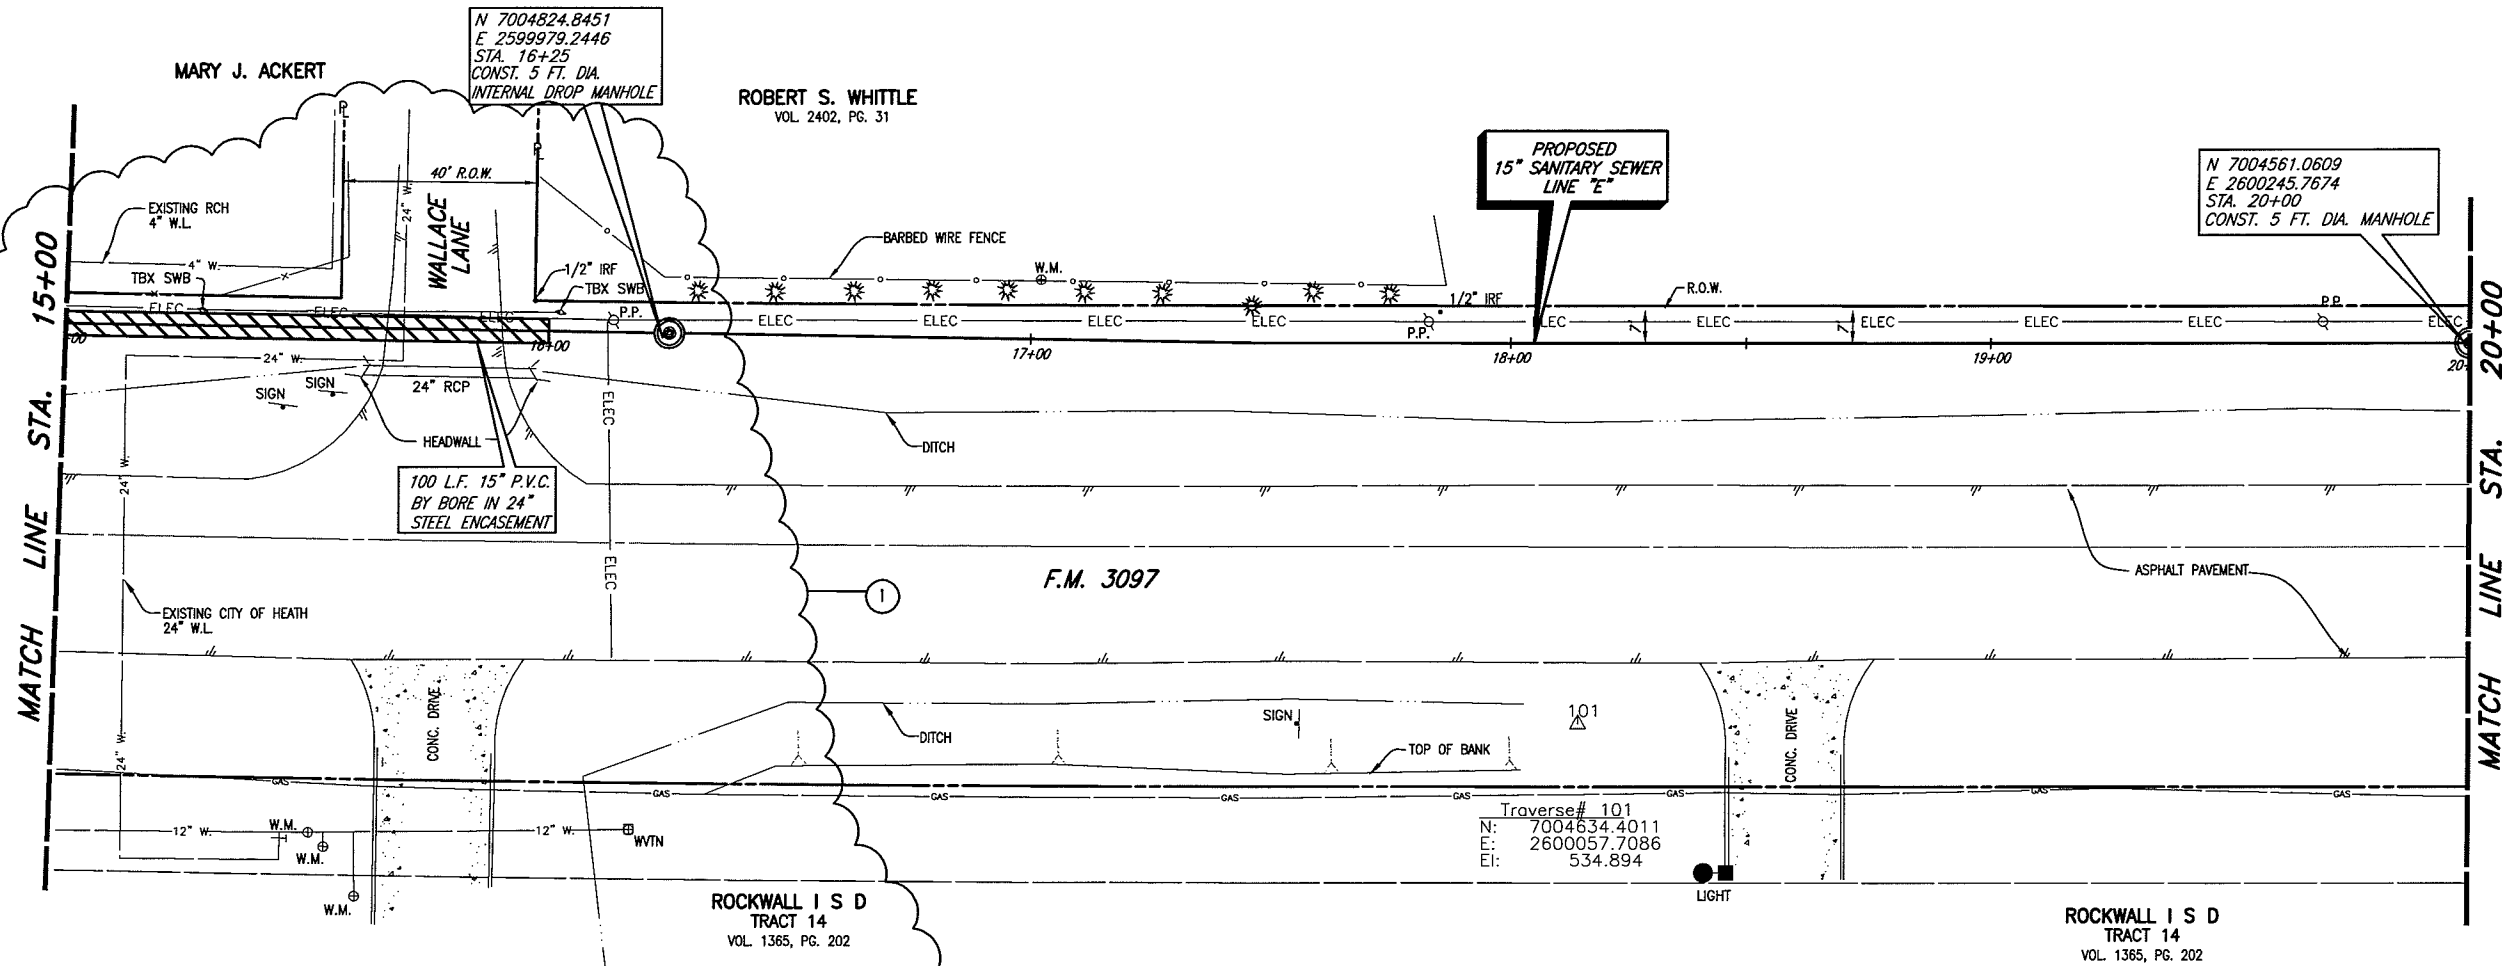

CITY OF ROCKWALL, TEXAS

**F.M. 3097 SAN. SEW. IMPROVEMENTS
SAN. SEW. LINE "E" PLAN AND PROFILE
STA 15+00 TO STA. 20+00**

BIRKHOFF, HENDRICKS & CONWAY, L.L.P.
CONSULTING ENGINEERS
Dallas, Texas

DESIGNED BY: P.A.C. PROJECT: 2004-147 SHEET NO. 20
DRAWN BY: B.H.C. DATE: DECEMBER, 2005 OF 35 SHEETS

PAUL A. CARLINE
85400
LICENSED PROFESSIONAL ENGINEER

① FIELD CHANGE NO. 1 SEPTEMBER 27, 2007