


NOTE: ABANDON EXISTING 6" WATERLINE IN PLACE.

RECORD DRAWING
 VERIFIED BY *Voranique Simon*
 DATE 4-20-00

RECORD DRAWING

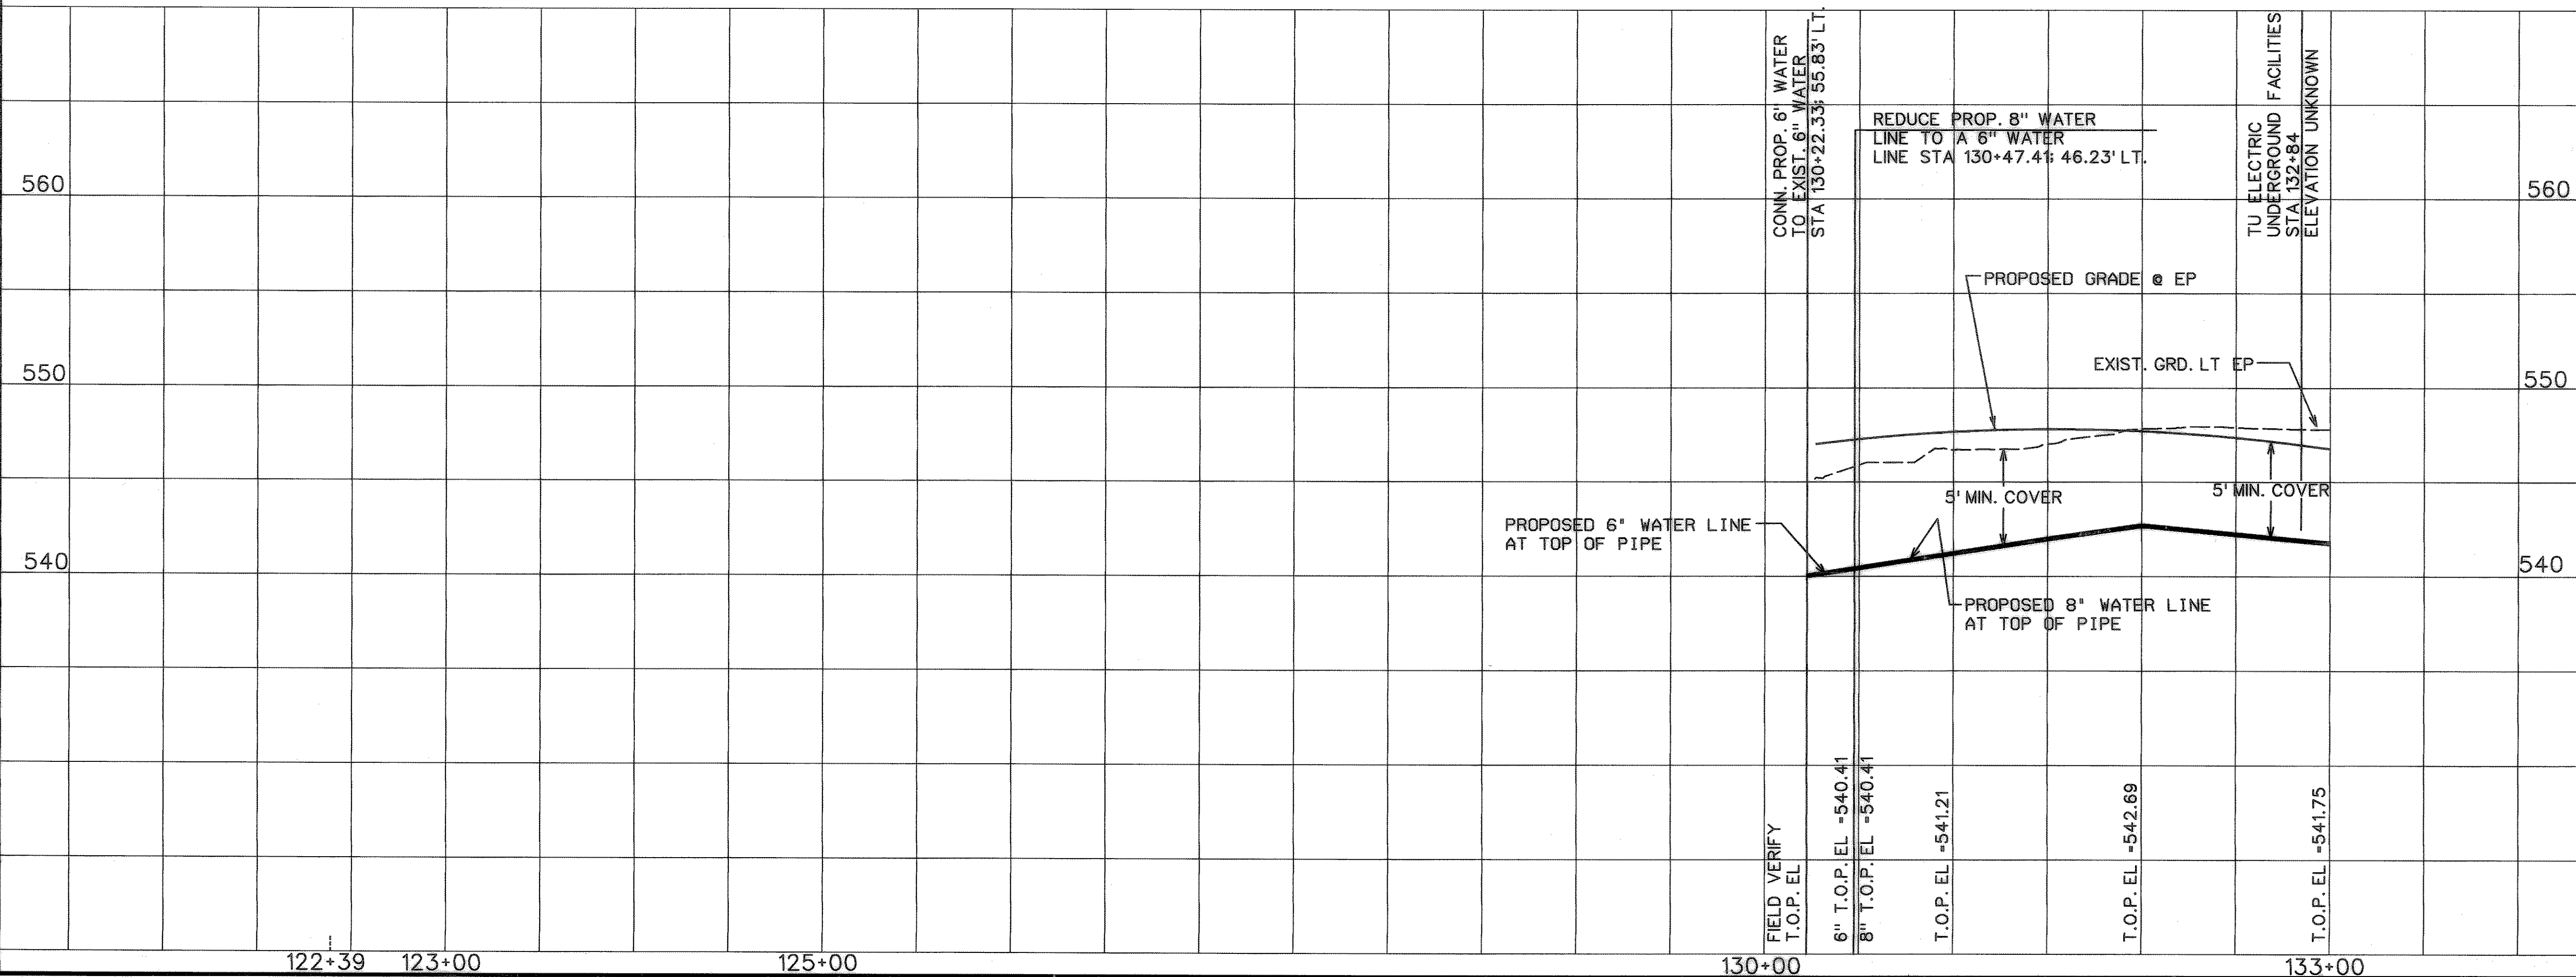

STATE OF TEXAS
 VORANIQUE V. SIMON
 06381
 PROFESSIONAL ENGINEER
Voranique Simon
 4-19-00

STATE OF TEXAS
 ROBERT C. REACH
 48587
Robert C. Reach
 1-14-99

CITY OF ROCKWALL
 "THE NEW HORIZON"

UTILITY RELOCATIONS FOR FM 740 WIDENING

UTILITY PLAN AND PROFILE
PROPOSED 8" WATER LINE
 STA. 128+00 TO STA. 133+00

TurnerCollie & Braden Inc.
 ENGINEERS • PLANNERS • PROJECT MANAGERS

Unit	A103	Scale: Horz. 1"=50'	Vert. 1"=5'	Date	JANUARY 1999
Designed	TCB	Checked	V.S.	Job No.	15-97925-100
Drawn	TCB	Approved	<i>TCB</i>		SHEET 6 OF 31