
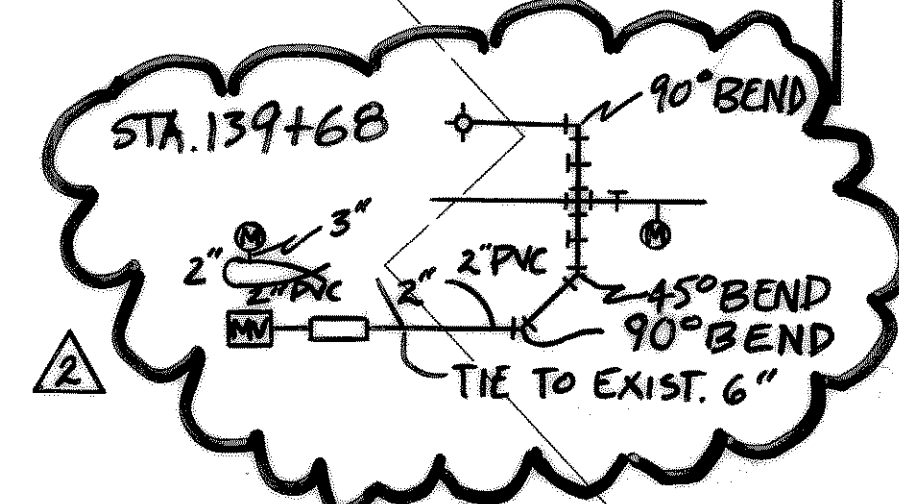





PI STA 137+50.1829
 X = 2317011.6714
 Y = 450248.2338
 Δ = 13° 11' 39.82" RT.
 D = 2° 15' 00.00"
 T = 294.5114'
 L = 586.4175'
 R = 2546.4791'

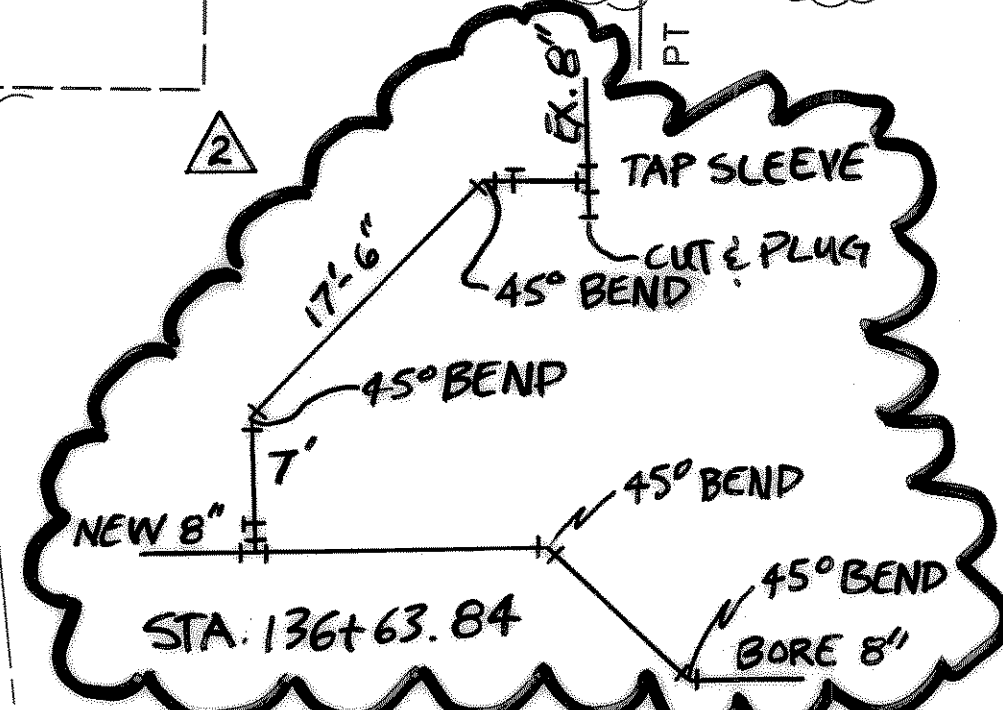

NOTE:
 ABANDON EXISTING 6" WATERLINE
 IN PLACE.

RECORD DRAWING
 VERIFIED BY *Vernique Lima*
 DATE 4-20-00

1 REVISION #1:
 CASING INSTALLATION TYPE ADDED
 2 RECORD DRAWING

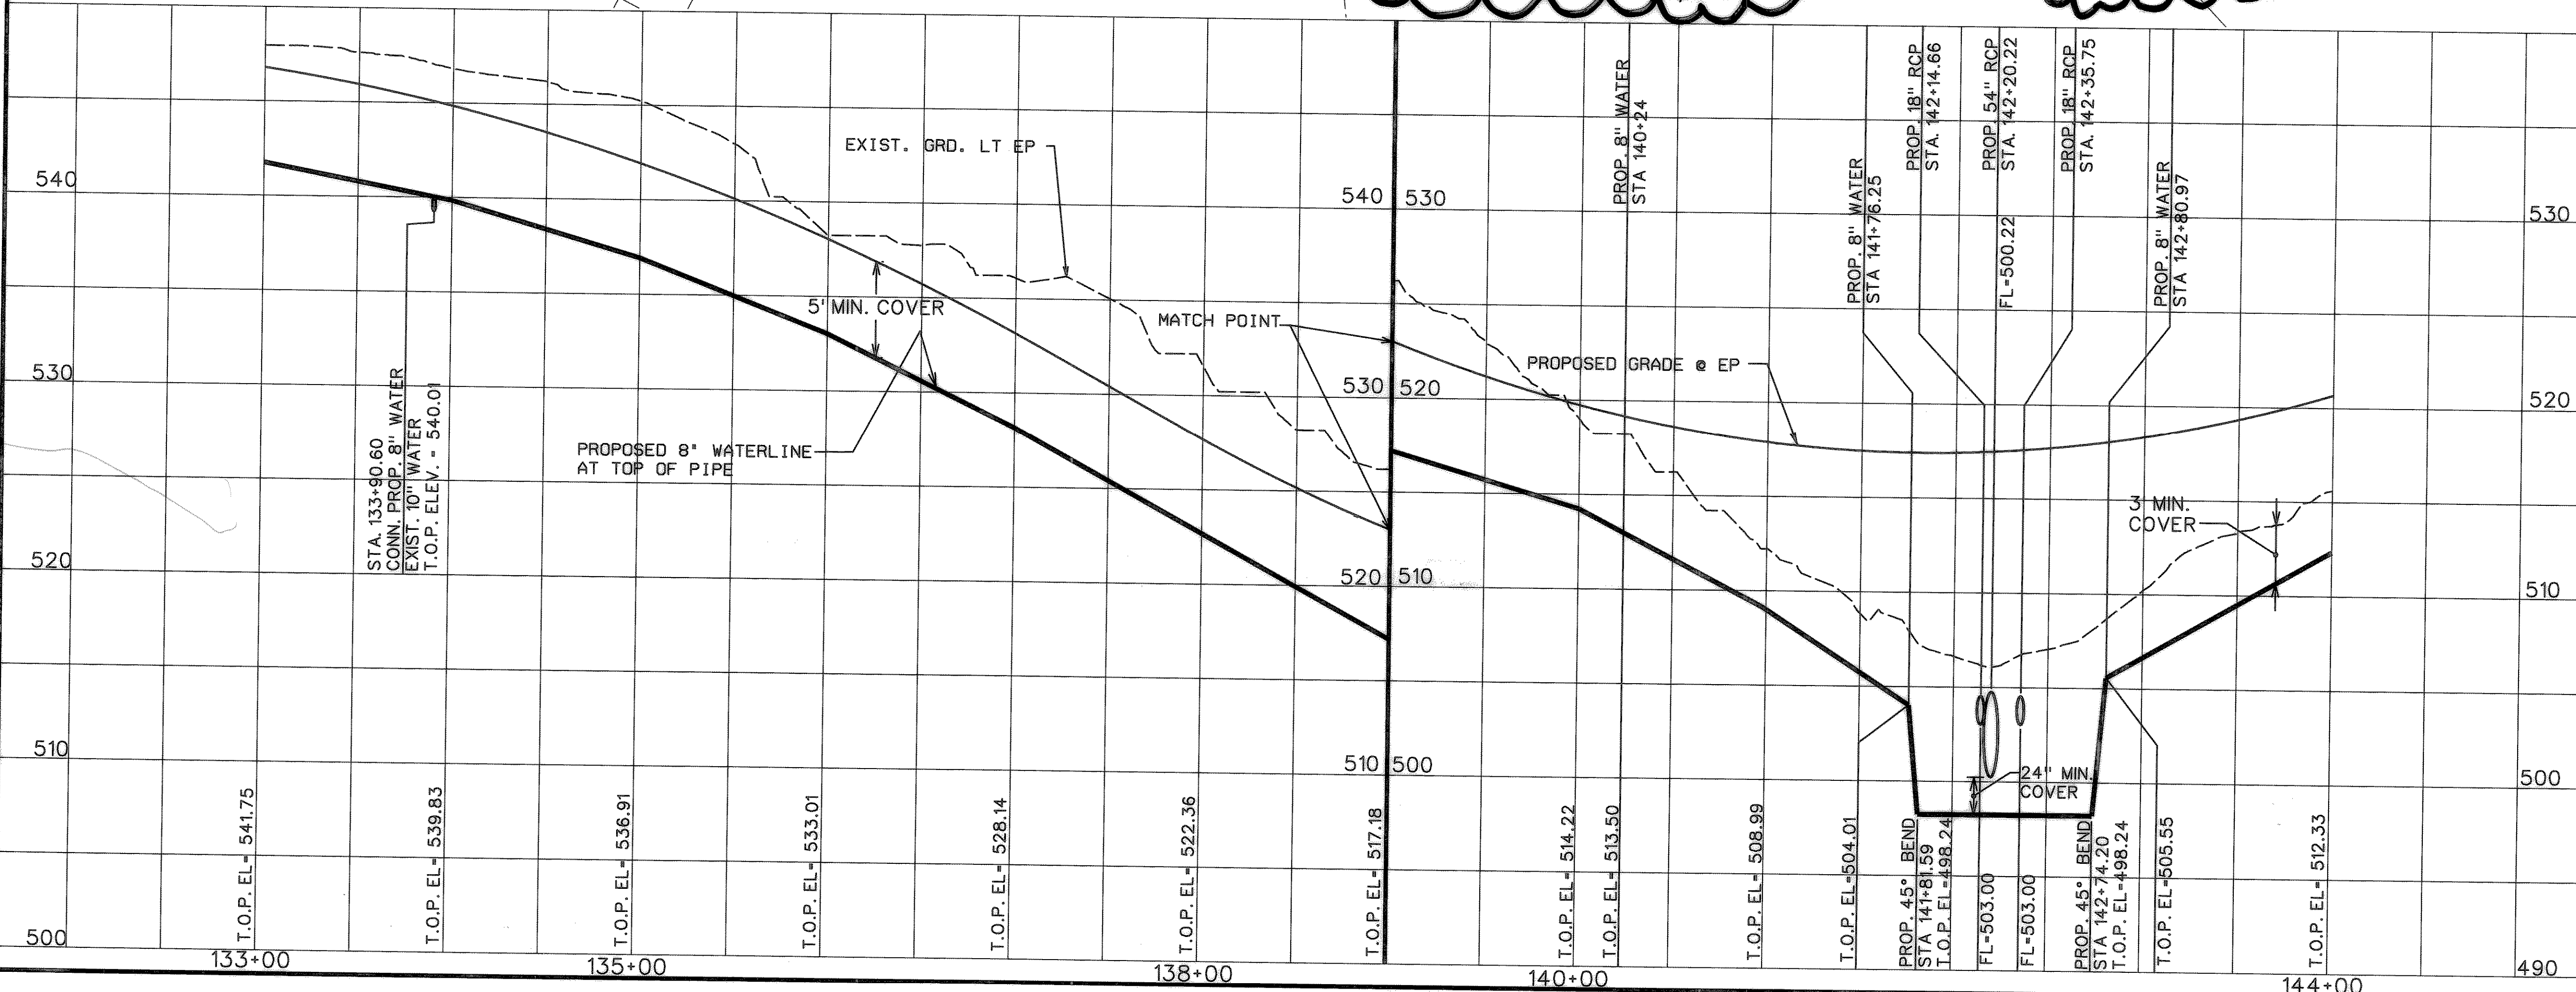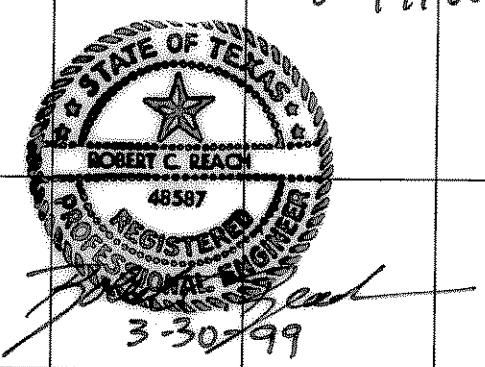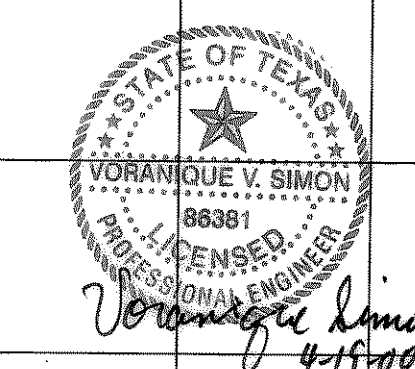

CITY OF ROCKWALL
 "THE NEW HORIZON"

UTILITY RELOCATIONS FOR FM 740 WIDENING

UTILITY PLAN AND PROFILE
 PROPOSED 8" WATER LINE
 STA. 133+00 TO STA. 144+00

Turner Collier & Braden Inc.
 ENGINEERS • PLANNERS • PROJECT MANAGERS

Unit	A103	Scale	Horz. 1"=50' Vert. 1"=5'	Date	JANUARY 1999
Designed	TCB	Checked	V.S.	Job No.	15-97925-100
Drawn	TCB	Approved			SHEET 7 OF 31

PLANNING & DESIGN SERVICES, INC.