




HORIZONTAL SCALE: 1" = 20'
VERTICAL SCALE: 1" = 2'

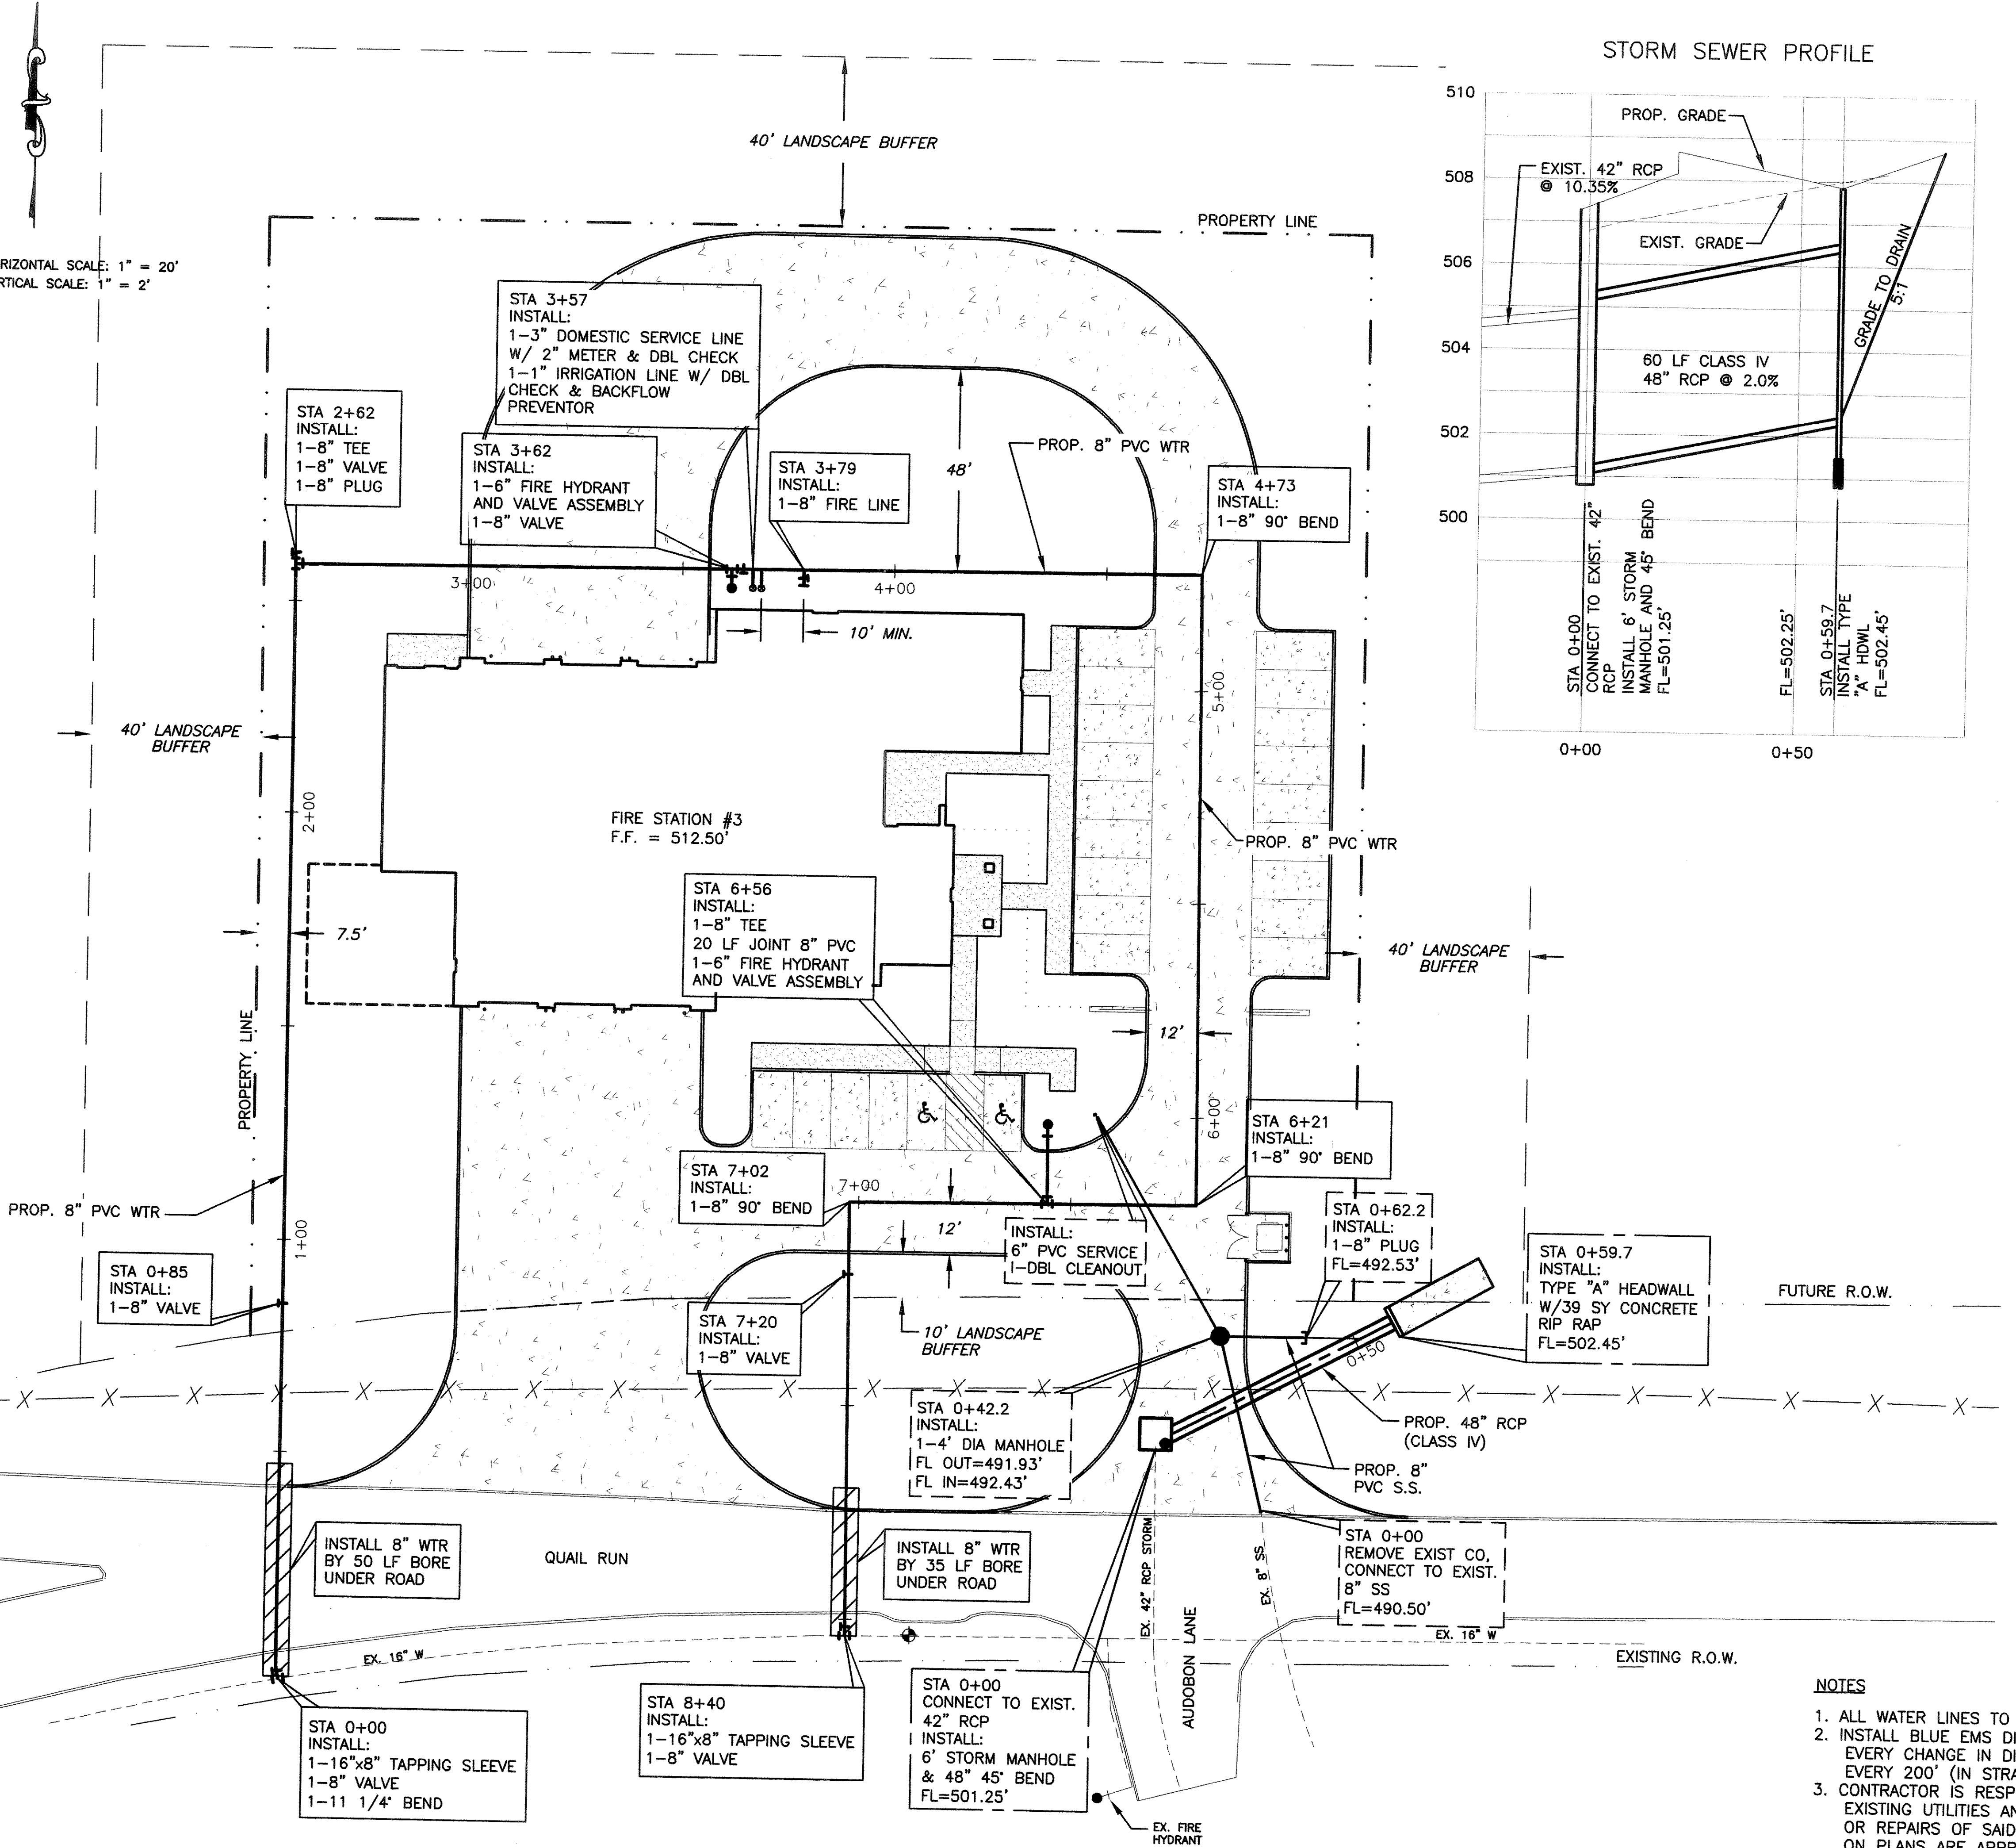

STORM SEWER PROFILE

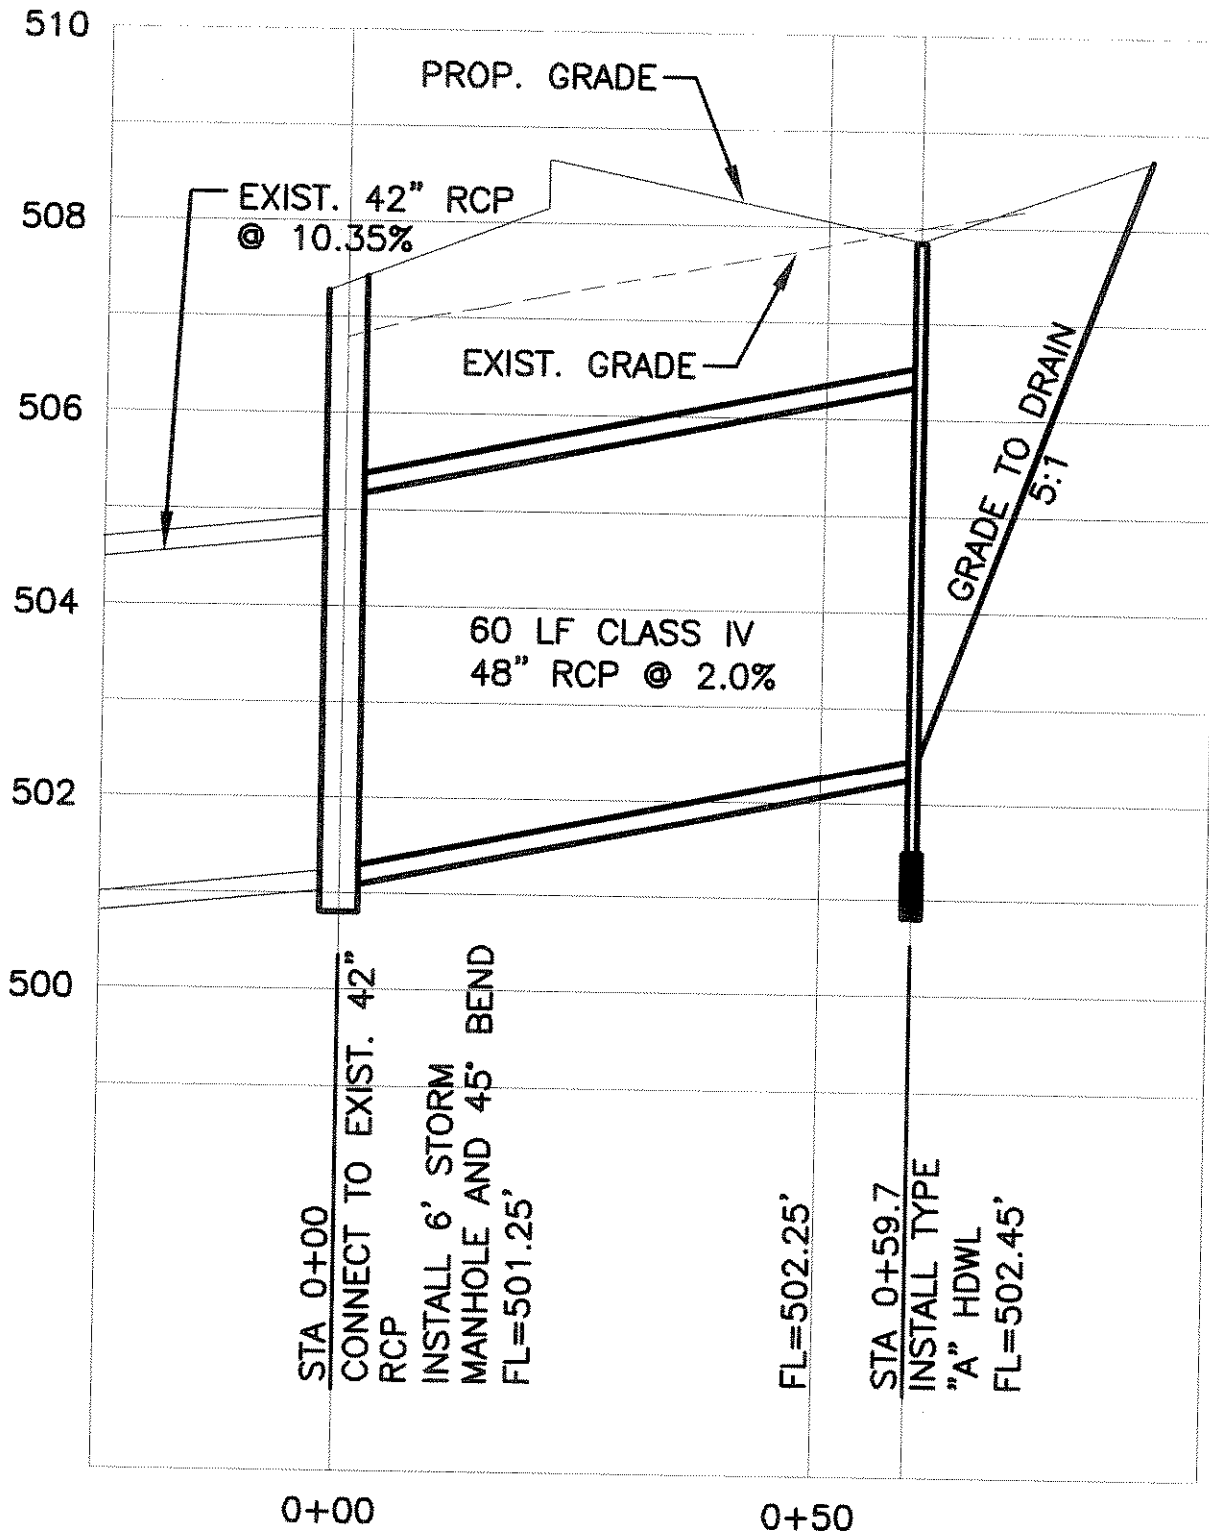

SANITARY SEWER PROFILE

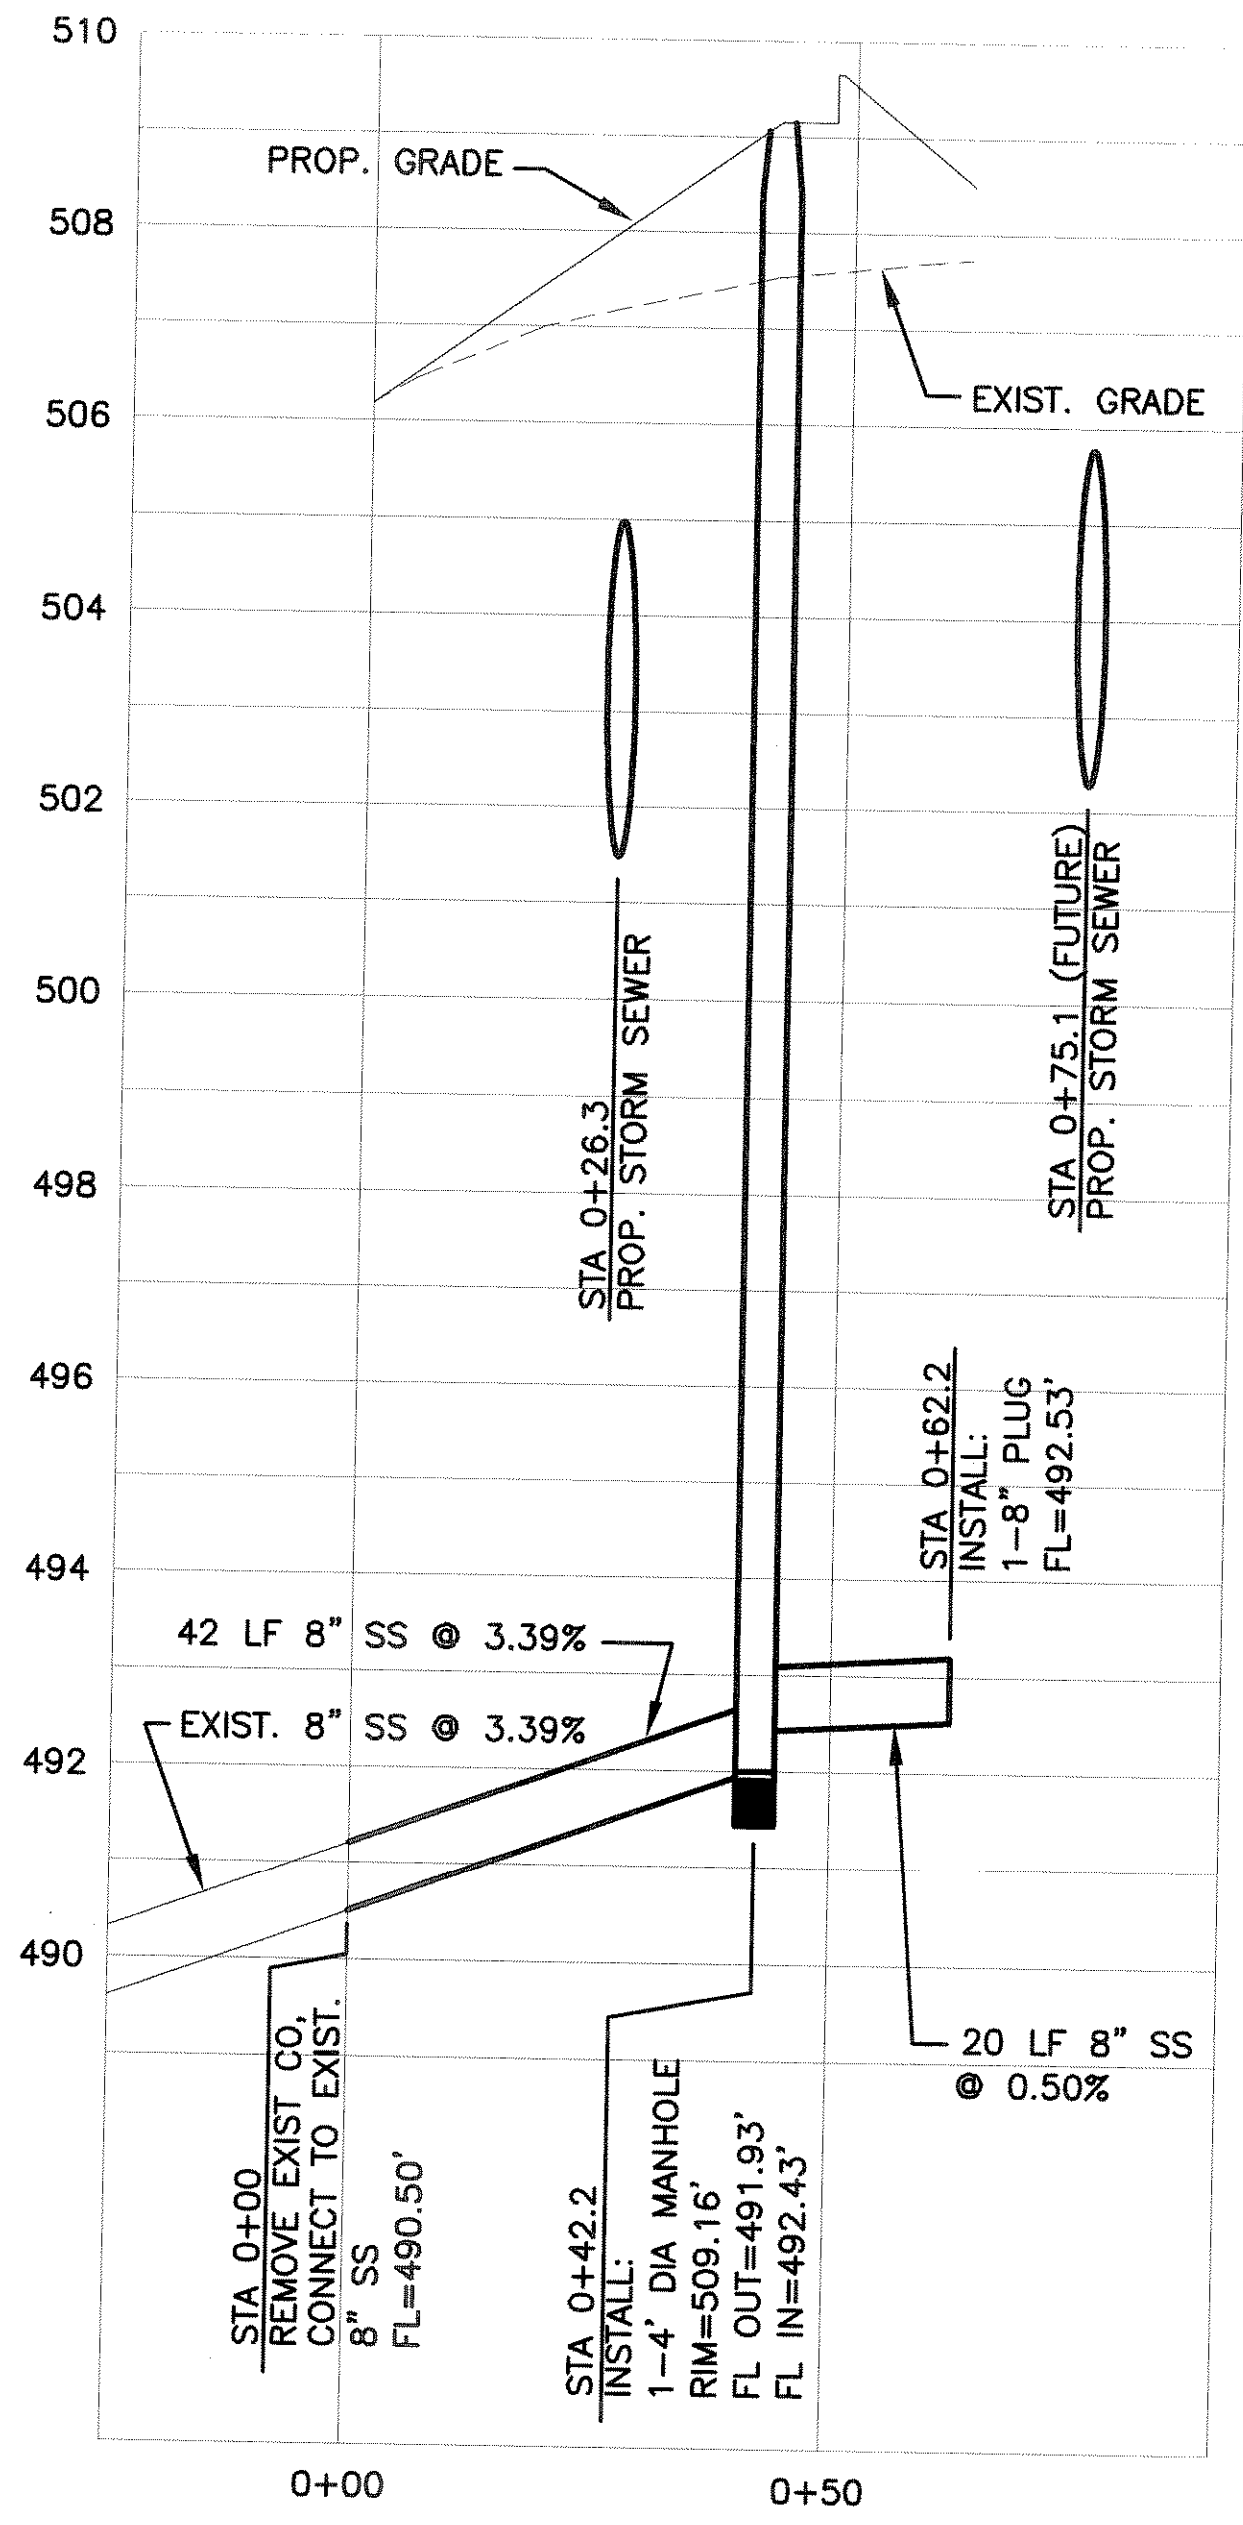

NOTES

1. ALL WATER LINES TO BE MIN. C900, CLASS 200, DR14.
2. INSTALL BLUE EMS DISKS ON THE WATER LINE AT EVERY CHANGE IN DIRECTION, VALVE, SERVICE, AND EVERY 200' (IN STRAIGHT LINES).
3. CONTRACTOR IS RESPONSIBLE FOR LOCATION OF ALL EXISTING UTILITIES AND FOR ANY RELOCATIONS, DAMAGES, OR REPAIRS OF SAID EXISTING UTILITIES. EXISTING UTILITIES ON PLANS ARE APPROXIMATE.
4. USE CITY OF ROCKWALL STANDARD DETAILS AND NCTCOG 3RD EDITION DETAILS, AS MODIFIED BY CITY.



CALLAHAN & FREEMAN
ARCHITECTS
P.O. Box 15377 Fort Worth, Texas 76119
(817) 478-1765 (817) 478-1497

Fab-Crete
1150 E. Mansfield Hwy., Kenesaw, TX 76060
(817) 478-1137 Fax: (817) 361-2544

CITY OF ROCKWALL
NEW FIRE STATIONS
FIRE STATIONS 3 AND 4
ROCKWALL, TEXAS

UTILITY PLAN

DATE: 22 SEPT 2008
REVISIONS:
JOB NO: 55039 SFC
DRAWN BY: KRL

SHEET NO.
C-3.3
COPYRIGHT © 2008

DESIGN - BUILD TEAM