
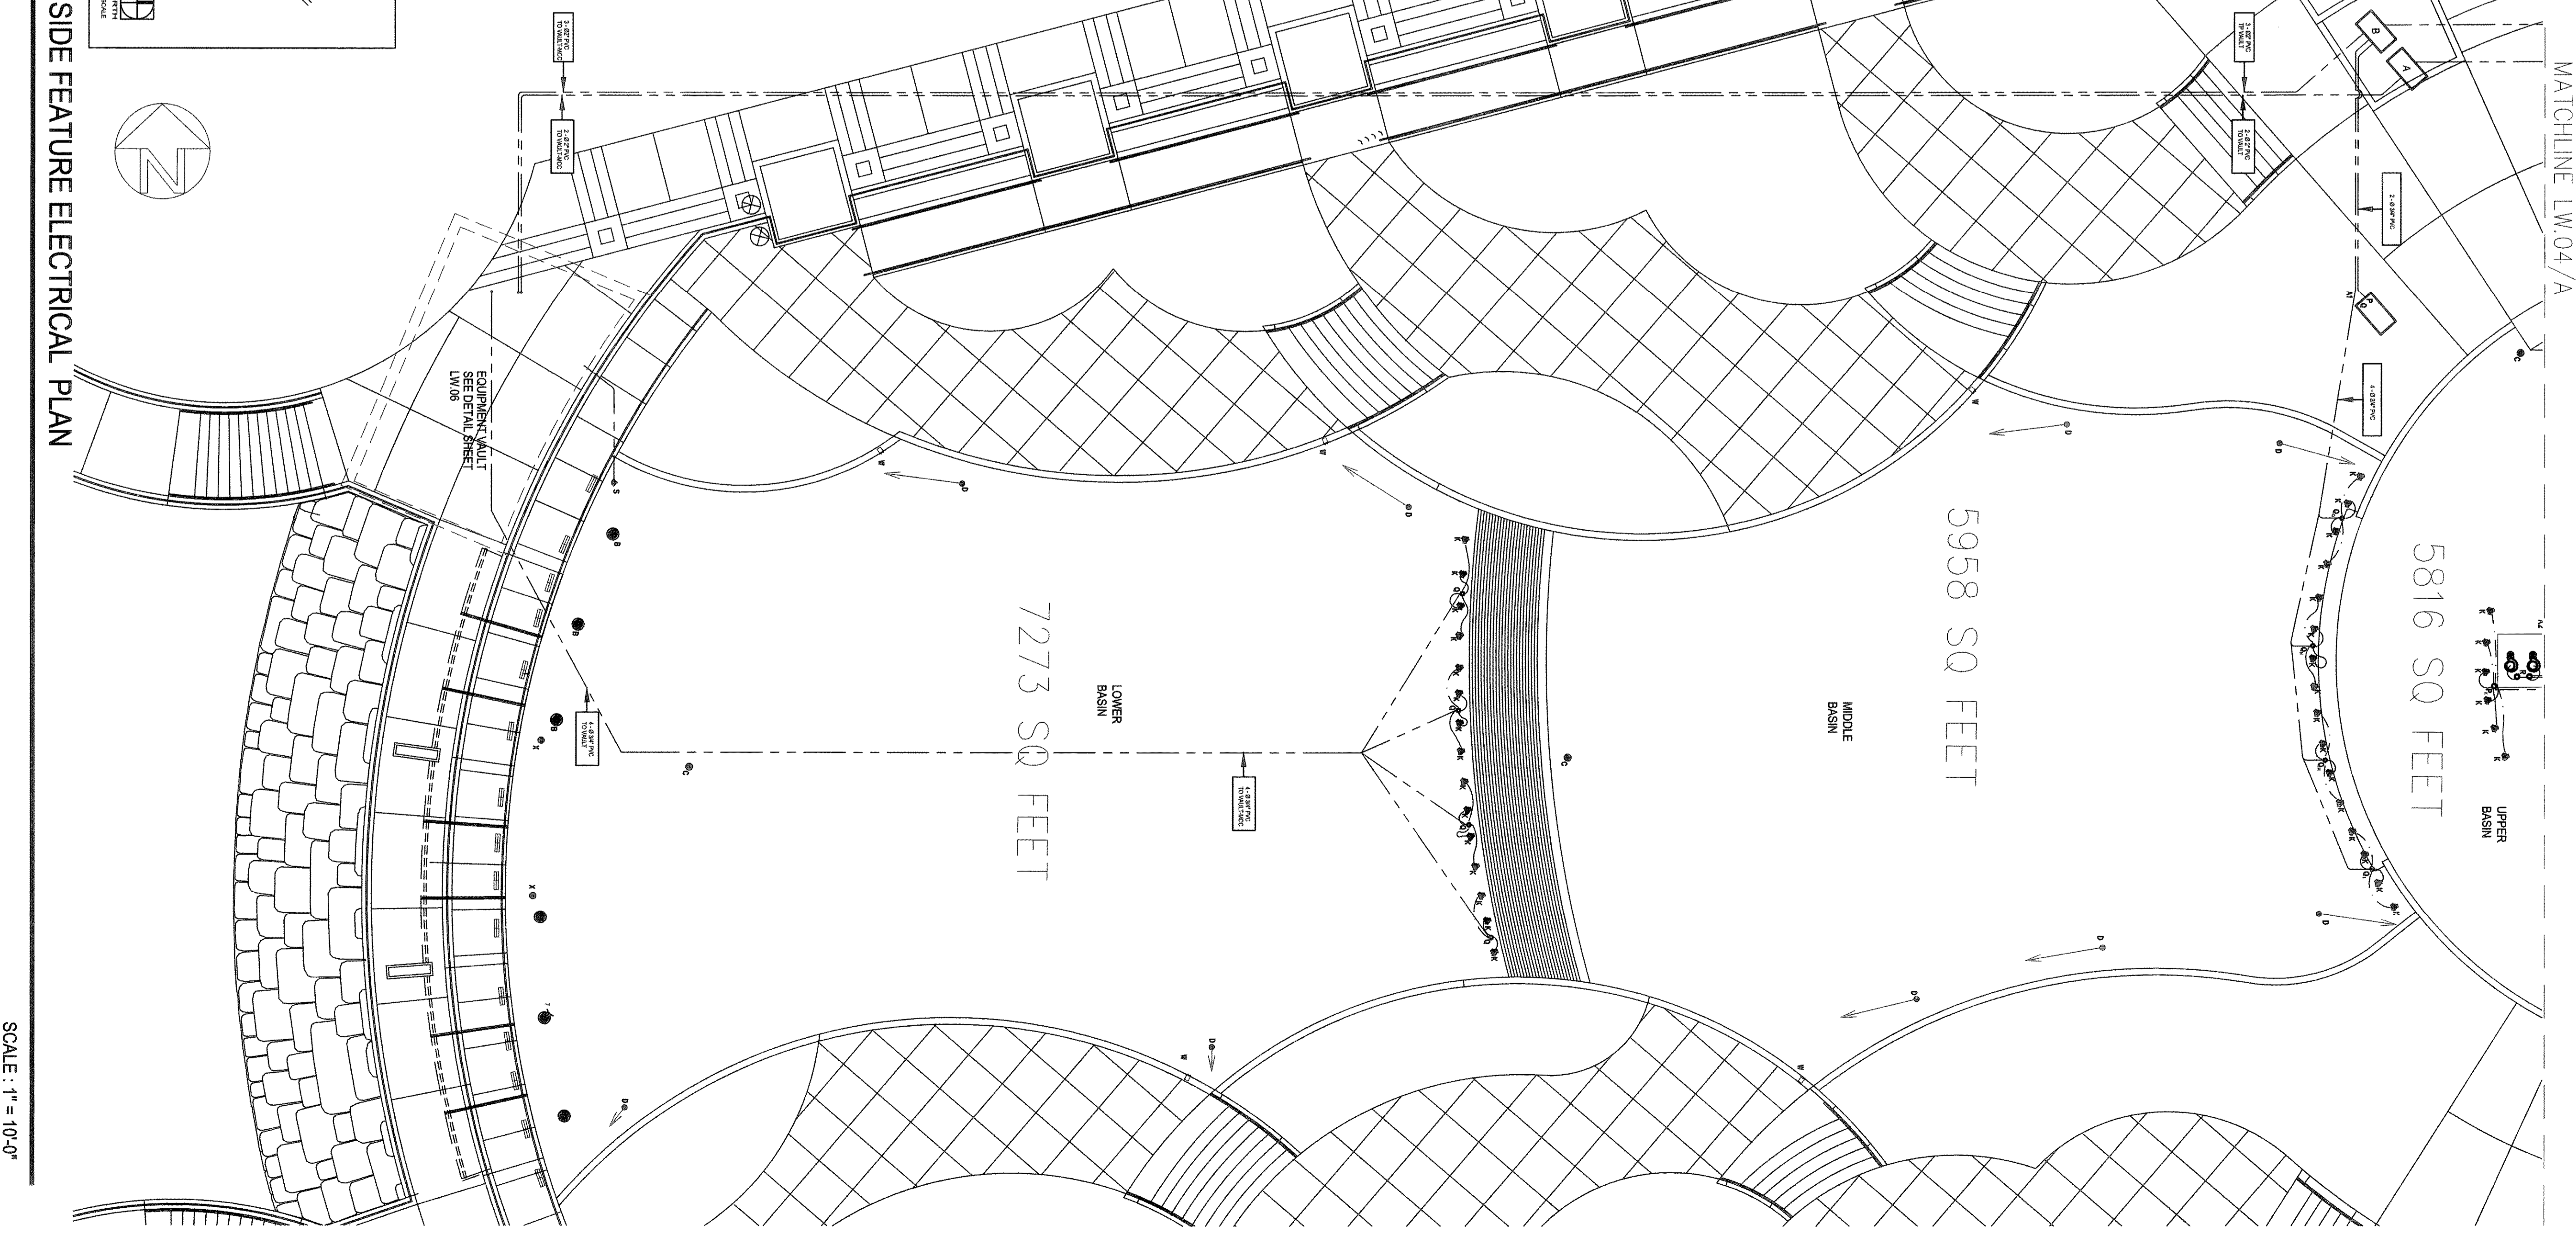
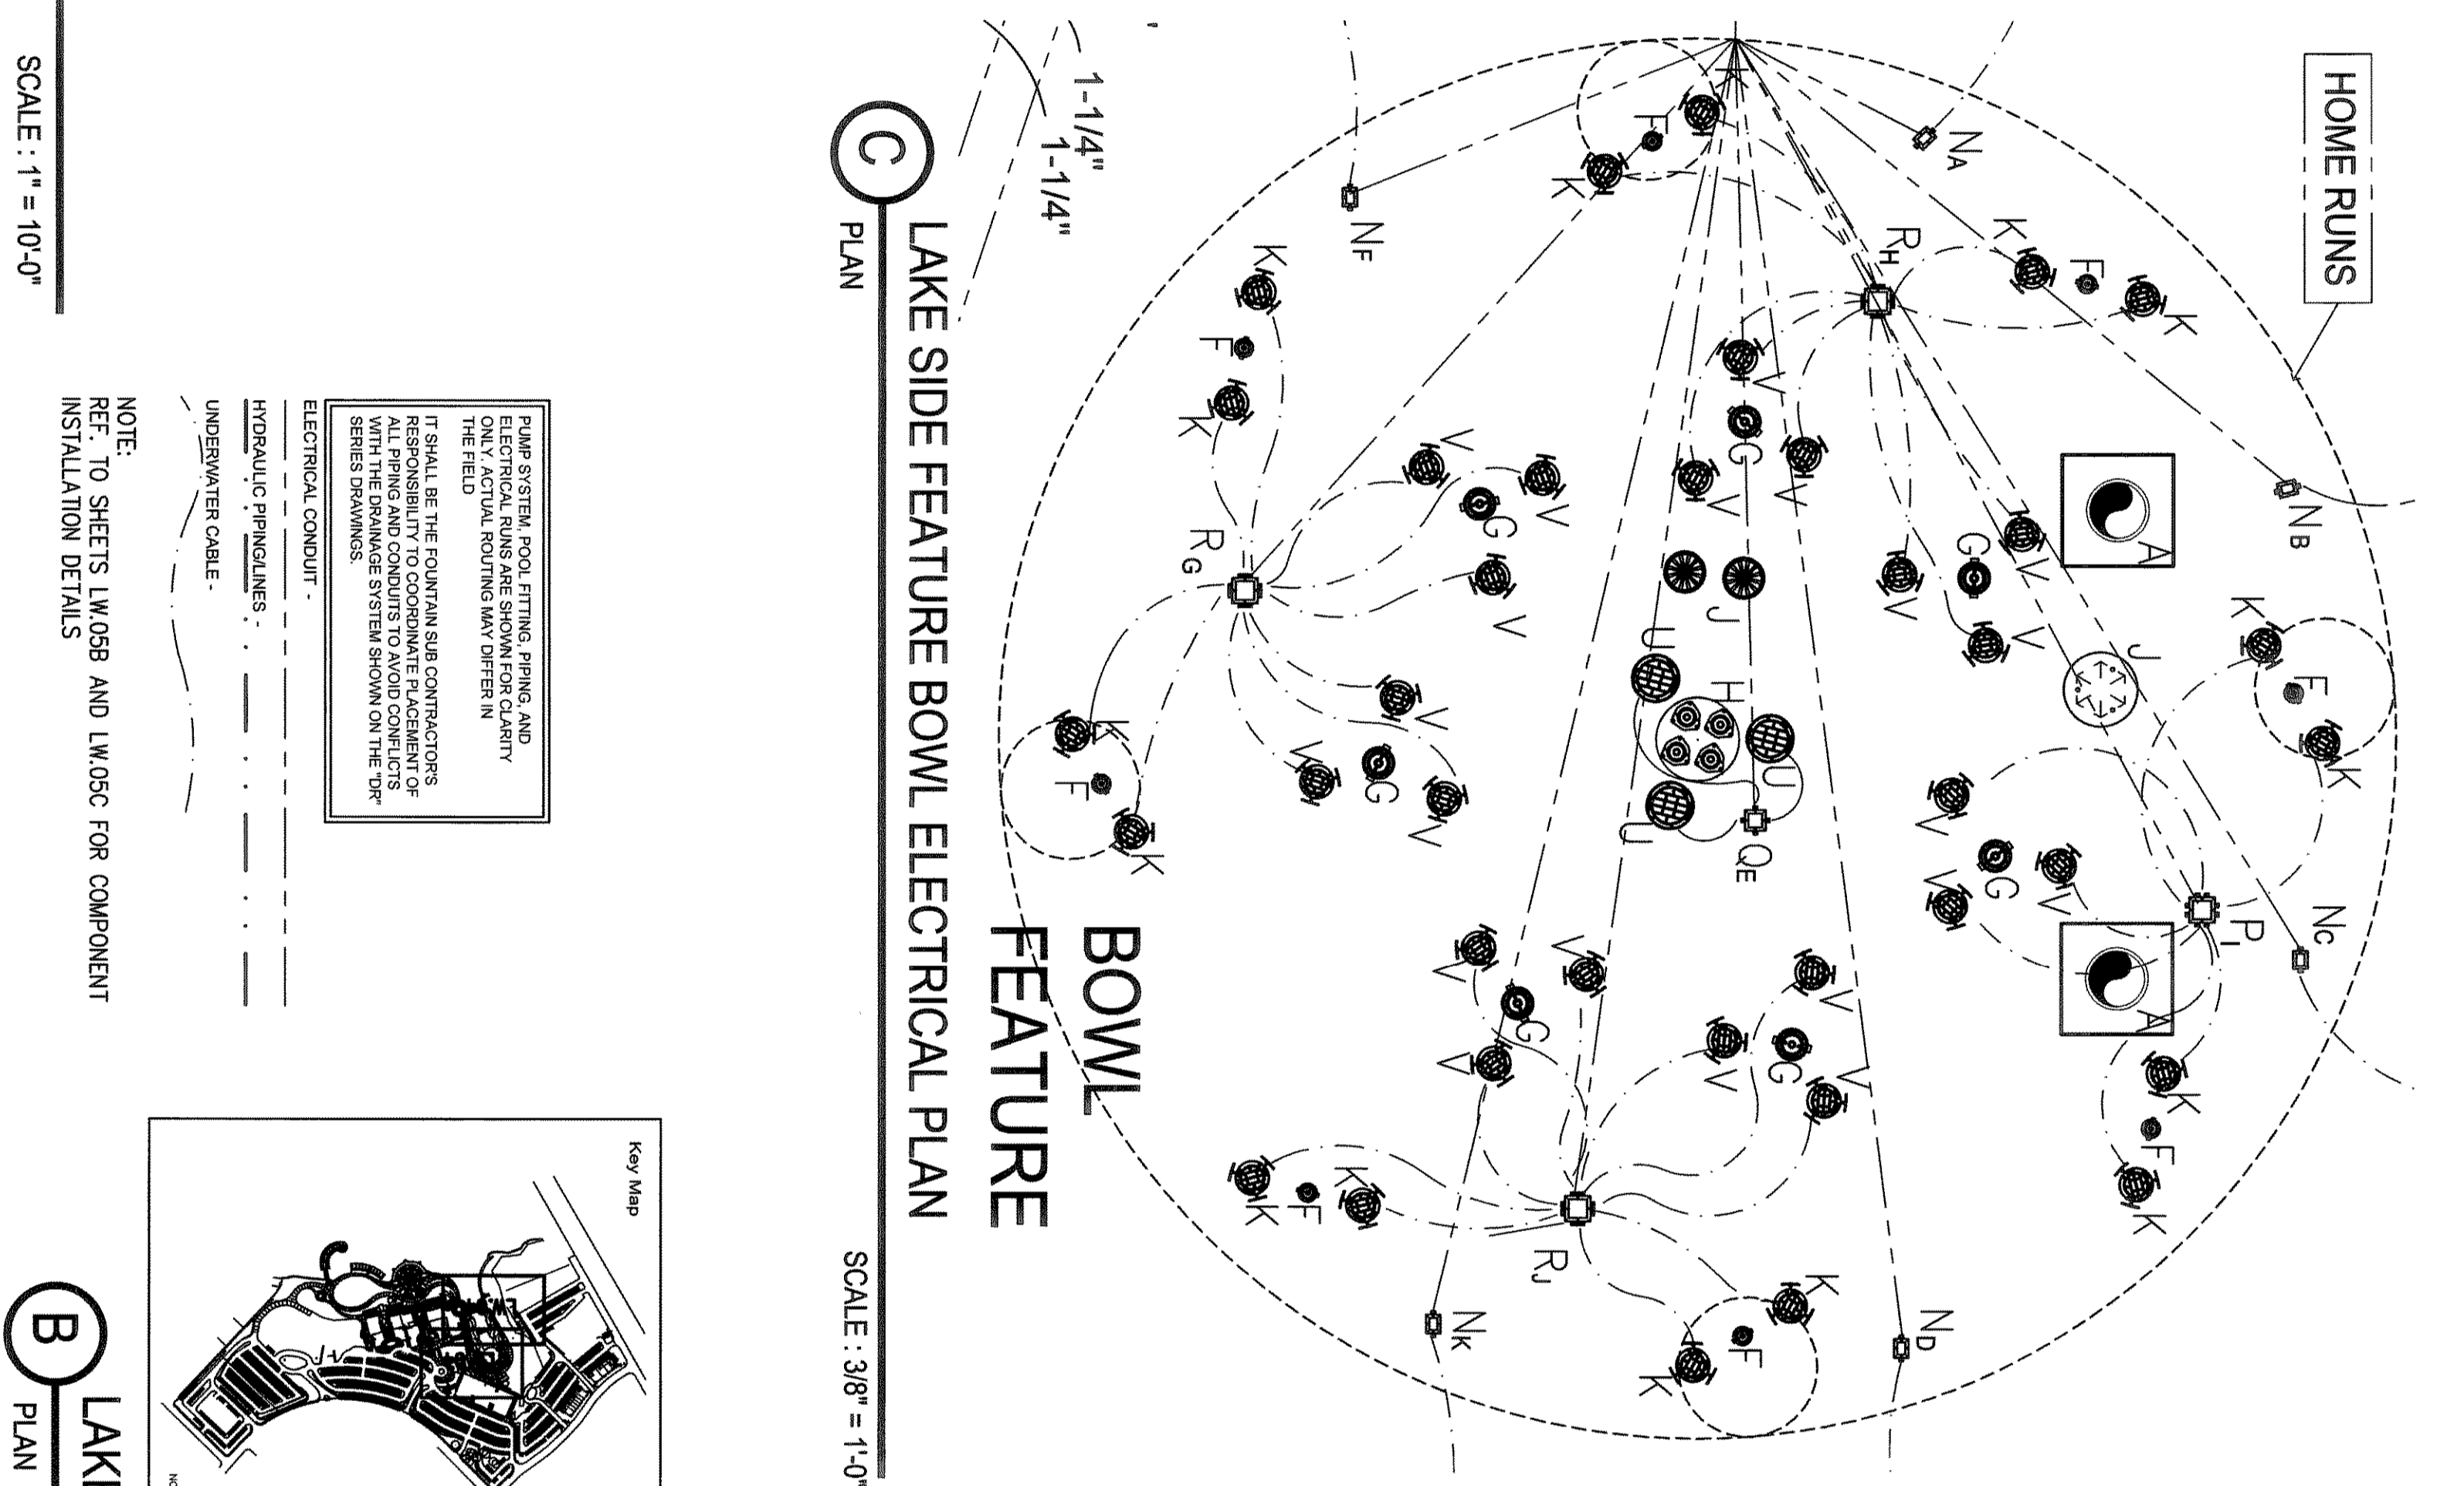


JUNCTION BOXES (IN PLANTER)
(24"X24"X8")

ITEM	ITEM DESCRIPTION	QUANTITY
A	1/2" SCH. 80 PVC W/ 1/2" WATERSTOP PENETRATION AND 24"X24" BRISER PLATE	2
B	650000 SECTION DRAIN	2
C	650000 POOL DRAIN FITTING	14
D	650000 THERMATED NUT FITTING WITH ELBOW	14
E	650000 ALUMINUM WOODIE - BRASS WOODIE	8
F	650000 CASCADE WOODIES WITH SHIMS AND DISK AND DISK NUT FITTING	8
G	650000 CASCADE WOODIES WITH SHIMS AND DISK NUT FITTING	7
H	650000 CENTER PAD OR WOODIE SECTION 423 PINE DISK NUT FITTING	1
J	650000 WIND STOPPING HELD/DRIVE CRANK FITTINGS	2
K	650000 UNDERWATER LIGHT FIXTURE AT 250 WATTS 120V	88
L	650000 UNDERWATER LIGHT FIXTURE AT 500 WATTS 120V	18
M	650000 JUNCTION BOX WITH ERRORS STUB UP AND 2 ESS902 COB2 SEALS	6
N	650000 JUNCTION BOX WITH ERRORS STUB UP AND 1 ESS902 COB2 SEAL	2
P	650000 JUNCTION BOX WITH ERRORS STUB UP AND ESS902 COB2 SEALS	2
Q	650000 JUNCTION BOX WITH ERRORS STUB UP AND ESS902 COB2 SEALS	14
R	650000 JUNCTION BOX WITH ERRORS STUB UP AND ESS902 COB2 SEALS	5
S	650000 JUNCTION BOX WITH ERRORS STUB UP TRIPLE ES100 LEVEL SENSORS	1
T	WERN SWIMMERS IN SWIMMER TROUSERS	15
U	650000 UNDERWATER LIGHT FIXTURE AT 1000 WATTS 120V	3
V	650000 UNDERWATER LIGHT FIXTURE AT 500 WATTS 120V	21
W	AMS-150 FRONT ACCESS SWIMMER	5
X	650000 FILTER SECTION DRAIN	2
Y	6" POOL DRAIN GATE VALVE W/ LOCKABLE VALVE BOX	2
Z	CAST IN PLACE EQUIPMENT VAULT	1
A1	WATER DISTRIBUTION VALVE VAULT	1
A2	IMPERMEABLE PUMP SLUMP - REF. STRUCTURAL PLANS	1

- NOTE:
- 1) PIPING AND ELECTRICAL LAYOUTS ARE DIAGRAMMATIC ONLY. FOUNTAIN SUB CONTRACTOR TO COORDINATE WITH CIVIL AND UTILITIES FOR MOST EFFICIENT ROUTE CONTAINING AS FEW ELBOWS AND DIRECTIONAL CHANGES AS POSSIBLE.
 - 2) REFERENCE PIPE RUN, RISER DIAGRAM SHEET LW.05 FOR ALL PIPE SIZES. INSTALL REDUCERS IN VAULT AND BASINS AS CLOSE AS POSSIBLE TO ALL EQUIPMENT AND FITTINGS.
 - 3) REFERENCE ELECTRICAL PLANS FOR SPECIFICATIONS AND LOCATIONS OF ELECTRICAL PULL BOXES.

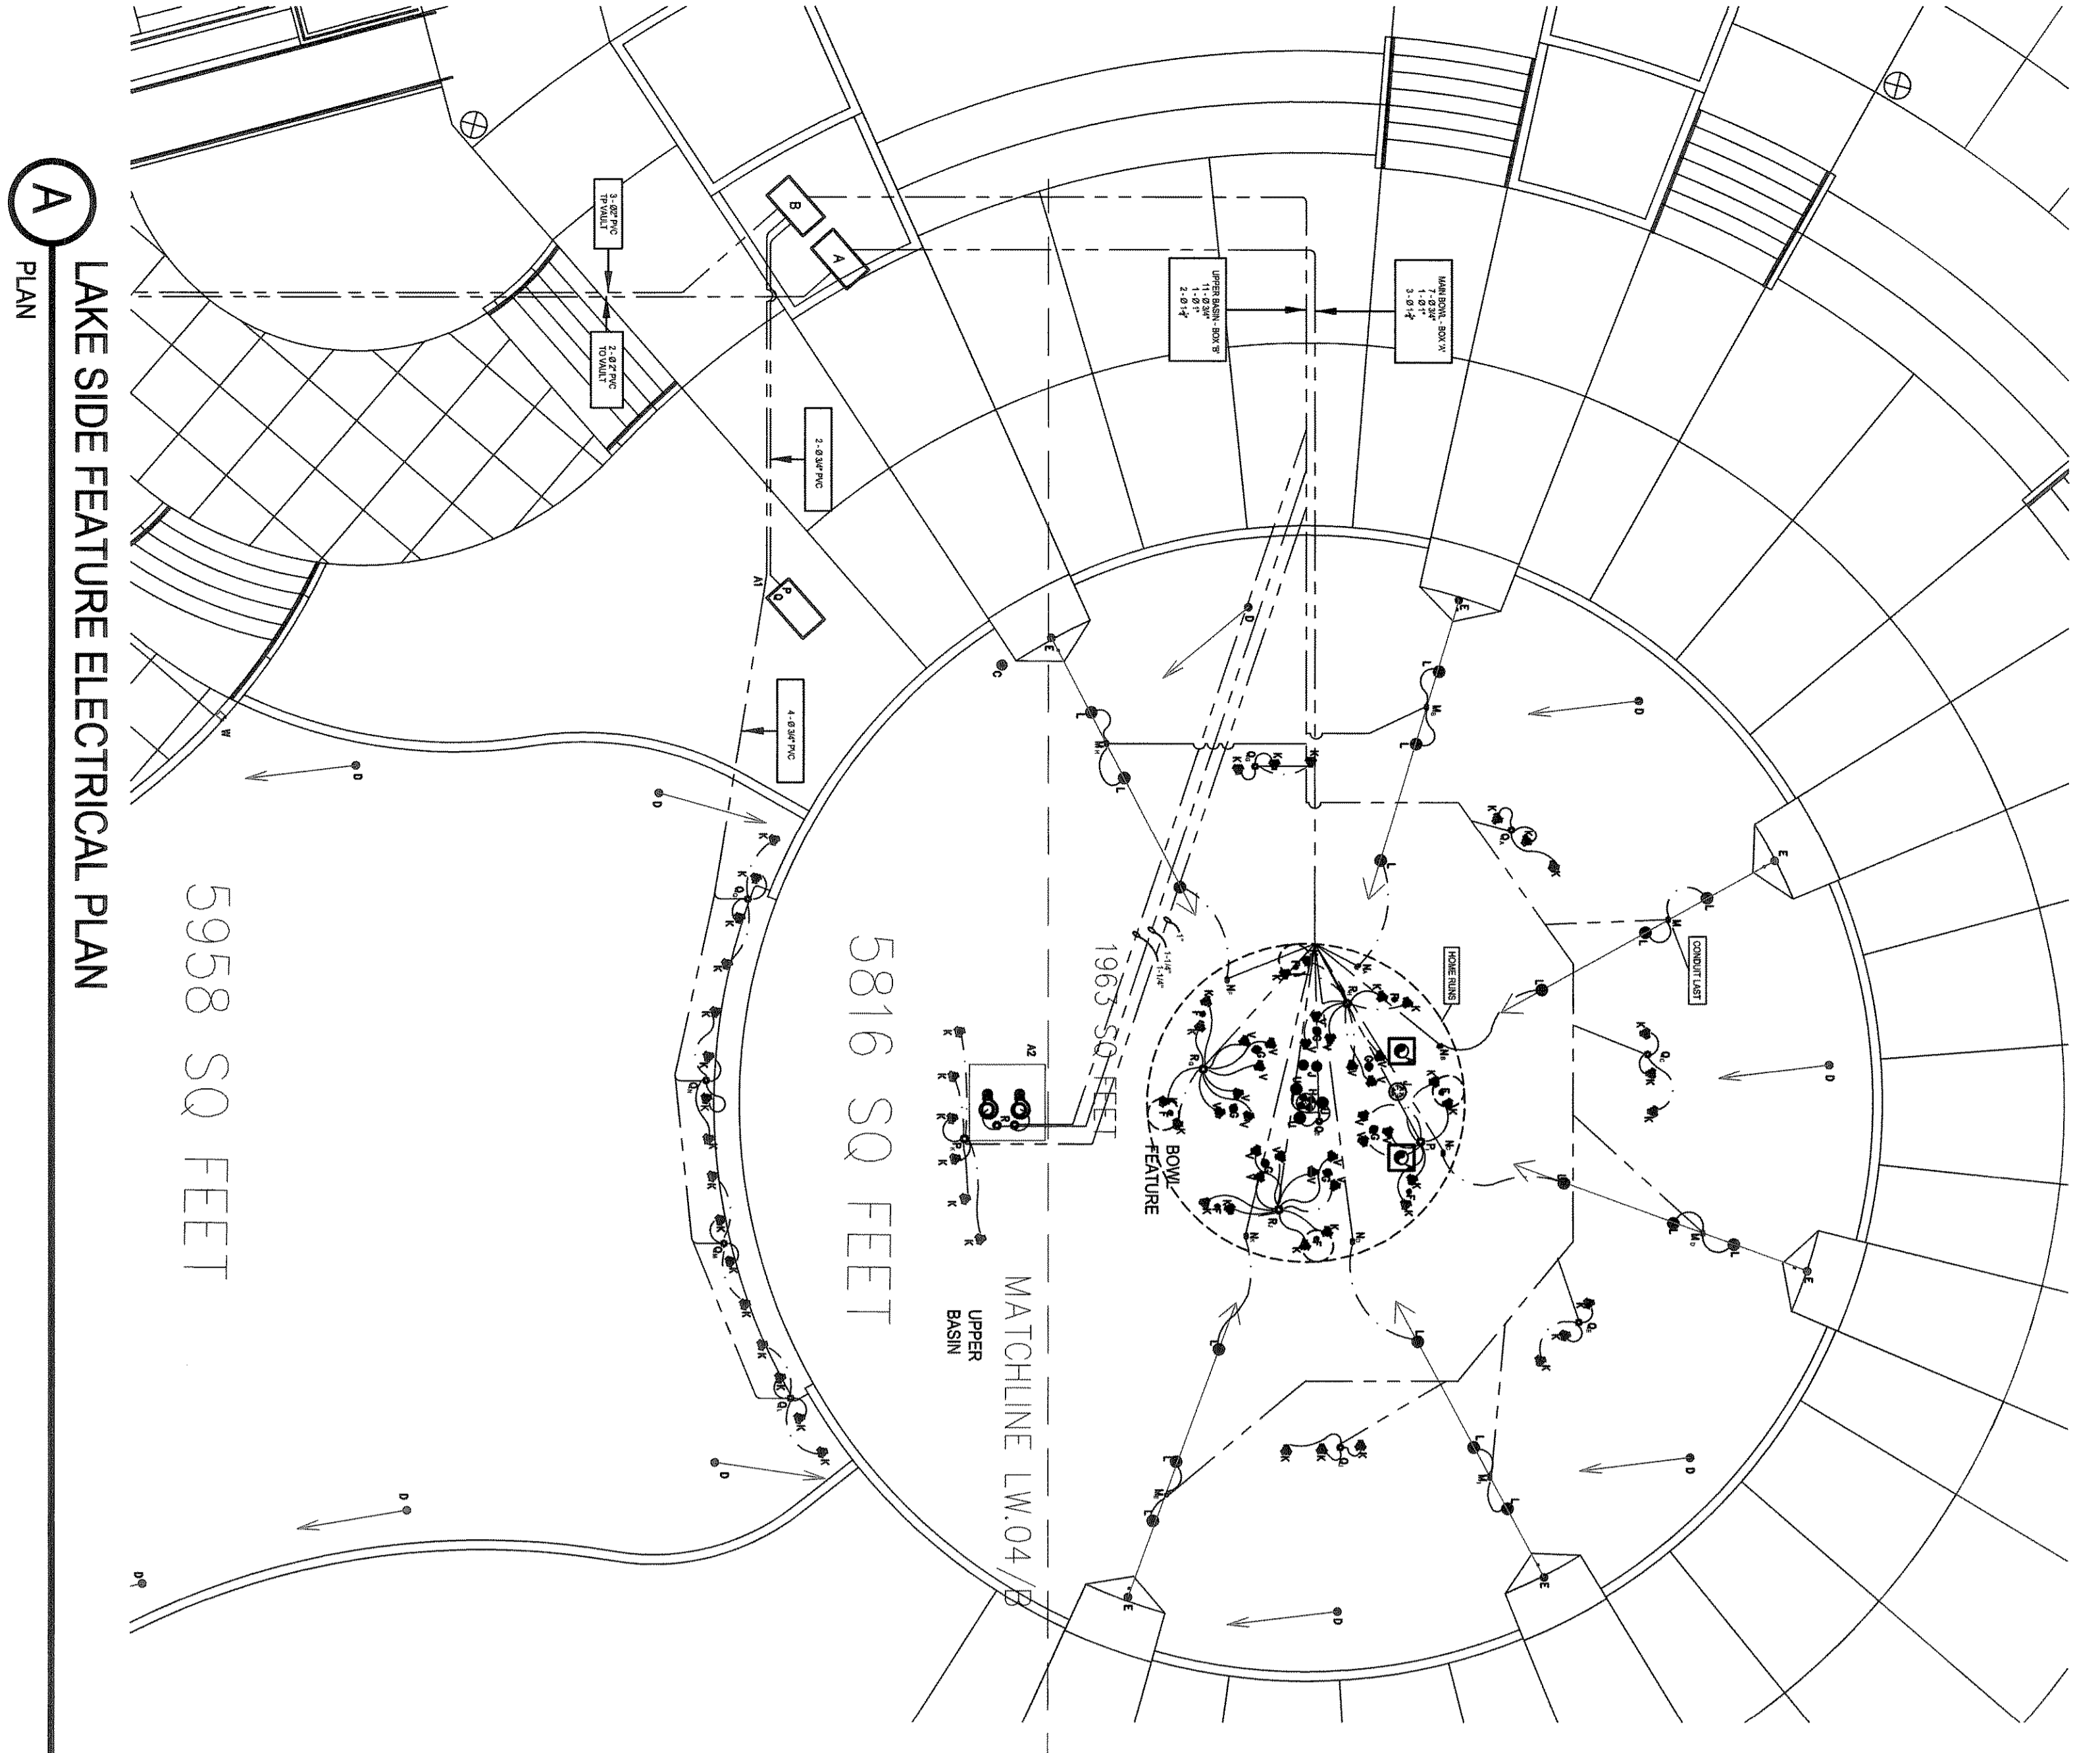


SCALE: 1" = 10'-0"

SCALE: 3/8" = 1'-0"

SCALE: 1" = 10'-0"

PIPE SYSTEM POOL FITTING, PIPING, AND VALVE SCHEDULES SHALL BE AS SHOWN ON THE SHEET UNLESS OTHERWISE NOTED. REFER TO THE COMMON SCHEDULES FOR ALL PIPING AND COMPONENTS TO AVOID CONFLICTS. REFER TO THE COMMON SCHEDULES FOR ALL ELECTRICAL COMPONENTS AND FITTINGS. REFER TO THE COMMON SCHEDULES FOR ALL ELECTRICAL COMPONENTS AND FITTINGS.

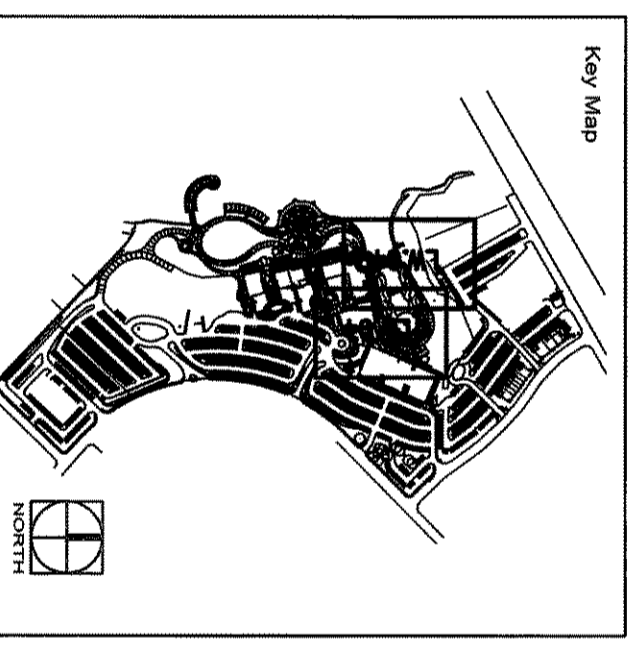

T B G

PARTNERS

Landscape Architects • Planners

302 North Market, Suite 450
Dallas, Texas 75202
214/744-0757 Fax: 214/744-8178
Austin • Dallas • Houston • McAllen

THE HARBOR
ROCKWALL, TEXAS

Greenleaf
Pump Services, Inc.

• SALES • SERVICE •
• DESIGN • CONSULTING • CONTRACTING •

Headquarters
1425 Windsor, Suite 108
Dallas, Texas 75206
Ph: 972-486-0057 Fax: 972-486-0313

REGISTRATION

NO. ISSUED/REVISIONS	DATE
1 AS BUILT	07/17/2005
2 AS BUILT	07/17/2005

SHEET TITLE
LAKE SIDE ELECTRICAL PLAN

JOB NO. 4930
DATE 12/2005
DRAWN BY GOR
CHECKED BY: [Signature]
FILE: 4930-THE HARBOR-AS-BUILT-11
SHEET NUMBER

LW.04