

**THE HARBOR
ROCKWALL, TEXAS**


RESTORATION

NO.	ISSUE/REVISIONS	DATE
1	AS SHOWN	07/12
2	AS SHOWN	11/26


SHEET TITLE
**PLAZA
SUCTION PIPE
PLAN**

JOB NO. 4930
DATE 12, 2005
DRAWN BY: GJR
CHECKED BY:
FILE: 4930_THEHARBOR_A-BUILD_110
SHEET NUMBER

LW.07

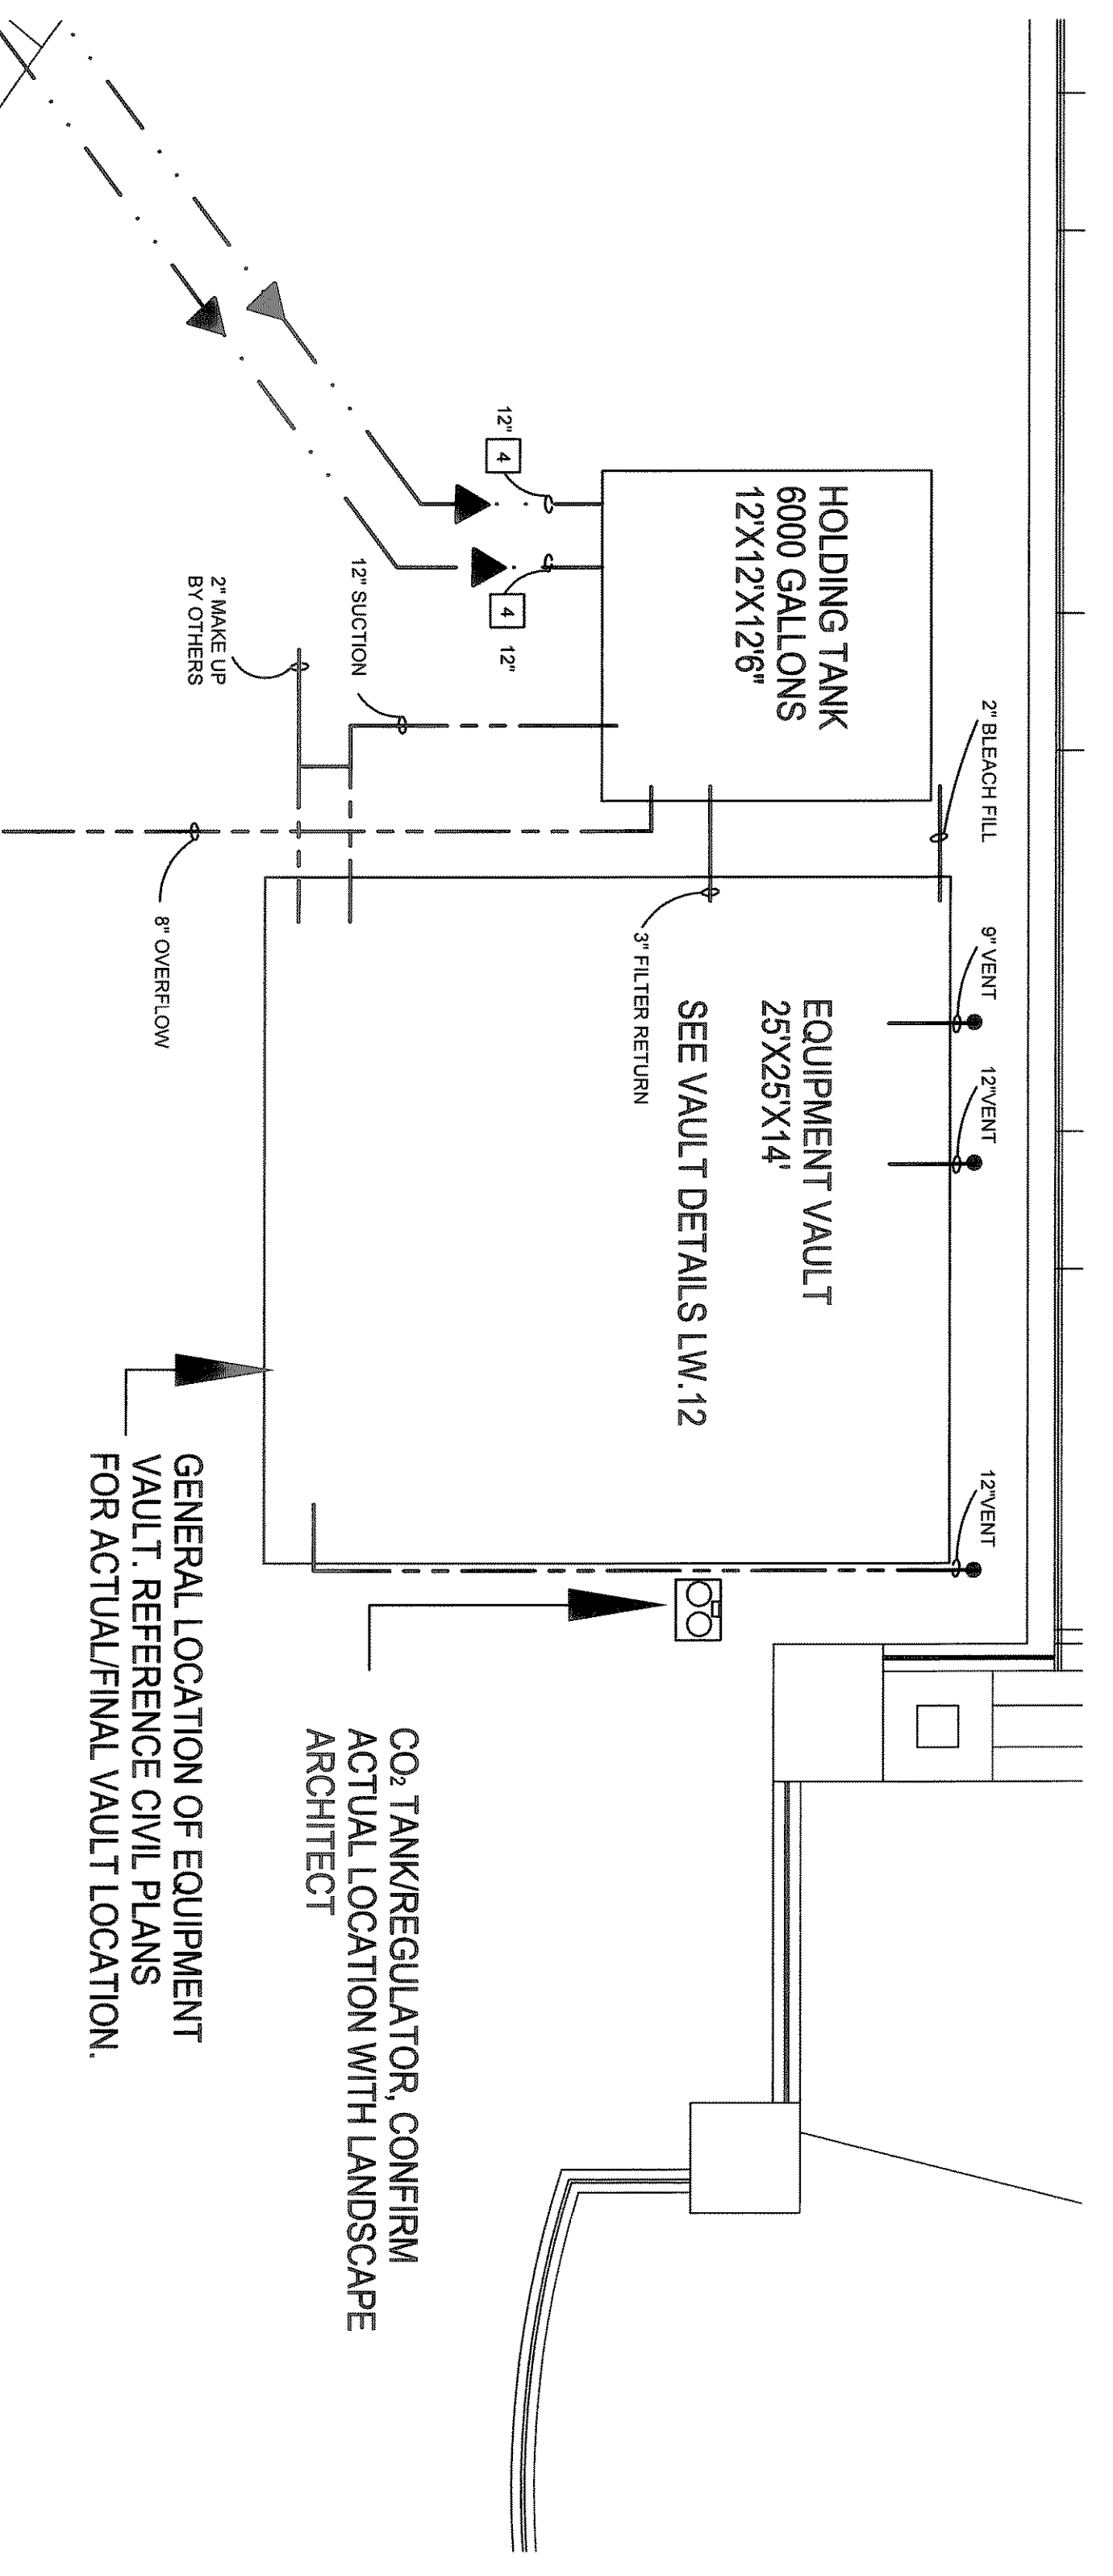

B PLAZA FEATURE SUCTION PIPING PLAN
SCALE: 3/8" = 1'-0"

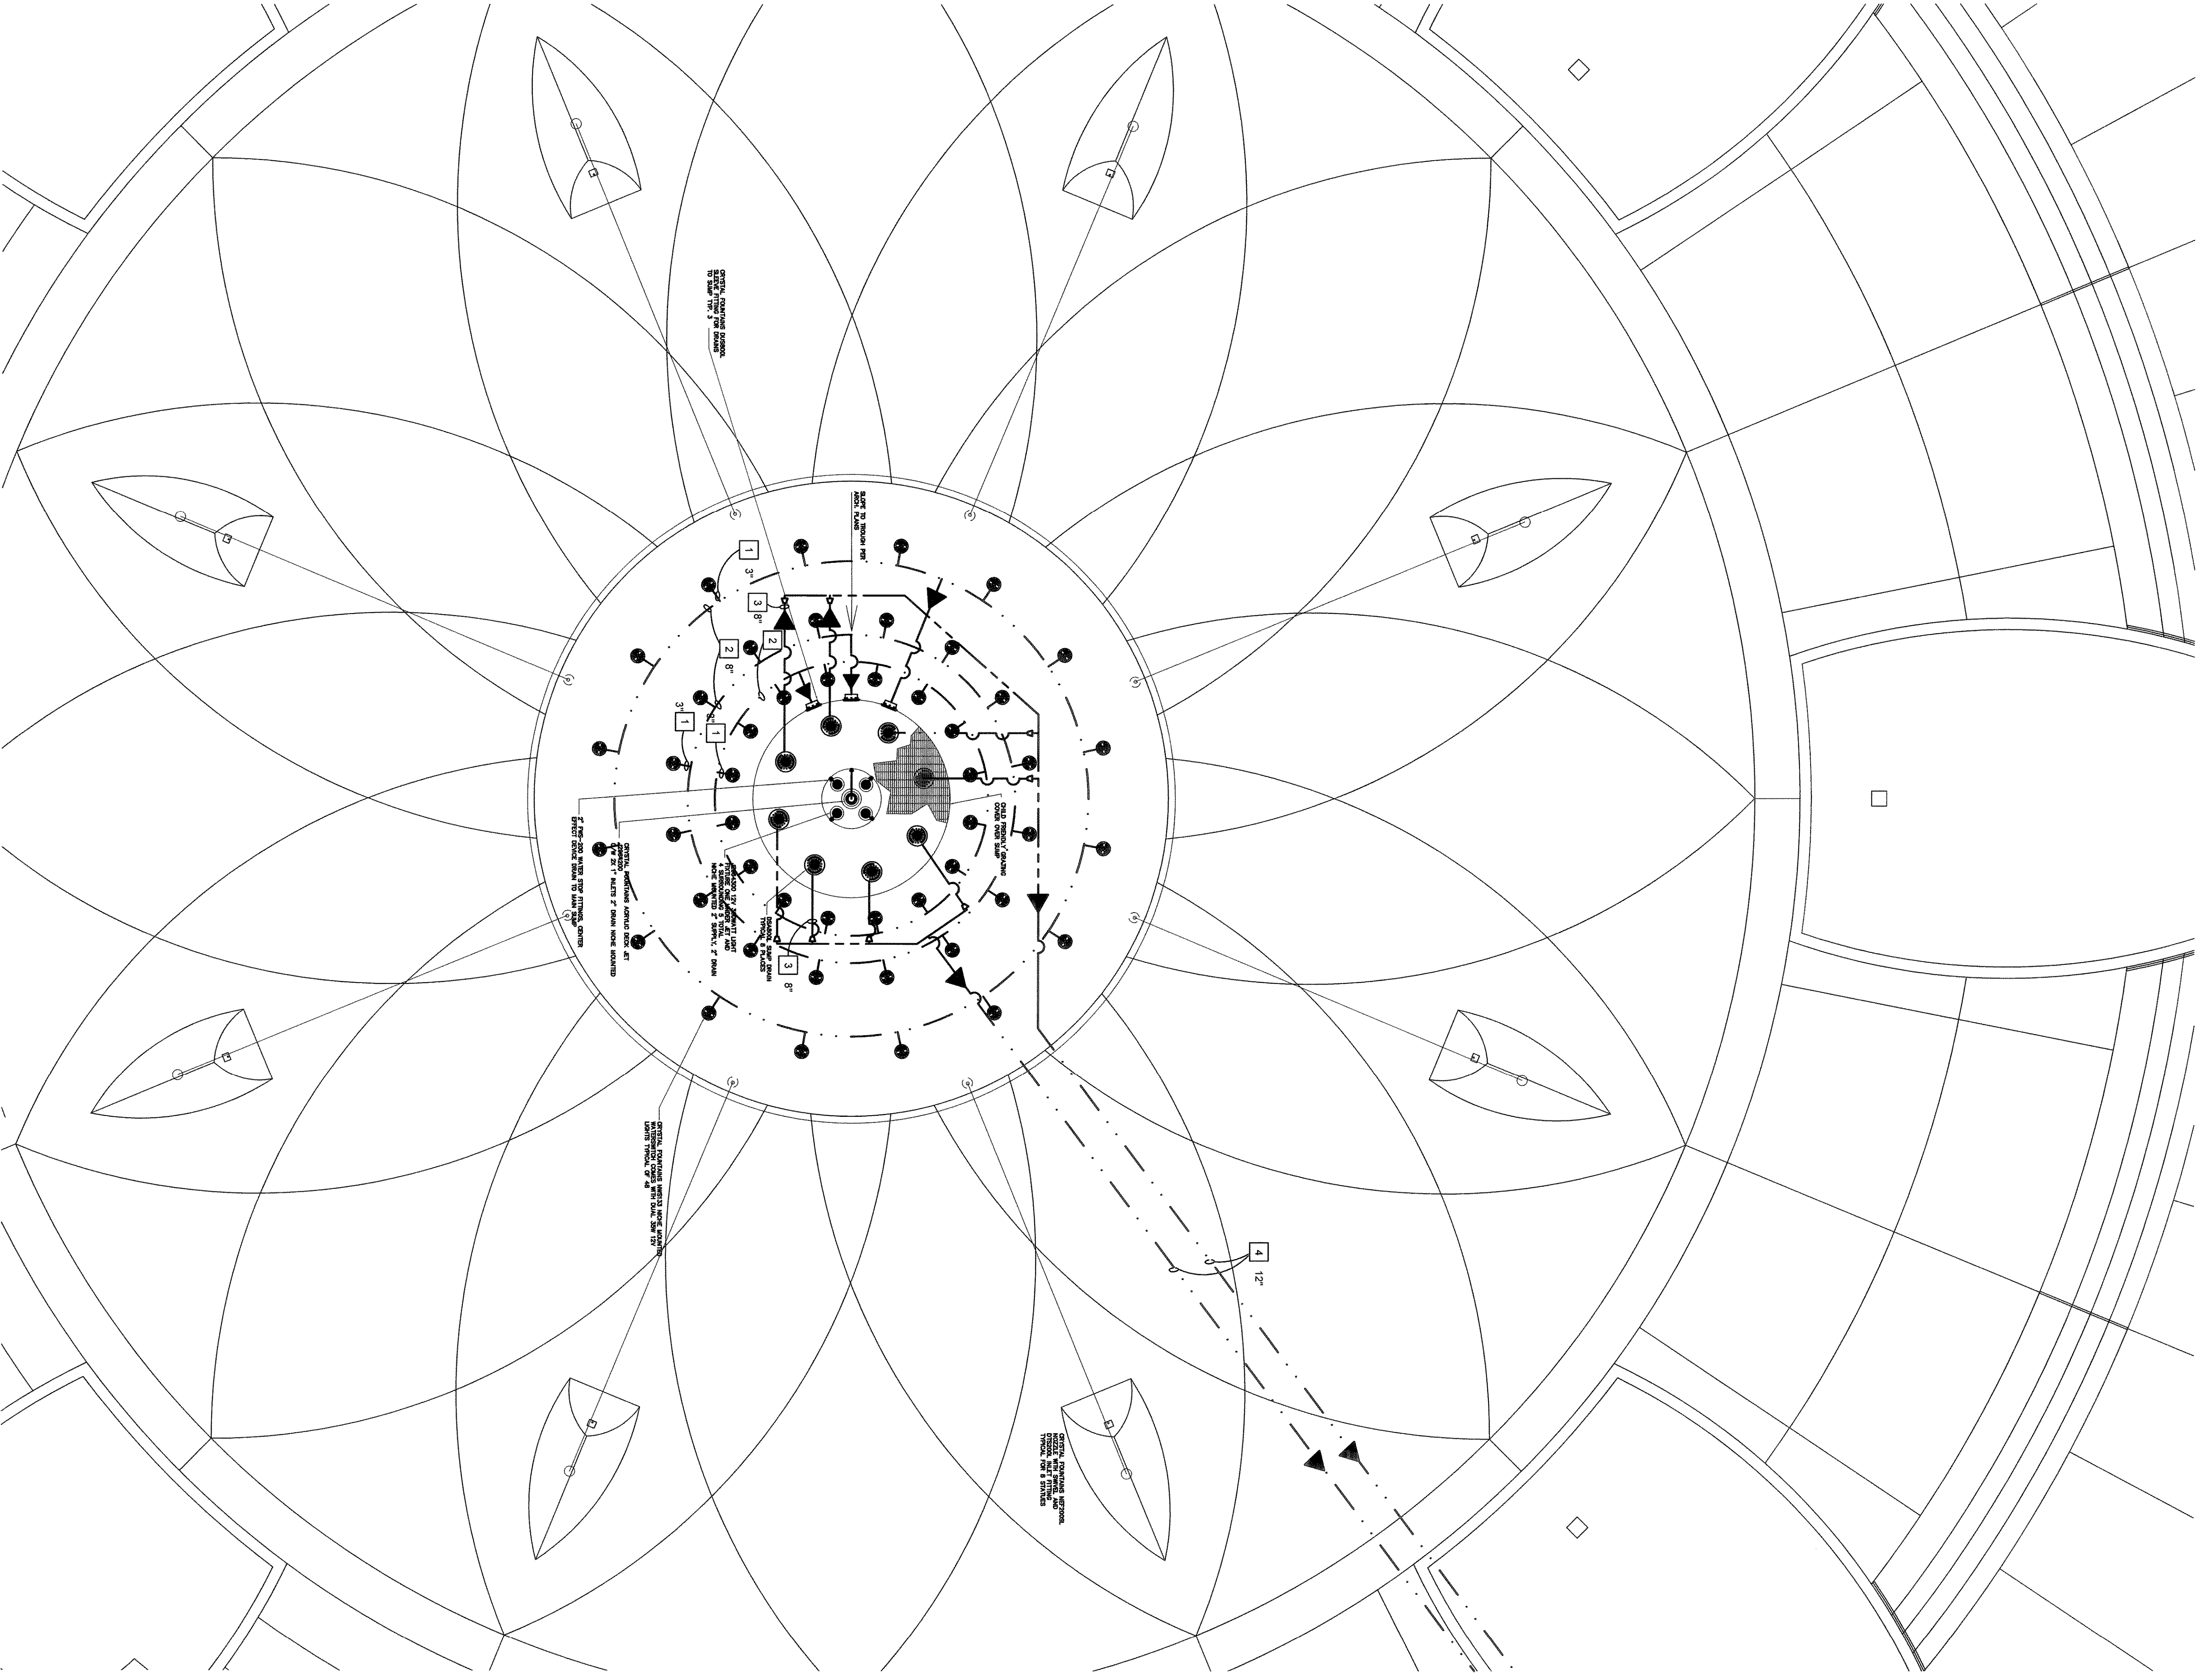

A PLAZA FEATURE SUCTION PIPING PLAN
SCALE: 3/8" = 1'-0"

SYSTEM FEATURE SUCTION PIPING LEGEND

SYM	SIZE	DESCRIPTION	REMARK
1	12"	SCH. 40 PVC WATER/SWITCH/DRAIN TO MAIN CLEAN LINE (TYPE FALL WATER)	40
2	8"	SCH. 40 PVC MAIN DRAIN TO COLLECTION	3
3	6"	SCH. 40 PVC COLLECTION SUMP TO DRAIN TO MAIN DRAIN LINE TO HOLDING	8
4	4"	SCH. 40 PVC MAIN DRAIN LINES TO HOLDING TANK	2

NOTE: RESERVE ALL PIPE SPACES AND MARK TO DENOTE OR PREVENTIONS AS POSSIBLE.

PLAZA FEATURE SUCTION PIPING, AND THE FIELD. THE CONTRACTOR SHALL BE RESPONSIBLE TO CONSULT WITH THE DESIGNER WITH THE DRAINAGE SYSTEM SHOWN ON THE SITE VISITS.

ELECTRICAL CONDUIT
UNDERPUMPING CABLE

REF. SHEET LW.11B FOR COMPONENT INSTALLATION DETAILS

