

**THE HARBOR
 ROCKWALL, TEXAS**

REGISTRATION

| No. | ISSUE/REVISIONS | DATE |
|-----|-------------------------|---------|
| 1 | POST-BID ADDENDUM Q1/Q2 | 11/7/05 |
| 2 | AS BUILT | 11/7/05 |

SHEET TITLE
**PLAZA
 SUCTION PIPE
 PLAN**

JOB NO. 4930
 DATE: JULY 12, 2005
 DRAWN BY: GDR
 CHECKED BY: JLB
 FILE: 49302-PLAZA SUCTION PIPE PLAN
 SHEET NUMBER

LW.07B

WATER FEATURE SUCTION PIPING LEGEND


| SYM | SIZE | DESCRIPTION | #REQD |
|-----|------|--|-------|
| 1 | 3" | SCH 80 PVC WATERSWITCH DRAIN TO MAIN SUMP LINE (TYP. ALL WATER SWITCHES) | 48 |
| 2 | 8" | SCH. 80 PVC MAIN DRAIN TO COLLECTION SUMP | 3 |
| 3 | 8" | SCH. 80 PVC COLLECTION SUMP TO DRAIN TO MAIN DRAIN LINE TO HOLDING TANK | 8 |
| 4 | 12" | SCH. 80 PVC MAIN DRAIN LINES TO HOLDING TANK | 2 |

NOTE: REDUCE ALL PIPE SIZES AS NEAR TO DEVICE OR PENETRATIONS AS POSSIBLE.

PLUMB SYSTEM BOULDER FITTING PIPING AND ONLY ACTUAL ROUTING MAY DIFFER IN THE FIELD
 IT SHALL BE THE FOUNTAIN SUB CONTRACTORS RESPONSIBILITY TO COORDINATE PLACEMENT OF THE DRAINAGE SYSTEM SHOWN ON THE DRAWINGS WITH THE DRAINAGE SYSTEM SHOWN ON THE DRAWINGS.

ELECTRICAL CONDUIT -
 HYDRAULIC PIPING LINES -
 UNDERWATER CABLE -

REF. SHEET LW.11B FOR COMPONENT INSTALLATION DETAILS

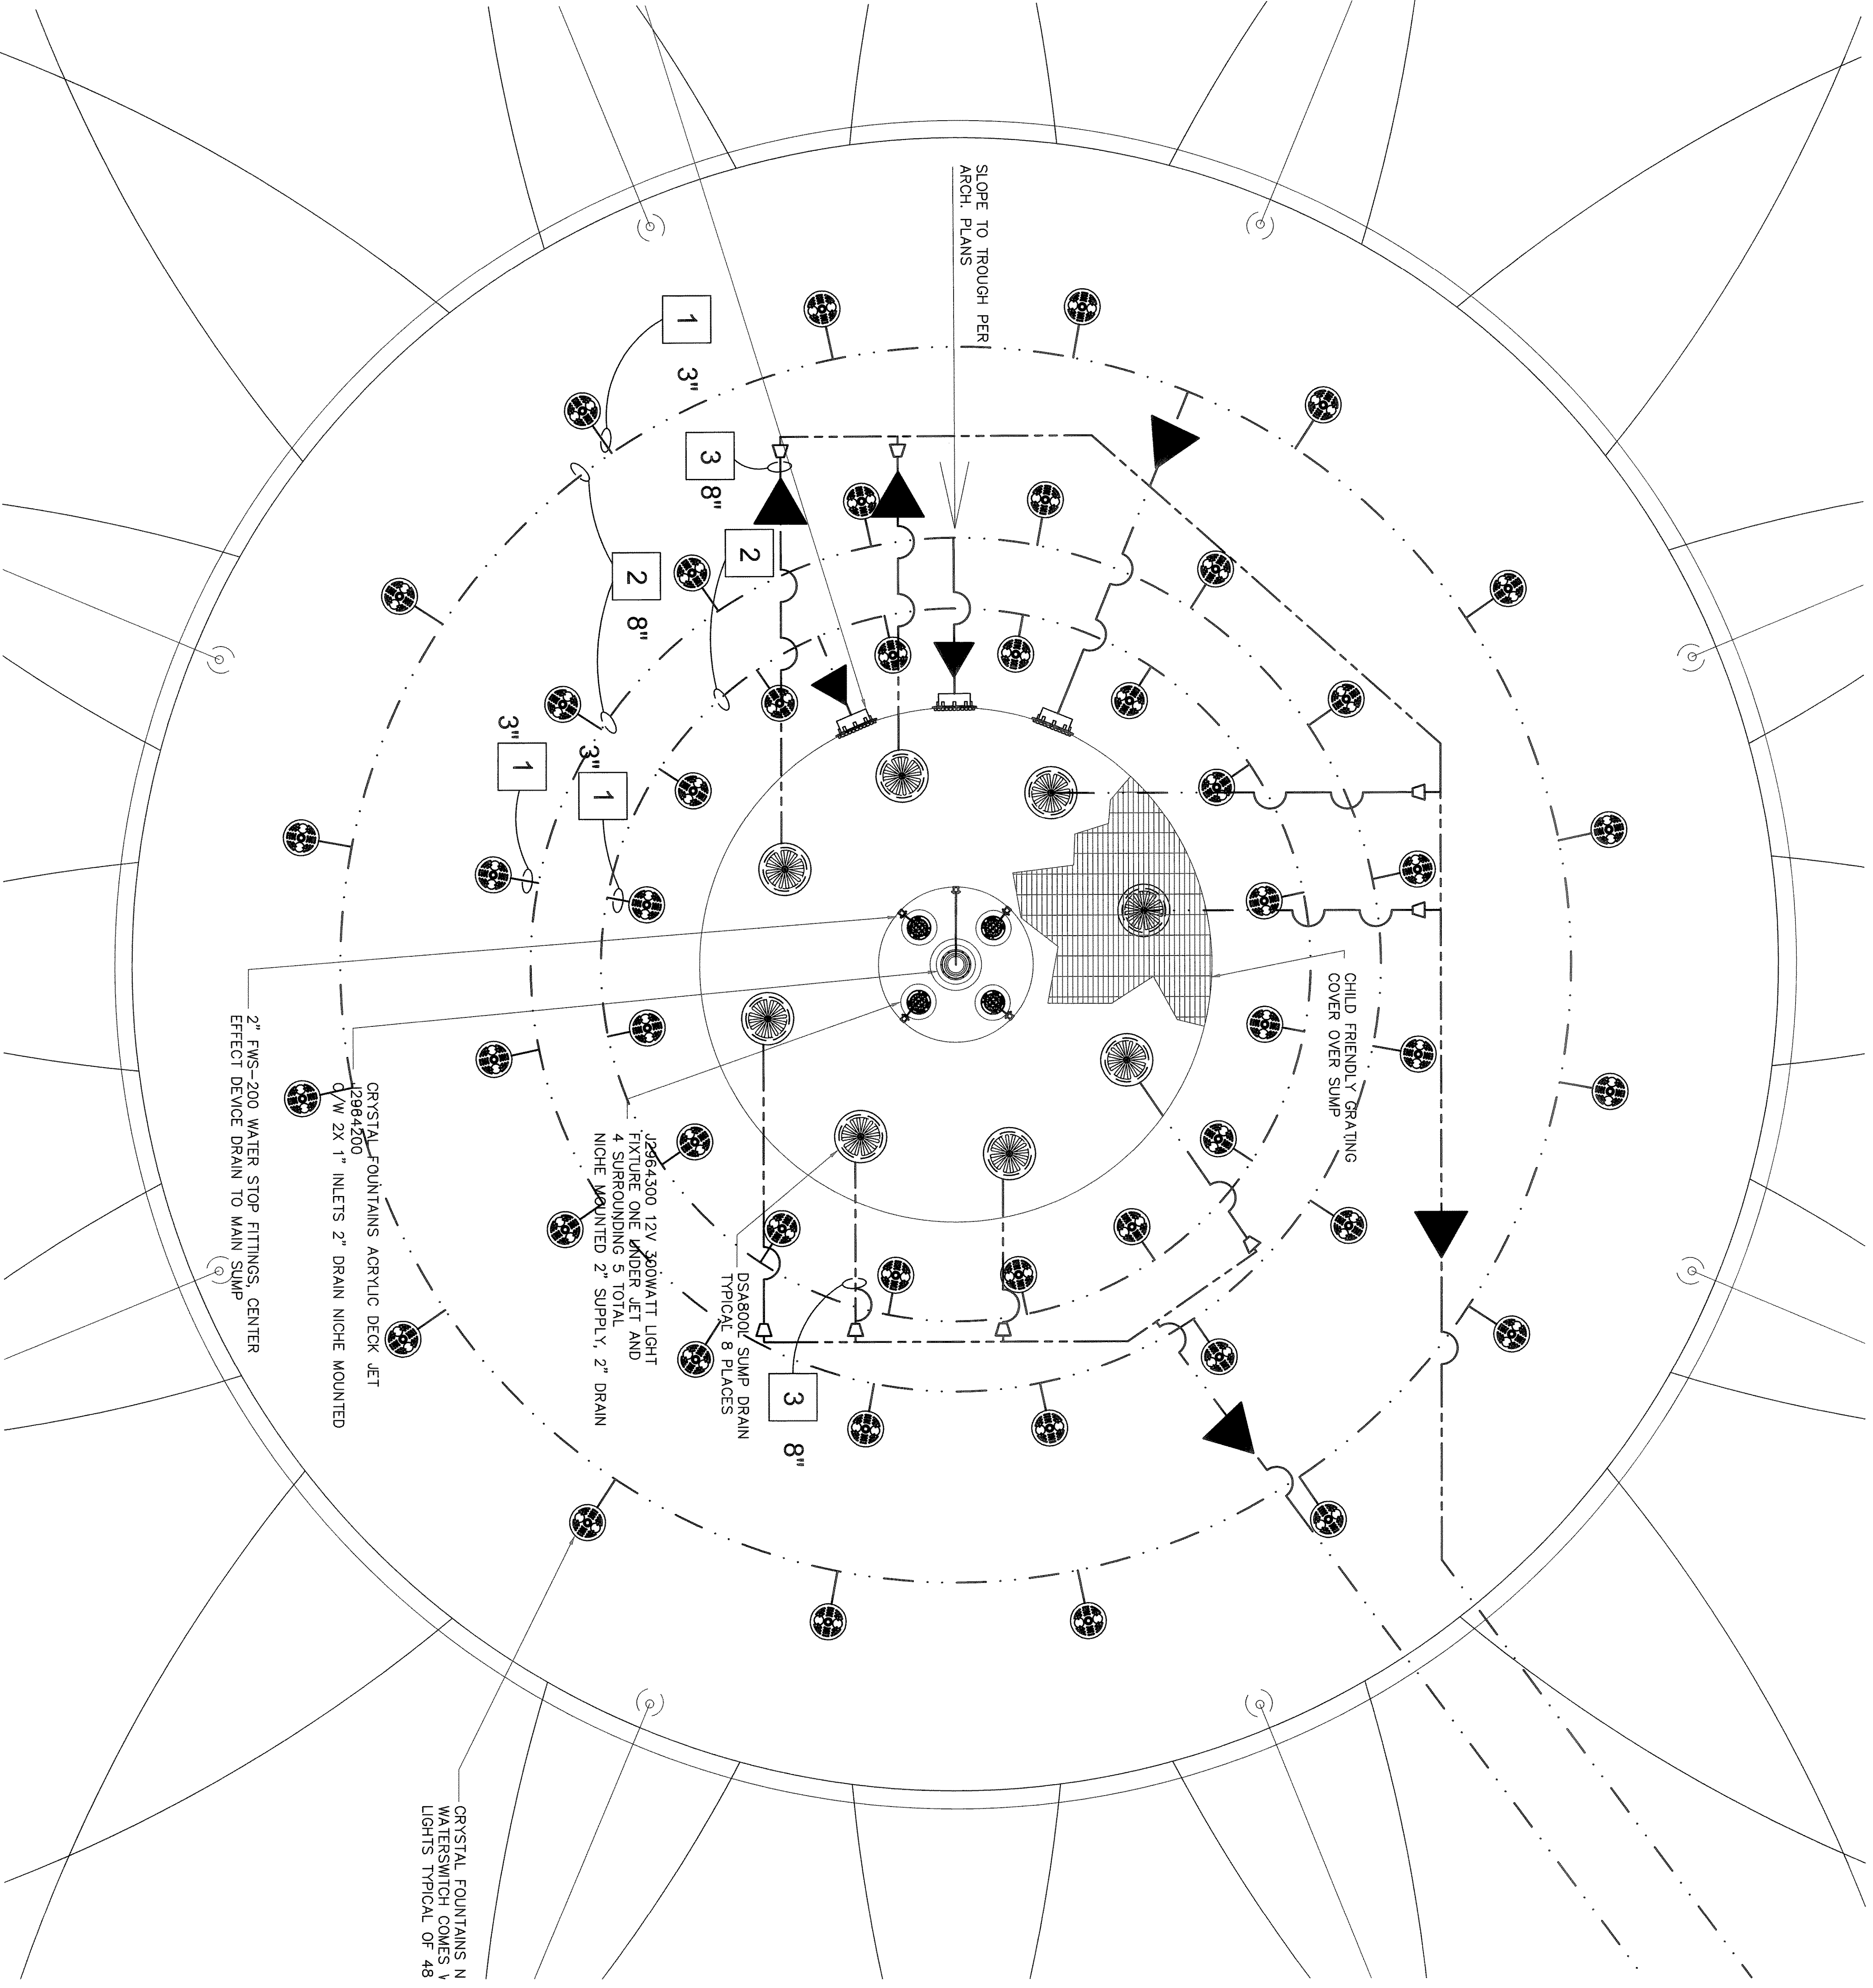

C ENLARGED PLAZA FEATER SUCTION PIPING PLAN
 SCALE: 1/2" = 1'-0"

