

MATCH LINE STA. 108+00

MATCH LINE STA. 117+00

STA 108+61.50, 49.61' LEFT  
BASELINE TRP NO. 13  
SET 5/8" IRON ROD WITH CAP  
N = 702232.7700  
E = 2607741.3900  
ELEV = 594.57

!!! CAUTION !!!  
UNDERGROUND TELEPHONE  
LINE IN PROJECT AREA

P.I. STA. 113+38.43  
Δ = 0.52° LT.  
N. = 7021754.7952  
E. = 2607703.1278

STA. 110+00  
FURNISH & INSTALL  
1- FIRE HYDRANT

STA. 113+00  
FURNISH & INSTALL  
1- FIRE HYDRANT

STA. 117+00  
FURNISH & INSTALL  
1- 12" GATE VALVE


STA. 111+65  
FURNISH & INSTALL  
1- 2" COMBINATION AIR &  
VACUUM RELEASE VALVE

STA. 112+50  
FURNISH & INSTALL  
1- 12" MJ X 12" FLG TEE  
1- 12" FLG X MJ GATE VALVE  
1- 12" PLUG  
20- LF 12" WL  
FOR REDC

STA. 116+00  
FURNISH & INSTALL  
1- FIRE HYDRANT



PROPOSED 12" WATER LINE

**RECORD DRAWING**  
VERIFIED BY *[Signature]*  
DATE 11-27-01

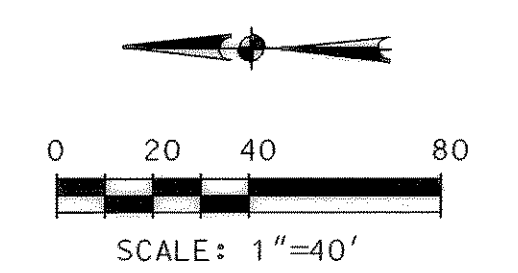

LEGEND	
[Symbol]	POWER POLE
[Symbol]	GUY WIRE
[Symbol]	TELEPHONE BOX
[Symbol]	POST
[Symbol]	SIGN
[Symbol]	IRON ROD
[Symbol]	FIRE HYDRANT
[Symbol]	WATER METER
[Symbol]	MAILBOX
[Symbol]	WATER METER
[Symbol]	IRRIGATION CONTROL VALVE
[Symbol]	GUARD RAIL
[Symbol]	GAS METER
[Symbol]	GROUND LIGHT
[Symbol]	CHAIN LINK FENCE
[Symbol]	WOOD FENCE
[Symbol]	ASH TREE
[Symbol]	OAK TREE
[Symbol]	CEDAR TREE
[Symbol]	BARBED WIRE FENCE
[Symbol]	REFLECTOR
[Symbol]	APPROXIMATE TELEPHONE LINE
[Symbol]	APPROXIMATE GAS LINE
[Symbol]	APPROXIMATE WATER LINE
[Symbol]	OVERHEAD POWER LINE
[Symbol]	PINE TREE
[Symbol]	PECAN TREE

**UNDERGROUND UTILITIES**  
THE LOCATION OF EXISTING UTILITIES SHOWN ON THESE PLANS ARE APPROXIMATE AND BASED ON DATA FURNISHED BY UTILITY COMPANIES. IT IS THE RESPONSIBILITY OF THE CONTRACTOR TO LOCATE AND VERIFY ON-SITE THE UTILITIES THAT MAY CONFLICT WITH THE CONSTRUCTION.

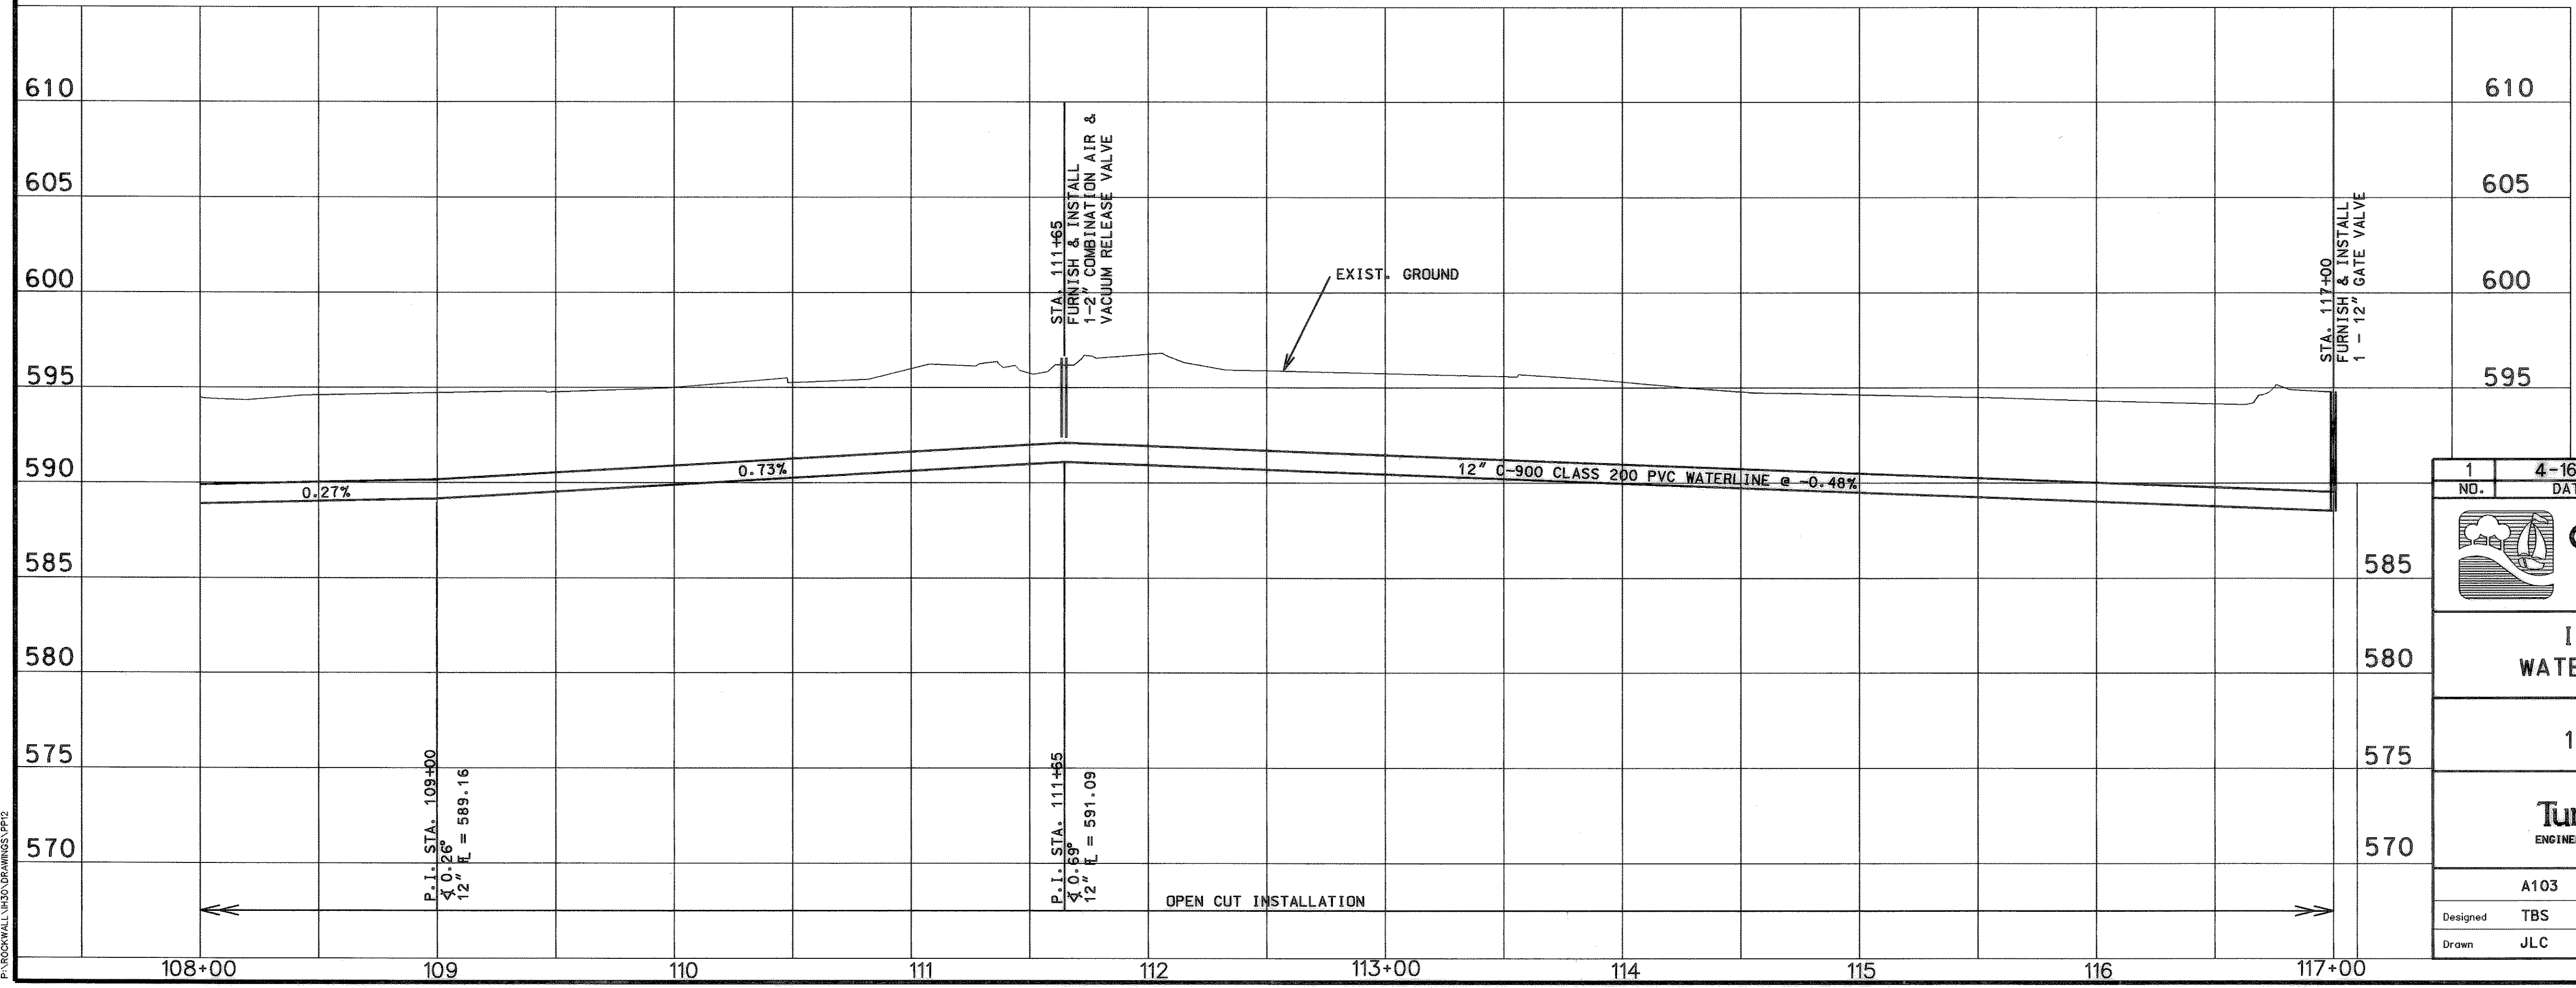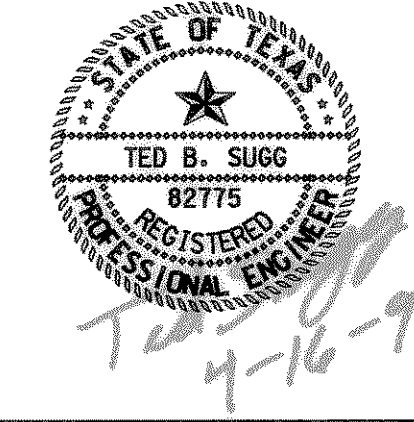

1	4-16-99	REALIGNMENT	TBS
NO.	DATE	REVISION	APPROV
<b>CITY OF ROCKWALL</b> "THE NEW HORIZON"			
I.H. 30 AND FM 549 WATER LINE IMPROVEMENTS			
UTILITY PLAN AND PROFILE 12" PVC WATER LINE STA. 108+00 TO STA. 117+00			
<b>Turner Collie &amp; Braden Inc.</b> ENGINEERS • PLANNERS • PROJECT MANAGERS			
A103	Scale: Horz. 1"=40' Vert. 1"=5'	Date	FEBRUARY, 1999
Designed	TBS	Checked	DWN
Drawn	JLC	Approved	RCR
		Job No.	15-98925-200
		SHEET 15 OF 33	

P:\ROCKWALL\1509\DRAWINGS\15P2