

CAUTION
UNDERGROUND TELEPHONE LINE IN PROJECT AREA

SEE SHEET 31 FOR DETAIL

STA. 21+50, 5' RT
FURNISH & INSTALL
1 - 8" X 8" TAPPING SLEEVE & VALVE
ON EXIST. 8" WL
5 LF 8" WL CONNECT TO
NEW 12" WL

STA. 22+00
FURNISH & INSTALL
1 - FIRE HYDRANT

BORE PROPOSED 12" WATER LINE UNDER DRAINAGE STRUCTURE (NOT ENCASED)

TXDOT RIGHT-OF-WAY


STA. 20+00
FURNISH & INSTALL
1 - 12" GATE VALVE

STA. 19+00
FURNISH & INSTALL
1 - FIRE HYDRANT

STA. 24+20.29
FURNISH & INSTALL
1 - 12" PLUG
N = 7020338.7753
E = 2605291.4724


STA. 24+50
FURNISH & INSTALL
1 - 12" FLG X 8" FLG TEE
1 - 12" FLG X MJ GATE VALVE

STA. 23+16.64, 18+00' RIGHT
BASELINE TRP NO. 17
SET 3/4" IRON ROD WITH CAP
N = 7020328.3290
E = 2605447.2960
ELEV = 581.894

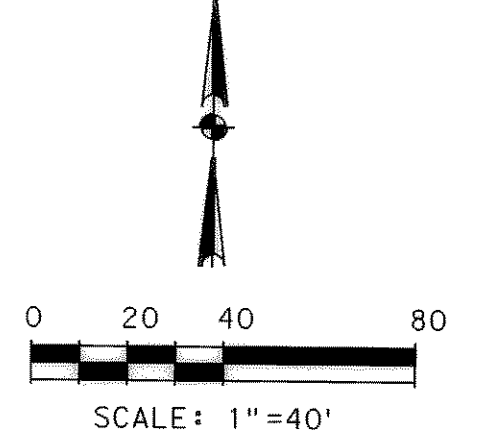


LEGEND	
[Symbol]	POWER POLE
[Symbol]	GUY WIRE
[Symbol]	TELEPHONE BOX
[Symbol]	POST
[Symbol]	SIGN
[Symbol]	IRON ROD
[Symbol]	FIRE HYDRANT
[Symbol]	WATER METER
[Symbol]	MALBOX
[Symbol]	WATER METER
[Symbol]	IRRIGATION CONTROL VALVE
[Symbol]	GUARD RAIL
[Symbol]	GAS METER
[Symbol]	GROUND LIGHT
[Symbol]	CHAIN LINK FENCE
[Symbol]	WOOD FENCE
[Symbol]	ASH TREE
[Symbol]	OAK TREE
[Symbol]	CEDAR TREE
[Symbol]	BARBED WIRE FENCE
[Symbol]	REFLECTOR
[Symbol]	APPROXIMATE TELEPHONE LINE
[Symbol]	APPROXIMATE GAS LINE
[Symbol]	APPROXIMATE WATER LINE
[Symbol]	OVERHEAD POWER LINE
[Symbol]	PINE TREE
[Symbol]	PECAN TREE

RECORD DRAWING
3-6-02

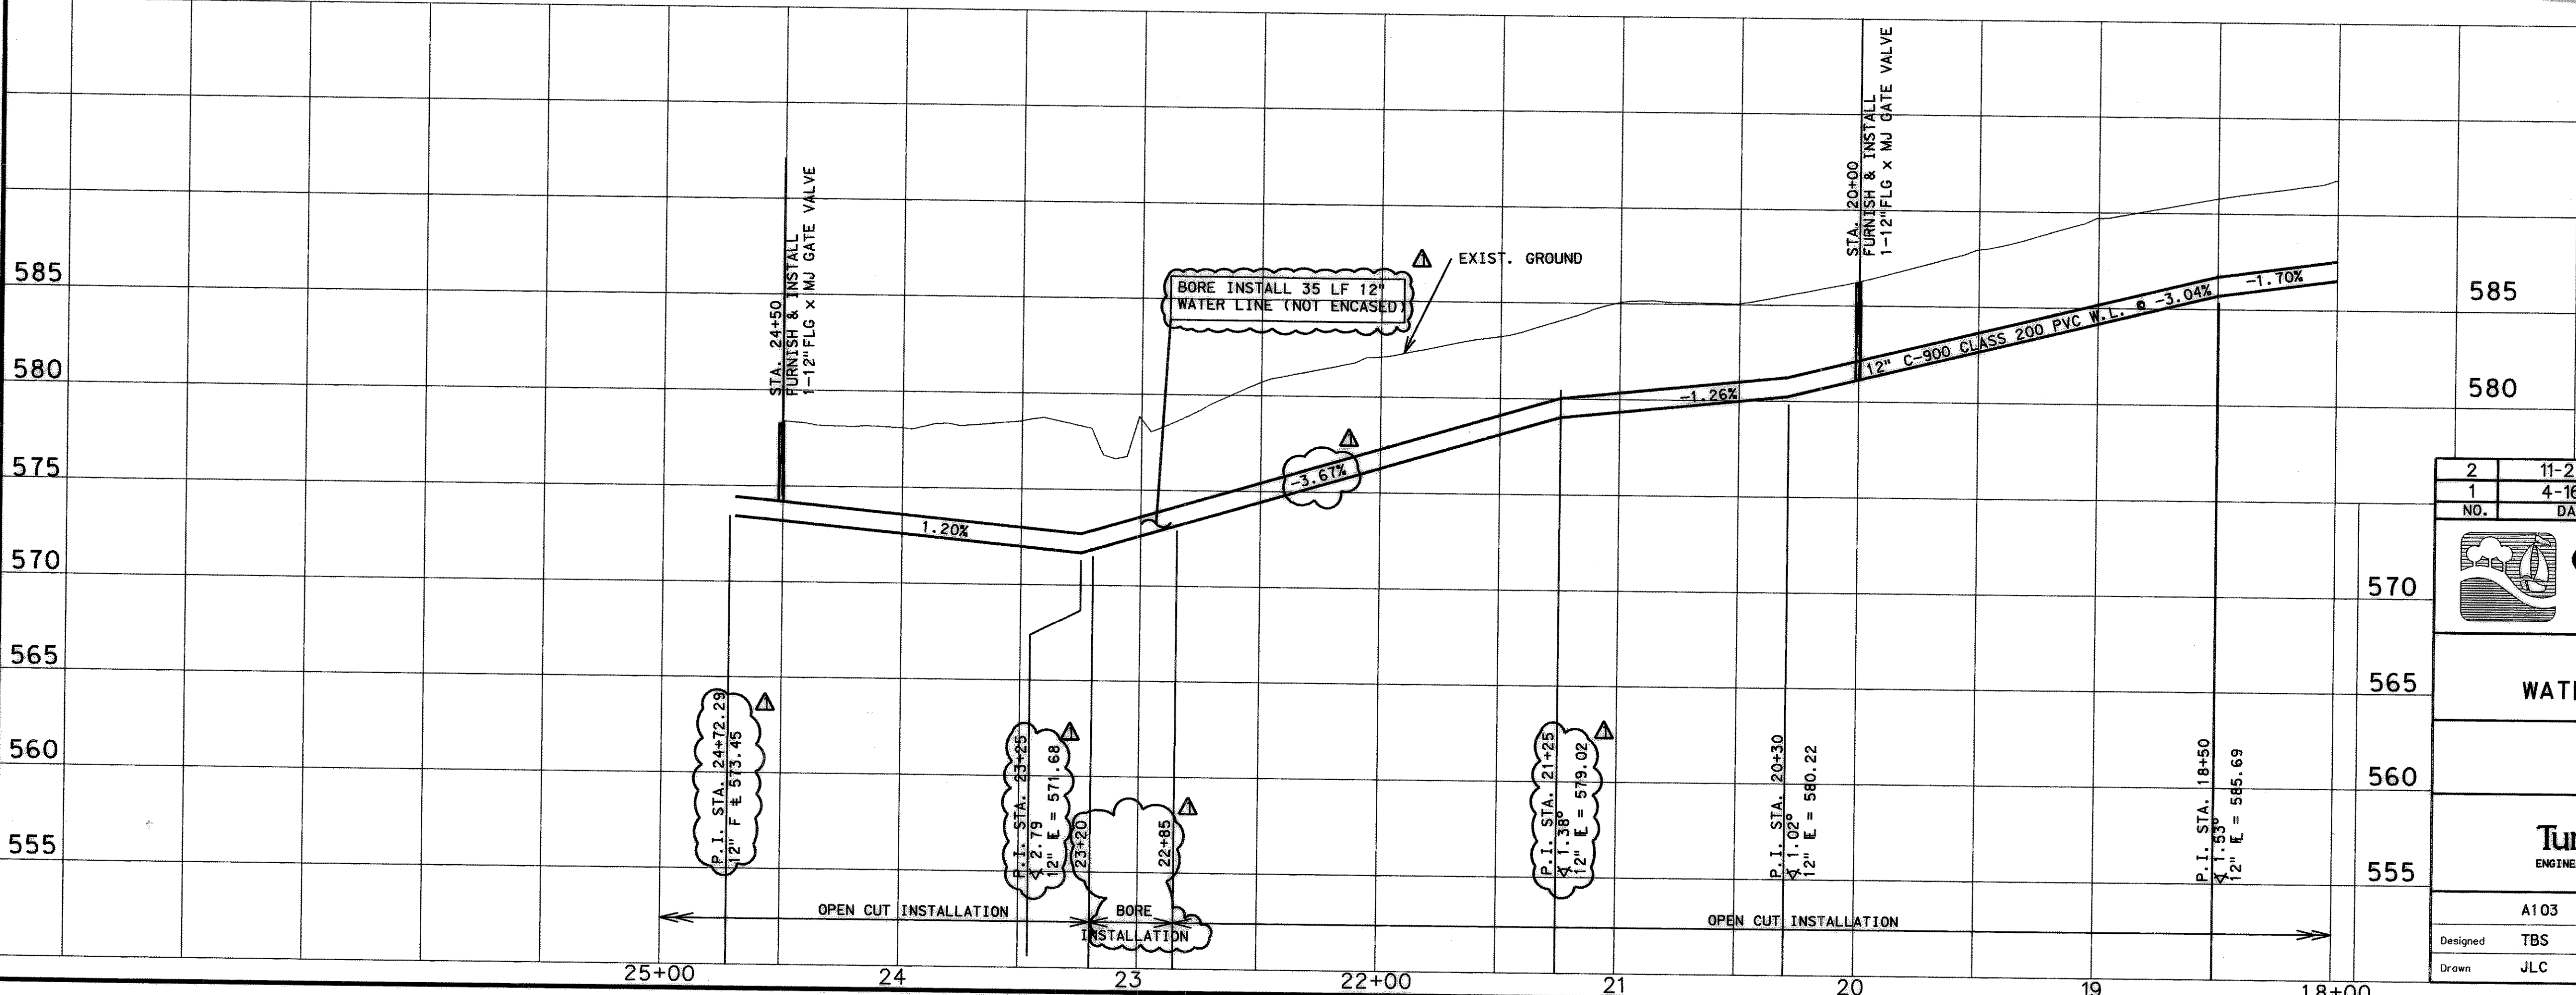

UNDERGROUND UTILITIES

THE LOCATION OF EXISTING UTILITIES SHOWN ON THESE PLANS ARE APPROXIMATE AND BASED ON DATA FURNISHED BY UTILITY COMPANIES. IT IS THE RESPONSIBILITY OF THE CONTRACTOR TO LOCATE AND VERIFY ON-SITE THE UTILITIES THAT MAY CONFLICT WITH THE CONSTRUCTION.

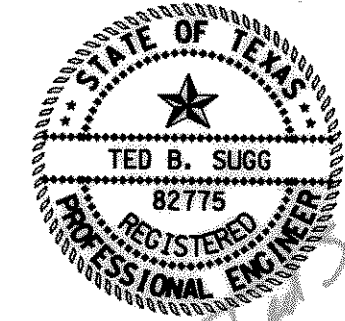

2	11-27-01	RECORD DRAWING	TBS
1	4-16-99	REALIGNMENT	TBS
NO.	DATE	REVISION	APPROV
CITY OF ROCKWALL "THE NEW HORIZON"			
S.H. 276 WATER LINE IMPROVEMENTS			
UTILITY PLAN AND PROFILE 12" WATER LINE			
TurnerCollie & Braden Inc. ENGINEERS • PLANNERS • PROJECT MANAGERS			
A103	Scale: Horz. 1"=40' Vert. 1"=5'	Date	FEBRUARY, 1999
Designed: TBS	Checked: DWN	Job No. 15-98925-200	
Drawn: JLC	Approved: RCR	SHEET 20 OF 33	