
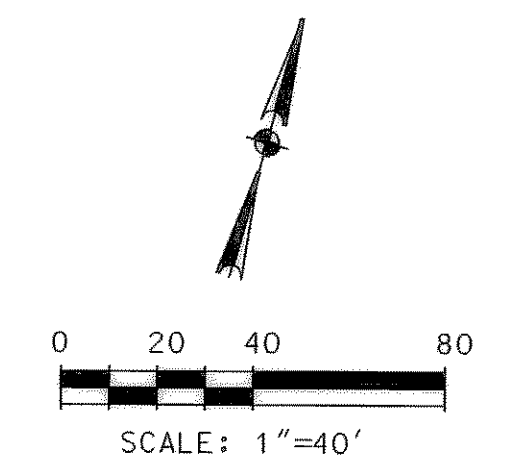



MATCH LINE STA. 45+00

MATCH LINE STA. 54+00

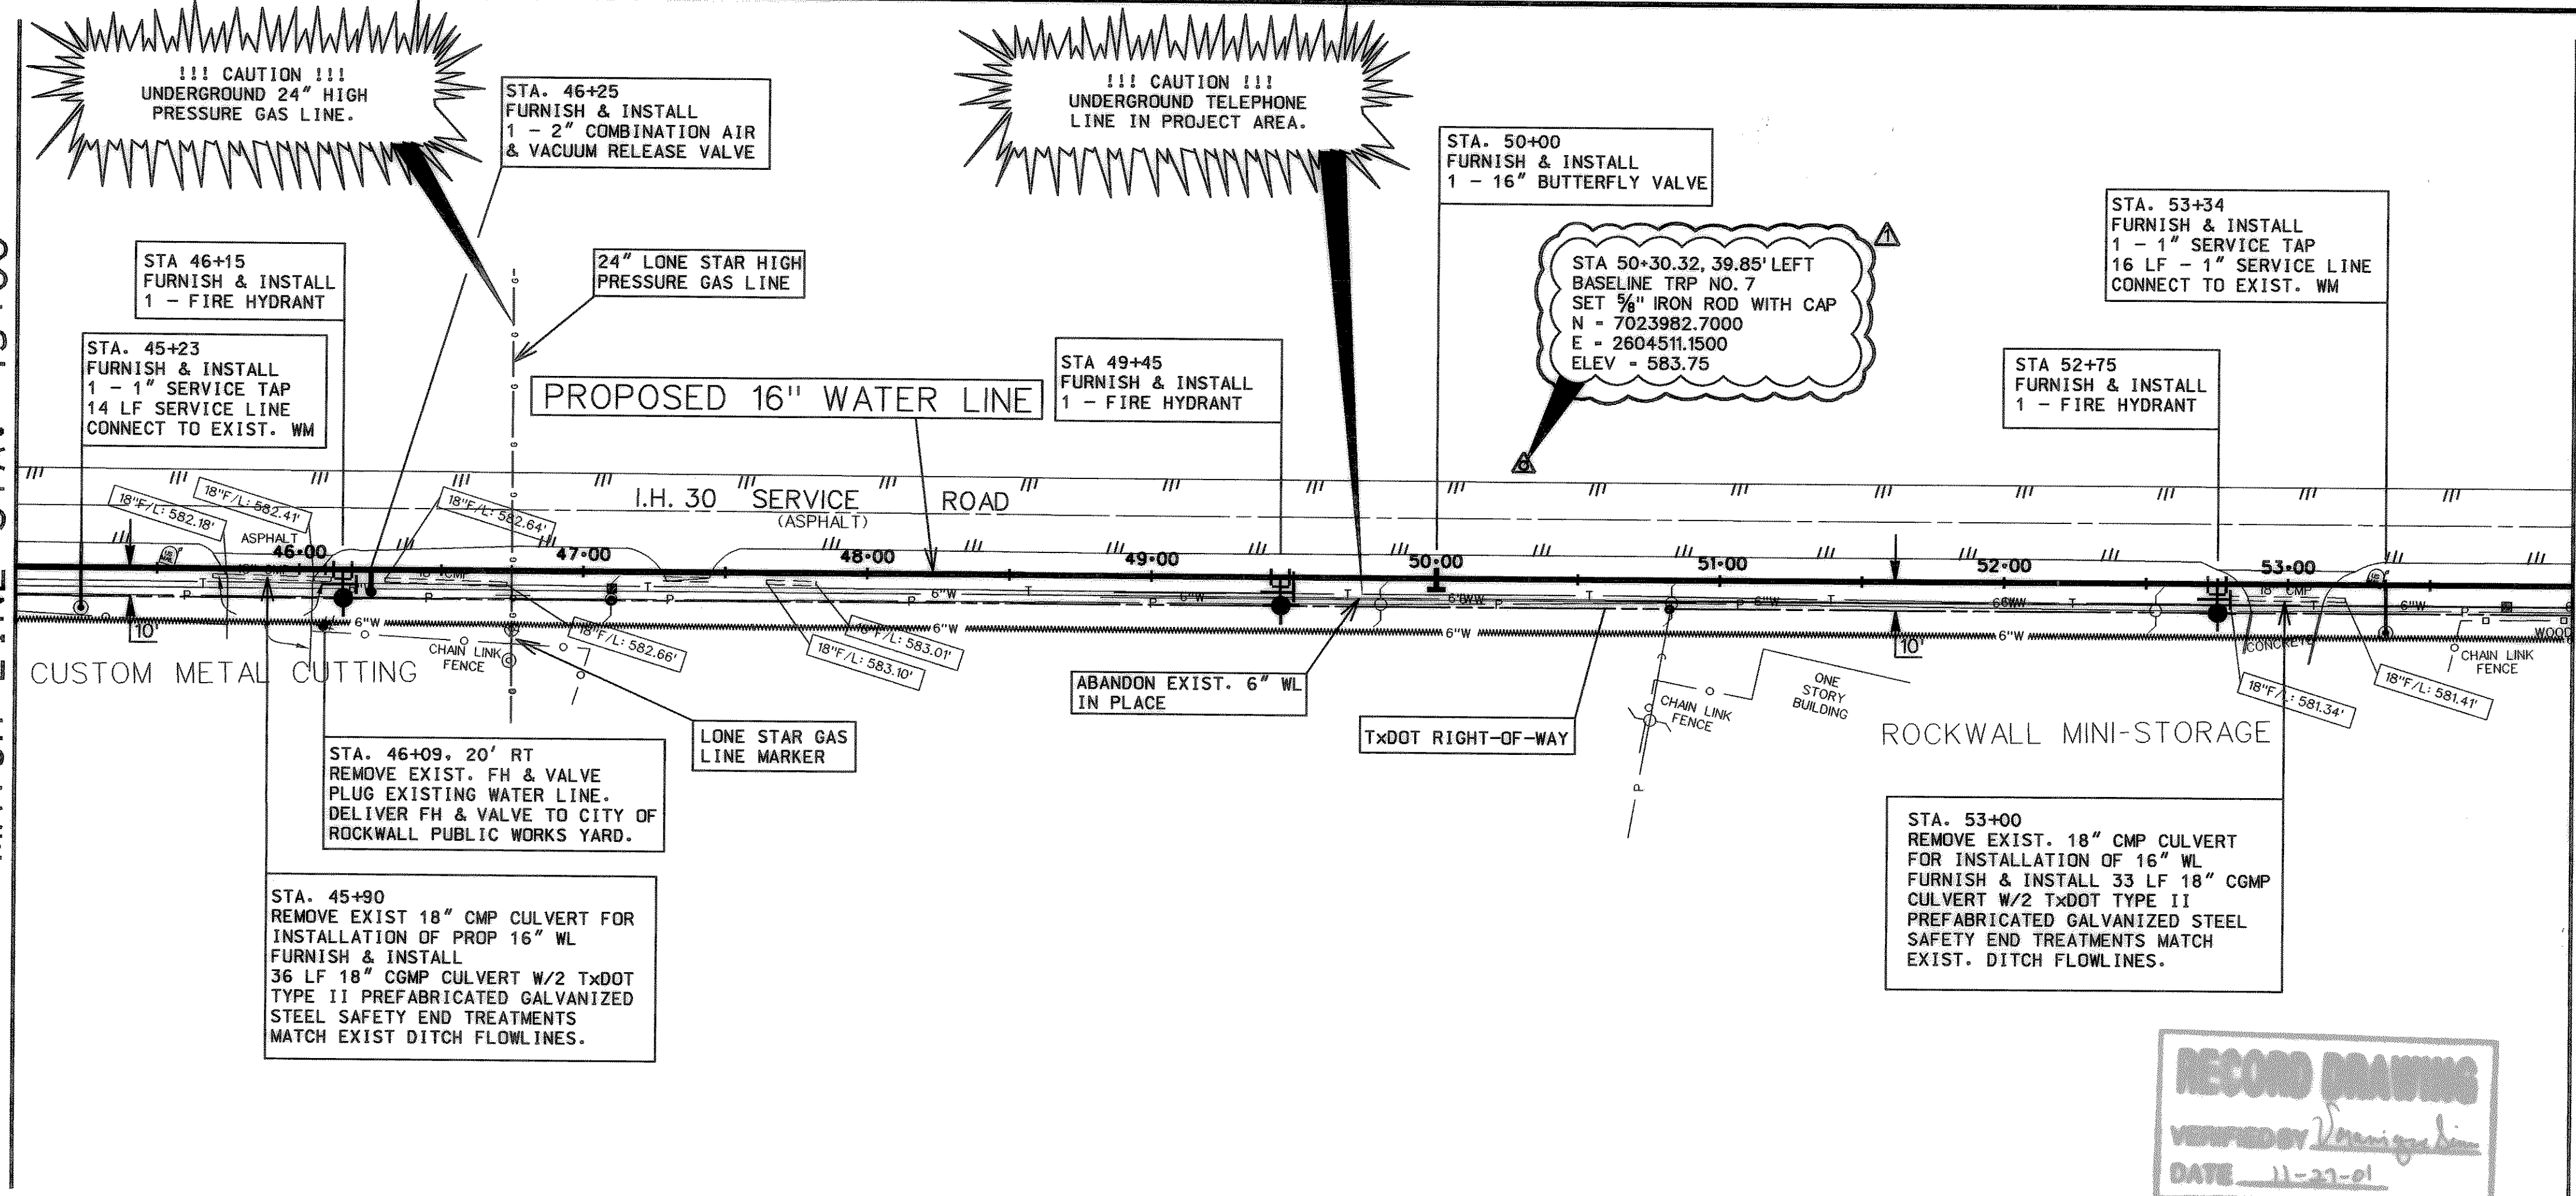


LEGEND	
[Symbol]	POWER POLE
[Symbol]	GUY WIRE
[Symbol]	TELEPHONE BOX
[Symbol]	POST
[Symbol]	SIGN
[Symbol]	IRON ROD
[Symbol]	FIRE HYDRANT
[Symbol]	WATER METER
[Symbol]	MAILBOX
[Symbol]	WATER METER
[Symbol]	IRRIGATION CONTROL VALVE
[Symbol]	GUARD RAIL
[Symbol]	GAS METER
[Symbol]	GROUND LIGHT
[Symbol]	CHAIN LINK FENCE
[Symbol]	WOOD FENCE
[Symbol]	ASH TREE
[Symbol]	OAK TREE
[Symbol]	CEDAR TREE
[Symbol]	BARBED WIRE FENCE
[Symbol]	REFLECTOR
[Symbol]	APPROXIMATE TELEPHONE LINE
[Symbol]	APPROXIMATE GAS LINE
[Symbol]	APPROXIMATE WATER LINE
[Symbol]	OVERHEAD POWER LINE
[Symbol]	PINE TREE
[Symbol]	PECAN TREE

RECORD DRAWING
 VERIFIED BY *[Signature]*
 DATE 11-27-01

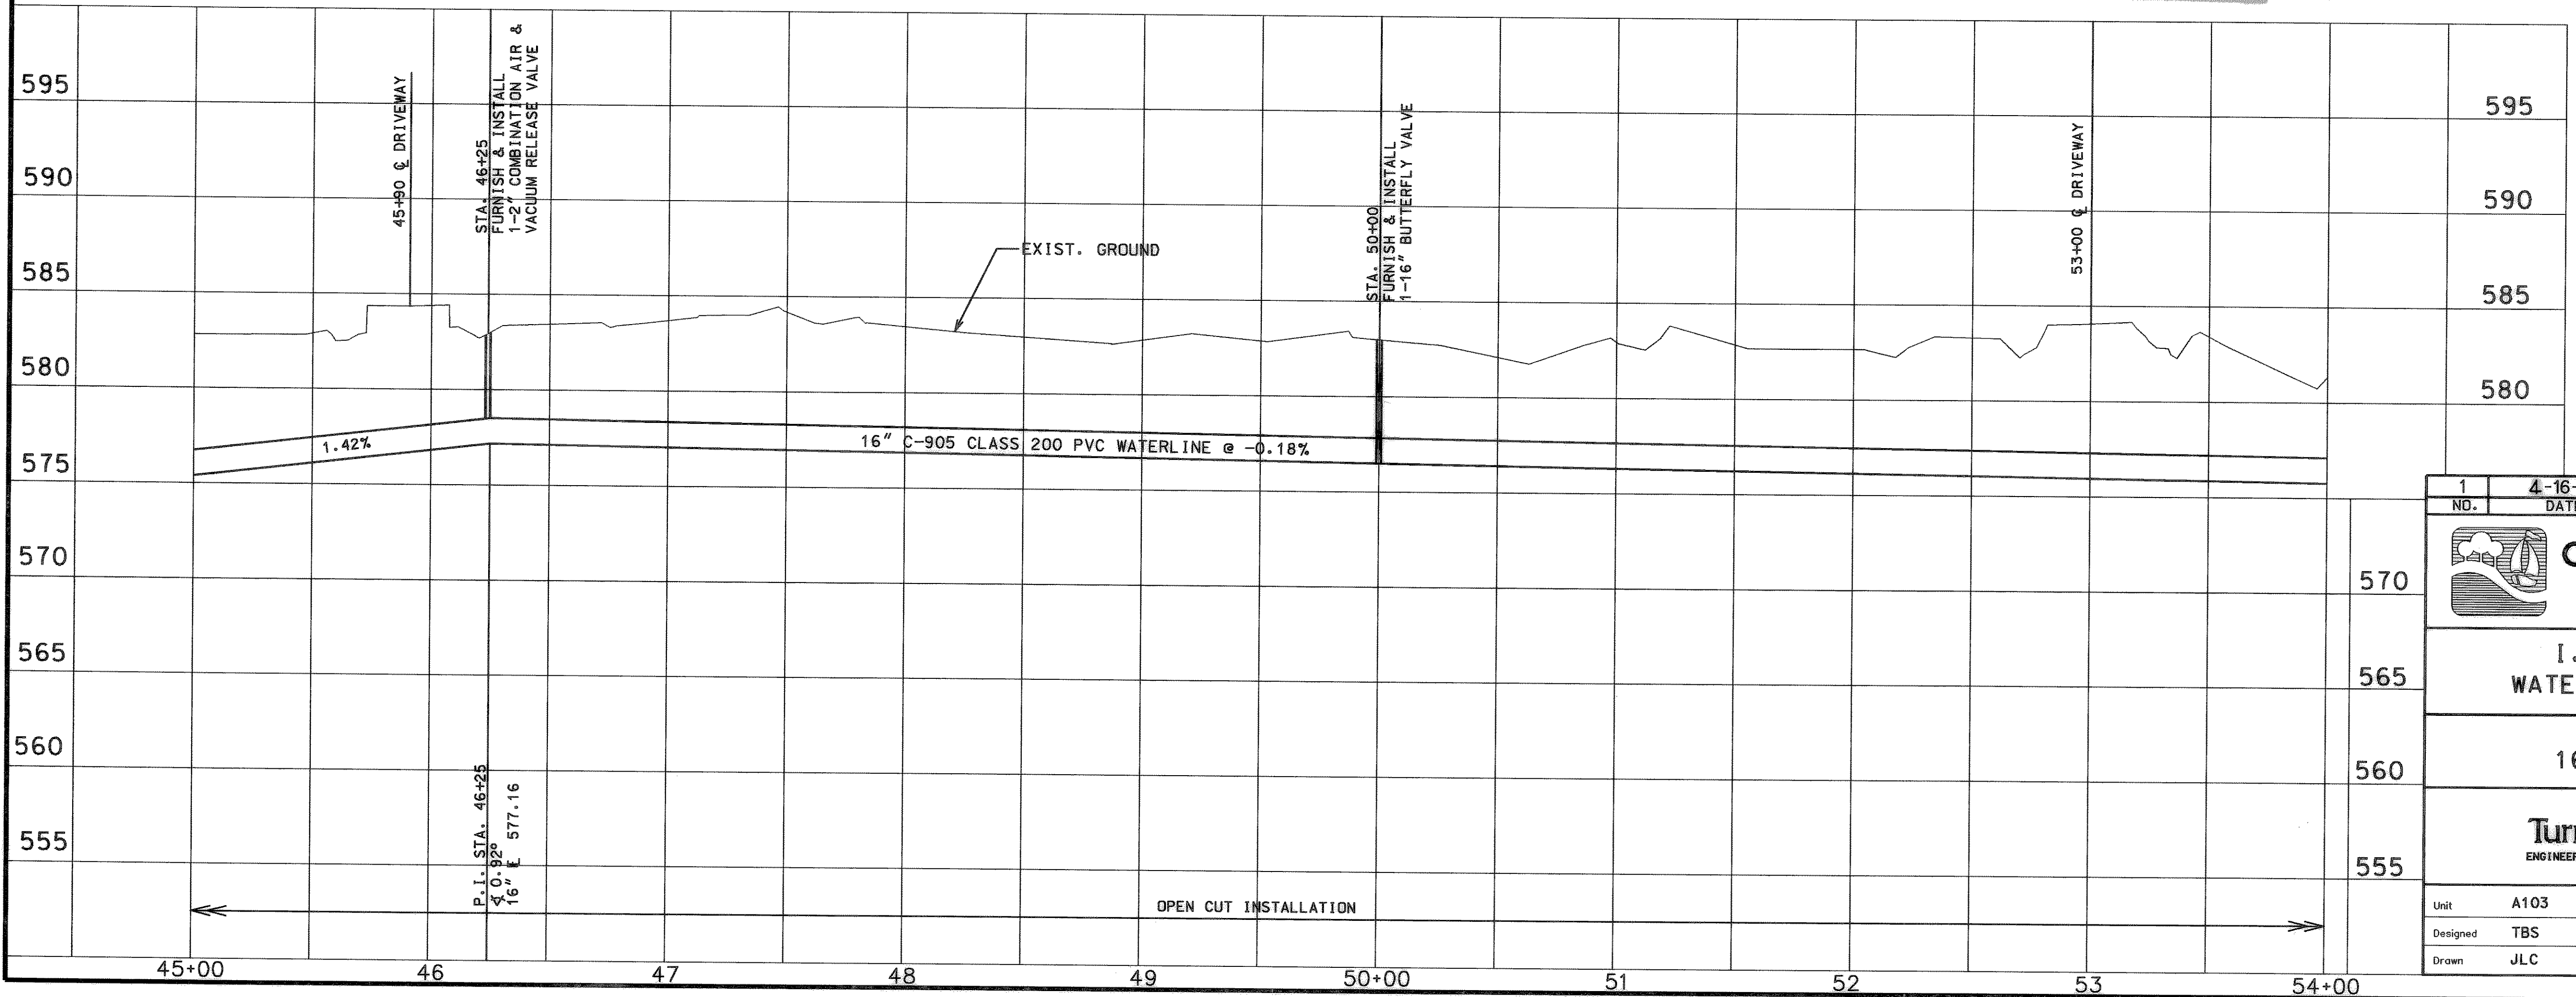

UNDERGROUND UTILITIES

THE LOCATION OF EXISTING UTILITIES SHOWN ON THESE PLANS ARE APPROXIMATE AND BASED ON DATA FURNISHED BY UTILITY COMPANIES. IT IS THE RESPONSIBILITY OF THE CONTRACTOR TO LOCATE AND VERIFY ON-SITE THE UTILITIES THAT MAY CONFLICT WITH THE CONSTRUCTION.

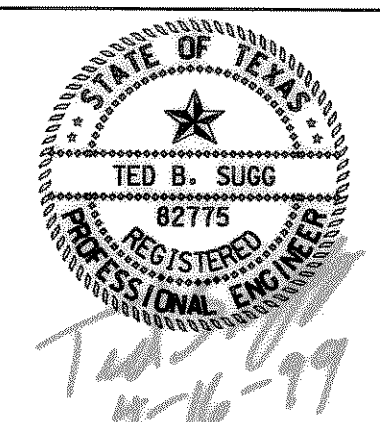

NO.	1	DATE	4-16-99	REALIGNMENT REVISION	TBS APPROV
 CITY OF ROCKWALL "THE NEW HORIZON"					
I.H. 30 AND FM 549 WATER LINE IMPROVEMENTS					
UTILITY PLAN AND PROFILE 16" PVC WATER LINE STA. 45+00 TO STA. 54+00					
TurnerCollie & Braden Inc. ENGINEERS • PLANNERS • PROJECT MANAGERS					
Unit	A103	Scale	Horz. 1"=40' Vert. 1"=5'	Date	FEBRUARY, 1999
Designed	TBS	Checked	DWN	Job No.	15-98925-200
Drawn	JLC	Approved	RCR	SHEET 8 OF 33	

P:\ROCKWALL\140\DRAWINGS\PROSA