



**RECORD DRAWING**  
 VERIFIED BY *David J. C...*  
 DATE 11-21-01

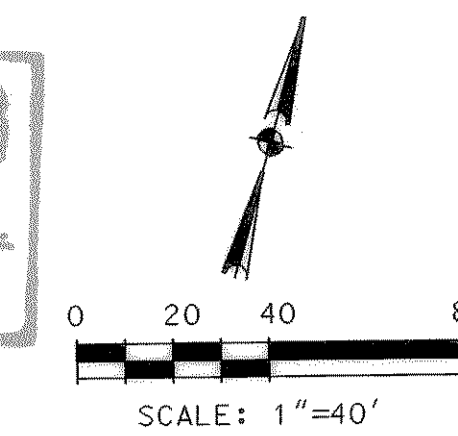

MATCH LINE STA. 54+00



MATCH LINE STA. 63+00

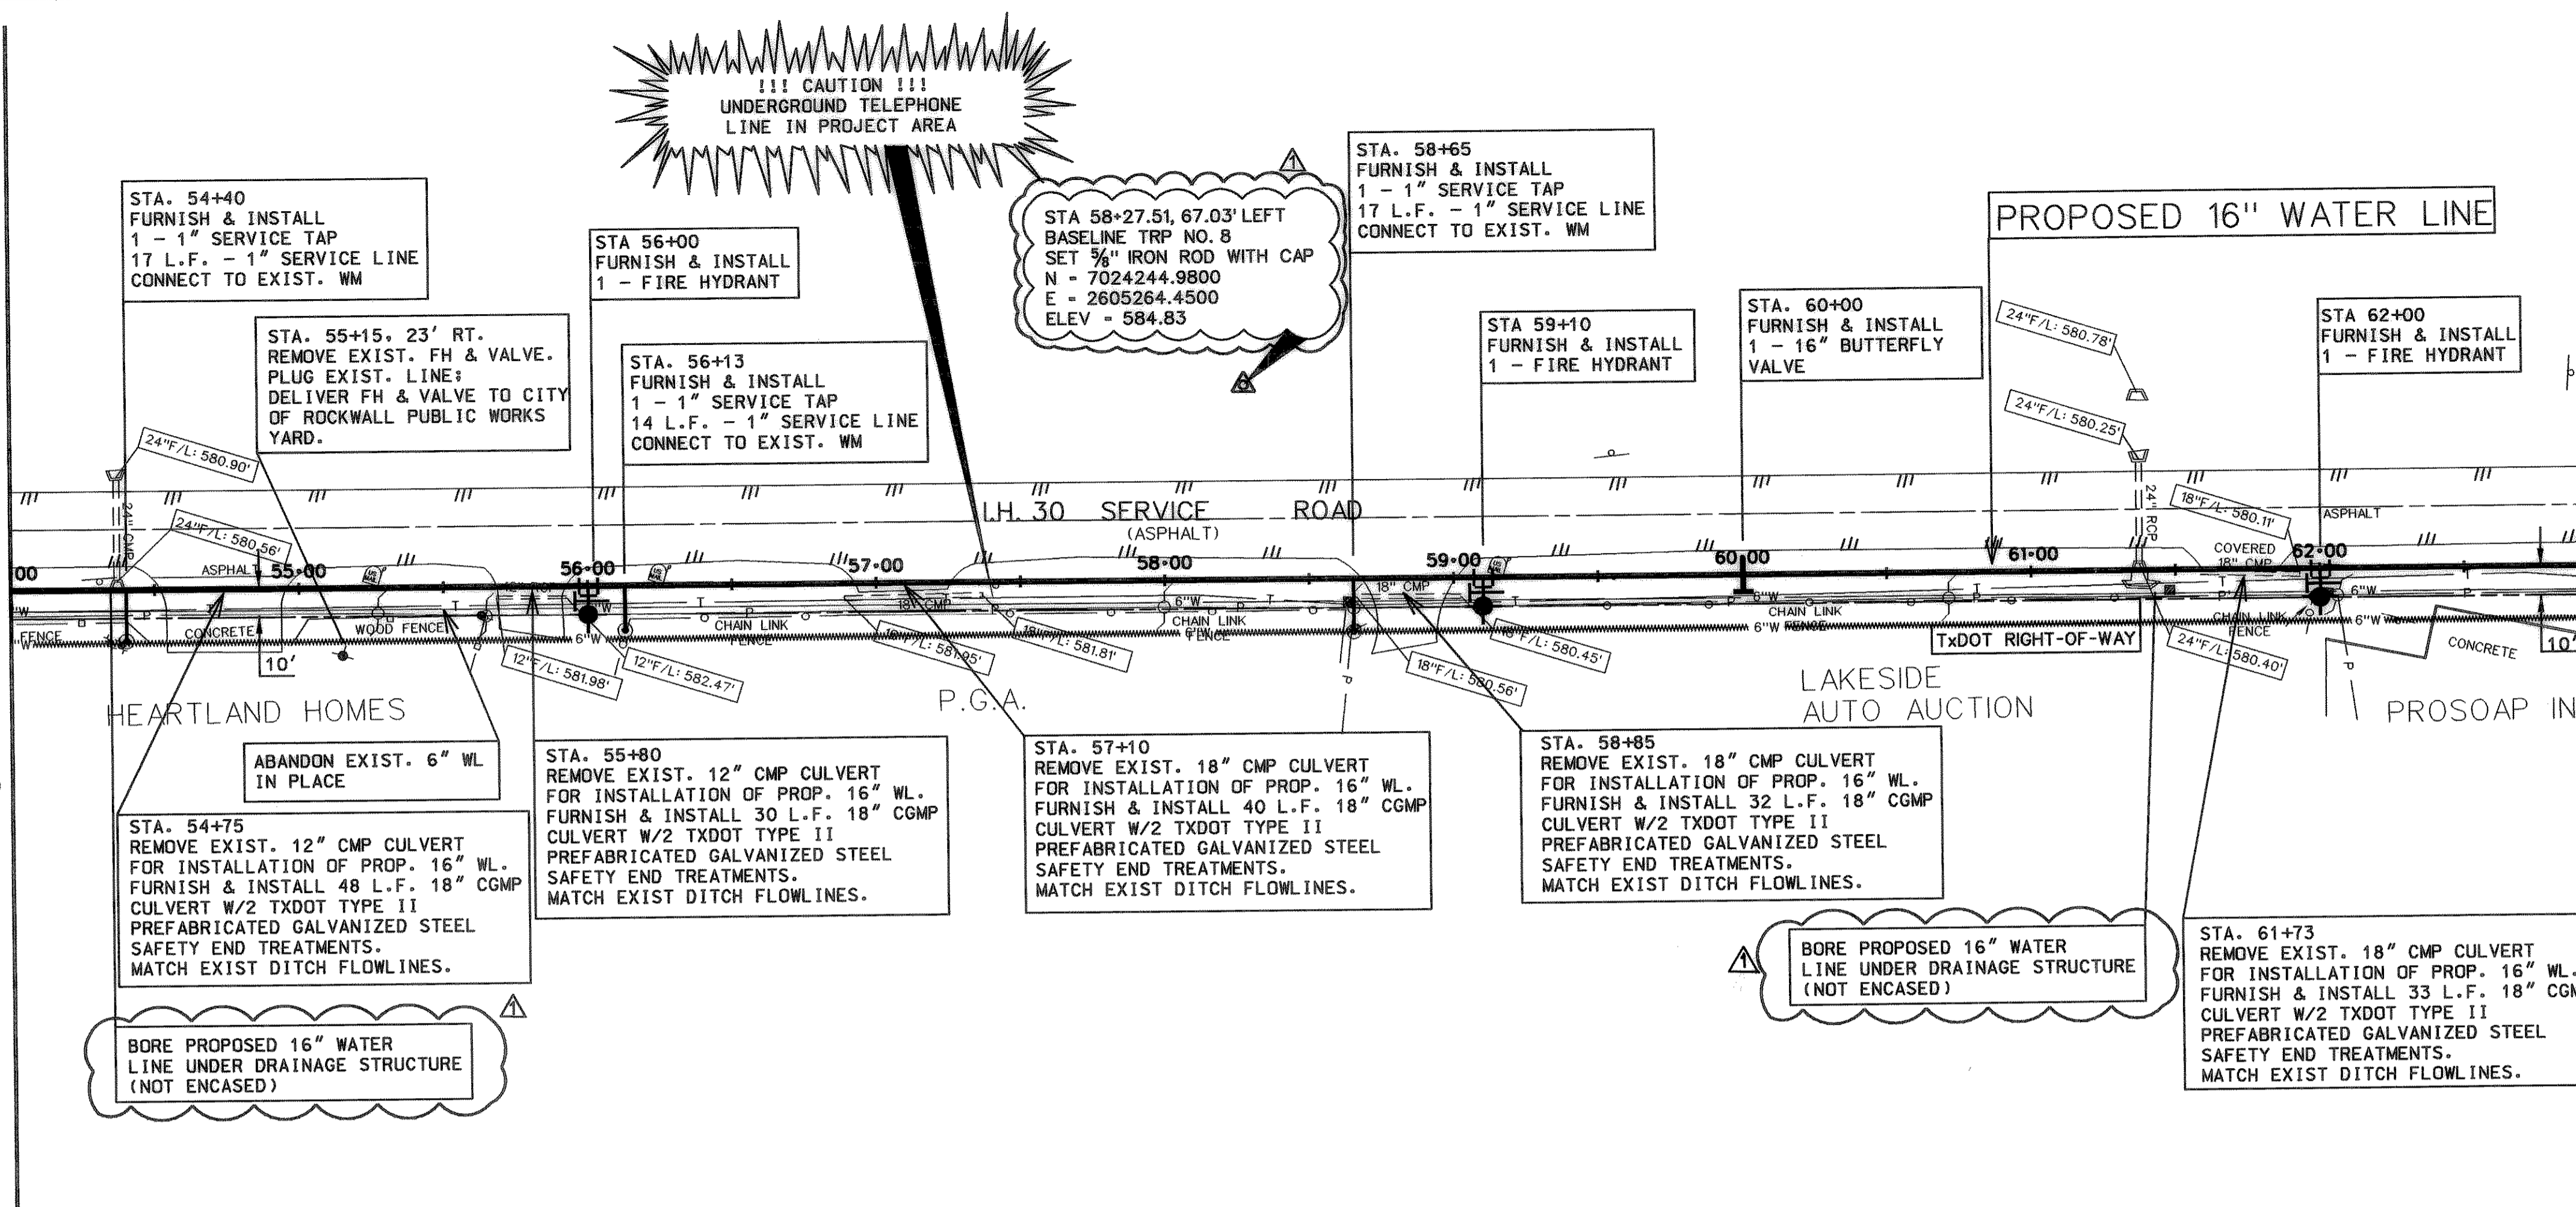

LEGEND	
	POWER POLE
	GUY WIRE
	TELEPHONE BOX
	POST
	SIGN
	IRON ROD
	FIRE HYDRANT
	WATER METER
	MAILBOX
	WATER METER
	IRRIGATION CONTROL VALVE
	GUARD RAIL
	GAS METER
	GROUND LIGHT
	CHAIN LINK FENCE
	WOOD FENCE
	ASH TREE
	OAK TREE
	CEDAR TREE
	BARBED WIRE FENCE
	REFLECTOR
	APPROXIMATE TELEPHONE LINE
	APPROXIMATE GAS LINE
	APPROXIMATE WATER LINE
	OVERHEAD POWER LINE
	PINE TREE
	PECAN TREE

**UNDERGROUND UTILITIES**

THE LOCATION OF EXISTING UTILITIES SHOWN ON THESE PLANS ARE APPROXIMATE AND BASED ON DATA FURNISHED BY UTILITY COMPANIES. IT IS THE RESPONSIBILITY OF THE CONTRACTOR TO LOCATE AND VERIFY ON-SITE THE UTILITIES THAT MAY CONFLICT WITH THE CONSTRUCTION.

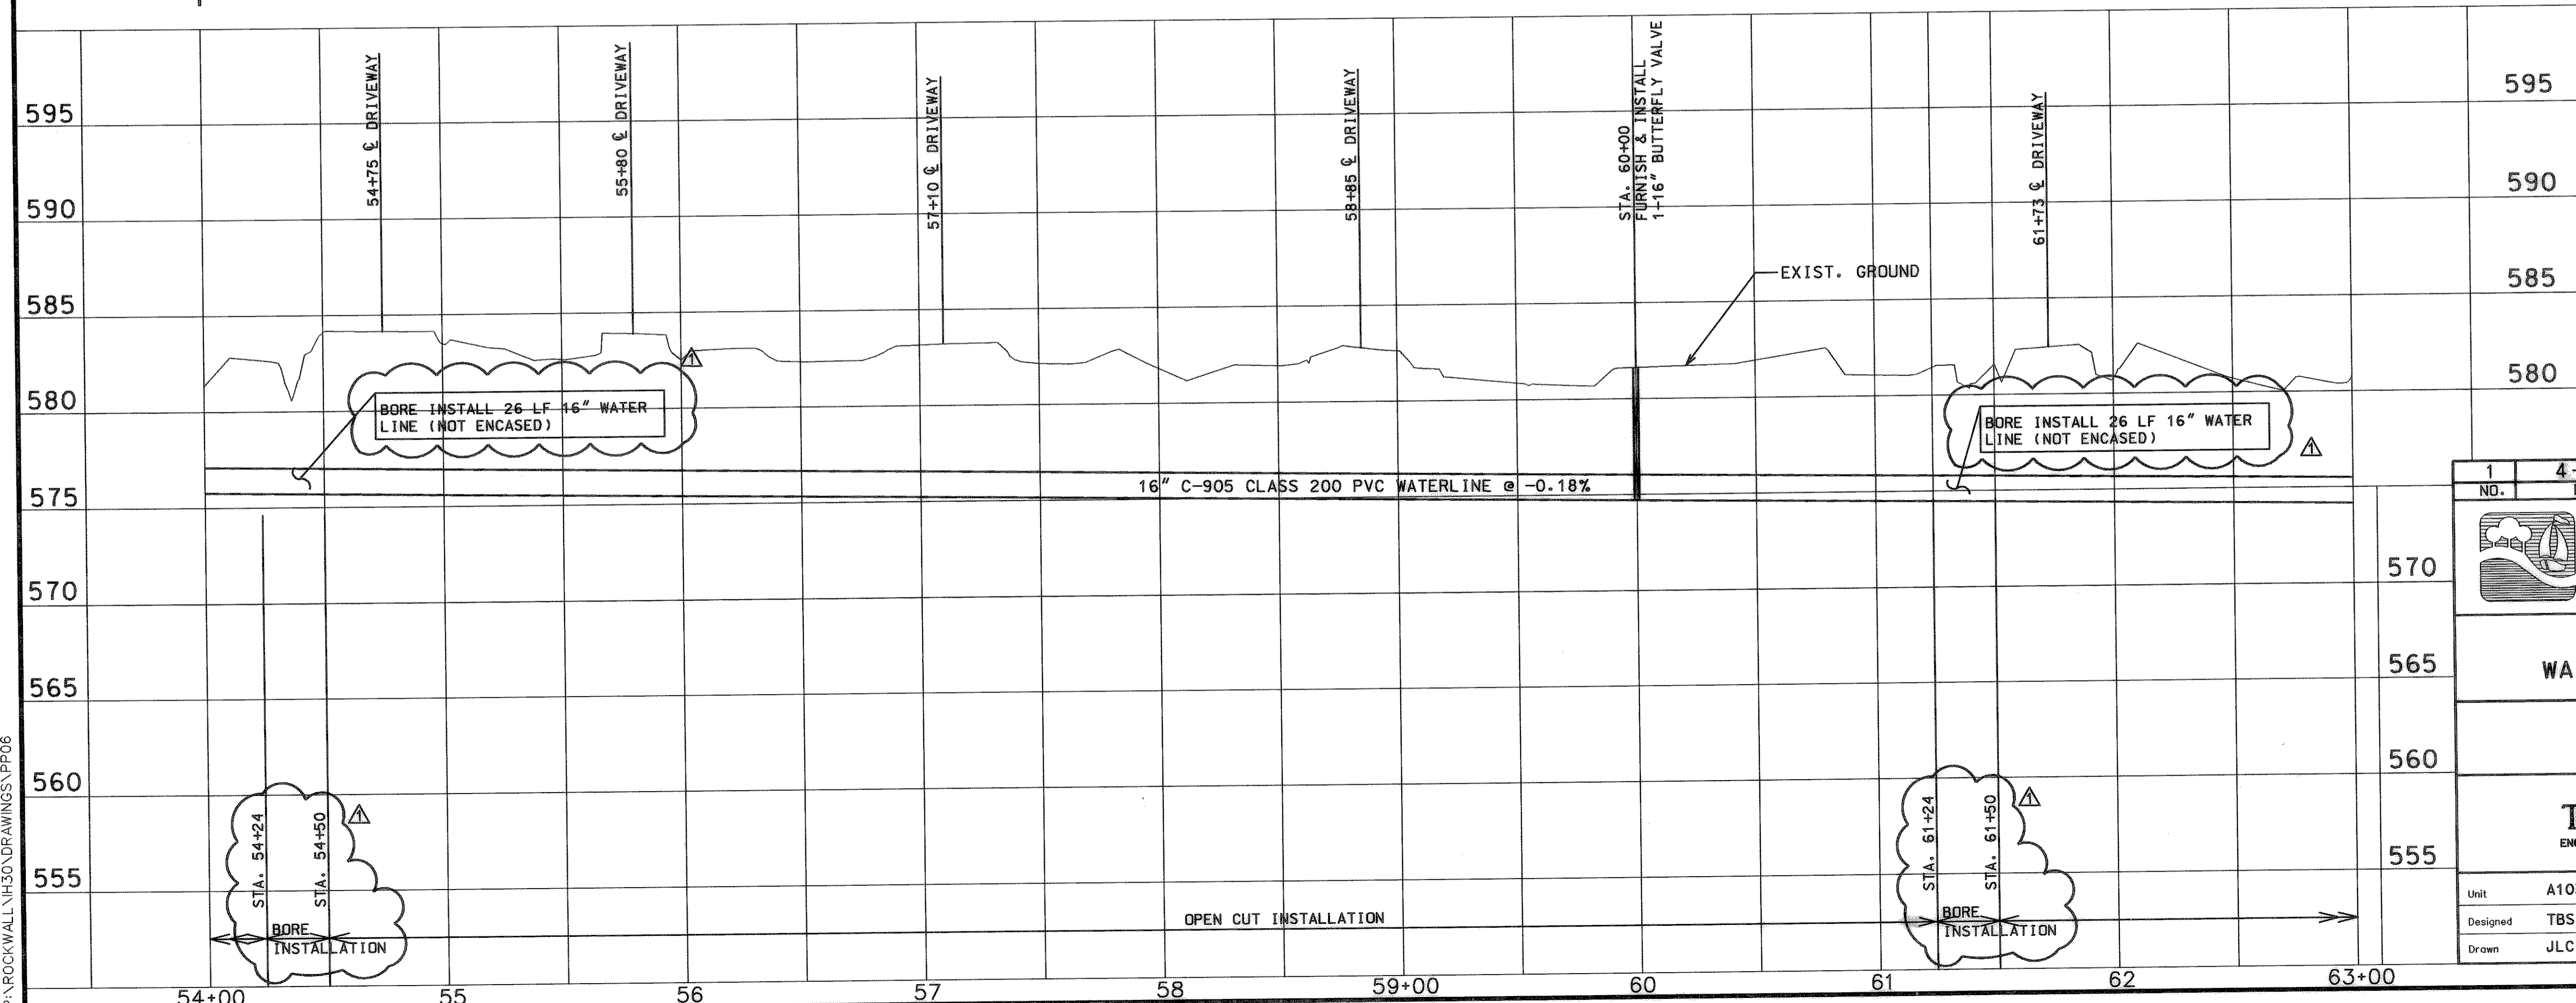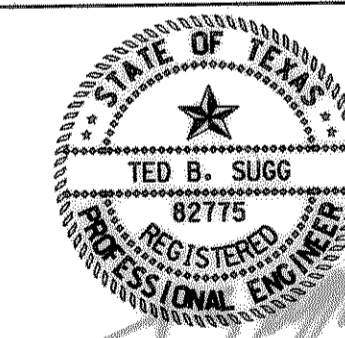

1	4-16-99	REALIGNMENT	TBS
NO.	DATE	REVISION	APPROV
<b>CITY OF ROCKWALL</b> "THE NEW HORIZON"			
<b>I.H. 30 AND FM 549</b> <b>WATER LINE IMPROVEMENTS</b>			
UTILITY PLAN AND PROFILE <b>16" PVC WATER LINE</b> STA. 54+00 TO STA. 63+00			
<b>TurnerCollie &amp; Braden Inc.</b> <small>ENGINEERS • PLANNERS • PROJECT MANAGERS</small>			
Unit	A103	Scale: Horz. 1"=40' Vert. 1"=5'	Date FEBRUARY, 1999
Designed	TBS	Checked DWN	Job No. 15-98925-200
Drawn	JLC	Approved RCR	SHEET 9 OF 33

P:\ROCKWALL\I.H.30 DRAWINGS\PP06