




LIFT STATION PLAN
Scale: 1/2" = 1'0"

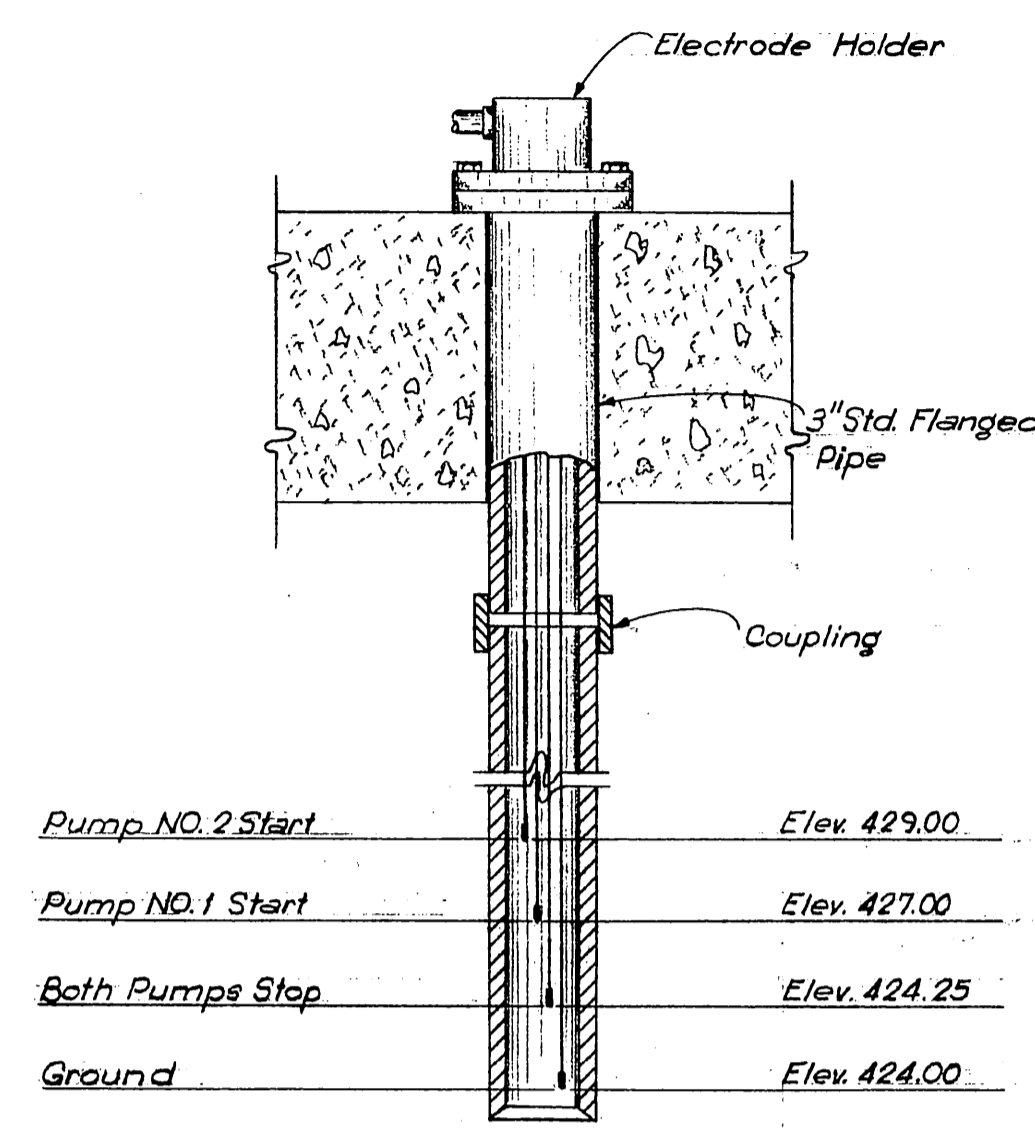


ELECTRODE HOLDER DETAIL

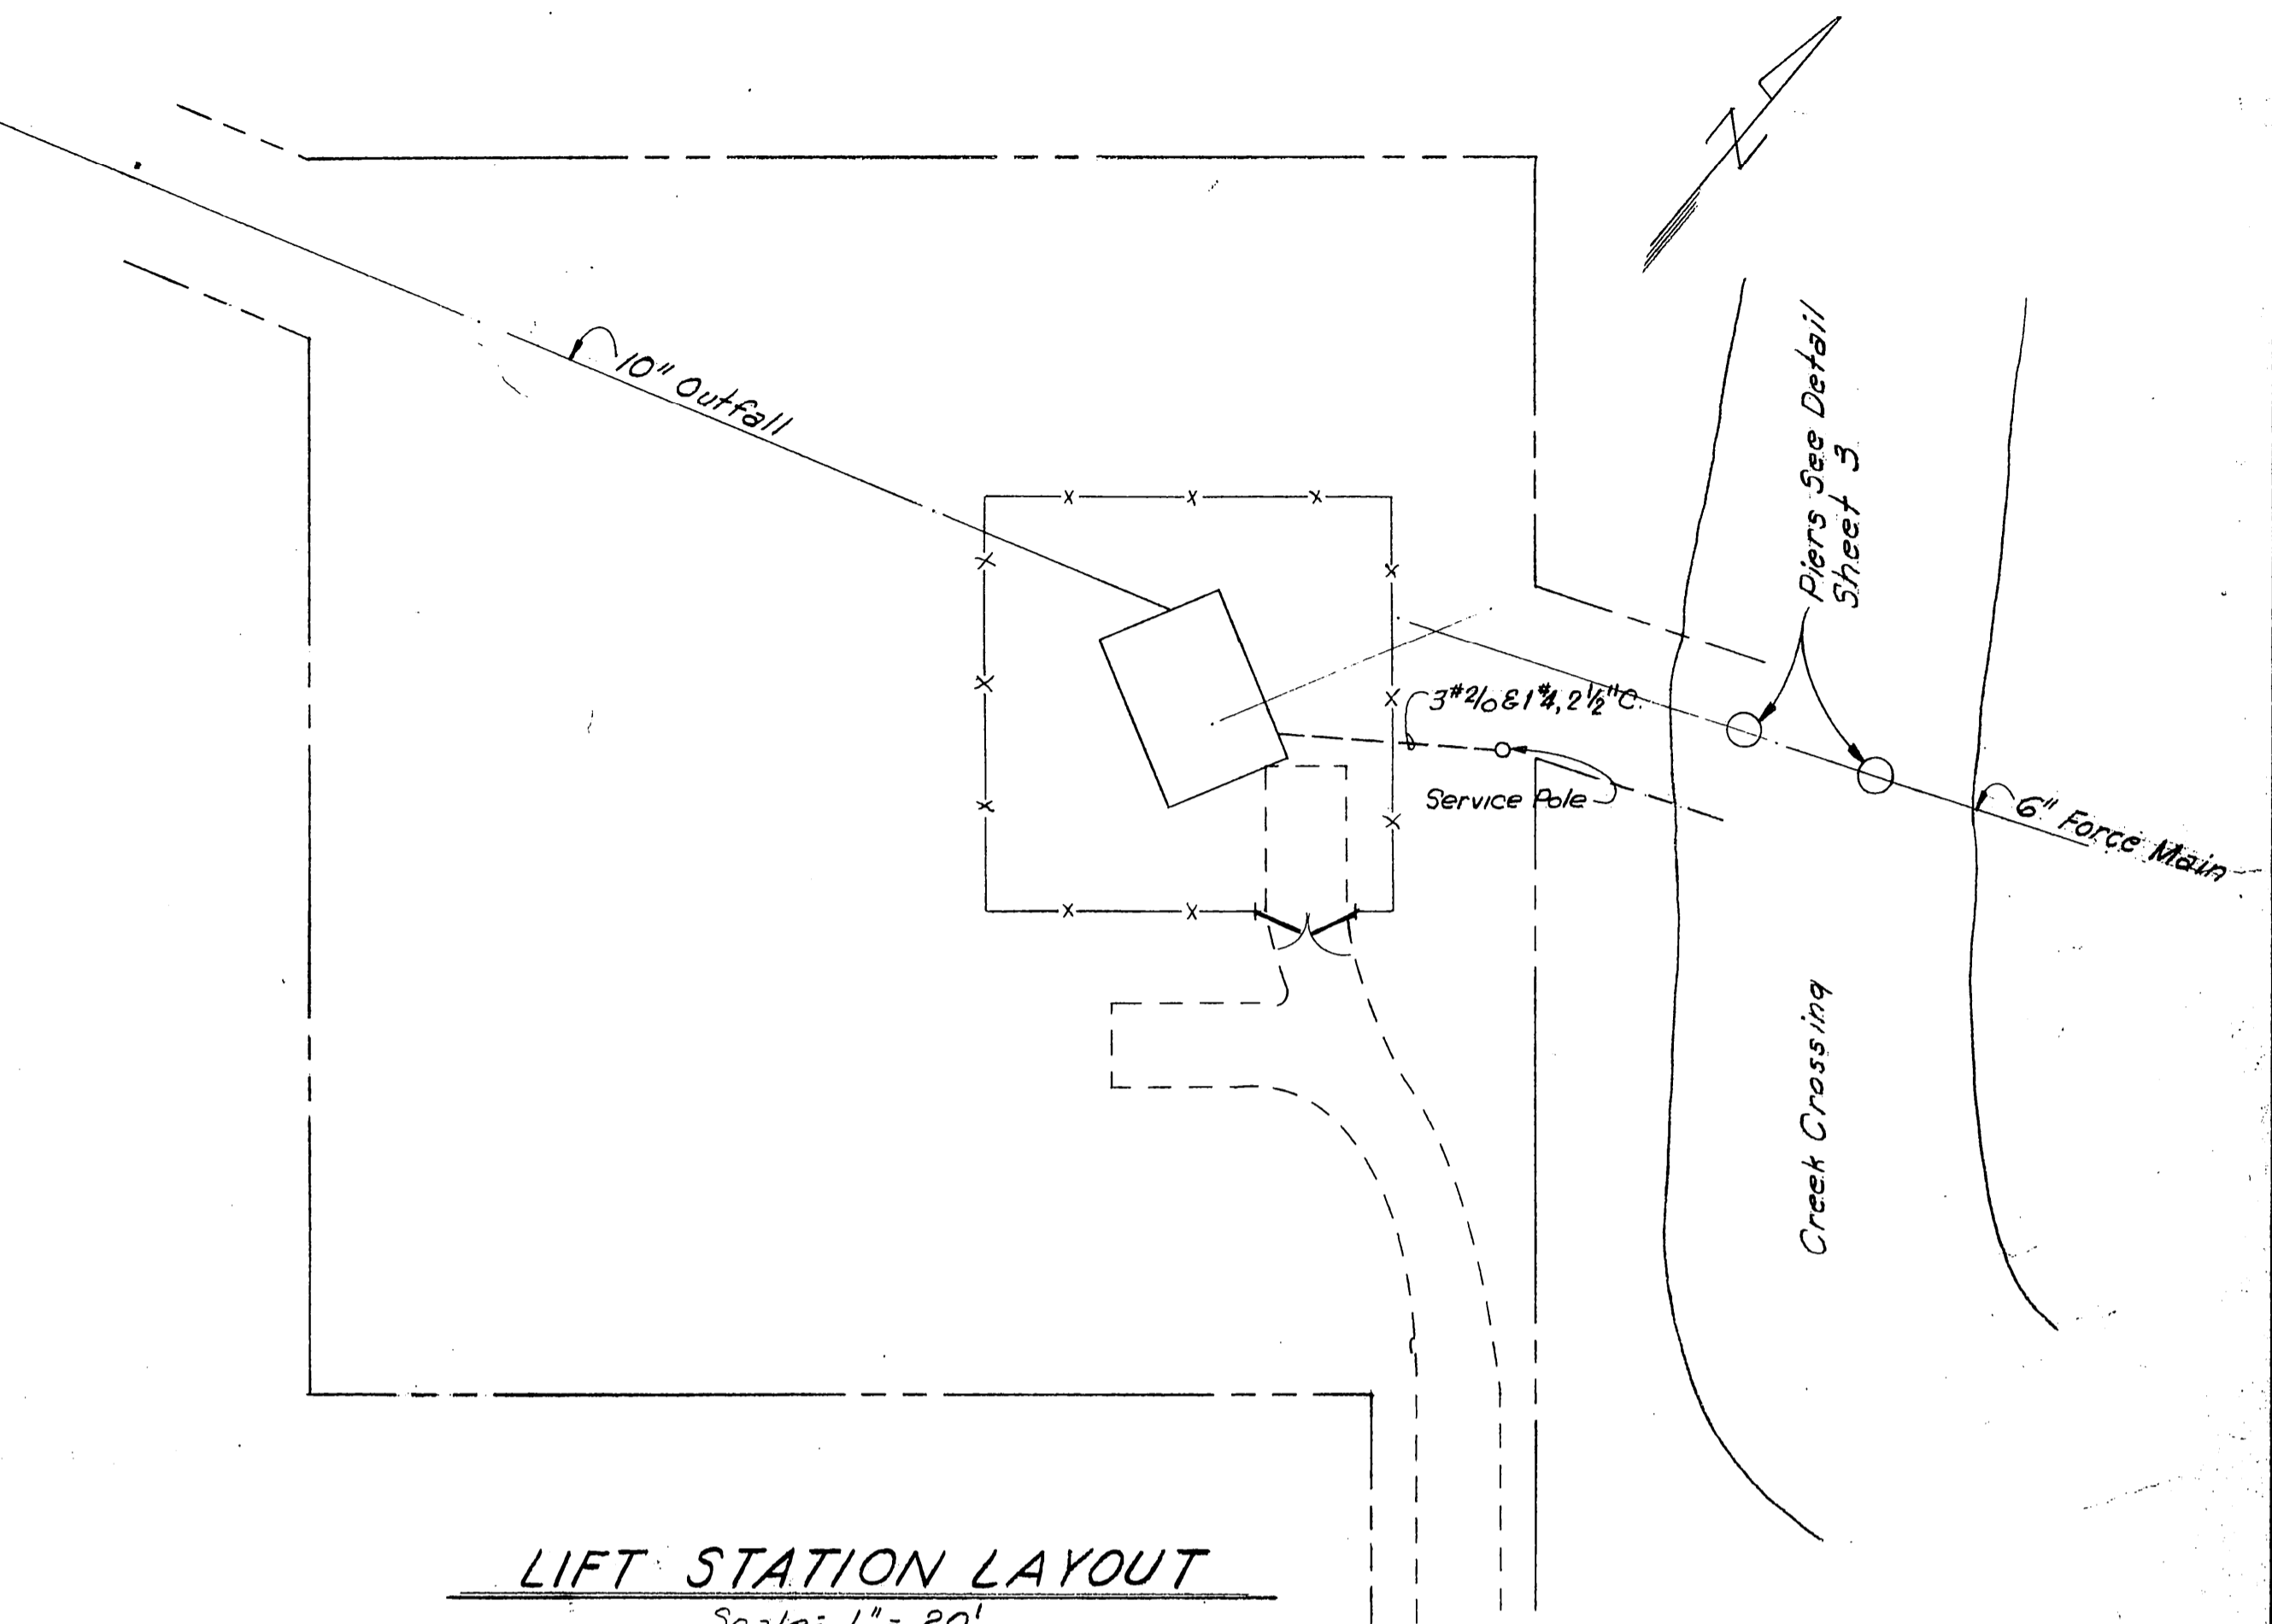


LIFT STATION LAYOUT
Scale: 1" = 20'

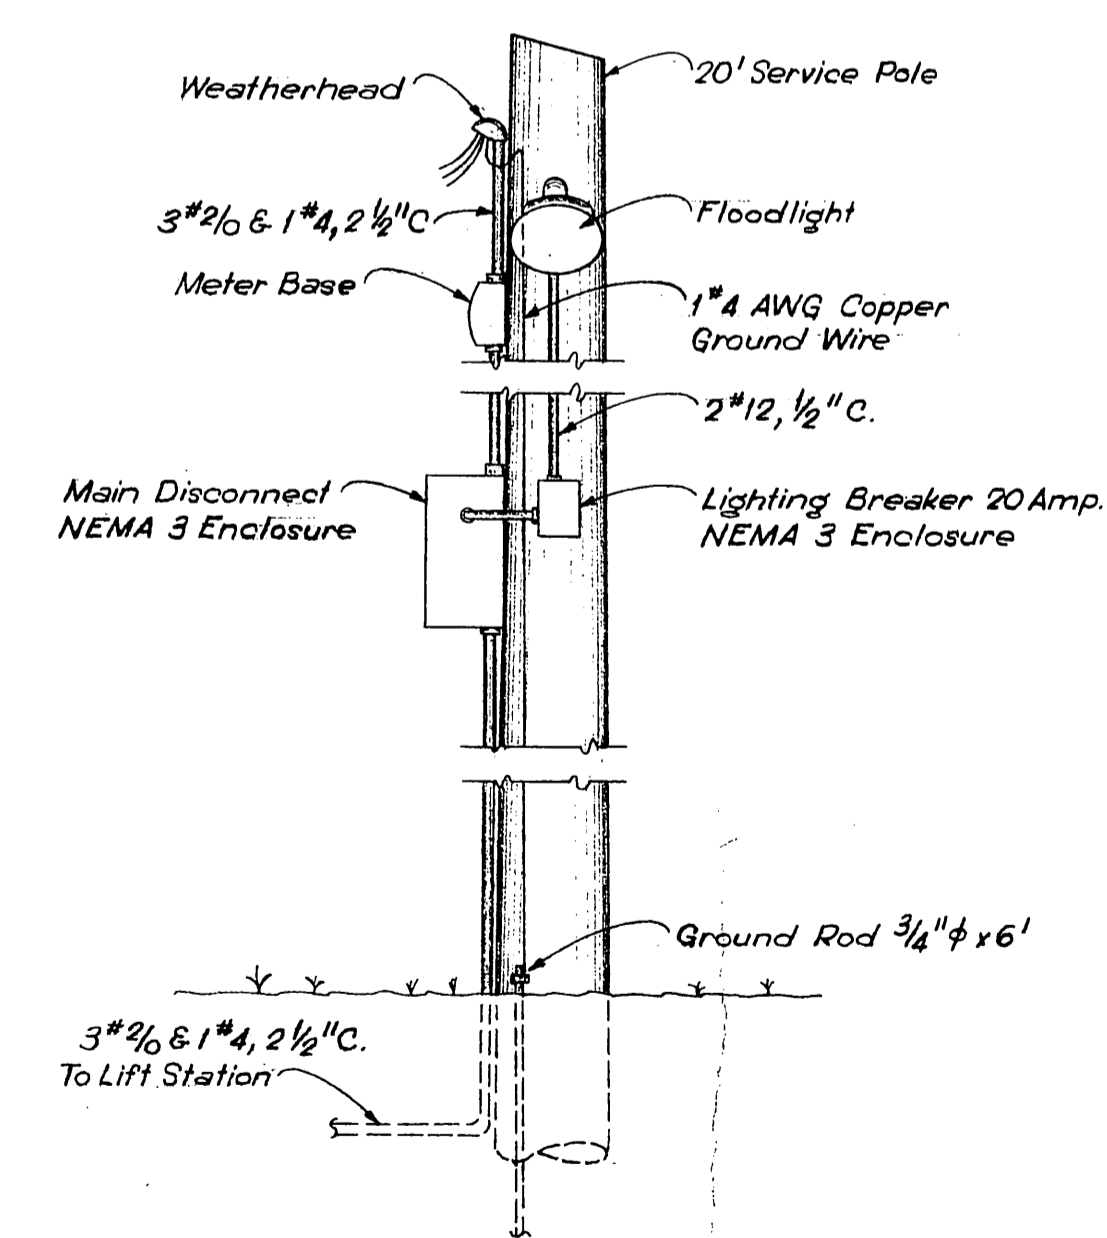


ELEVATION OF SERVICE POLE

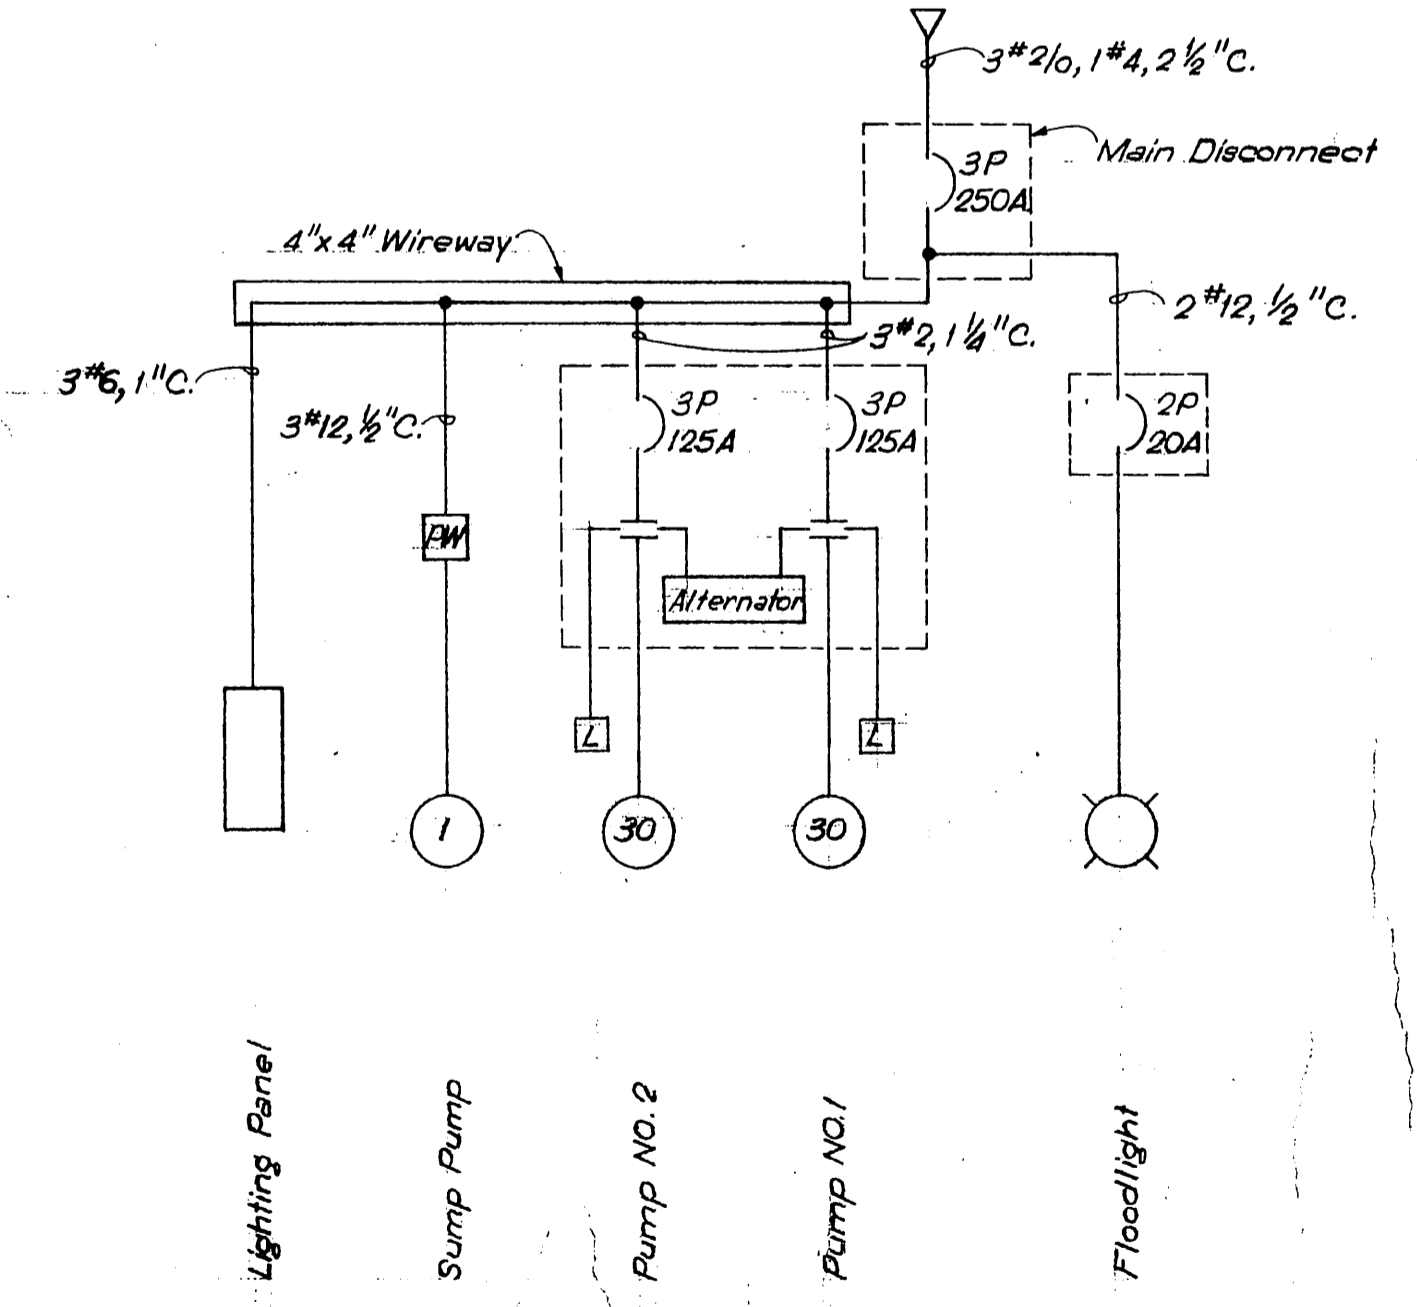

ONE LINE DIAGRAM

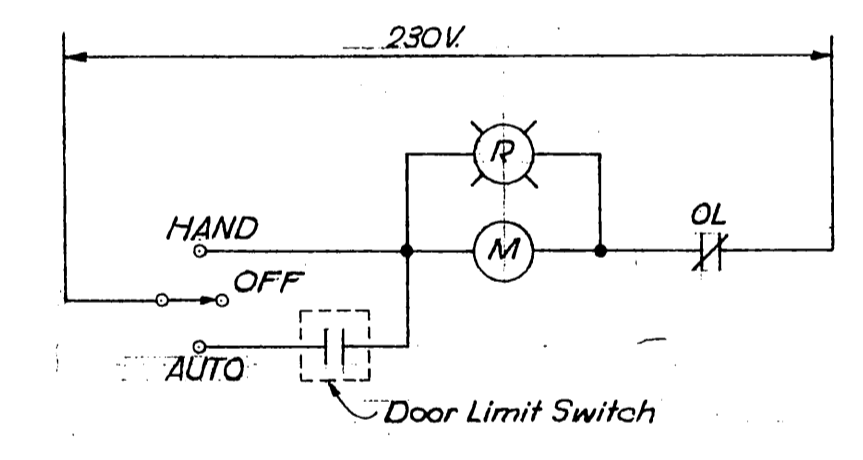


CONTROL SCHEMATIC FOR AIR BLOWER

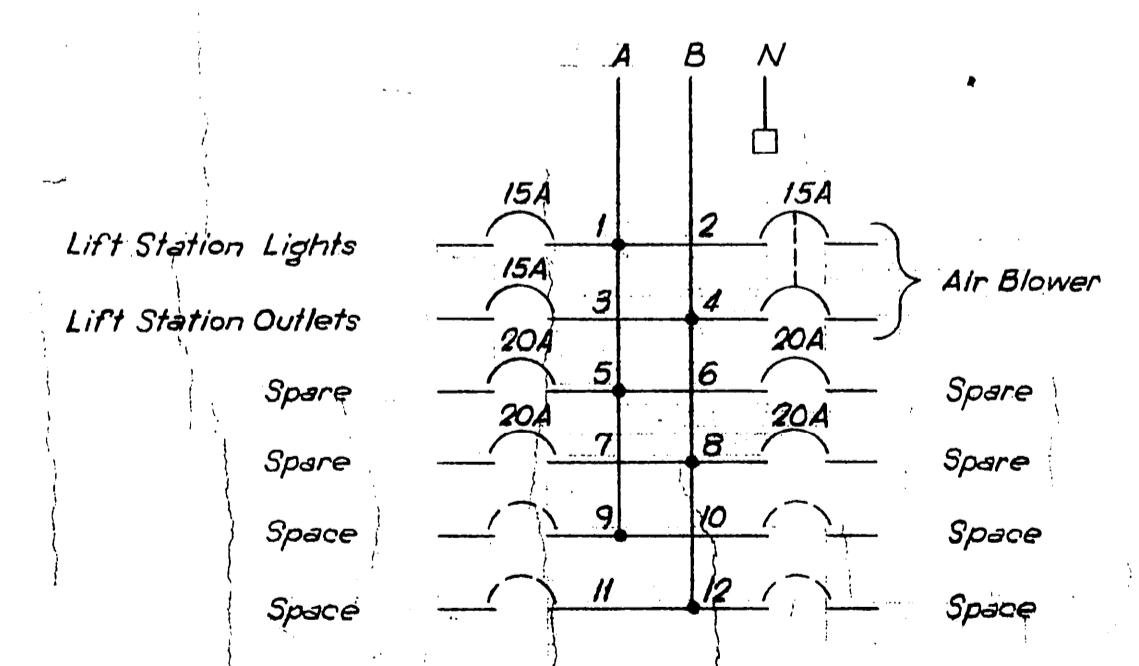

LIGHTING PANEL

REVISED AS BUILT
DATE AUG. 1972

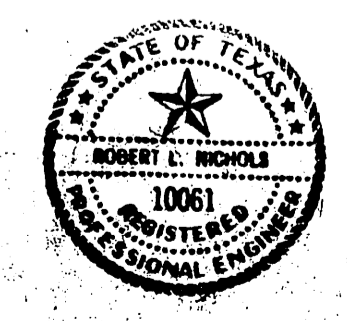

ROCKWALL, TEXAS
SEWER SYSTEM IMPROVEMENTS
LAKESIDE VILLAGE OUTFALL
LIFT STATION ELECTRICAL

DESIGNED: W R F
DRAWN: J W W
TRACED: W R F
CHECKED: W R F

FREES, NICHOLS & ENDRESS
CONSULTING ENGINEERS
FORT WORTH, TEXAS