



ELECTRICAL SITE PLAN
SCALE: 1"=10'

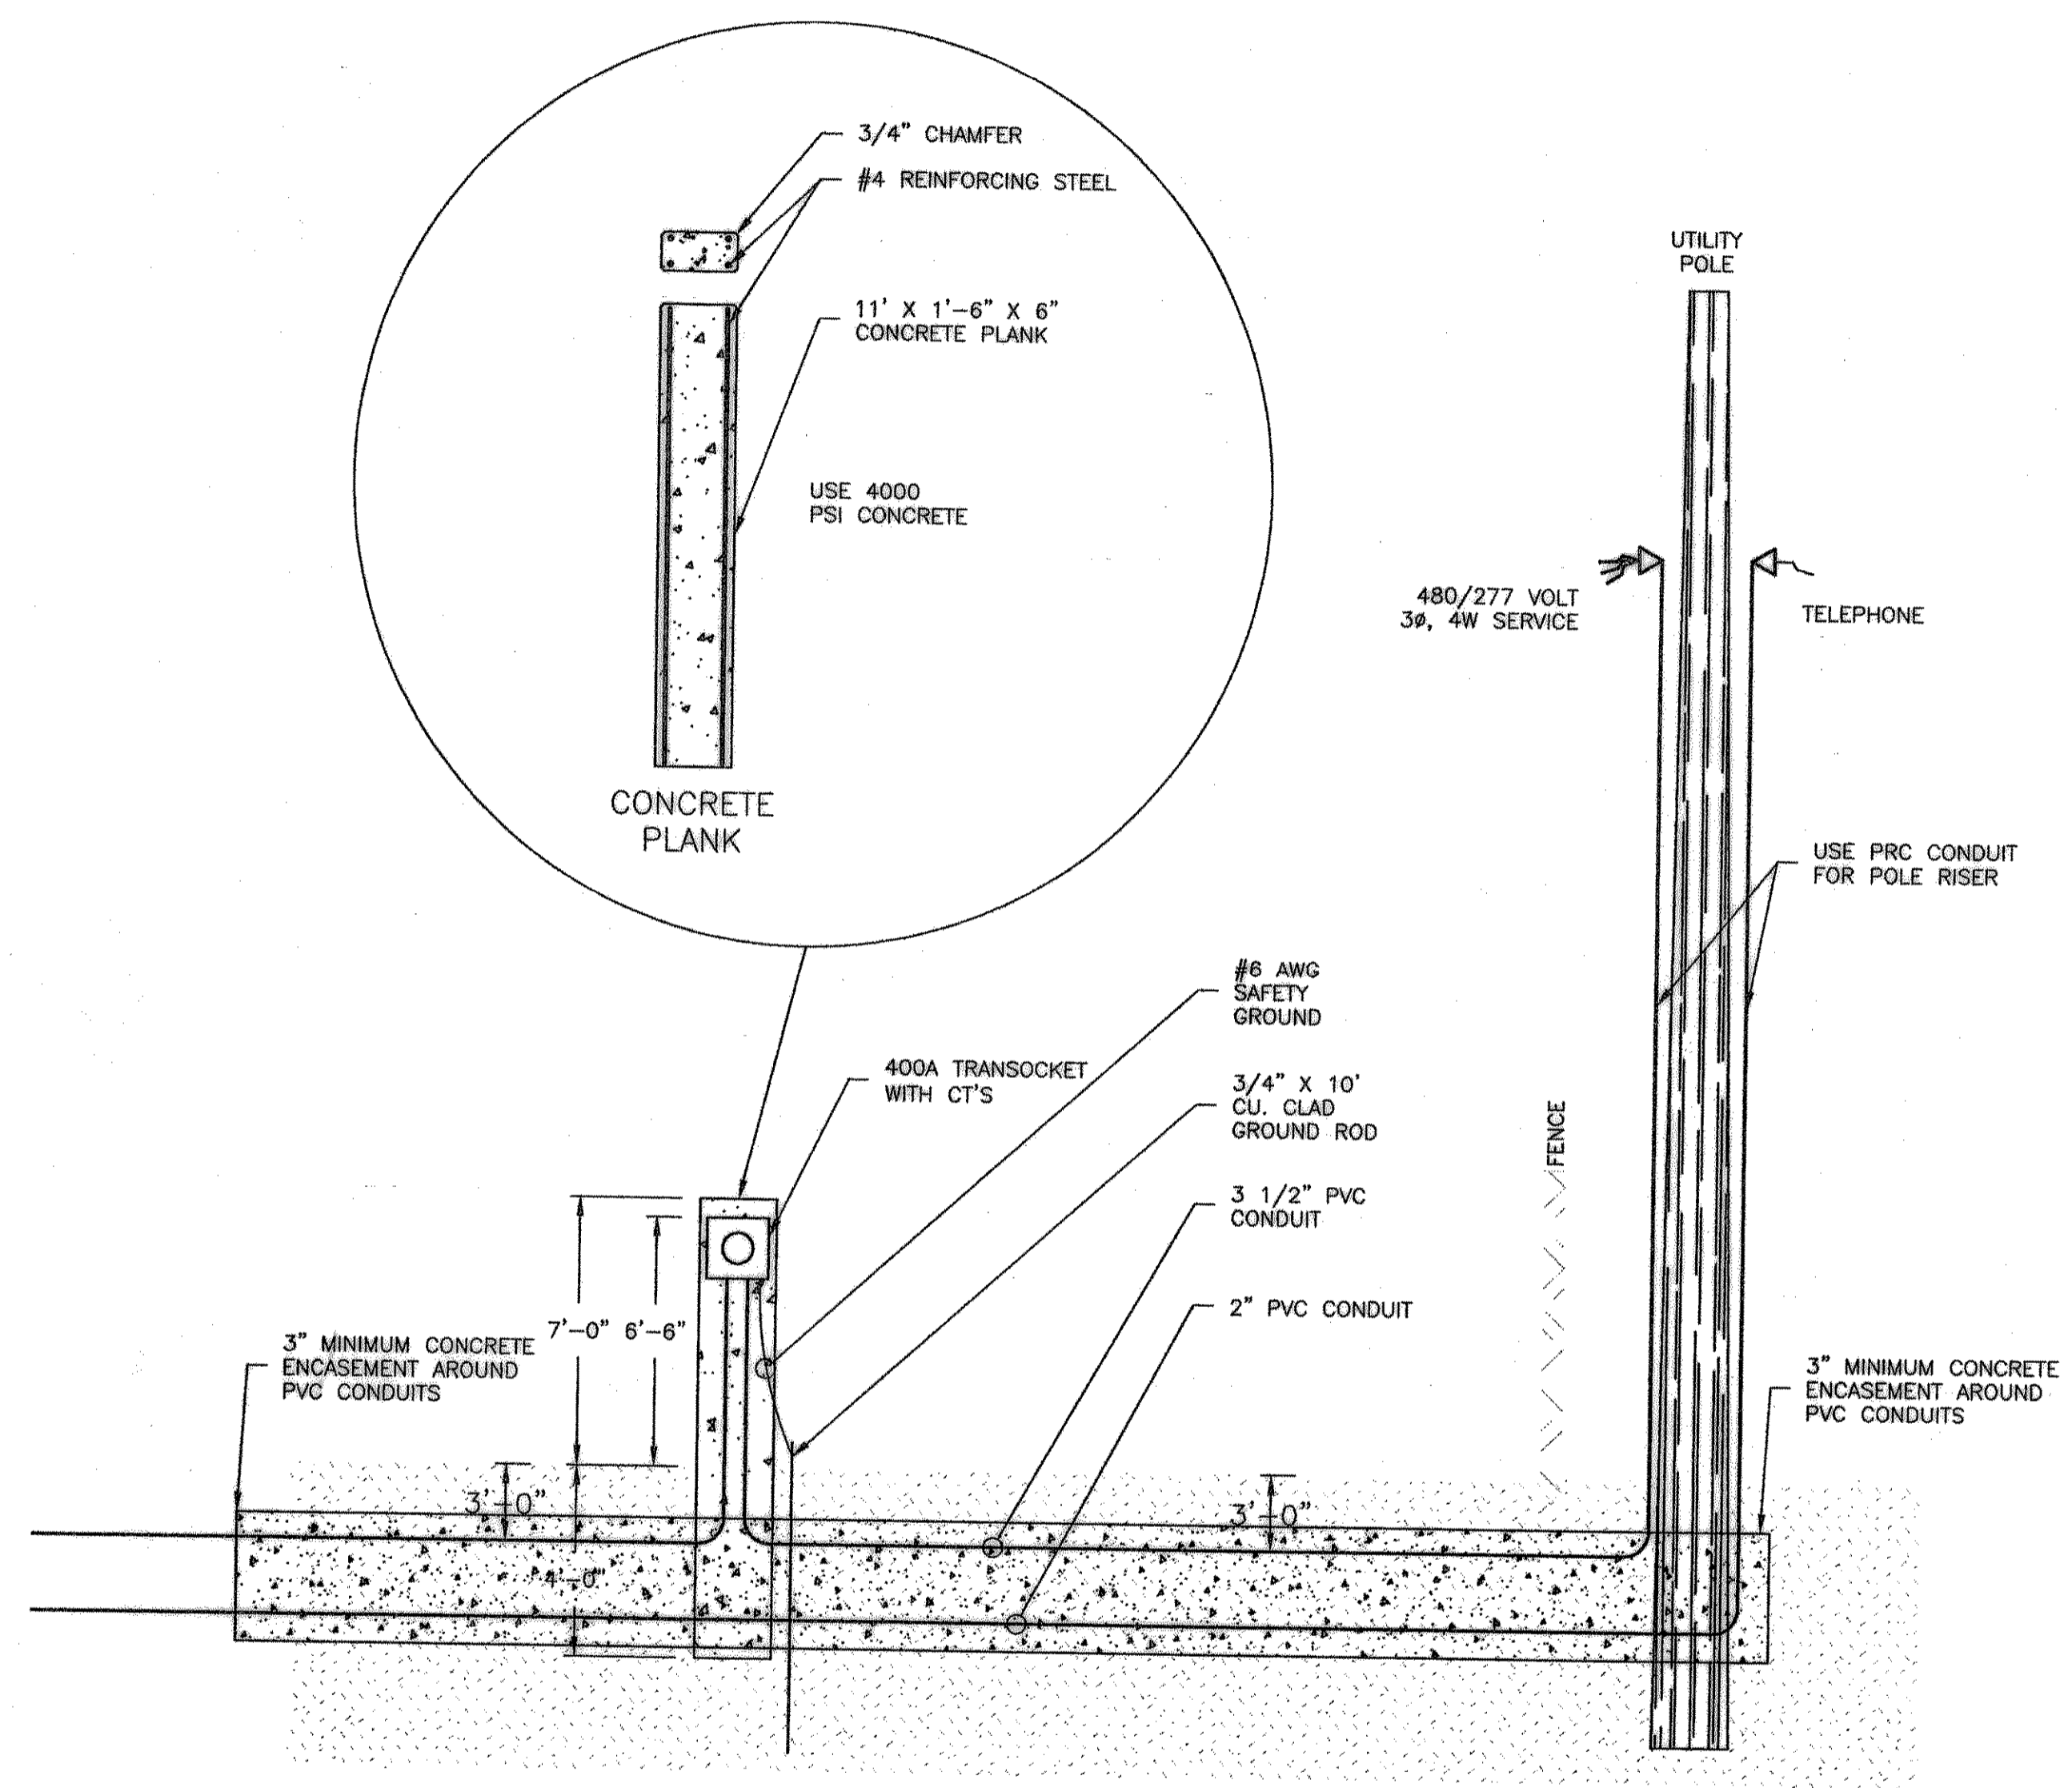

PARTIAL SITE PLAN ELEVATION
NOT TO SCALE

RECORD DRAWINGS:
THE INTENT OF THE OWNER AND ENGINEER WAS TO CONSTRUCT THESE FACILITIES ACCORDING TO THESE PLANS AS APPROVED BY THE CITY OF Rockwall. THE LINES AND GRADES WERE SET ON THE GROUND FOR CONSTRUCTION ACCORDING TO SAID PLANS. THE CITY OF Rockwall INSPECTED THE CONSTRUCTION. THE OWNER NOR ENGINEER DID NOT VERIFY LINES OR GRADES AFTER CONSTRUCTION. WE ARE NOT AWARE OF ANY CHANGES OR REVISIONS TO THESE PLANS DURING CONSTRUCTION EXCEPT AS NOTED.

CHI
CAMPOS ENGINEERING, Inc.
7430 Greenhill Avenue
Dallas, Texas 75231
(214) 891-6898 (Fax)
E-MAIL: campos@camposengineering.com
PROJECT NO: 04399.00

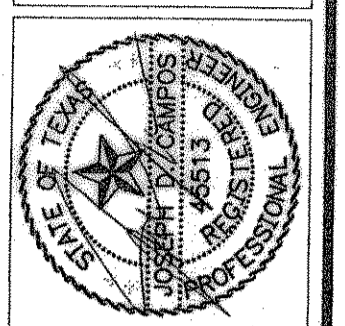

THE SEAL APPEARING ON THIS DOCUMENT WAS AUTHORIZED BY JOSEPH D. CAMPOS TEXAS P.E. NO. 45513 ON 1-17-00
1/19/08

DOUPHRATE & ASSOCIATES, INC.
ENGINEERING • PROJECT MANAGEMENT • SURVEYING
2231 RIDGE RD., # 200 ROCKWALL, TEXAS 75087
PHONE: (972)771-9004 FAX: (972)771-9005

ELECTRICAL SITE PLAN

REVISION
WLD. CHECKED
KEB. DRAWN
1/28/08 DATE
072MA PROJECT

E2