


Plans for NORTH LAKESHORE DRIVE LIFT STATION

LOCATED AT THE NORTHWEST CORNER OF
STATE HIGHWAY 205 AND NORTH LAKESHORE DRIVE
IN
THE CITY OF ROCKWALL,
ROCKWALL COUNTY, TEXAS


JANUARY 2009

INDEX OF SHEETS

SHEET NO.	DESCRIPTION	REV.
1	COVER SHEET	
G1	LIFT STATION GENERAL NOTES	
G2	SANITARY SEWER DRAINAGE AREA CALCULATIONS	
LS1	LIFT STATION SITE PLAN, DIMENSION CONTROL & PAVING PLAN	1, 2, 3
LS2	LIFT STATION DETAILS	
LS3	FORCE MAIN PLAN AND PROFILE	1
LS4	FORCE MAIN PLAN AND PROFILE	
LS5	LIFT STATION STRUCTURAL DETAILS	
D1	CONSTRUCTION DETAILS	
D2	CONSTRUCTION DETAILS	1
LS-E0.1	ELECTRICAL SITE PLAN	1
LS-E0.2	ELECTRICAL SITE PLAN DETAILS	1
LS-E0.3	ELECTRICAL SCHEDULES NOTES AND SPECIFICATIONS	1

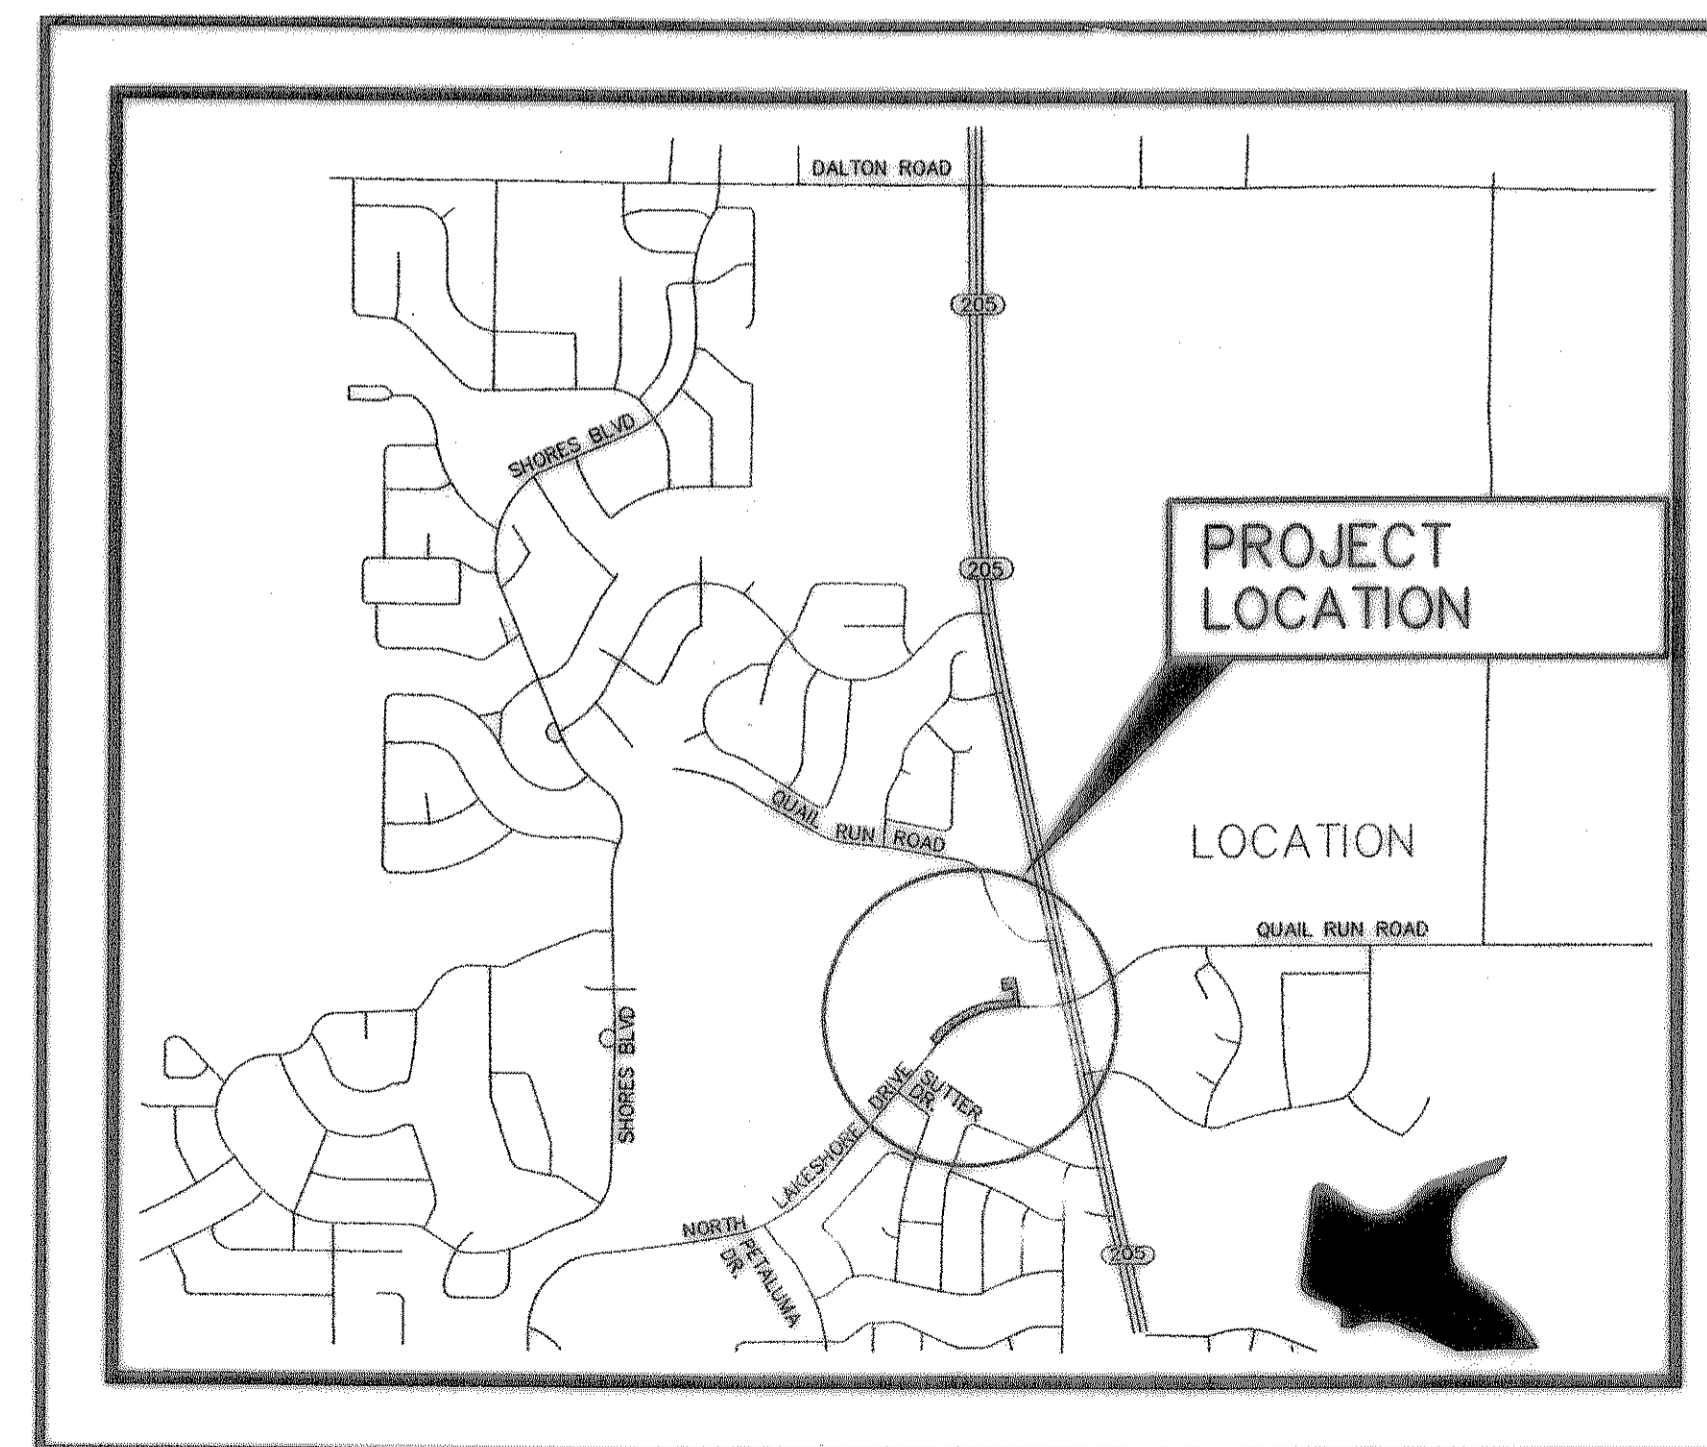

LOCATION MAP

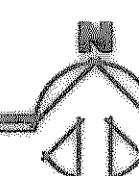

DEVELOPER:

SALVO REAL ESTATE SOLUTIONS

5005 LBJ Freeway (Loop 635)

Suite 840

Dallas, Texas 75244

Contact : Craig Pincince

Ph. (972) 331-2065

RECORD DRAWING

THIS RECORD DRAWING HEREIN REFLECTS TO THE BEST OF THE DESIGN ENGINEER'S KNOWLEDGE, THE APPROXIMATE LOCATION OF THE CONSTRUCTED WORK, USING INFORMATION AS PROVIDED BY THE CONTRACTORS



**Kimley-Horn
and Associates, Inc.**
12700 Park Central Dr. Suite 1800, Dallas, TX 75281 972-770-1900