
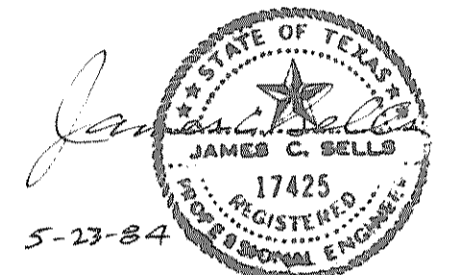


Scale: 1" = 40'

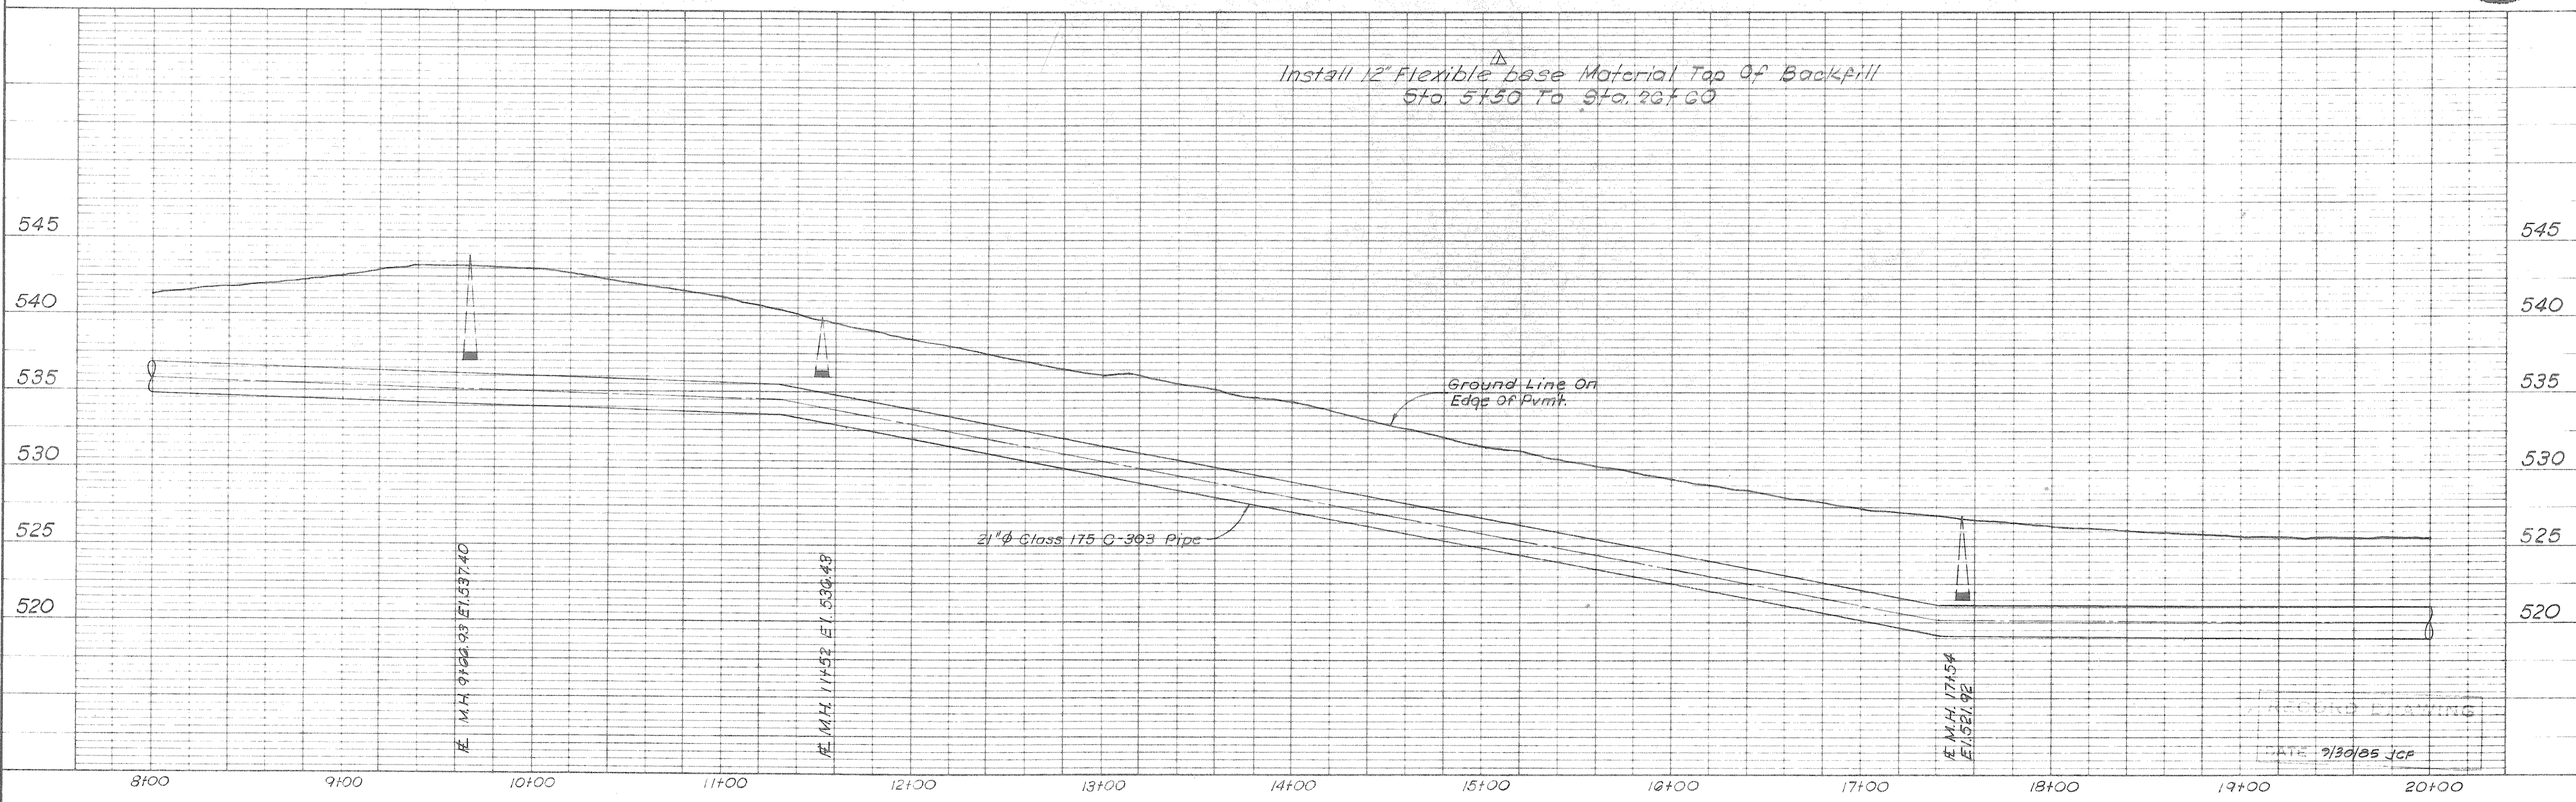

7-2-84 7-3-84 DATE	10" Embedment Material Changed to Flexible Base 13" #1 Rebar and Property Lines Added REVISION	DESIGNED J.S.S. DRAWN J.C.C. TRACED J.C.S. CHECKED T.A.R.	JOB NO. NTD 830998 DATE 1984 SCALE AS SHOWN	FREESE AND NICHOLS CONSULTING ENGINEERS FORT WORTH-AUSTIN, TEXAS	NORTH TEXAS MUNICIPAL WATER DISTRICT WATER TRANSMISSION SYSTEM	ROCKWALL STATION TO CASH PIPELINE PLAN AND PROFILE	SHEET 3 OF 11
--------------------------	--	--	---	--	---	---	------------------