
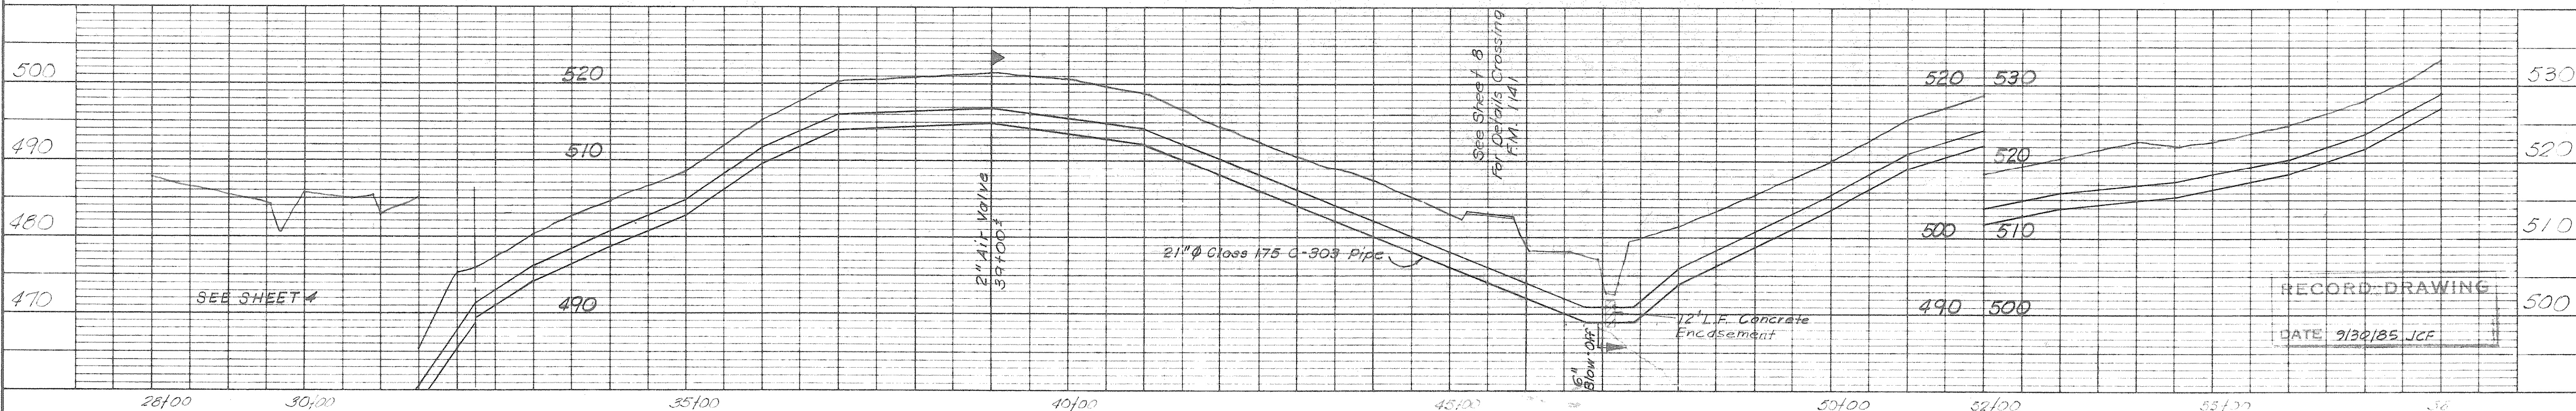
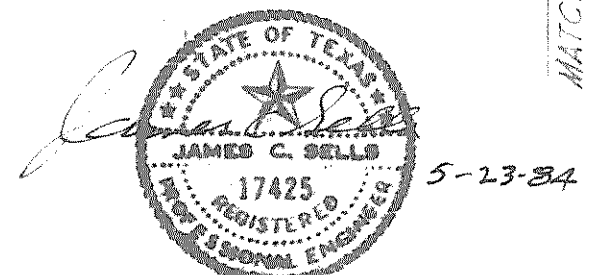
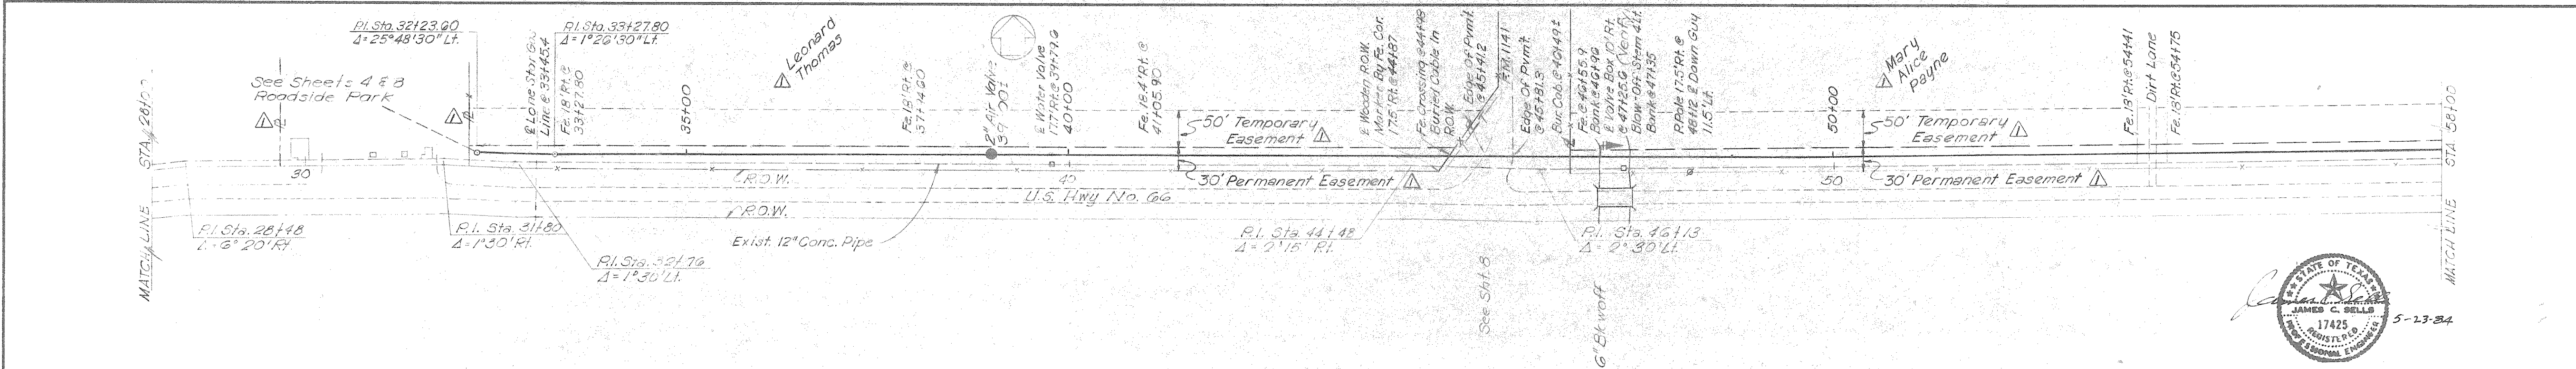
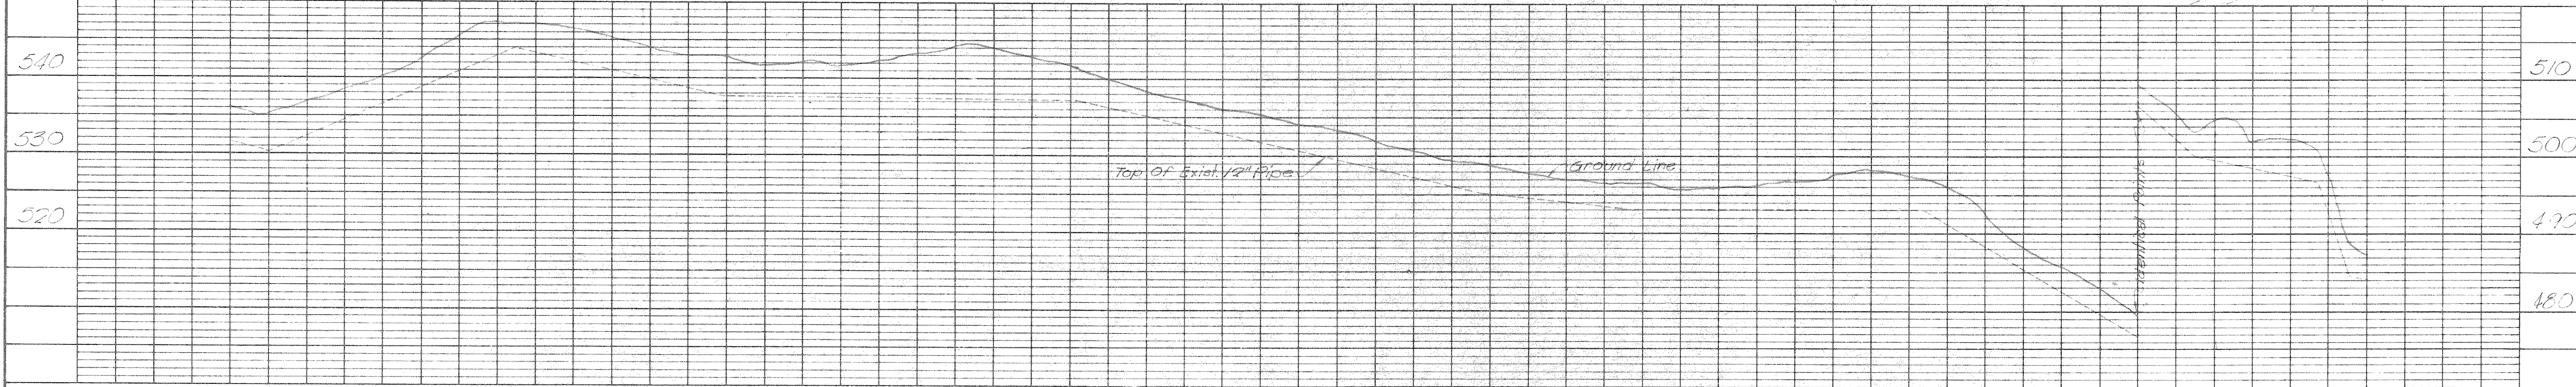


SEE SHEET 4
For Proposed 21" ϕ Pipeline

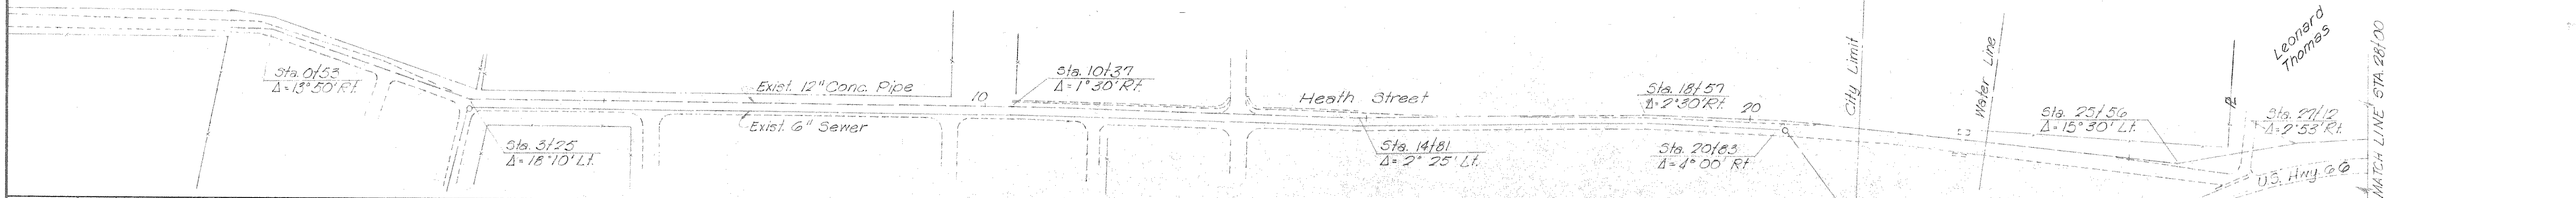

RECORD DRAWING
DATE 9/30/85 JCF

DESIGNED <u>JCS</u> DRAWN <u>DS</u> TRACED <u>JAR</u> CHECKED <u>JCS</u>	JOB NO. <u>NTD 83099B</u> DATE <u>AS SHOWN</u> SCALE <u>AS SHOWN</u>	FREESE AND NICHOLS CONSULTING ENGINEERS FORT WORTH - AUSTIN, TEXAS	NORTH TEXAS MUNICIPAL WATER DISTRICT WATER TRANSMISSION SYSTEM	ROCKWALL STATION TO CASH PIPELINE PLAN AND PROFILE	SHEET 5 OF 11
---	--	--	---	---	------------------