


S. KING SURVEY
ABSTRACT NO. 131
GRANVILLE DAVIS


S. KING SURVEY
ABSTRACT NO. 131
GRANVILLE DAVIS

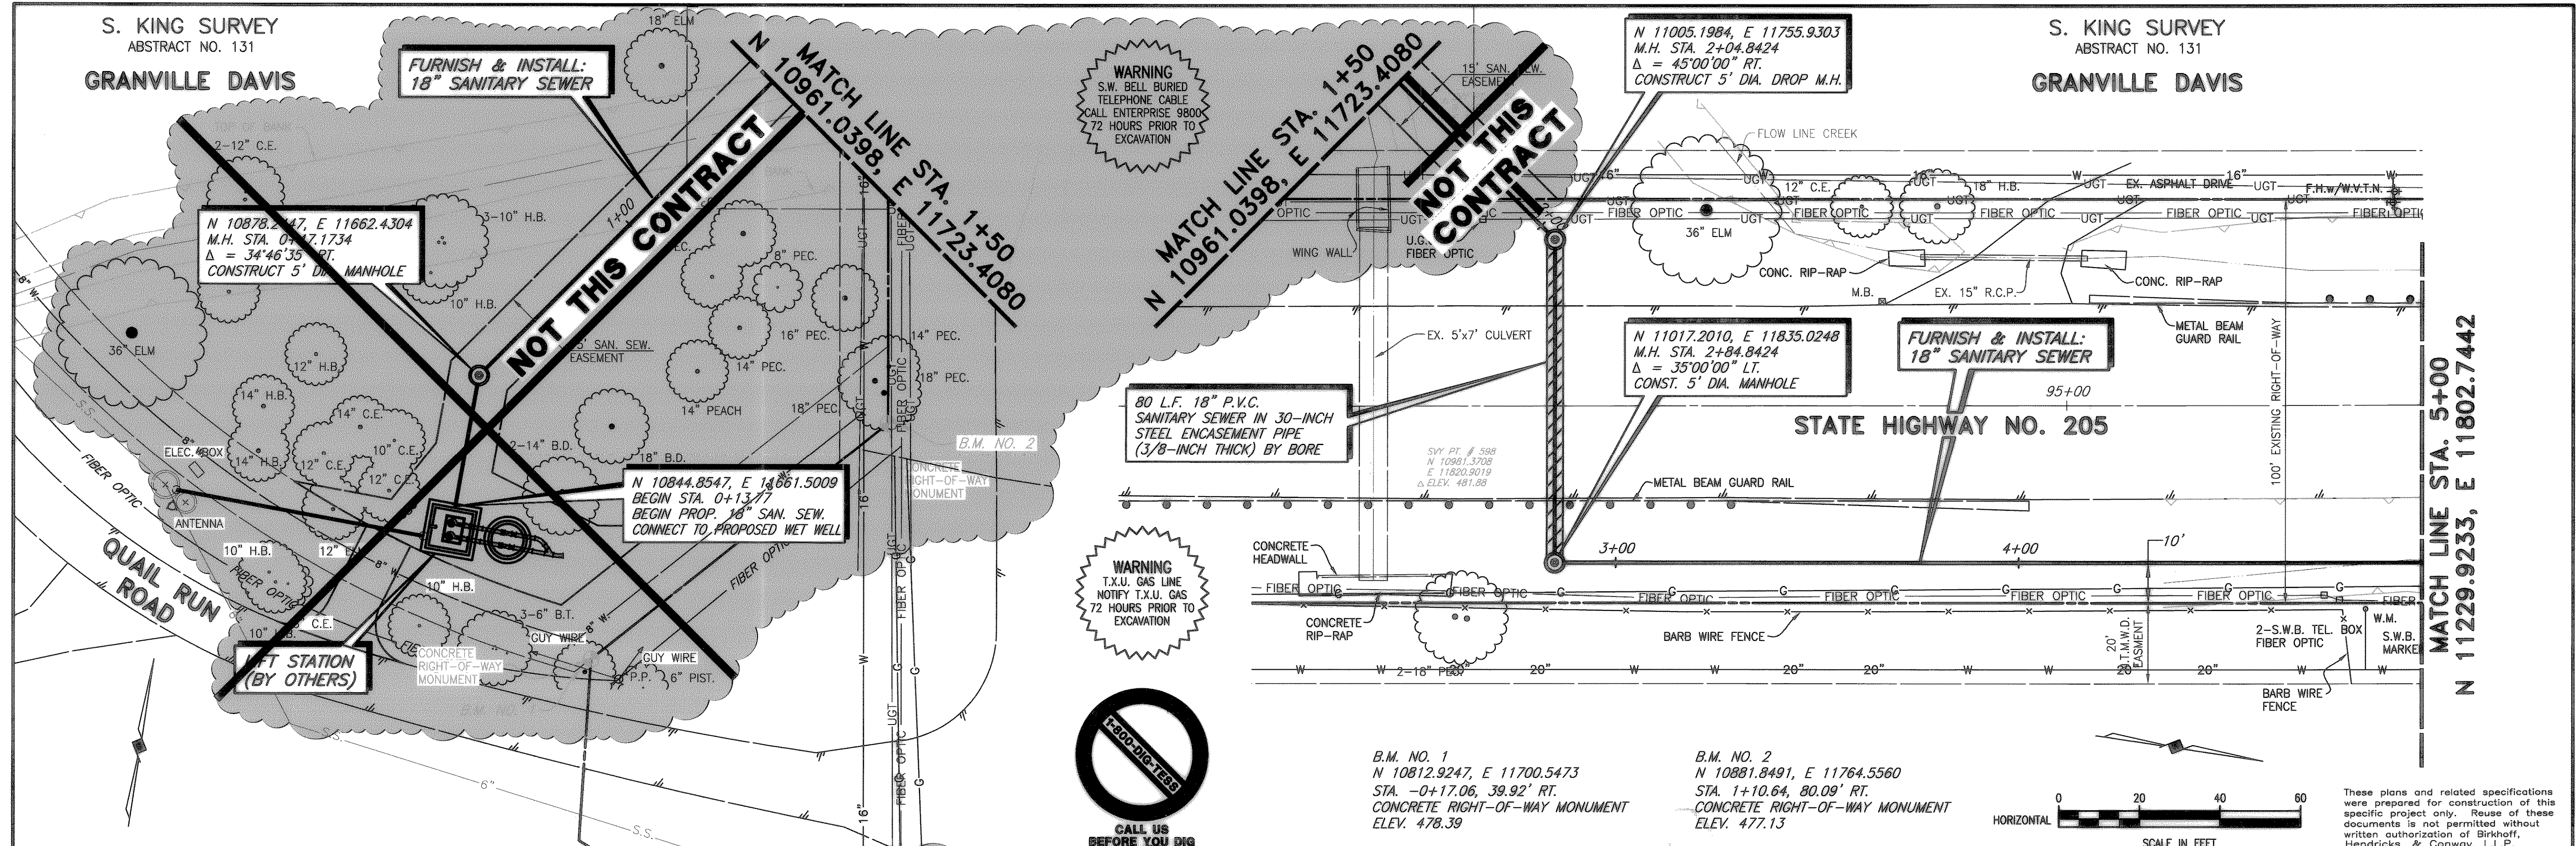


NO DIGGING
CALL US BEFORE YOU DIG

WARNING
S.W. BELL BURIED TELEPHONE CABLE
CALL ENTERPRISE 9800
72 HOURS PRIOR TO EXCAVATION

WARNING
T.X.U. GAS LINE
NOTIFY T.X.U. GAS
72 HOURS PRIOR TO EXCAVATION

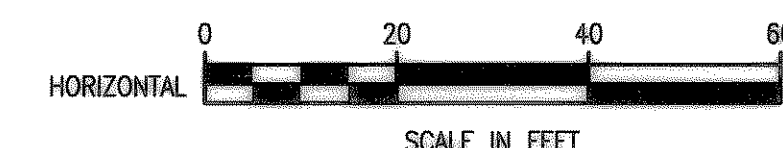


These plans and related specifications were prepared for construction of this specific project only. Reuse of these documents is not permitted without written authorization of Birkhoff, Hendricks, & Conway, L.L.P.

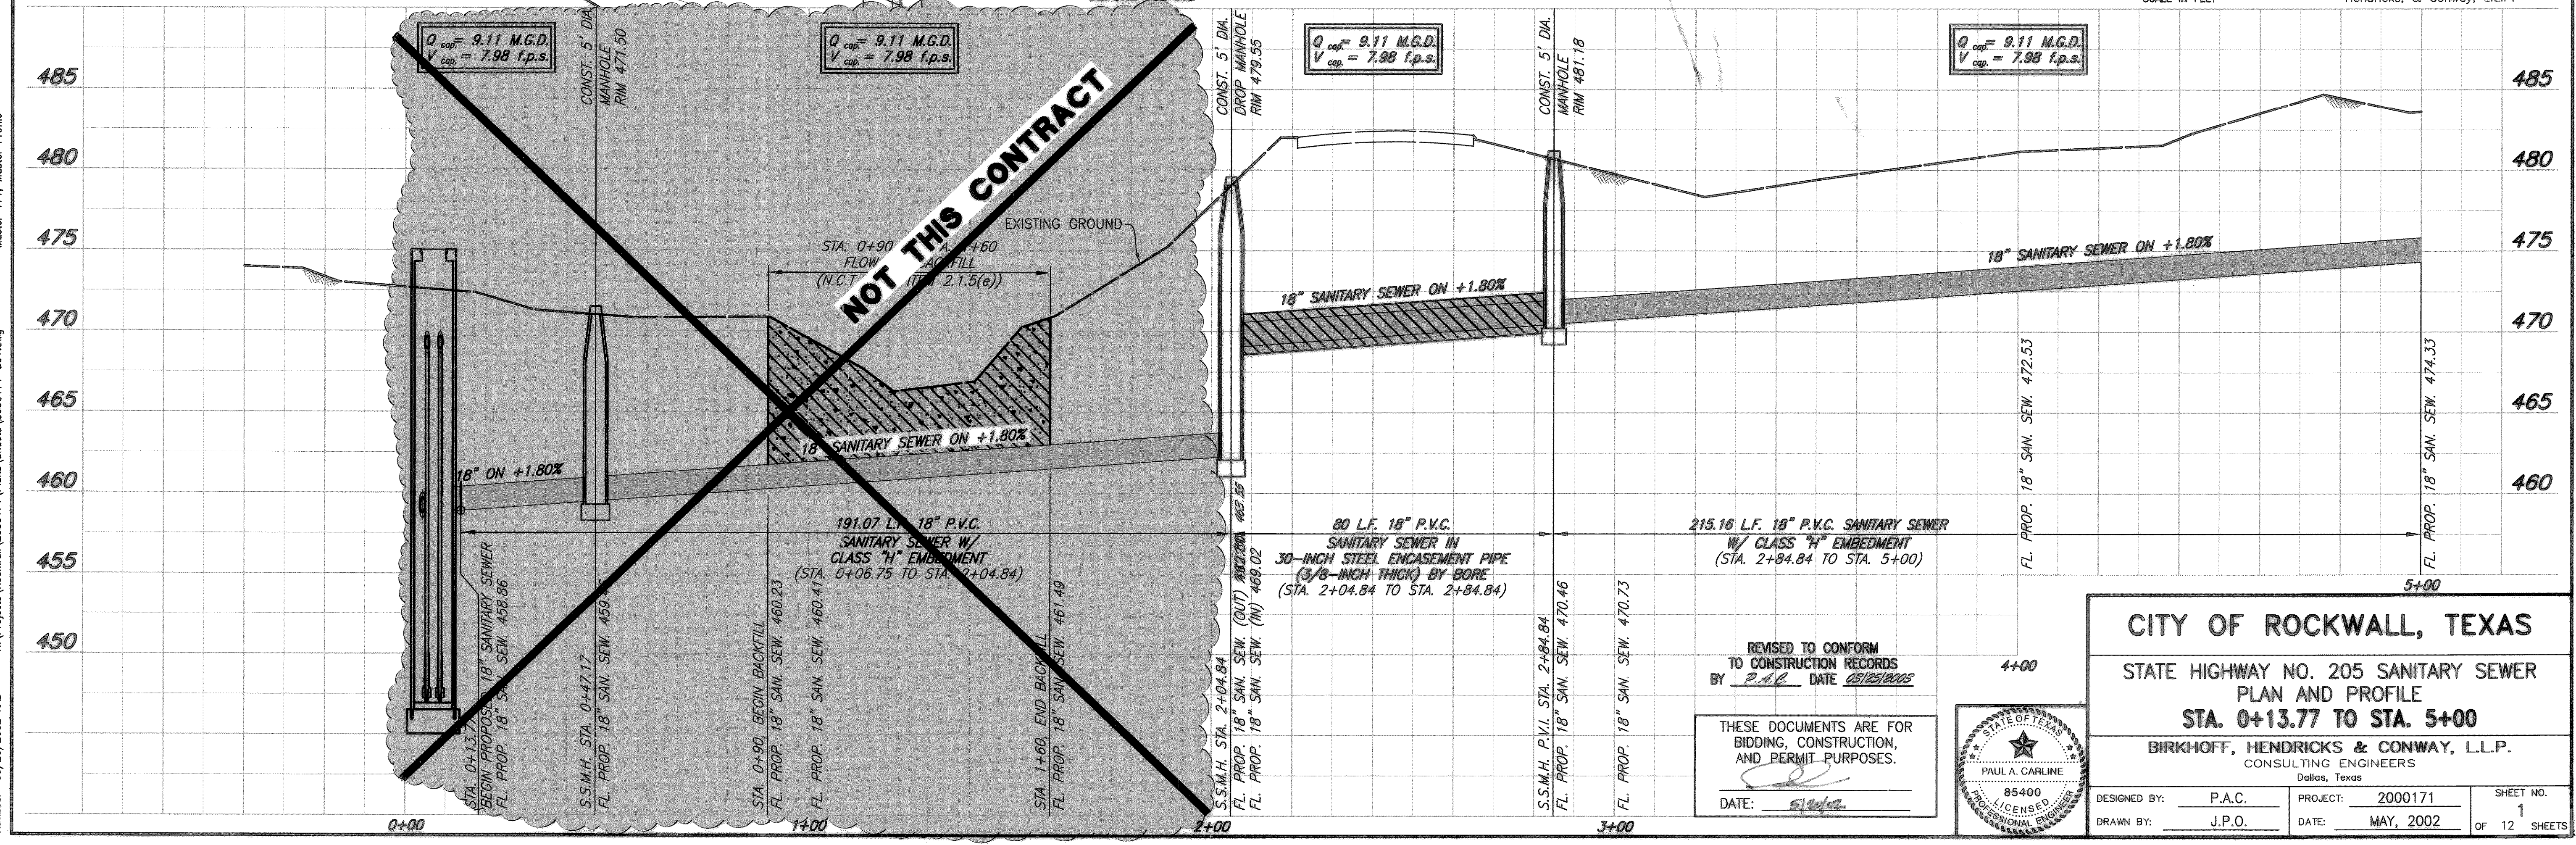

REVISED TO CONFORM TO CONSTRUCTION RECORDS BY P.A.C. DATE 05/25/2002

THESE DOCUMENTS ARE FOR BIDDING, CONSTRUCTION, AND PERMIT PURPOSES.
DATE: 5/20/02

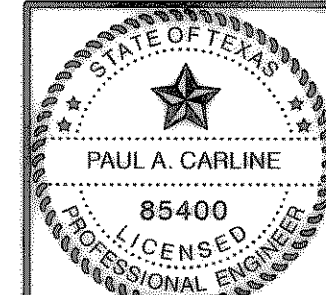

CITY OF ROCKWALL, TEXAS
STATE HIGHWAY NO. 205 SANITARY SEWER PLAN AND PROFILE
STA. 0+13.77 TO STA. 5+00
BIRKHOFF, HENDRICKS & CONWAY, L.L.P.
CONSULTING ENGINEERS
Dallas, Texas

DESIGNED BY: P.A.C.	PROJECT: 2000171	SHEET NO. 1
DRAWN BY: J.P.O.	DATE: MAY, 2002	OF 12 SHEETS

Revised: 05/20/2002 KAB
 H:\Projects\Rockwall\2000171\Plans\Sheets\2000171-501.dwg
 Master 171, Master Profile