


LEGEND	
●	IRON ROD
○	STORM MANHOLE
⚡	POWER POLE
⊕	WATER VALVE
⊠	TRAFFIC SIGNAL CONTROL BOX
⊙	TRAFFIC LIGHT
⊗	WATER METER
⊕	LIGHT STANDARD
⊖	SIGN
⊞	ELECTRIC BOX
⊚	FIRE HYDRANT
⊛	GUY WIRE
⊜	TELEPHONE BOX
⊝	SANITARY MANHOLE
⊞	POST
⊚	GROUND LIGHT
⊛	MONUMENT
⊜	SPRINKLER HEAD
⊝	GAS METER
⊞	GAS VALVE
⊚	IRON PIPE
⊛	CLEAN OUT
⊜	GRATE INLET
⊝	MAILBOX
⊞	TELEPHONE MANHOLE

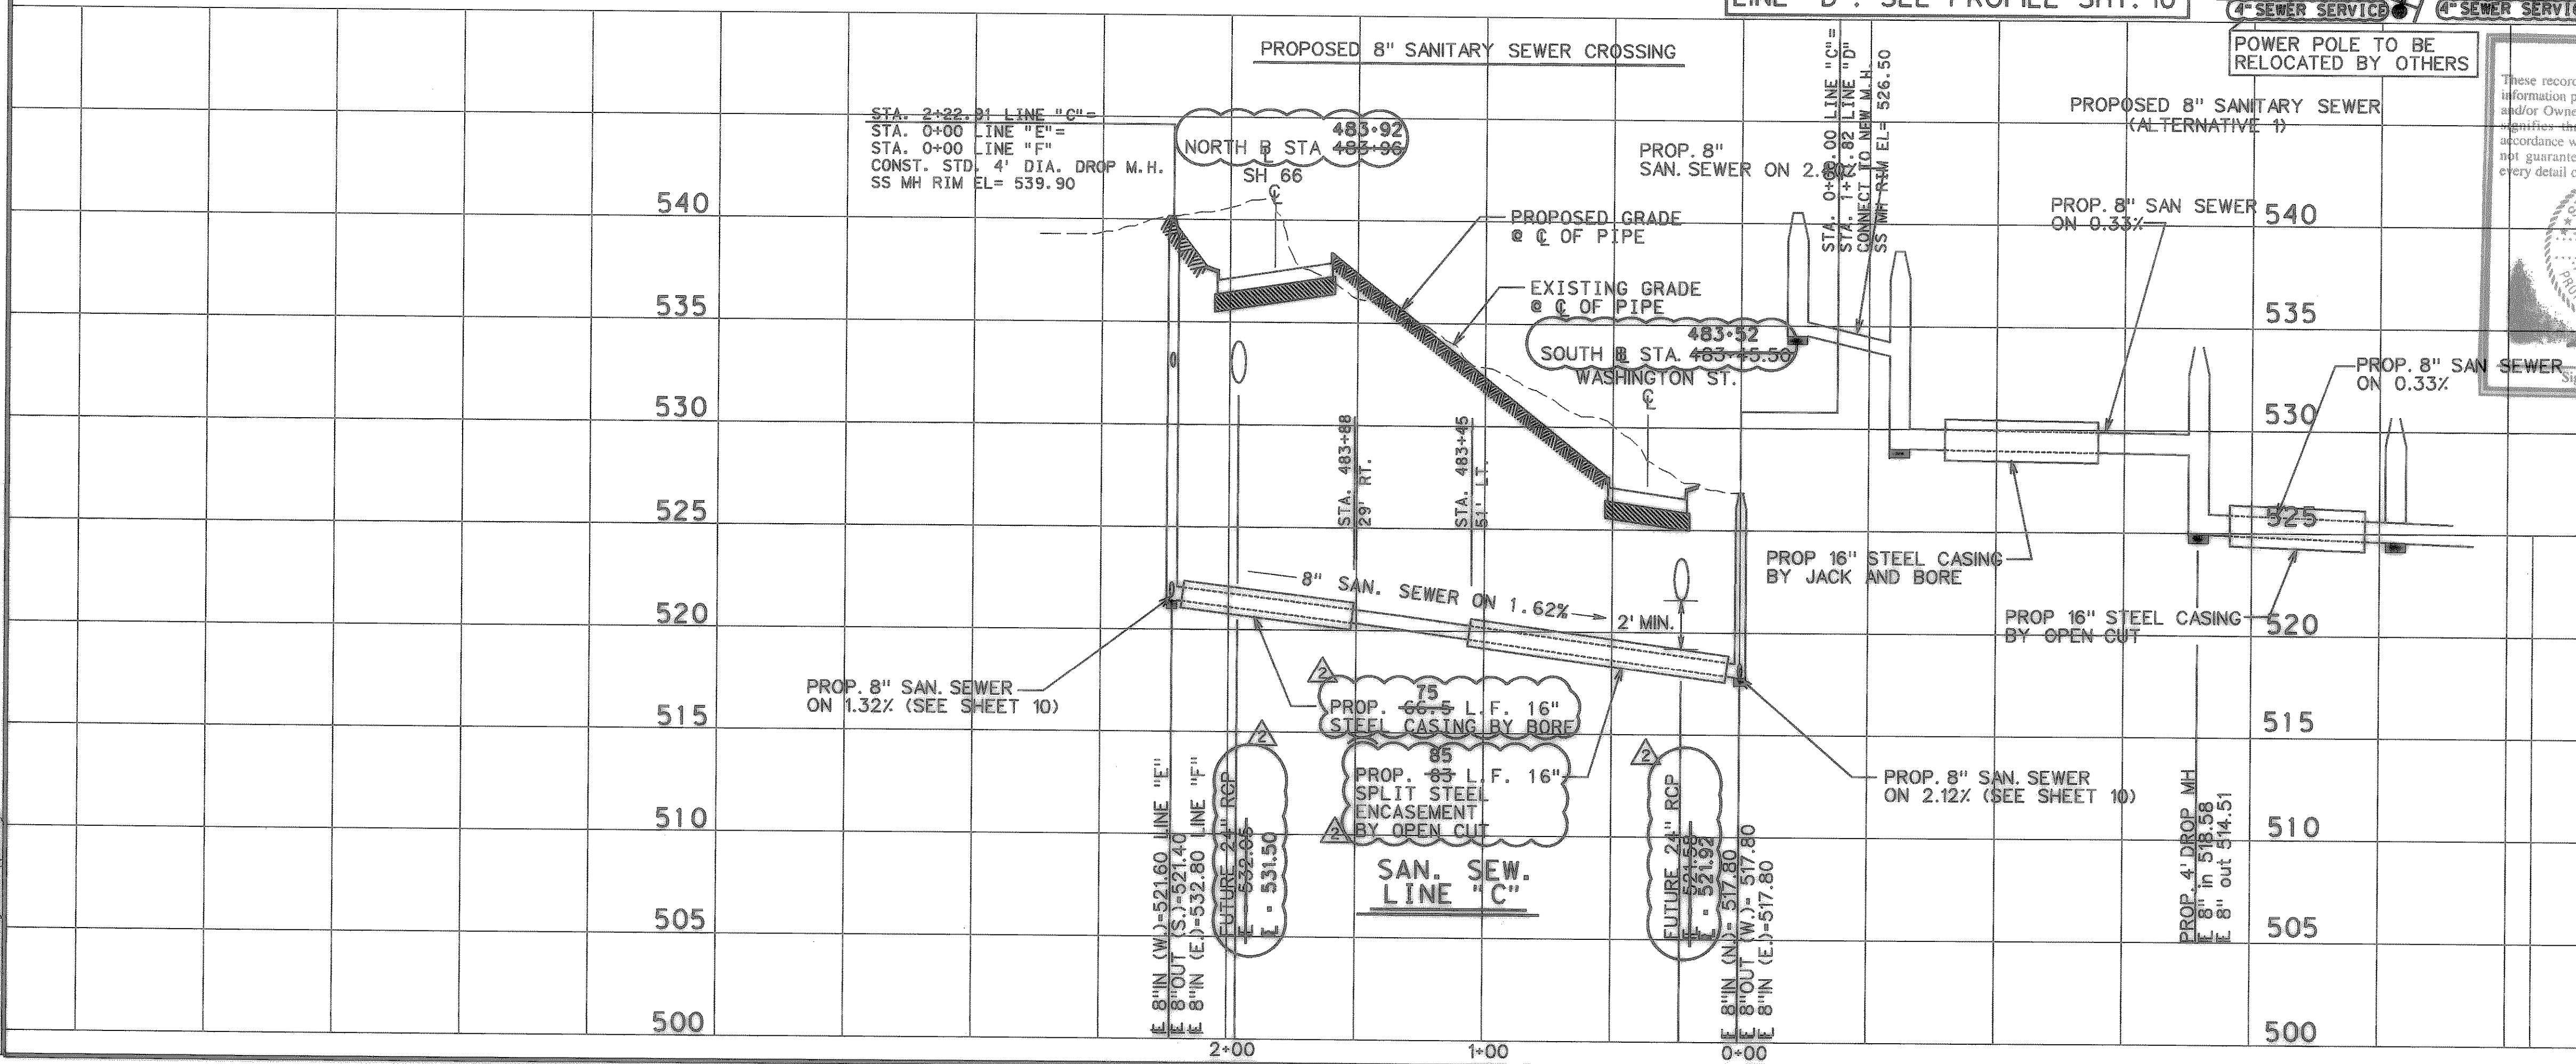

RECORD DRAWINGS  
 These record drawings have been prepared using information provided by the Construction Contractor and/or Owner. The seal and signature below only signify that the plans have been reviewed in accordance with the information provided and does not guarantee that these plans accurately show every detail of the construction project.

STATE OF TEXAS  
 REGISTERED PROFESSIONAL ENGINEER  
 TED B. SUGG  
 82775  
 12-10-02  
 Signature Date

UNDERGROUND UTILITIES  
 THE LOCATION OF EXISTING UTILITIES SHOWN ON THESE PLANS ARE APPROXIMATE AND BASED ON DATA FURNISHED BY UTILITY COMPANIES. IT IS THE RESPONSIBILITY OF THE CONTRACTOR TO LOCATE AND VERIFY ON-SITE THE UTILITIES THAT MAY CONFLICT WITH THE CONSTRUCTION.

THE SEAL APPEARING ON THIS DOCUMENT WAS AUTHORIZED BY  
 VORANIQUE V. SIMON, P.E. 88381  
 ON 15 AUGUST 2001

REVISED	1	8-1	PRESSURE PIPE ADDED
REVISED	2	8-02	RECORD DRAWINGS

**CITY OF ROCKWALL**  
 "THE NEW HORIZON"

S.H. 66  
 UTILITY RELOCATIONS

UTILITY PLAN AND PROFILE  
 PROPOSED SANITARY  
 SEWER RELOCATIONS

**Turner Collie & Braden Inc.**  
 ENGINEERS • PLANNERS • PROJECT MANAGERS

Unit	A123	Scale:	Horz. 1"=40'	Date	APRIL, 2001
Designed	VVS	Checked	TBS	Job No.	15-98925-300
Drawn	GBA	Approved	RCR		SHEET 8 OF 19

p:\rockwall\sh66\cambas\sh66.dwg