
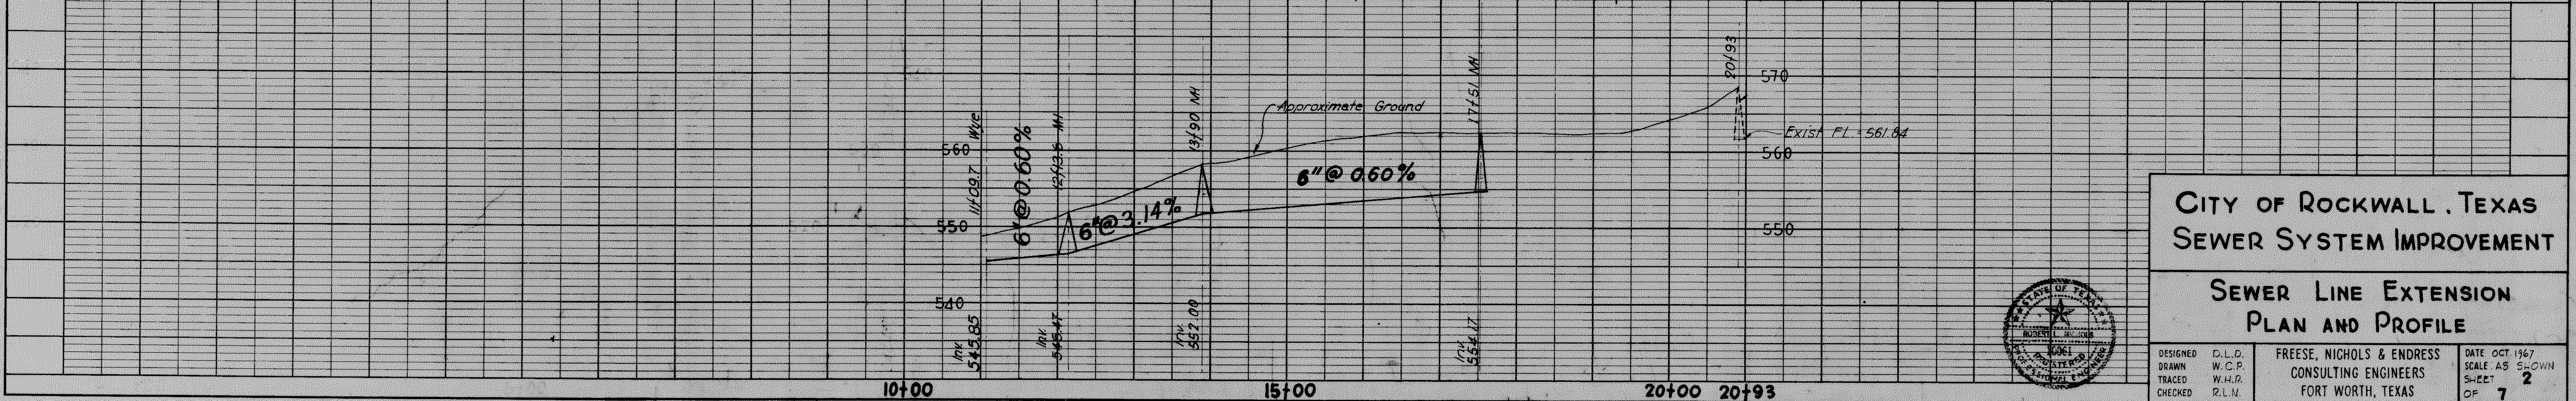
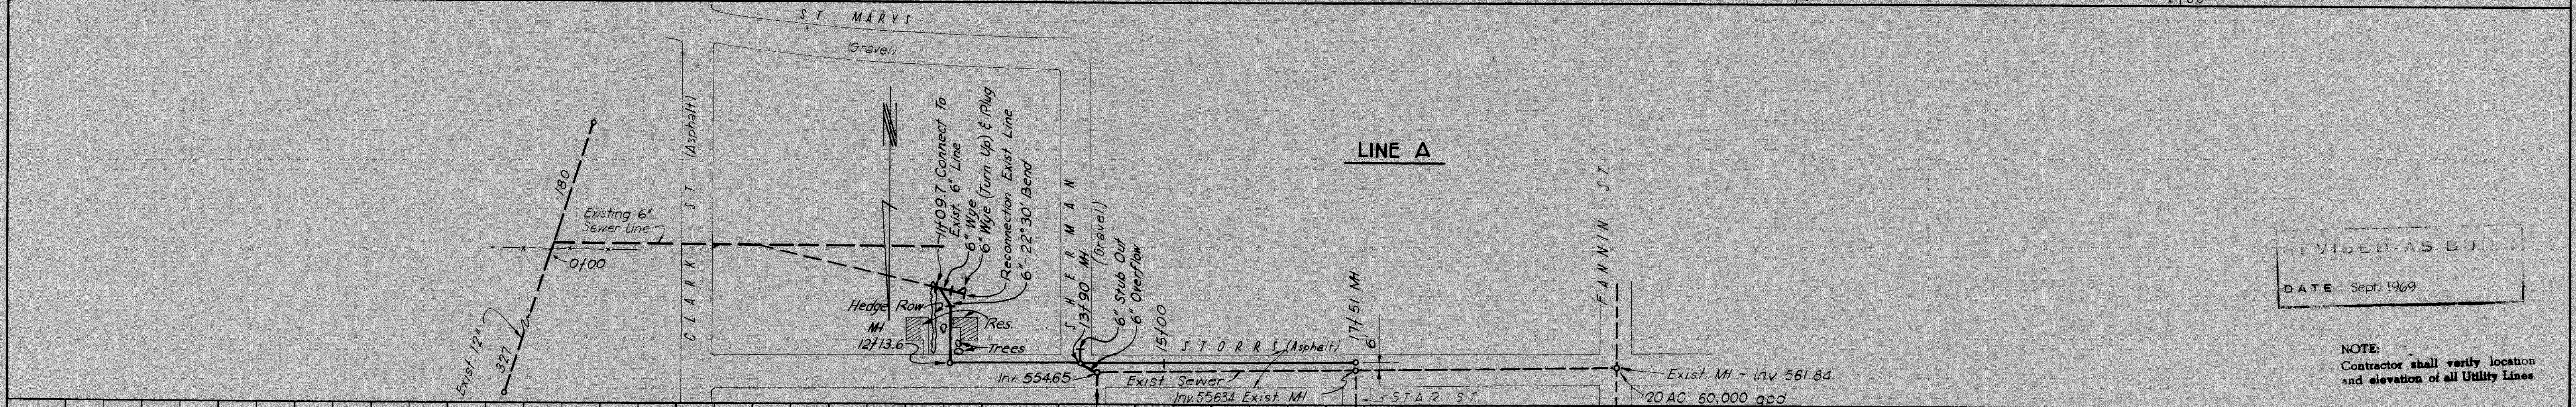
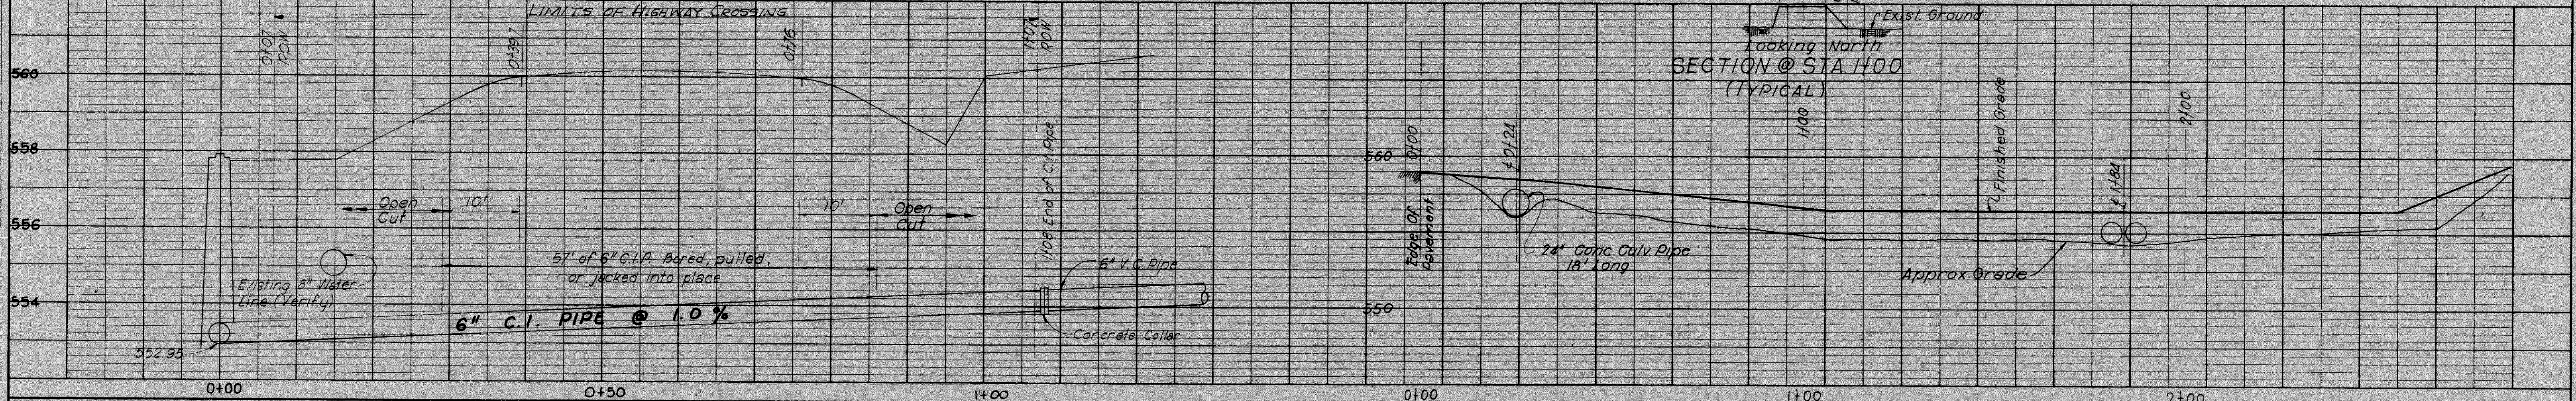


PLAN
 SURVEYED, PLOTTED, CHECKED, NO. BY DATE
 NOTE BOOK ALIGNMENT CHECKED, R.F. OF WY CHECKED, NO.

PROFILE
 SURVEYED, PLOTTED, CHECKED, NO. BY DATE
 NOTE BOOK ELEVATIONS CHECKED, R.F. OF WY CHECKED, NO.

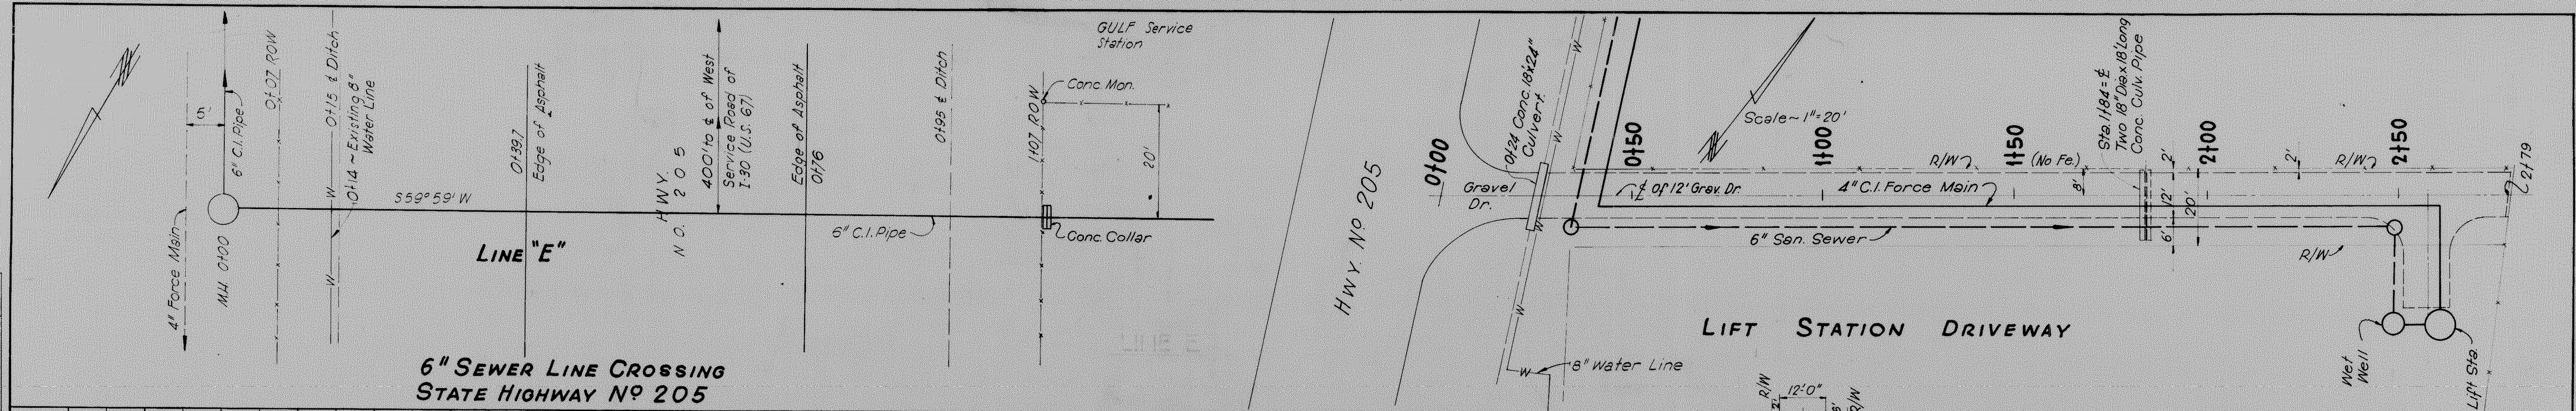

REVISED-AS BUILT
 DATE Sept. 1969

NOTE:
 Contractor shall verify location and elevation of all Utility Lines.

CITY OF ROCKWALL, TEXAS
 SEWER SYSTEM IMPROVEMENT
 SEWER LINE EXTENSION
 PLAN AND PROFILE

DESIGNED BY D.L.D. FREESE, NICHOLS & ENDRESS
 DRAWN BY W.C.P. CONSULTING ENGINEERS
 CHECKED BY R.L.N. FORT WORTH, TEXAS
 DATE OCT 1967
 SCALE AS SHOWN
 SHEET 2 OF 7

