

CITY OF ROCKWALL


" THE NEW HORIZON "

SIGNAL RIDGE

WASTEWATER IMPROVEMENTS

MAYOR
Ken Jones

CITY COUNCIL
Bill Cecil
Ron Coleson
Bob Cotti
John King
Billy Morris
Terry Raulston

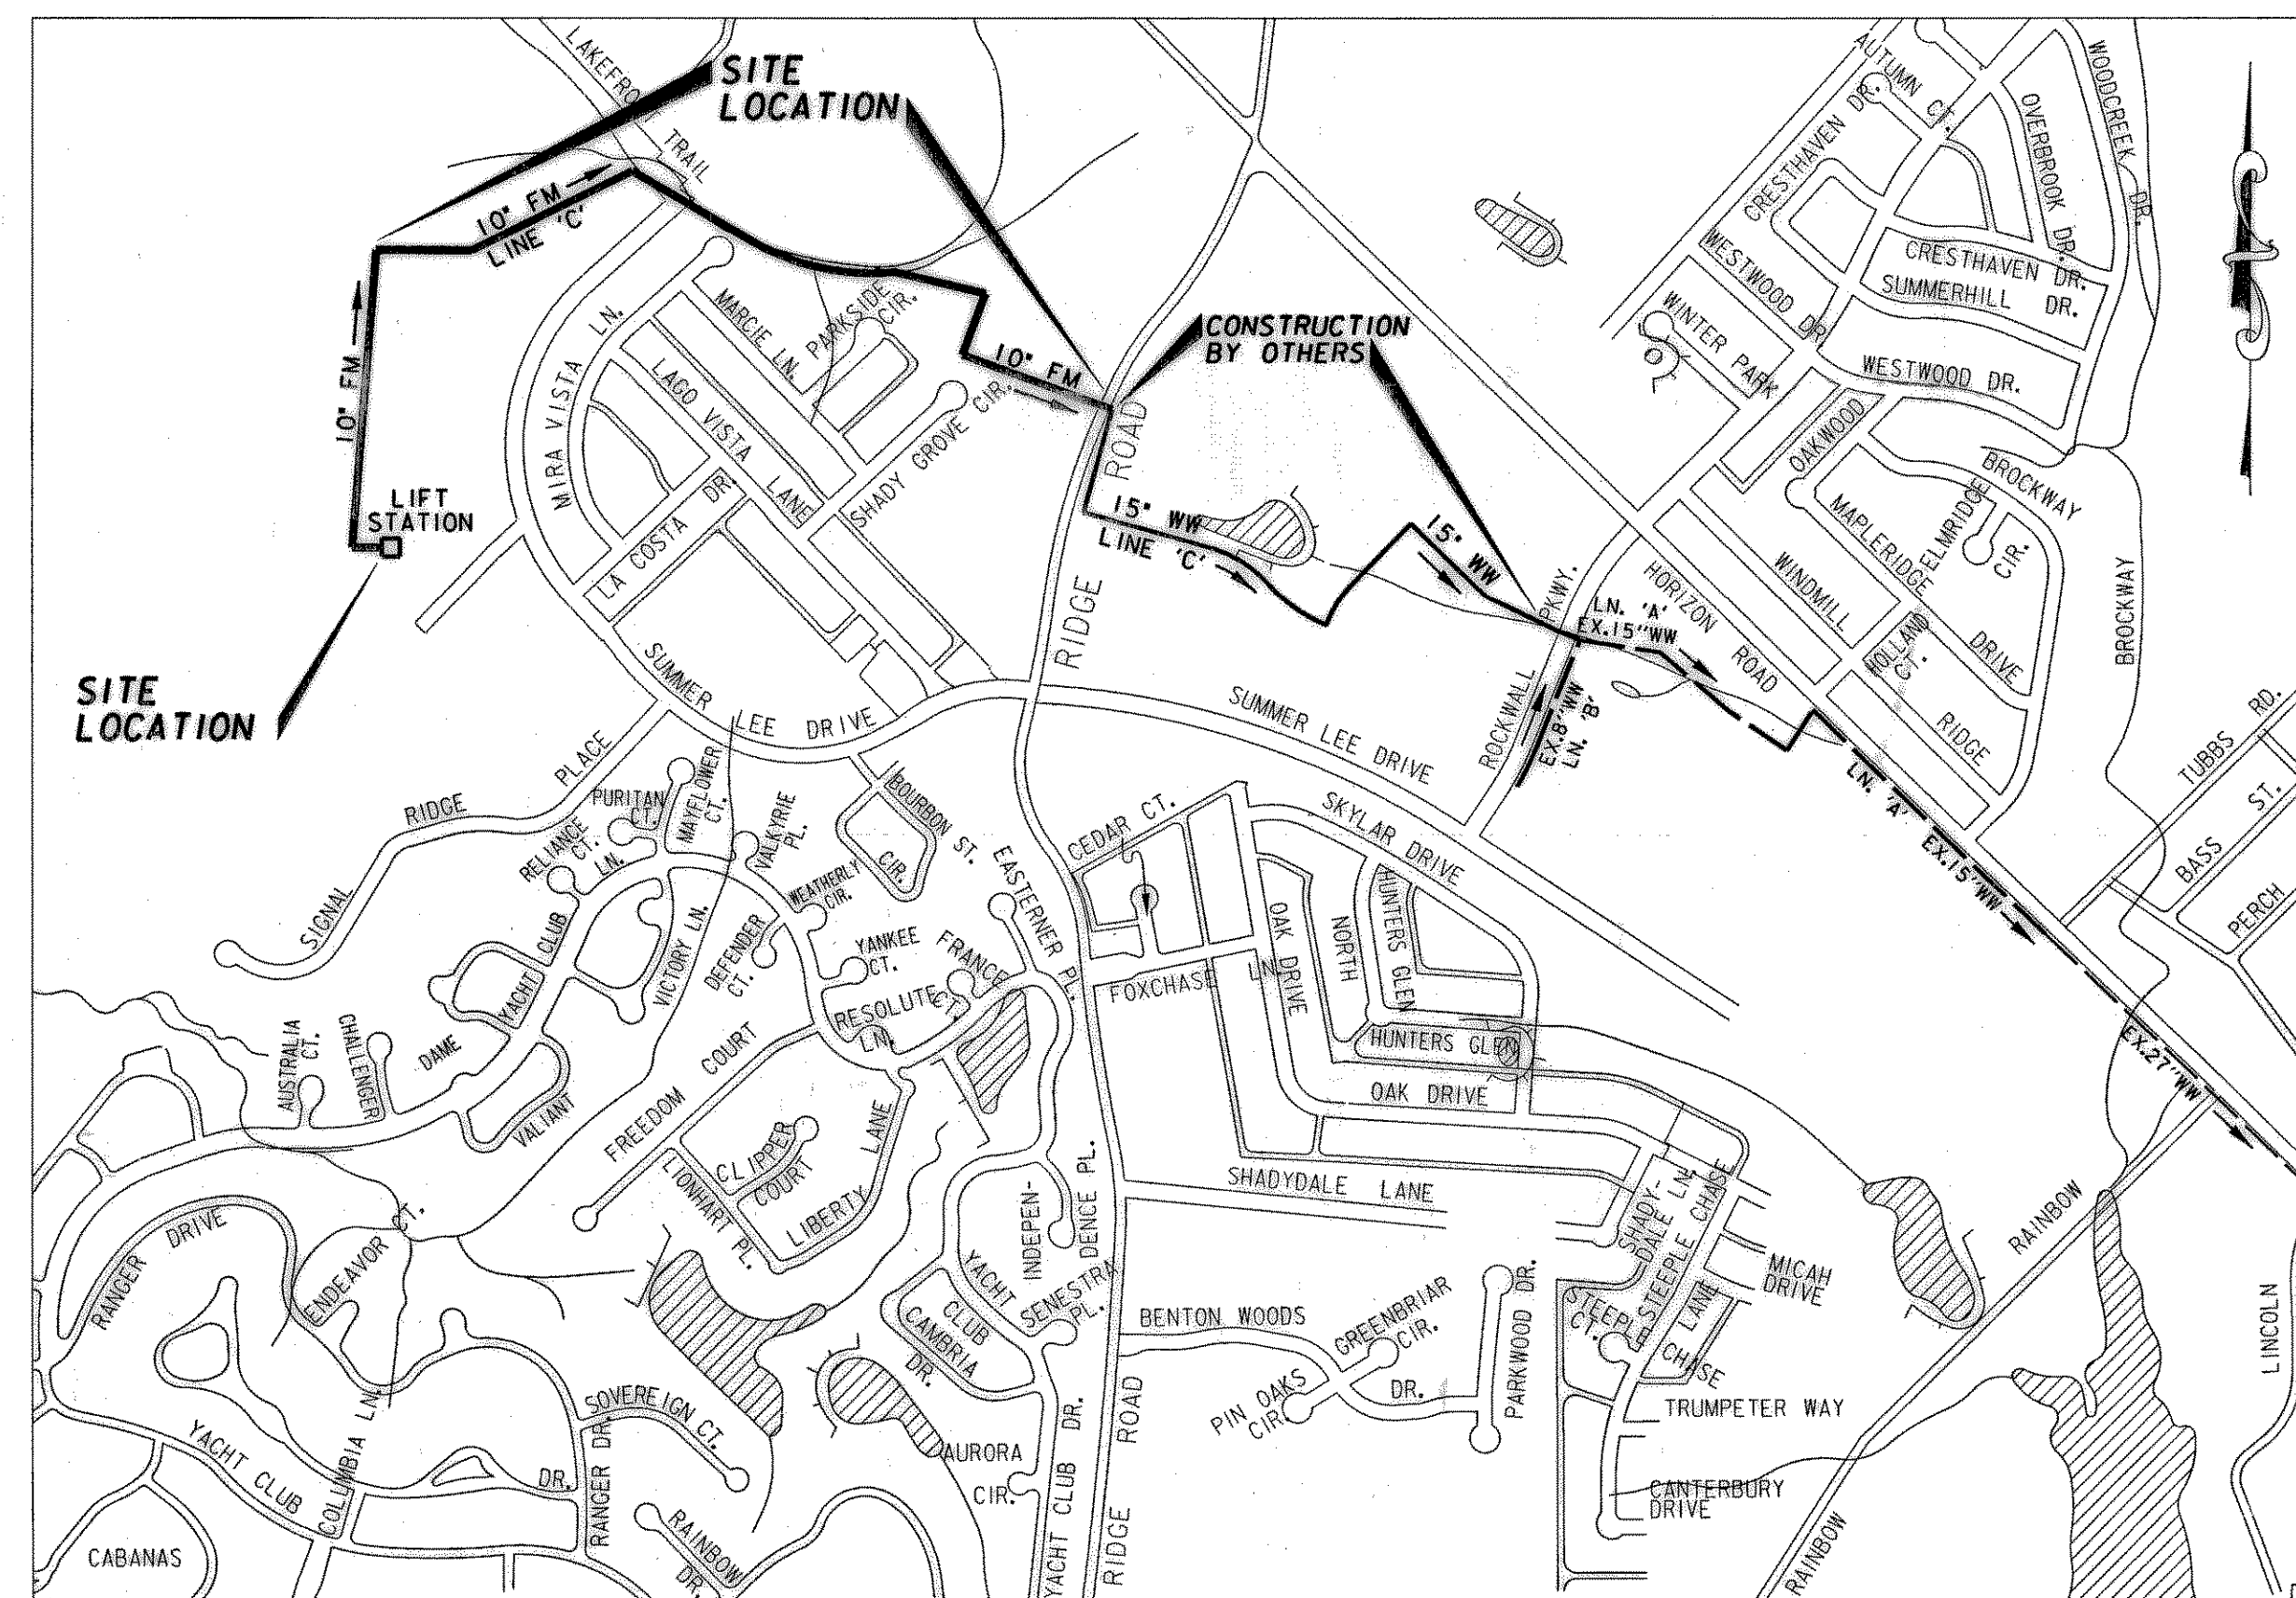


CONTRACTOR SHALL OBTAIN COPIES OF THE LATEST CITY OF ROCKWALL STANDARD DETAILS AND NORTH CENTRAL TEXAS COUNCIL OF GOVERNMENT STANDARD SPECIFICATIONS FOR PUBLIC WORKS CONSTRUCTION WITH ROCKWALL AMENDMENTS. CONTRACTOR SHALL HAVE ONE COPY ON THE PROJECT AT ALL TIMES.

INDEX OF DRAWINGS

| SHEET NO. | TITLE |
|-----------|------------------------------|
| 1 | COVER SHEET |
| 2 | ABBREVIATIONS & SYMBOLS |
| 3 | LIFT STATION SITE PLAN |
| 4 | LIFT STATION ELECTRICAL PLAN |
| 5 | LIFT STATION PLAN & SECTION |
| 6 | STRUCTURAL NOTES & DETAILS |
| 7-II | LINE 'C' FORCE MAIN |

RECORD DRAWINGS JANUARY 13, 2003
 THIS RECORD DOCUMENT HAS BEEN PREPARED BASED ON INFORMATION PROVIDED BY OTHERS. THE CONSULTANT HAS NOT VERIFIED THE ACCURACY AND/OR COMPLETENESS OF THIS INFORMATION AND SHALL NOT BE RESPONSIBLE FOR ANY ERRORS OR OMISSIONS THAT MAY BE INCORPORATED AS A RESULT OF ERRONEOUS INFORMATION PROVIDED BY OTHERS.

NOTE: INFORMATION ON UNDERGROUND FRANCHISED UTILITIES, BOTH EXISTING & PROPOSED, WAS NOT RECEIVED PRIOR TO ISSUING THESE PLANS FOR BID. CONTRACTOR TO VERIFY IN THE FIELD THE LOCATION OF ALL EXISTING UTILITIES PRIOR TO CONSTRUCTION. INFORMATION PROVIDED WITHIN THESE PLANS DOES NOT RELIEVE THE CONTRACTOR OF THE FULL AND TOTAL RESPONSIBILITY FOR THE PROTECTION OF EXISTING UTILITIES NOR ANY DAMAGES CAUSED BY SAID CONTRACTOR DURING CONSTRUCTION.

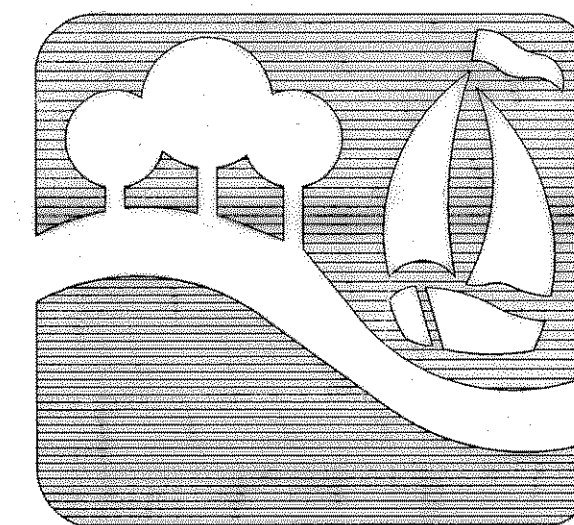

ROCKWALL, TEXAS


OWNER:

CITY OF ROCKWALL
 ENGINEERING DEPARTMENT
 205 WEST RUSK
 ROCKWALL, TEXAS 75087
 (972) 771-7700

ENGINEER:

HUITT-ZOLLARS, INC.
 3131 MCKINNEY AVE., SUITE 600
 DALLAS, TEXAS 75204
 (214) 871-3311

THE SEAL APPEARING ON THIS DOCUMENT WAS AUTHORIZED BY KENNETH A. ROBERTS, P.E. 55446 ON DECEMBER 3, 2001.

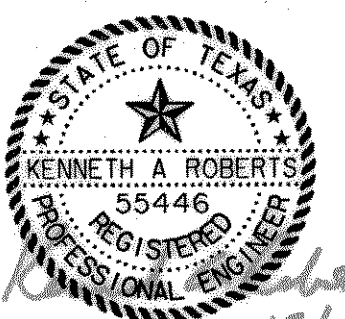

SIGNAL RIDGE WASTEWATER IMPROVEMENTS