



This record drawing is a compilation of the sealed engineering drawing for this project; modified by addenda, change orders and information furnished by the contractor. The information shown on the record drawings that was provided by the contractor or others not associated with the design engineer cannot be verified for accuracy or completeness. This original sealed drawing is on file at the offices of Birkhoff, Hendricks & Carter, L.L.P.  
BY PAC DATE 03/05/12

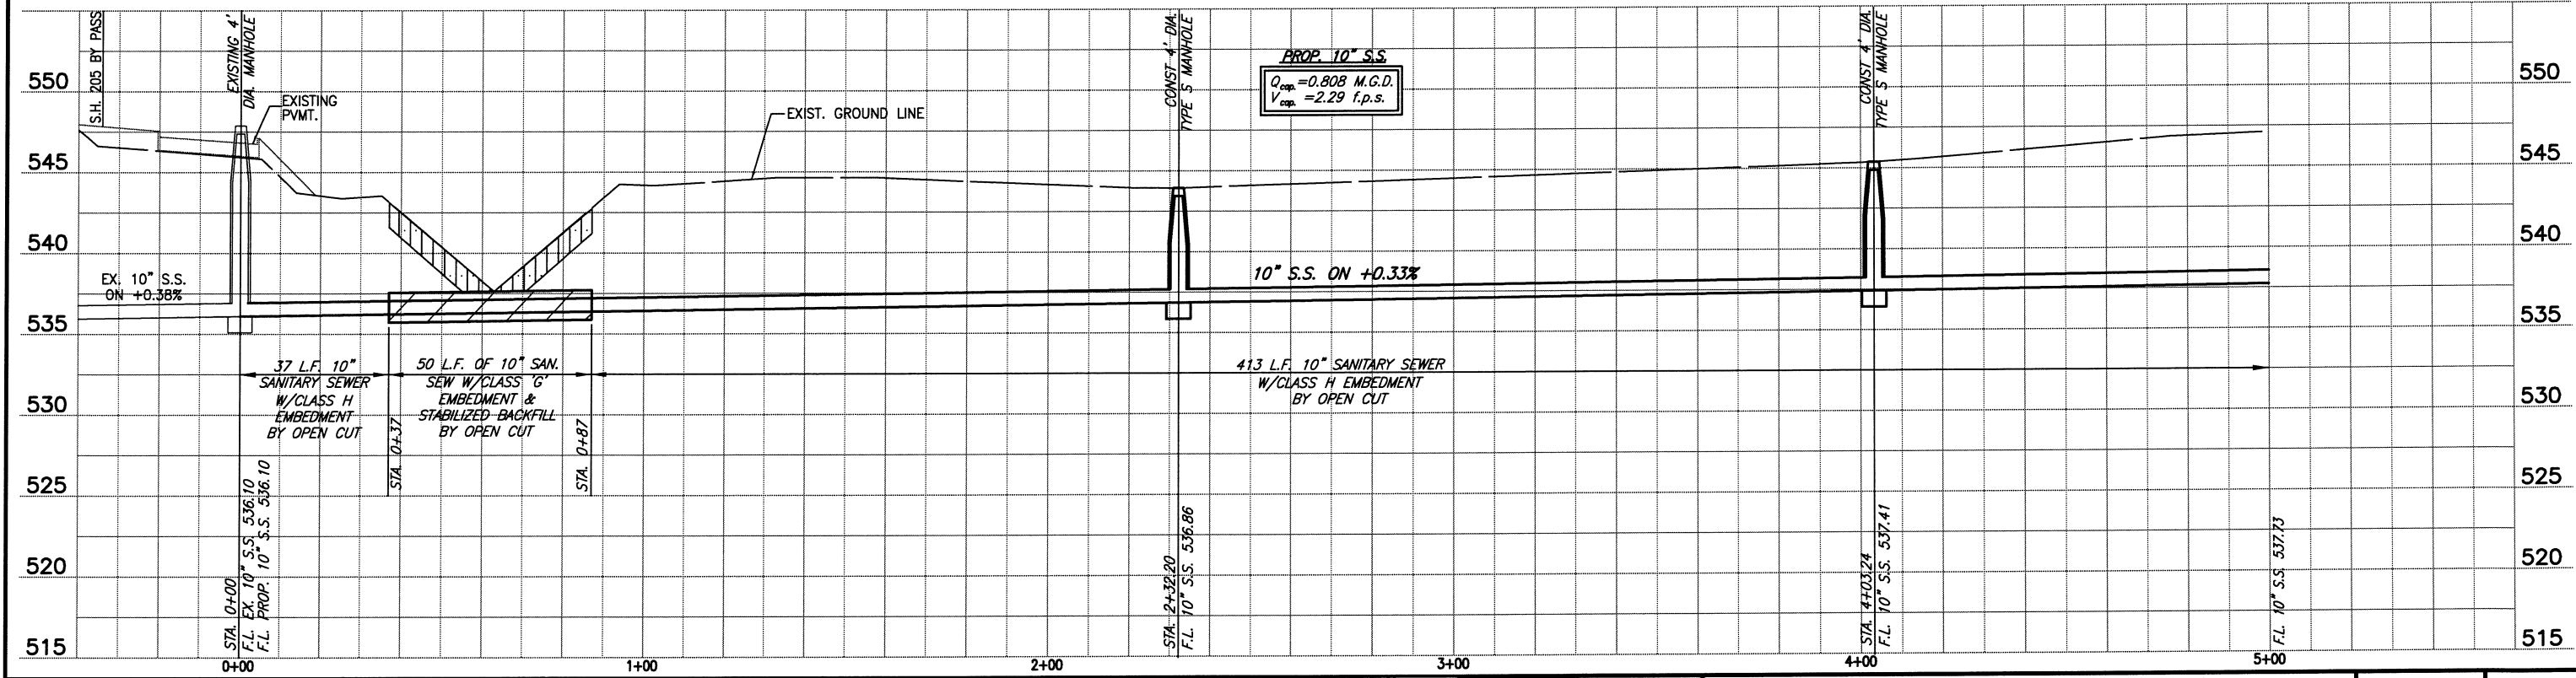

These plans and related specifications were prepared for construction of this specific project only. Reuse of these documents is not permitted without written authorization of Birkhoff, Hendricks, & Carter, L.L.P.

**BIRKHOFF, HENDRICKS & CARTER, L.L.P.**  
PROFESSIONAL ENGINEERS  
Texas Firm F526  
11910 Greenville Ave., Suite 600  
Dallas, Texas (214) 361-7900

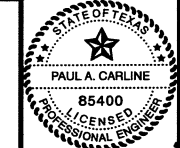

*[Signature]*  
10/19/10

**CITY OF ROCKWALL, TEXAS**  
BUFFALO CREEK SANITARY SEWER LINE (LINE B)  
10 INCH SANITARY SEWER REALIGNMENT N.E. OF S.H. 205 BY PASS  
PLAN AND PROFILE  
STA. 0+00 TO STA. 5+00

BHC  
PROJECT NO.  
2007-110  
October, 2010

SHEET NO.  
**5**