

These plans and related specifications were prepared for construction of this specific project only. Reuse of these documents is not permitted without written authorization of Birkhoff, Hendricks & Conway, L.L.P.

MATCH LINE STA. 60+00
N 7035086.4689, E 2597066.1103

N 7035095.7813, E 2597566.0214
MATCH LINE STA. 65+00

N 7035073.8072
E 2596576.2114
P.I. STA. 60+71.83
 $\Delta = 00^{\circ}28'58''$ LT.
PULL PIPE

SAWCUT & REMOVE
482 S.Y. ASPHALT PAVEMENT
FURNISH & INSTALL
482 S.Y. 6" FLEX BASE




PROP. 12" WATERLINE
(SEE SHEETS 20-29)

CP # 8
1/2" IRON ROD
N 7035105.9758
E 2597414.4785
ELEV. 520.18

FURNISH & INSTALL
500 L.F. 30"
FORCE MAIN

ROY L. HANCE
TRACT 2-1
83.794 AC.


ROY L. HANCE
VOL. 91, PG. 107
38.64 AC.

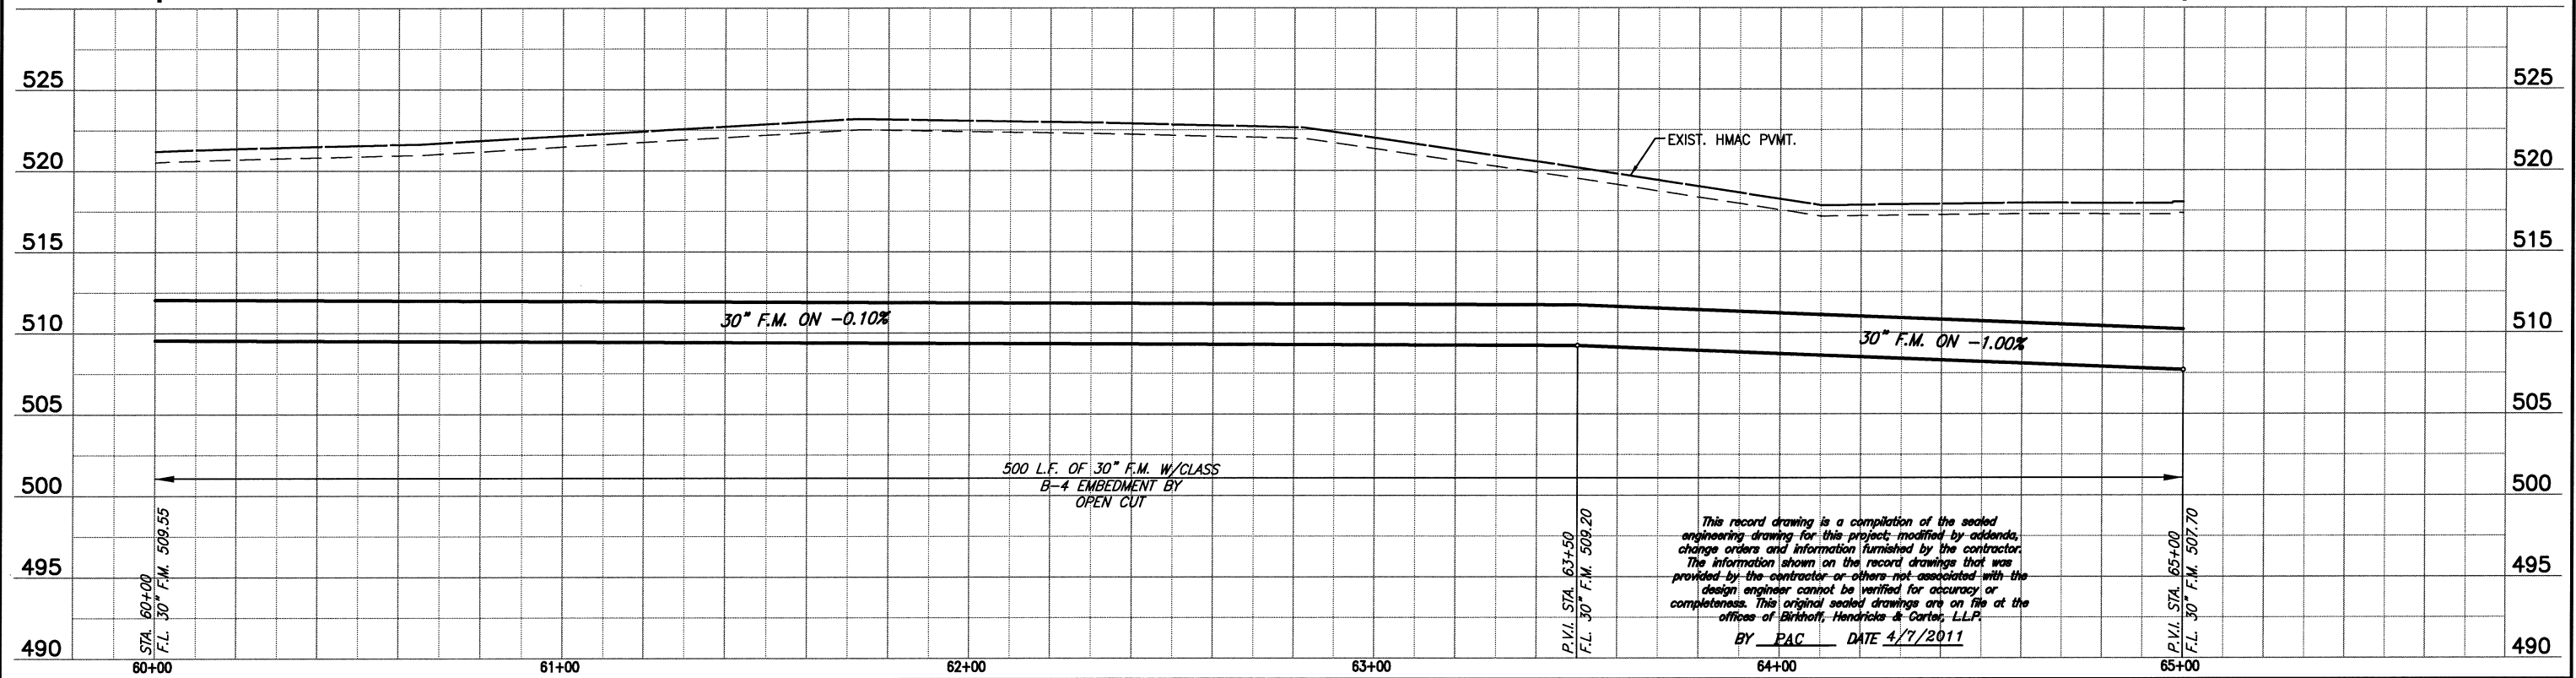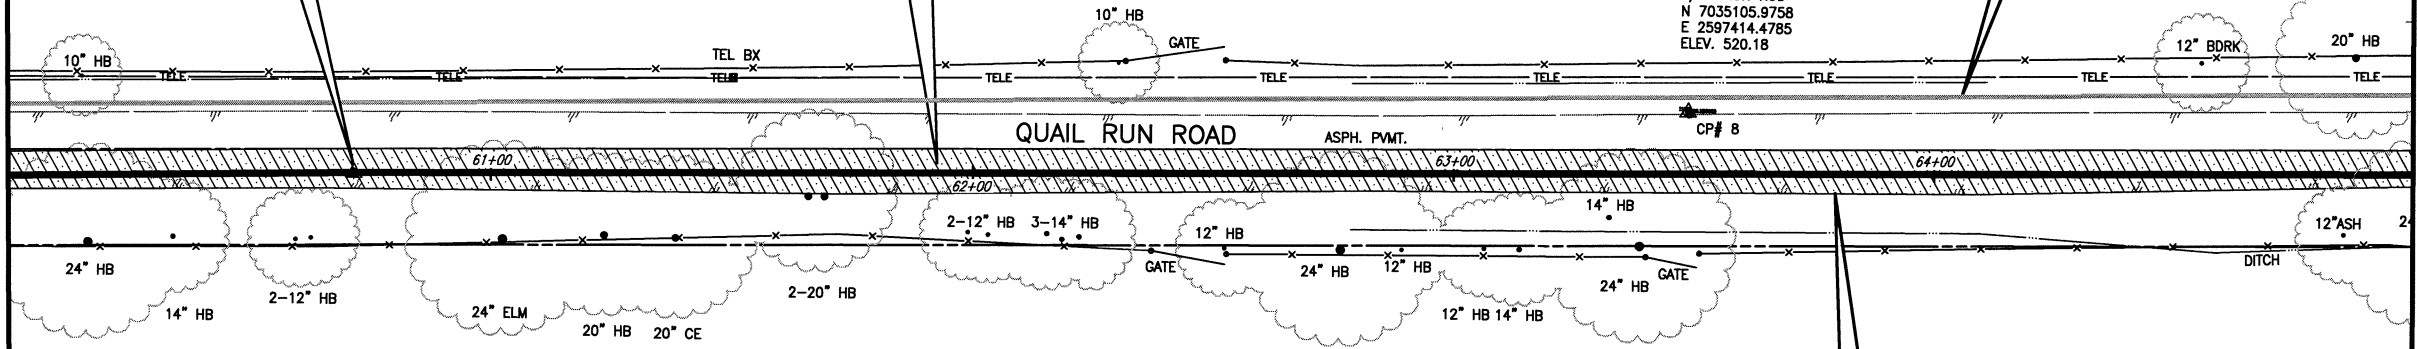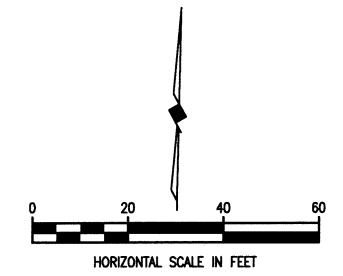

This record drawing is a compilation of the sealed engineering drawing for this project; modified by addenda, change orders and information furnished by the contractor. The information shown on the record drawings that was provided by the contractor or others not associated with the design engineer cannot be verified for accuracy or completeness. This original sealed drawings are on file at the offices of Birkhoff, Hendricks & Conway, L.L.P.
BY PAC DATE 4/7/2011

FIELD CHANGE NO. 1 - NOVEMBER 17, 2009

BIRKHOFF, HENDRICKS & CONWAY, L.L.P.
PROFESSIONAL ENGINEERS
Texas Firm F526
11910 Greenville Ave., Suite 600
Dallas, Texas 75243 (214) 361-7900

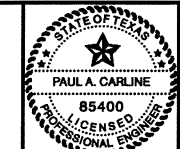

[Signature]
11/7/11

CITY ROCKWALL, TEXAS
SQUABBLE CREEK
30 INCH FORCE MAIN
PLAN AND PROFILE
STA. 60+00 TO STA. 65+00

BHC
PROJECT NO.
2007-110
July 2009
SHEET NO.
15