
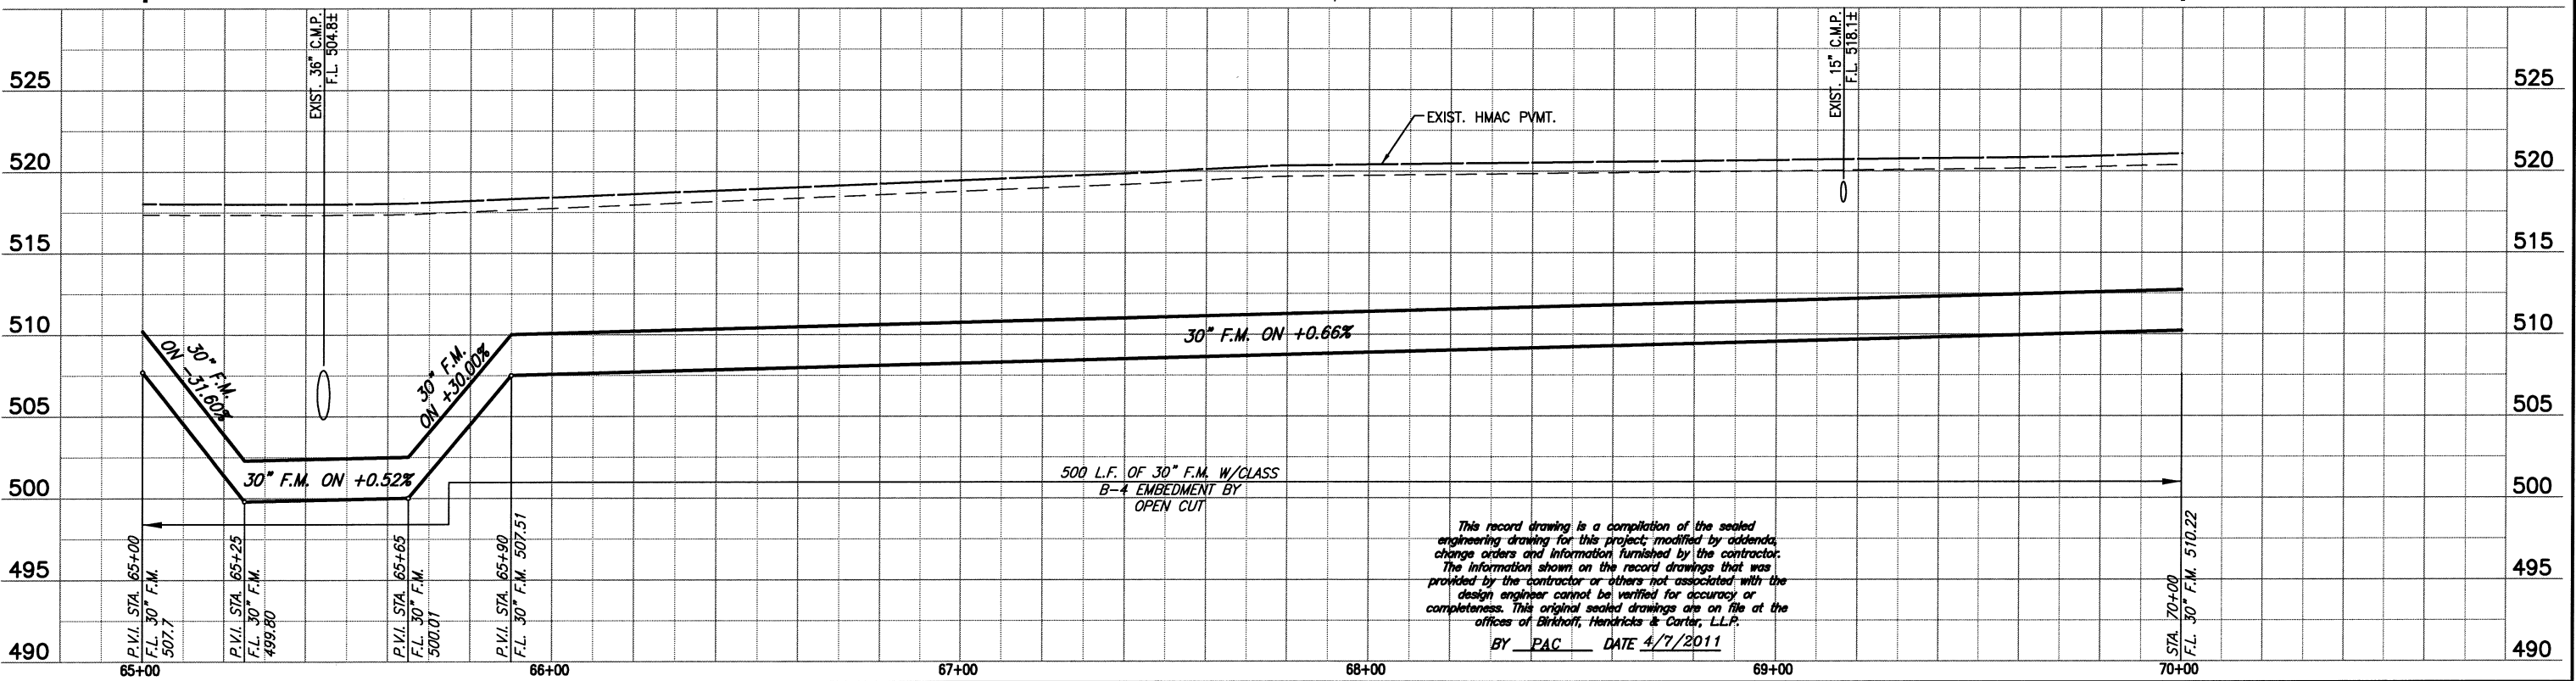
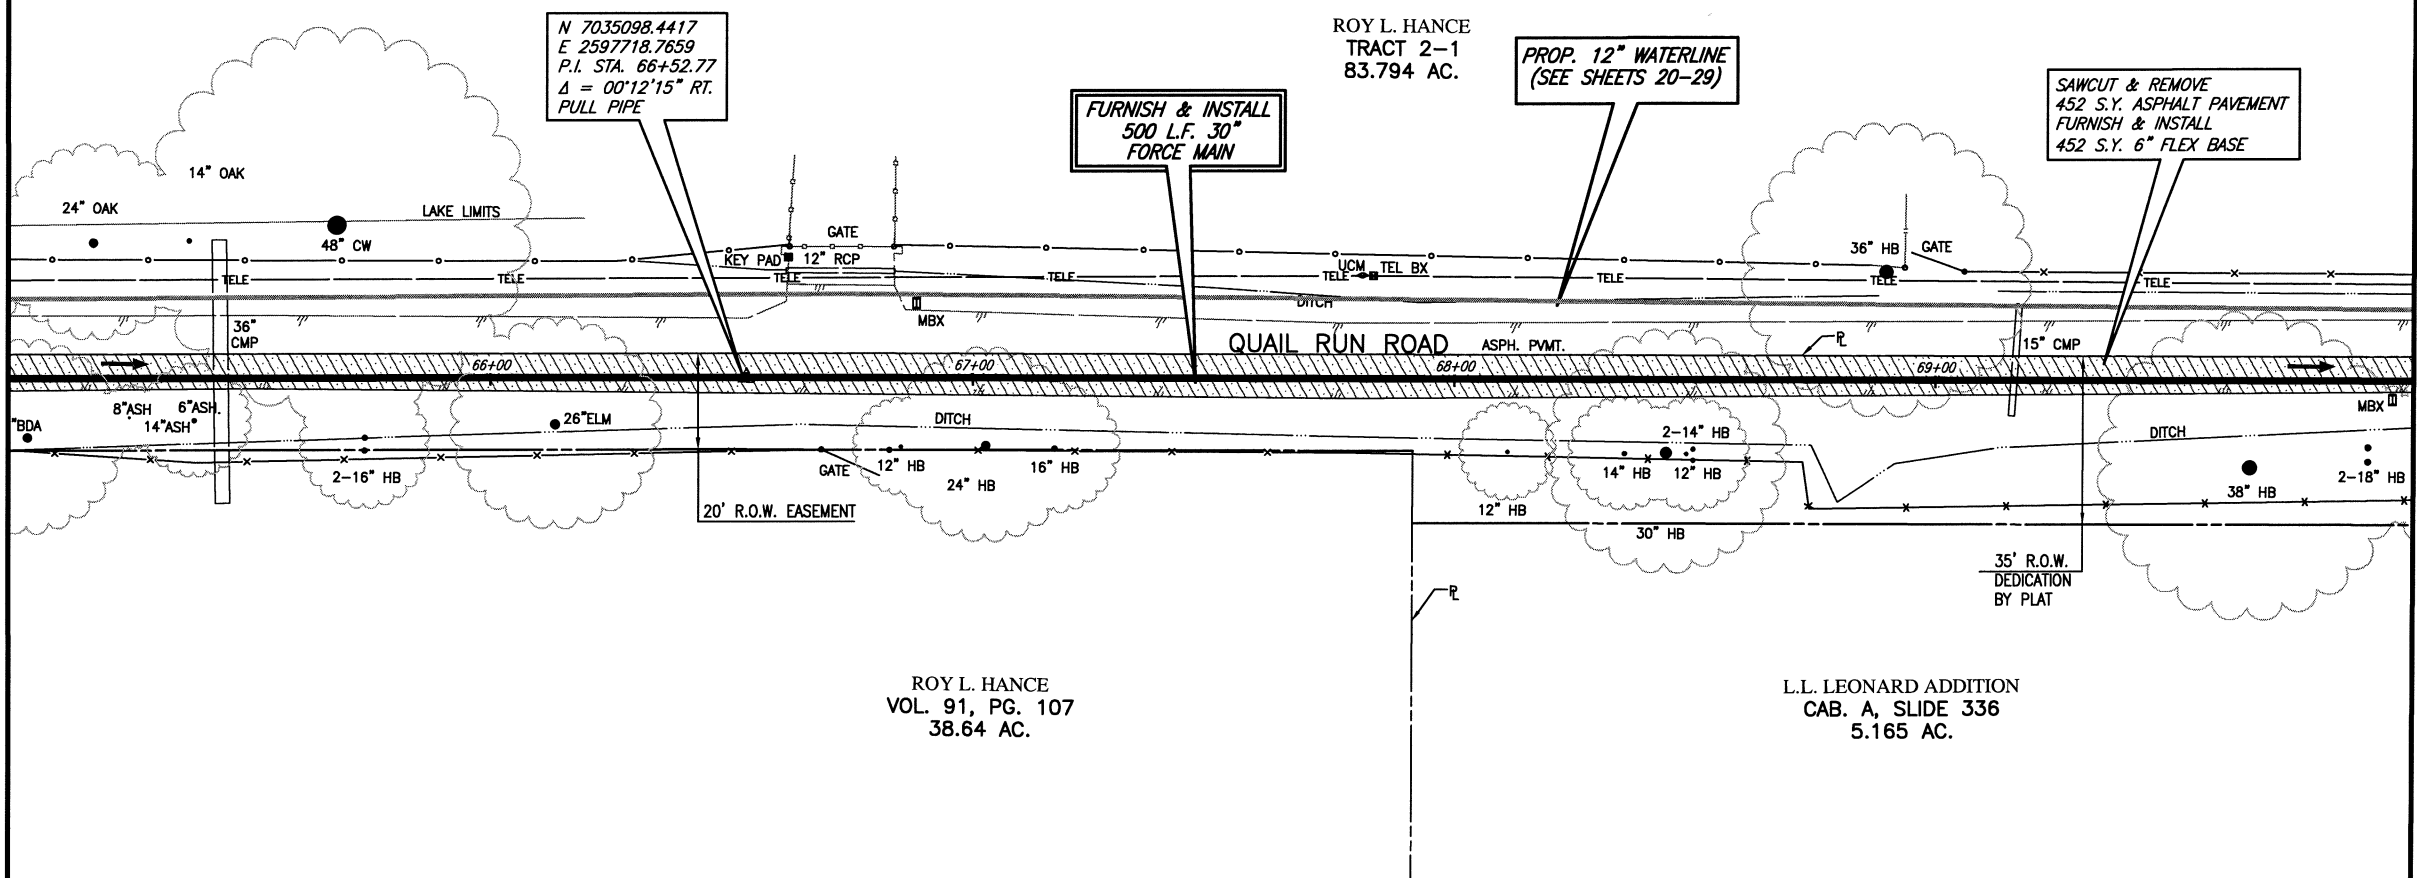


These plans and related specifications were prepared for construction of this specific project only. Reuse of these documents is not permitted without written authorization of Birkhoff, Hendricks, & Conway, L.L.P.


MATCH LINE STA. 65+00
N 7035095.7813, E 2597566.0214

MATCH LINE STA. 70+00
N 7035103.2521, E 2598065.9649

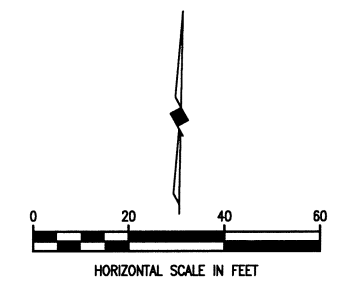

FIELD CHANGE NO. 1 - NOVEMBER 17, 2009

BIRKHOFF, HENDRICKS & CONWAY, L.L.P.
PROFESSIONAL ENGINEERS
Texas Firm F526
11910 Greenville Ave., Suite 600
Dallas, Texas 75243 (214) 361-7900

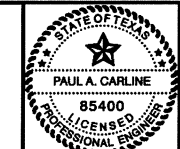

[Signature]
11/7/11

CITY ROCKWALL, TEXAS
SQUABBLE CREEK
30 INCH FORCE MAIN
PLAN AND PROFILE
STA. 65+00 TO STA. 70+00

BHC PROJECT NO. 2007-110
July 2009
SHEET NO. **16**