
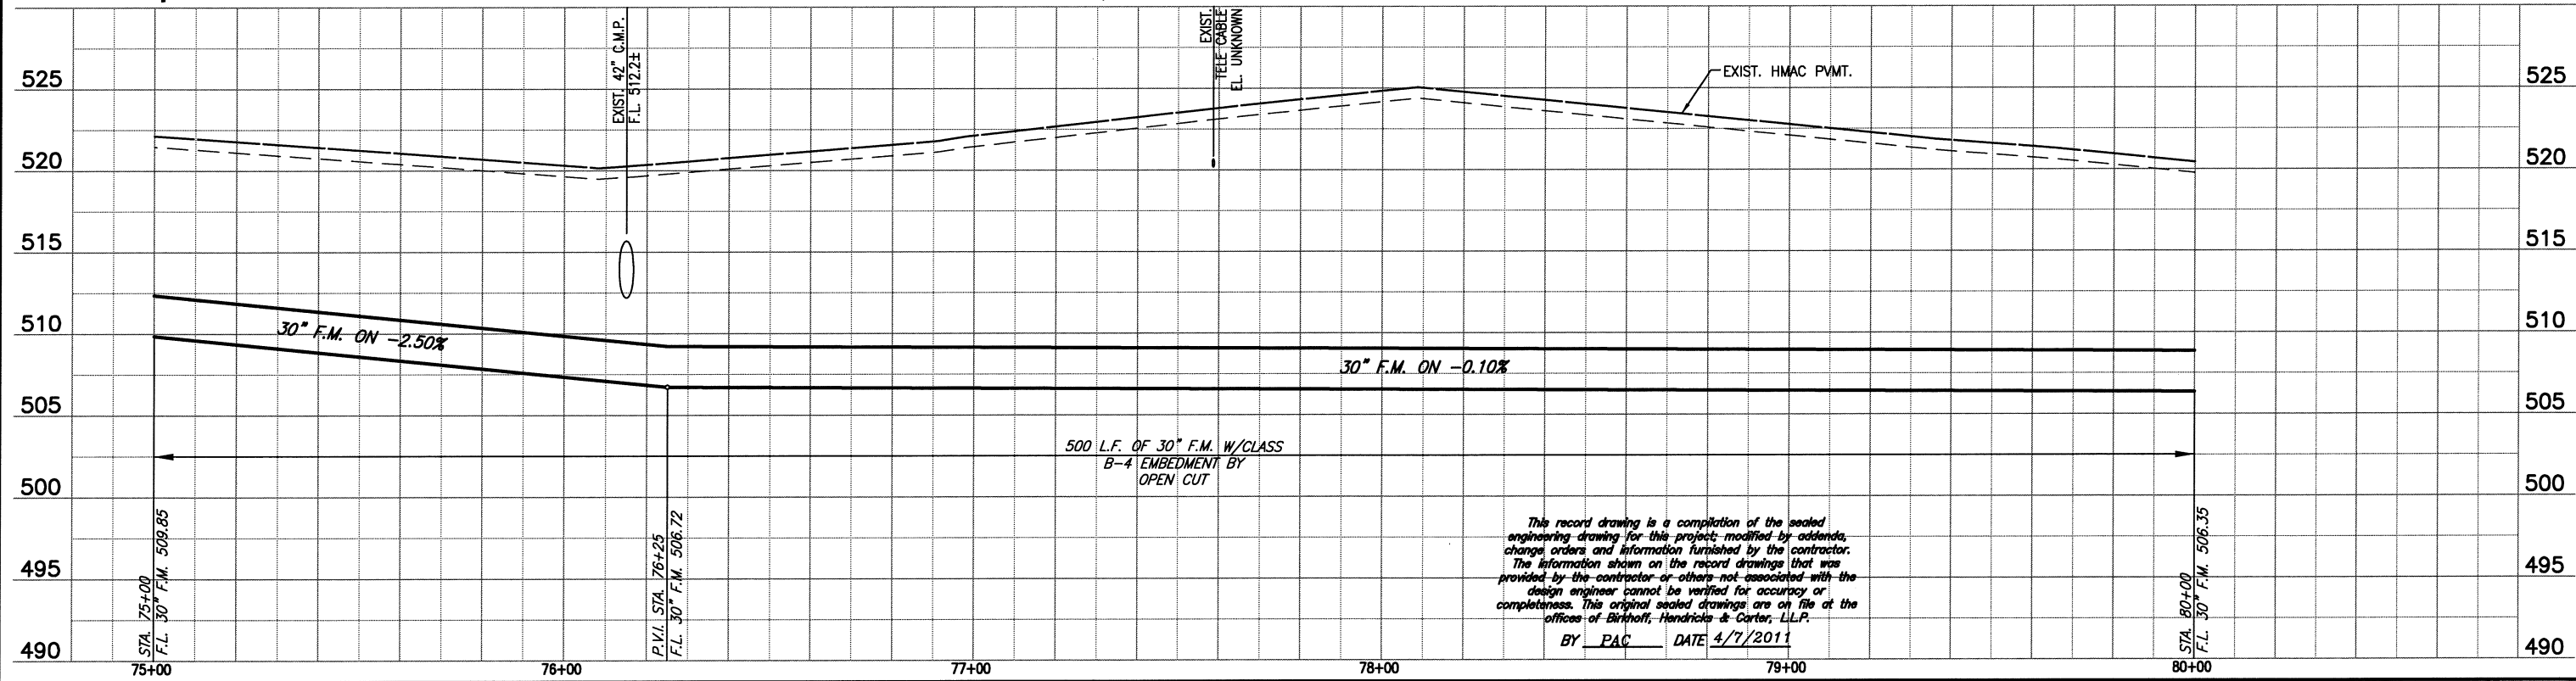
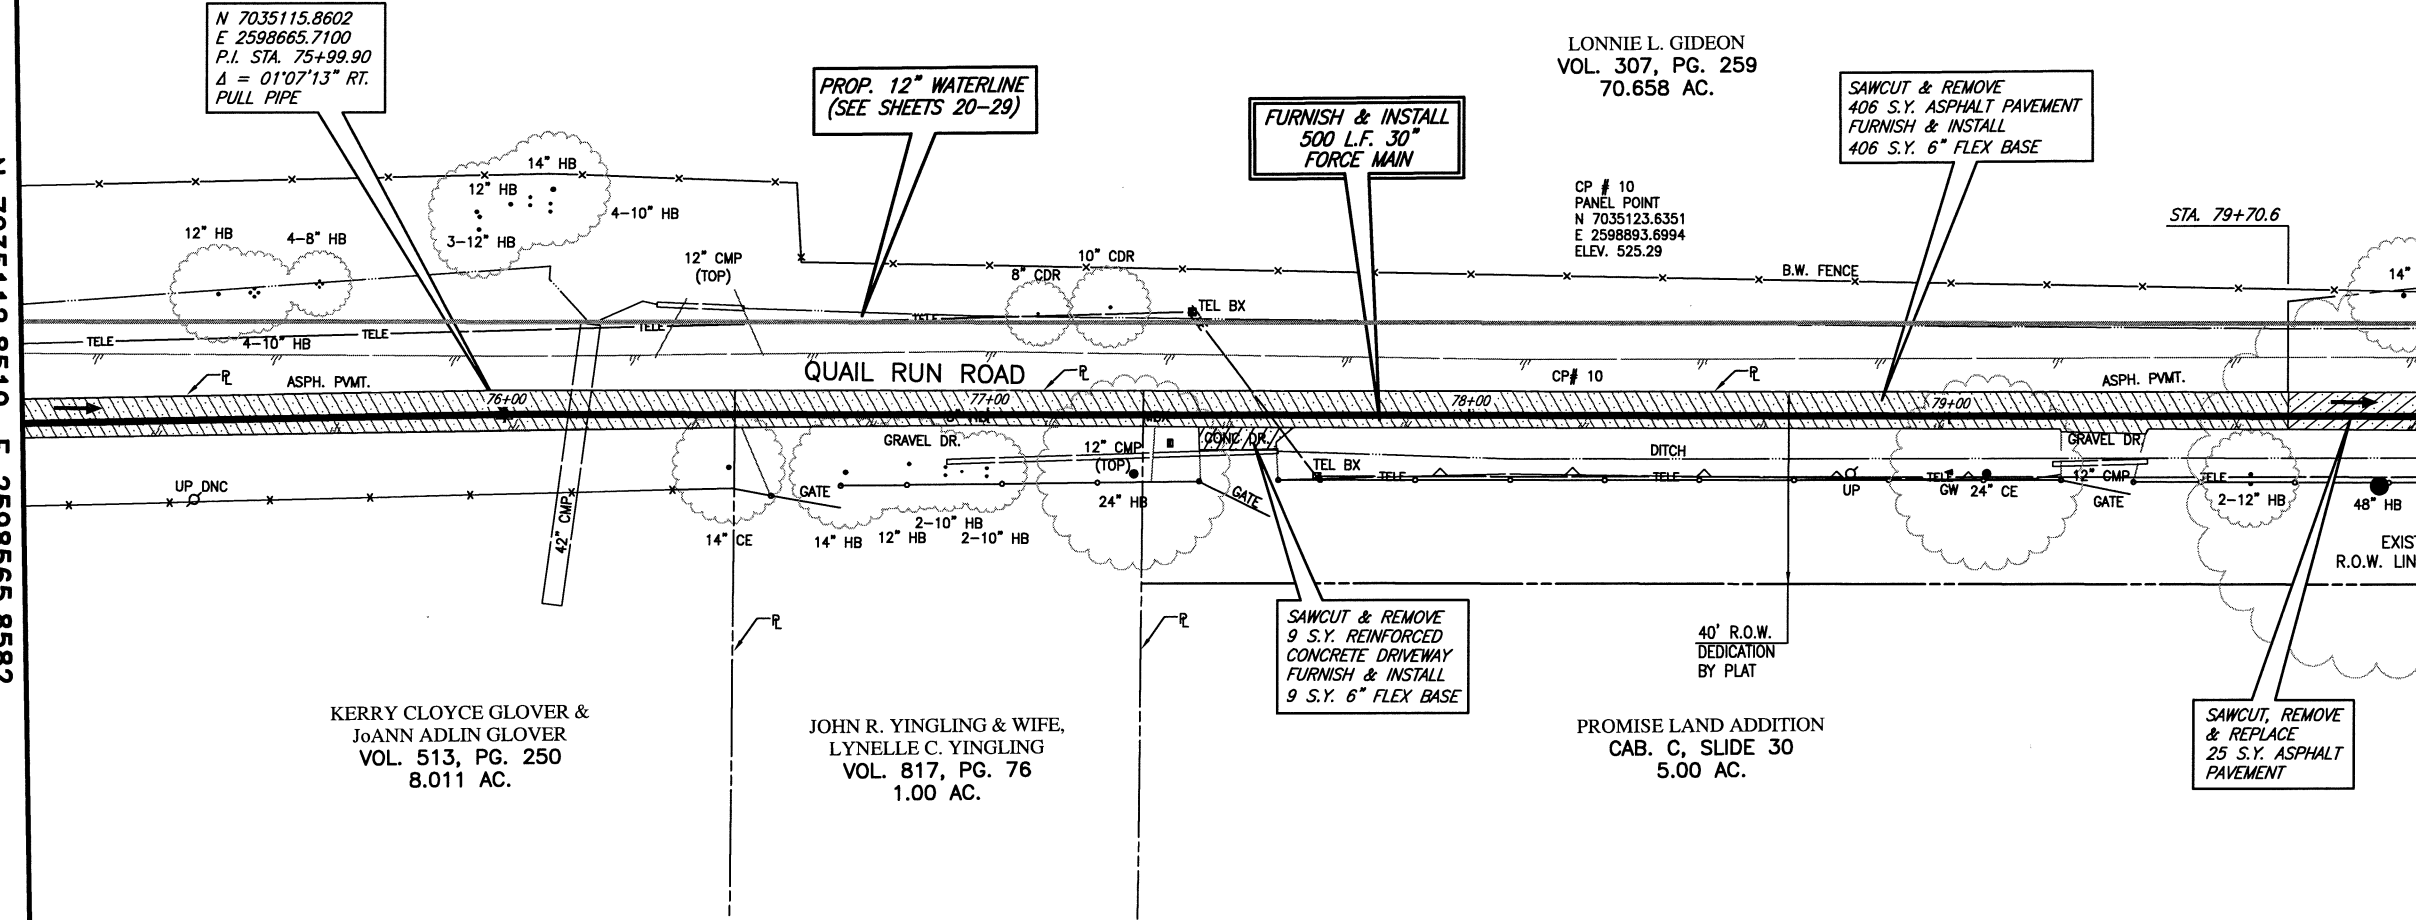


These plans and related specifications were prepared for construction of this specific project only. Reuse of these documents is not permitted without written authorization of Birkhoff, Hendricks, & Conway, L.L.P.

N 7035112.8519, E 2598565.8582
MATCH LINE STA. 75+00

N 7035120.0874, E 2599065.7905
MATCH LINE STA. 80+00

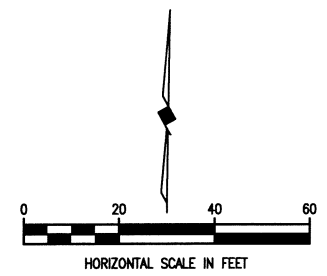

FIELD CHANGE NO. 1 - NOVEMBER 17, 2009

BIRKHOFF, HENDRICKS & CONWAY, L.L.P.
PROFESSIONAL ENGINEERS
Texas Firm F526
11910 Greenville Ave., Suite 600
Dallas, Texas 75243 (214) 361-7900



Paul A. Carline
11/7/11

CITY ROCKWALL, TEXAS
SQUABBLE CREEK
30 INCH FORCE MAIN
PLAN AND PROFILE
STA. 75+00 TO STA. 80+00

BHC
PROJECT NO.
2007-110
SHEET NO.
18
July 2009