

These plans and related specifications were prepared for construction of this specific project only. Reuse of these documents is not permitted without written authorization of Birkhoff, Hendricks, & Conway, L.L.P.

MATCH LINE STA. 80+00  
N 7035120.0874, E 2599065.7905

PROP. 12" WATERLINE  
(SEE SHEETS 20-29)

FURNISH & INSTALL  
187 L.F. 30" FORCE MAIN

N 7035121.9579  
E 2599242.8271  
P.I. STA. 81+77.05  
Δ = 45°18'10" RT.  
FURNISH & INSTALL  
1-45°00' BEND

N 7035118.0002  
E 2599246.8269  
P.I. STA. 81+82.67  
Δ = 45°18'10" RT.  
FURNISH & INSTALL  
1-45°00' BEND



SAWCUT, REMOVE & REPLACE  
156 S.Y. ASPHALT PAVEMENT

PROMISE LAND ADDITION  
CAB. C, SLIDE 30  
5.00 AC.

20' SAN. SEW.  
EASEMENT  
EXISTING  
30" FORCE MAIN

N 7035113.5835  
E 2599246.8269  
STA. 81+87.09  
REMOVE EXISTING PLUG  
CONNECT TO 30" FORCE MAIN  
END THIS PROJECT

NICHOLAS & SHERRI GRANT  
VOL. 4472, PG. 181  
10.215 AC.

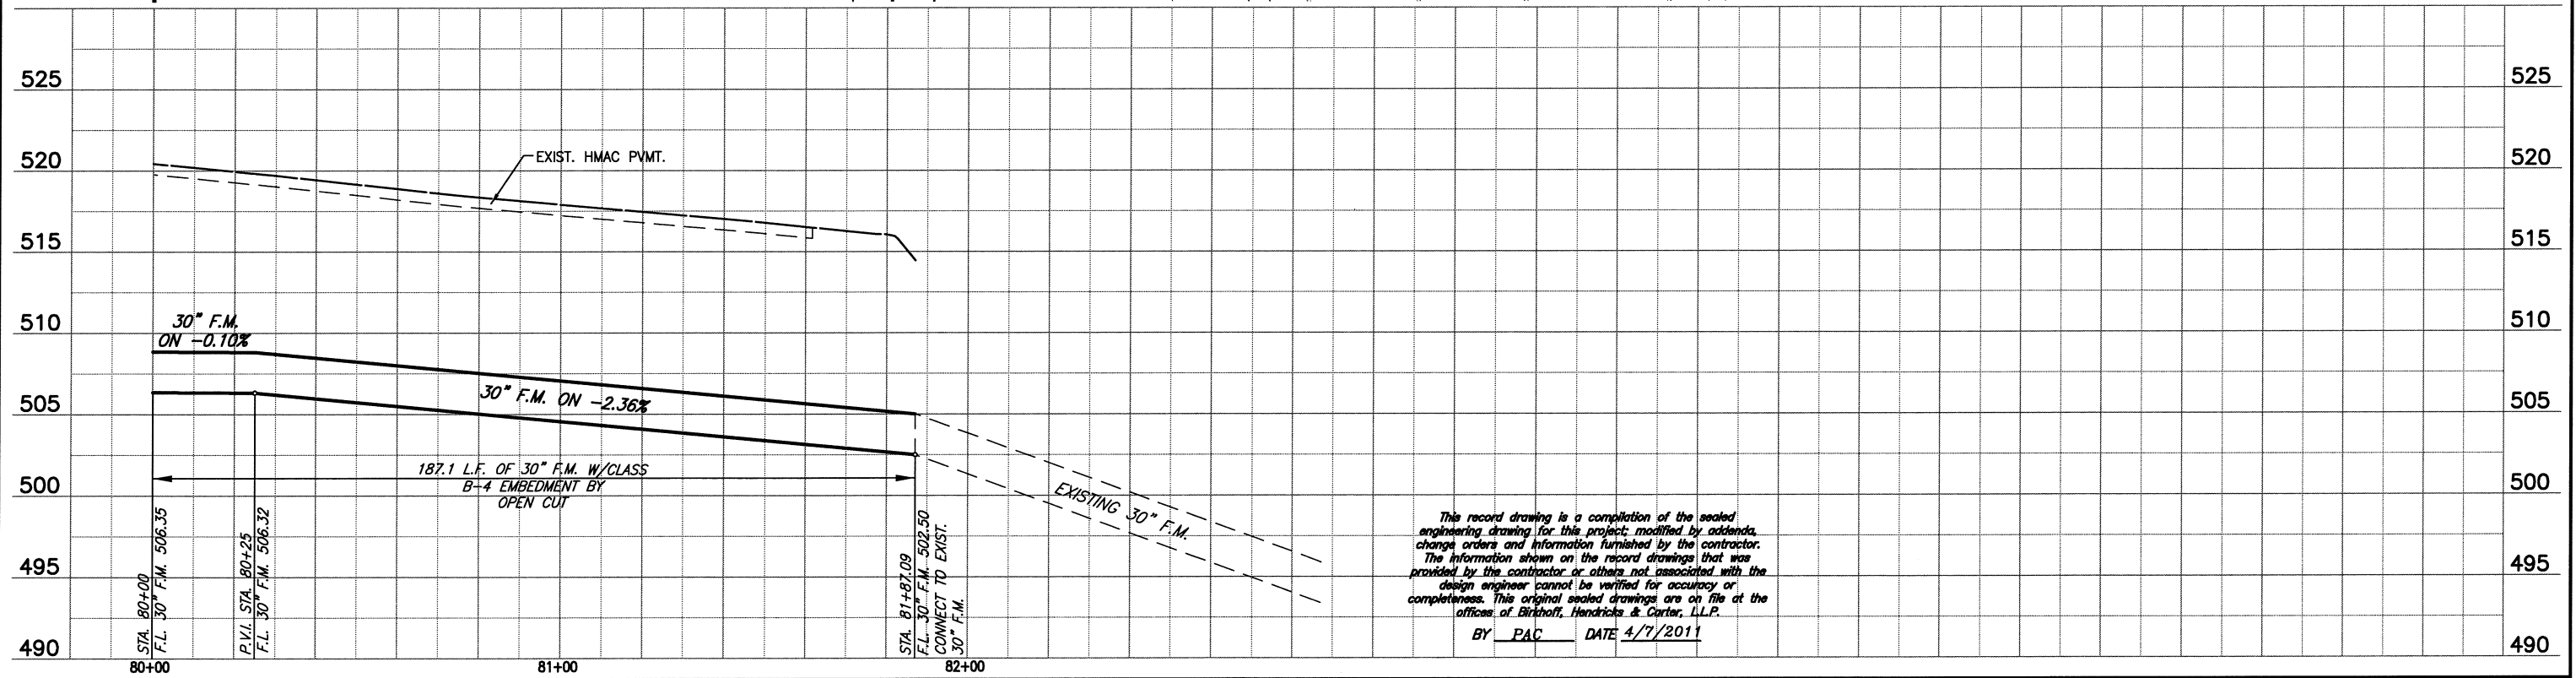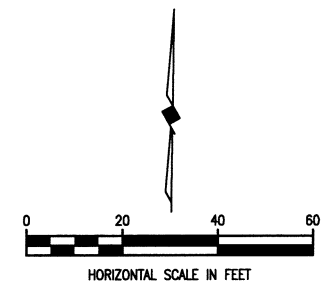

This record drawing is a compilation of the sealed engineering drawing for this project, modified by addenda, change orders and information furnished by the contractor. The information shown on the record drawings that was provided by the contractor or others not associated with the design engineer cannot be verified for accuracy or completeness. This original sealed drawings are on file at the offices of Birkhoff, Hendricks & Conway, L.L.P.  
BY PAC DATE 4/7/2011

FIELD CHANGE NO. 1 - NOVEMBER 17, 2009

**BIRKHOFF, HENDRICKS & CONWAY, L.L.P.**  
PROFESSIONAL ENGINEERS  
Texas Firm F526  
11910 Greenville Ave., Suite 600  
Dallas, Texas 75243 (214) 361-7900



*[Signature]*  
11/7/11

**CITY ROCKWALL, TEXAS**  
SQUABBLE CREEK  
30 INCH FORCE MAIN  
PLAN AND PROFILE  
STA. 80+00 TO STA. 81+70.12

BHC PROJECT NO. 2007-110	SHEET NO. <b>19</b>
April 2011	