 


JAVKER REALTY CORP.  
VOL. 3554, PG. 67  
2.52 AC.

STONE CREEK  
BALANCE LTD.  
VOL. 5010, PG. 267  
128.08 AC.



**WARNING**  
GAS LINE IN AREA!  
NOTIFY ATMOS ENERGY  
72 HOURS PRIOR TO  
EXCAVATION IN VICINITY  
OF STA. 26+18±

MATCH LINE STA. 25+00  
N 7034763.7541, E 2593653.0022

MATCH LINE STA. 30+00  
N 7035035.9861, E 2594069.4335

N 7034790.8437  
E 2593704.4987  
P.I. STA. 25+58.19  
Δ = 09°53'57" LT.  
FURNISH & INSTALL  
1-11' 15" BEND

FURNISH & INSTALL  
500 L.F. 30"  
FORCE MAIN

N 7034974.9519  
E 2593943.1739  
P.I. & P.C. STA. 28+59.62  
Δ = 07°22'41" RT.  
FURNISH & INSTALL  
11' 15" BEND

**F.M. CURVE DATA 4**  
Δ = 12°14'46" RT.  
R = 900.00'  
T = 96.55'  
L = 192.36'  
C.B. = N 65°51'19" E  
C.D. = 191.99'


SAWCUT, REMOVE & REPLACE  
62 S.Y. 4 INCH REINFORCED  
CONCRETE SIDEWALK

SAWCUT, REMOVE & REPLACE  
242 S.Y. 10 INCH REINF.  
CONC. PVMT., INCLUDING CURB

STA. 27+26 TO STA 28+46  
FURNISH & INSTALL  
120 L.F. 30" FORCE MAIN  
BY OTHER THAN OPEN CUT  
(NO ENCASEMENT)

SAWCUT, REMOVE & REPLACE  
84 S.Y. 4 INCH REINFORCED  
CONCRETE SIDEWALK

These plans and related specifications were prepared for construction of this specific project only. Reuse of these documents is not permitted without written authorization of Birkhoff, Hendricks & Conway, L.L.P.

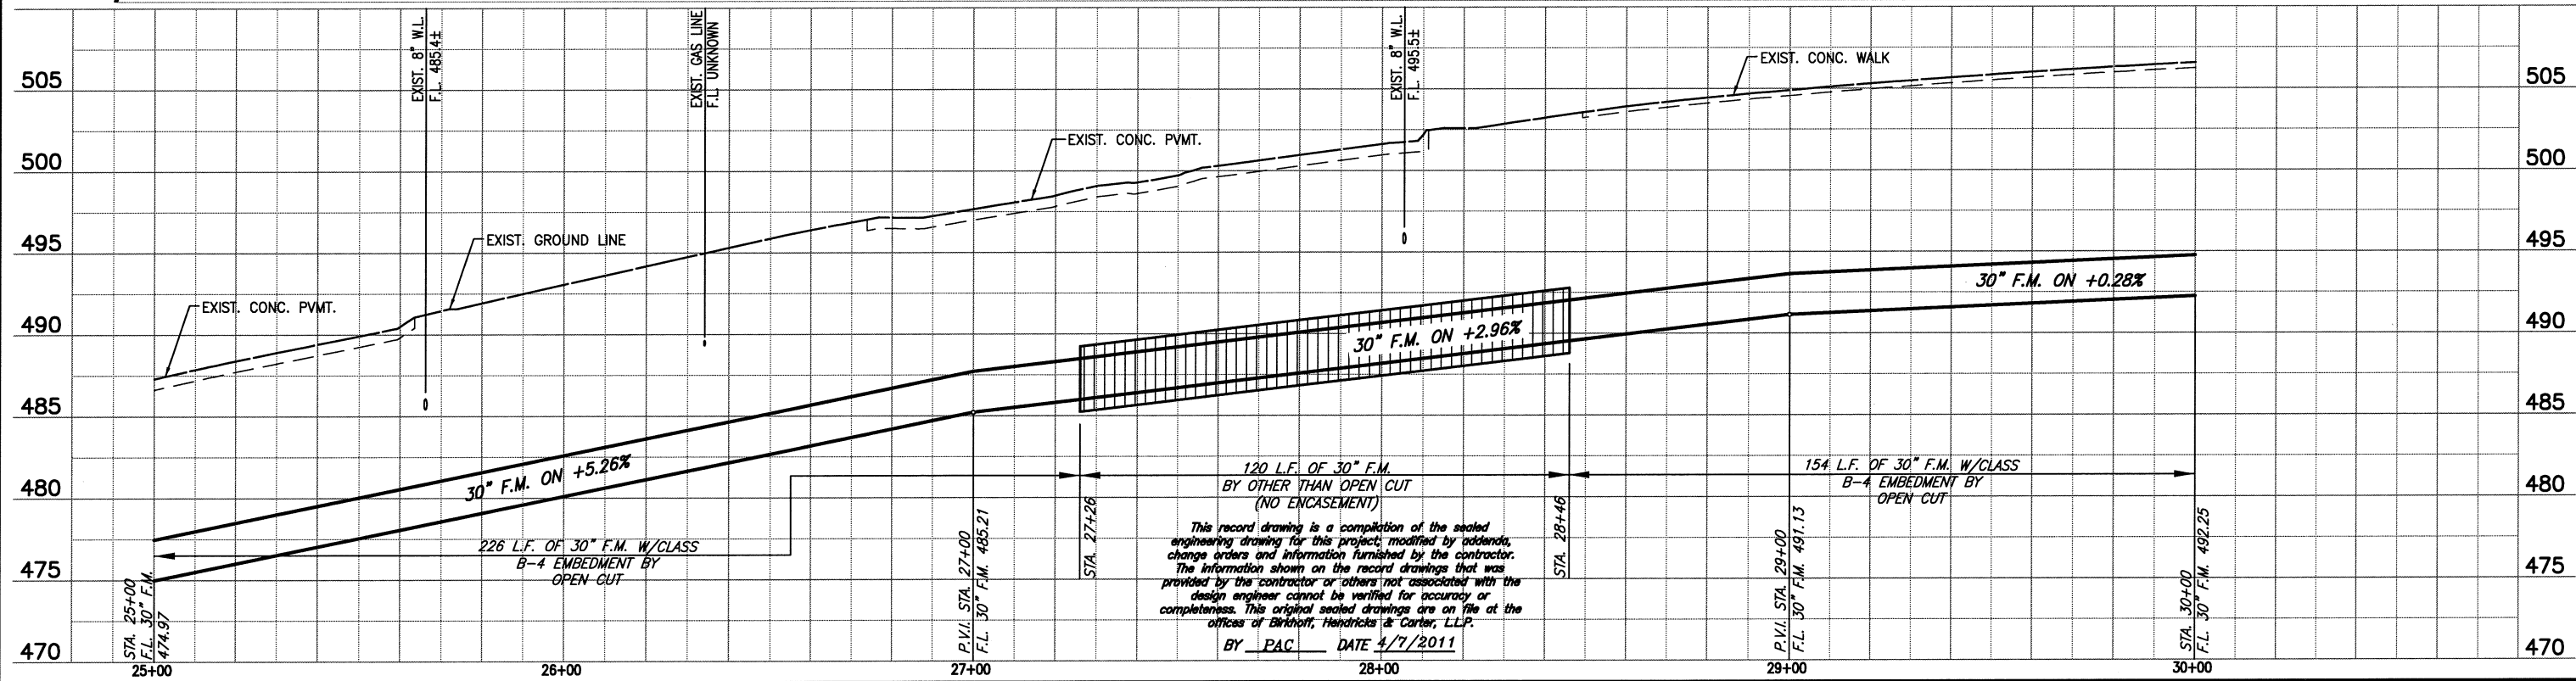

FIELD CHANGE NO. 1 - NOVEMBER 17, 2009

**BIRKHOFF, HENDRICKS & CONWAY, L.L.P.**  
PROFESSIONAL ENGINEERS  
Texas Firm F526  
11910 Greenville Ave., Suite 600  
Dallas, Texas 75243 (214) 361-7900



*Paul A. Carline*  
11/7/09

**CITY ROCKWALL, TEXAS**  
SQUABBLE CREEK  
30 INCH FORCE MAIN  
PLAN AND PROFILE  
STA. 25+00 TO STA. 30+00

BHC  
PROJECT NO.  
2007-110  
SHEET NO.  
**8**  
July 2009