

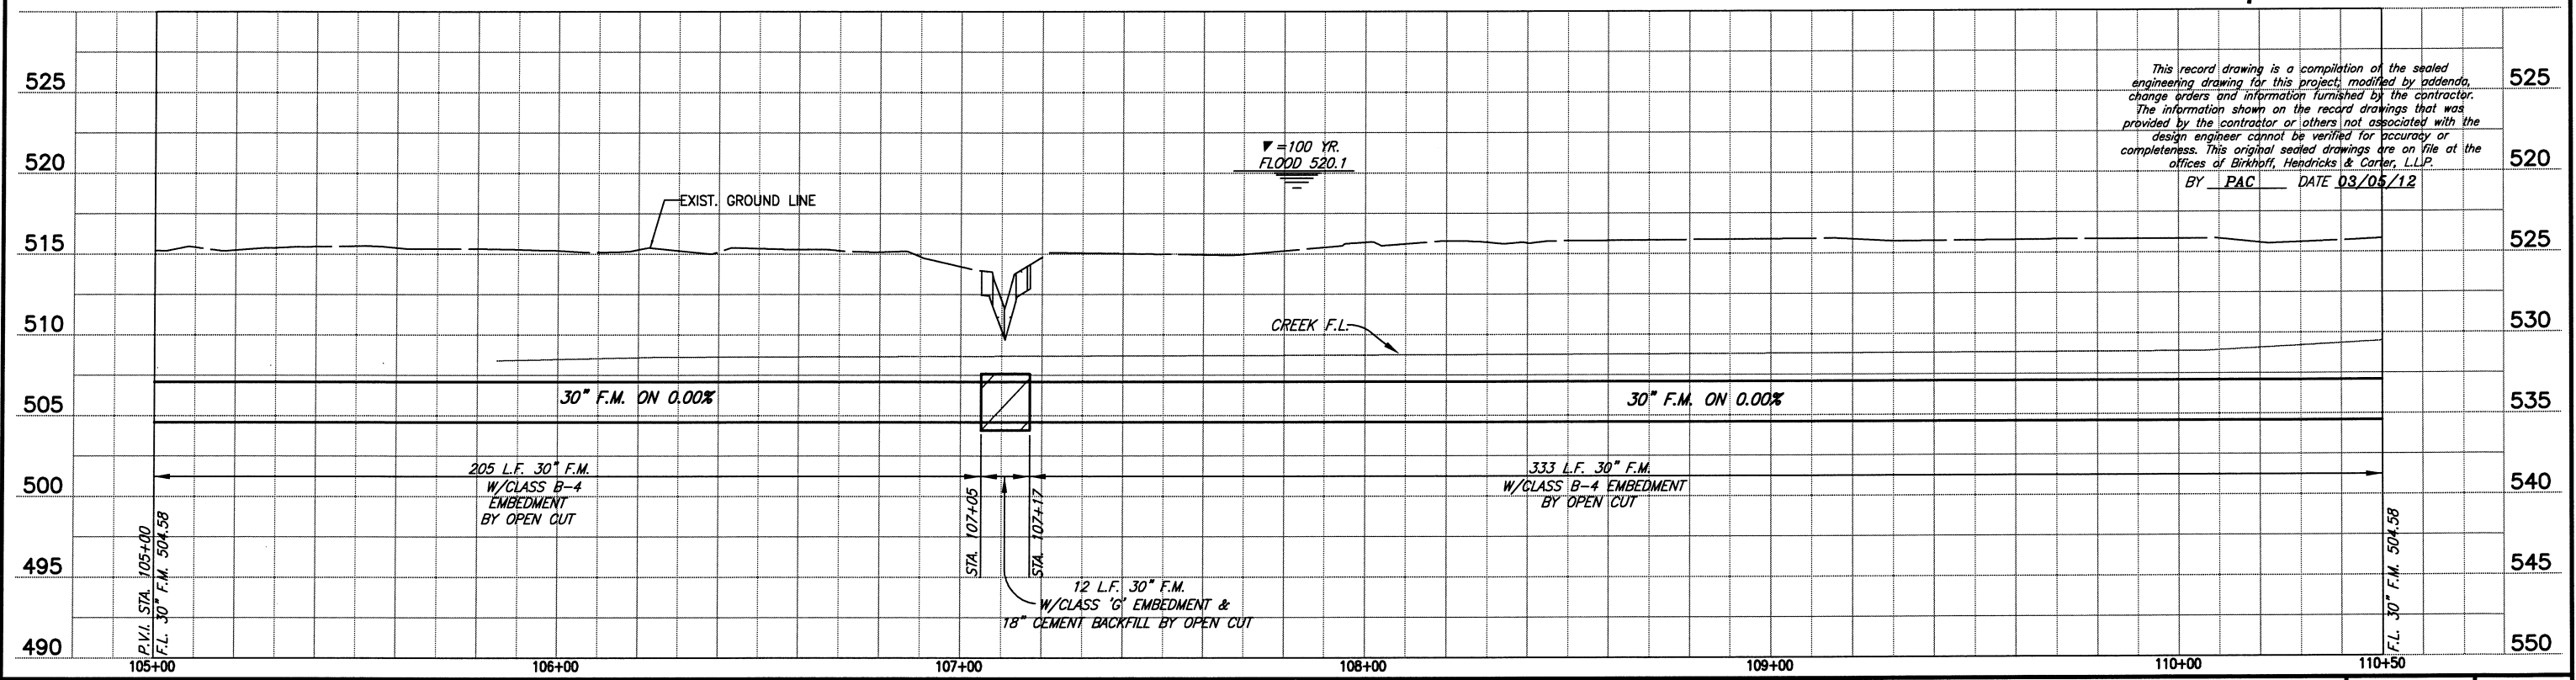


These plans and related specifications were prepared for construction of this specific project only. Reuse of these documents is not permitted without written authorization of Birkhoff, Hendricks, & Carter, L.L.P.

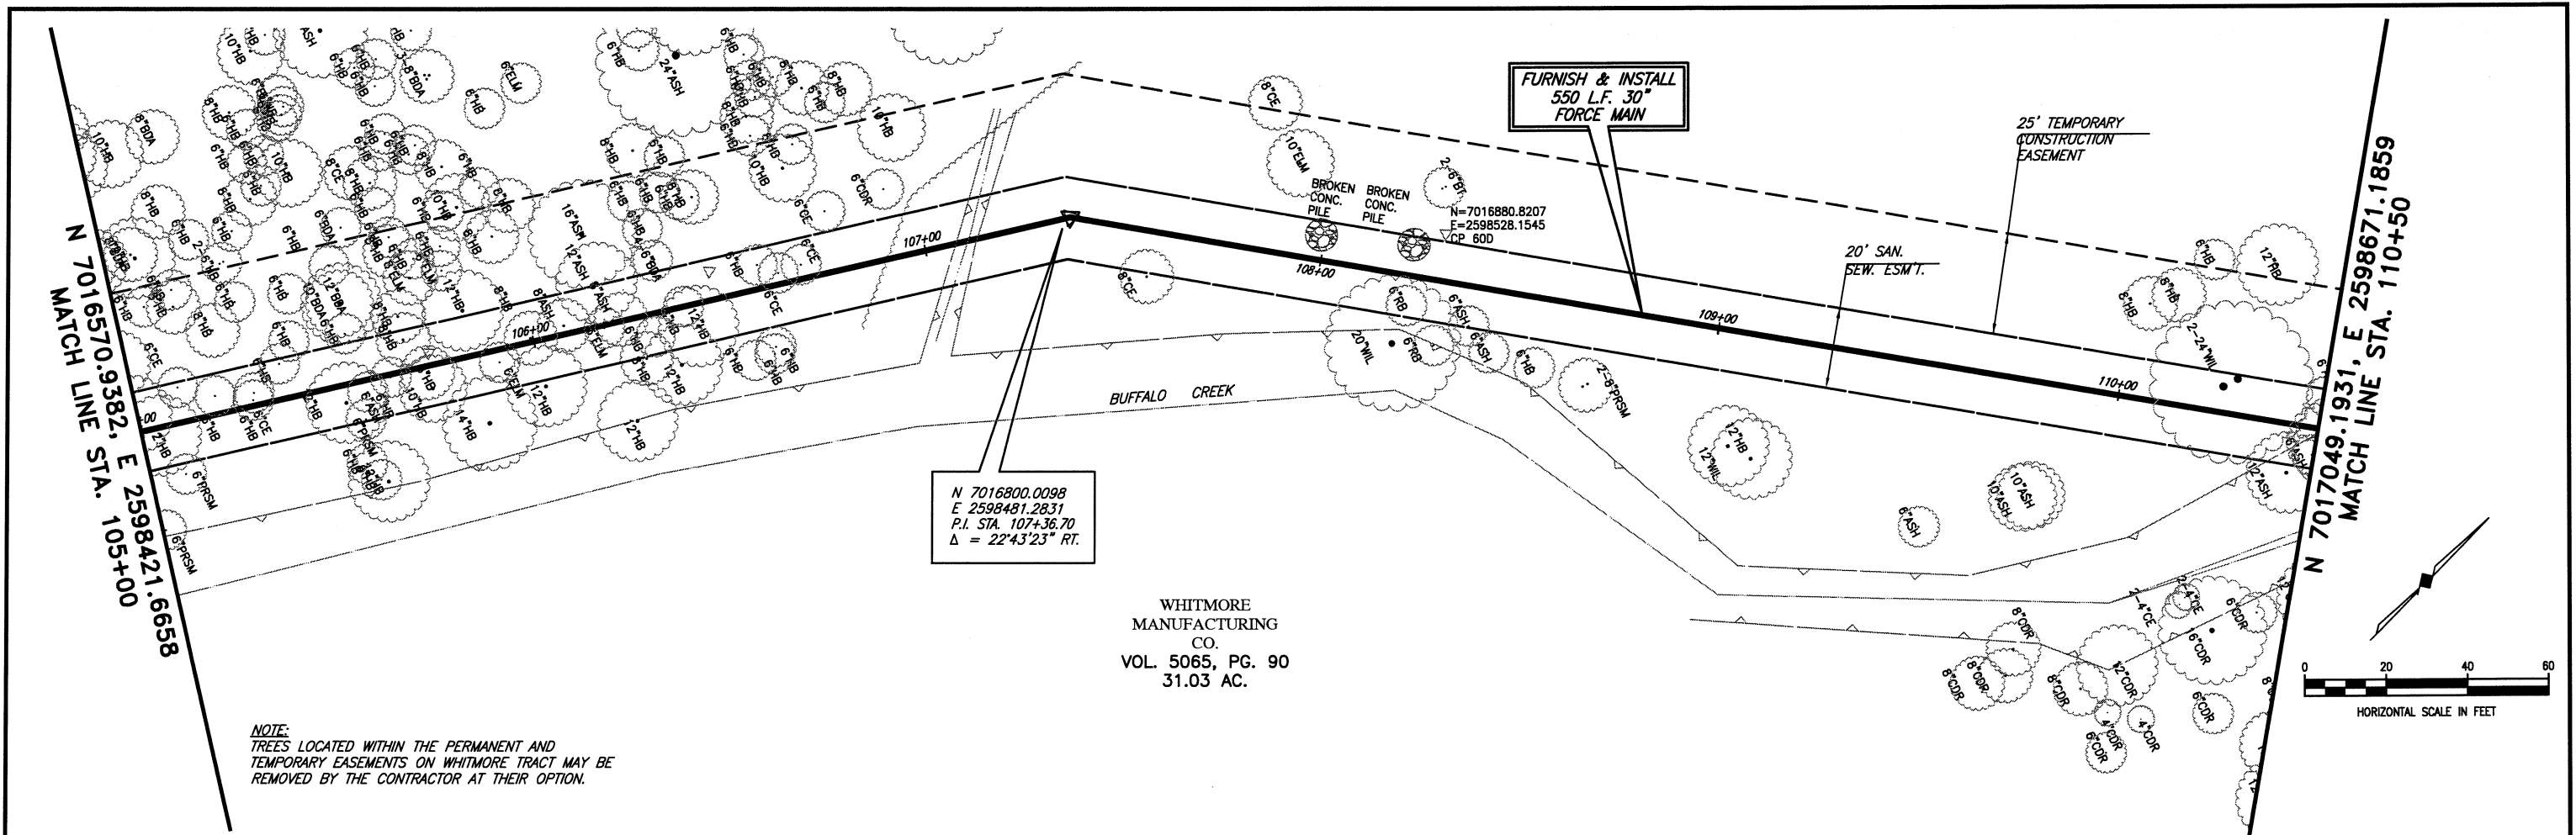

BIRKHOFF, HENDRICKS & CARTER, L.L.P.
 PROFESSIONAL ENGINEERS
 Texas Firm F526
 11910 Greenville Ave., Suite 600
 Dallas, Texas (214) 361-7900

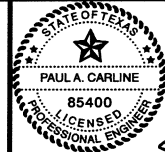

Paul A. Carlisle
 11/17/10

CITY OF ROCKWALL, TEXAS
 SQUABBLE CREEK FORCE MAIN
PLAN AND PROFILE
 STA. 105+00 TO STA. 110+50

BHC
 PROJECT NO.
 2007-110
 November, 2010

SHEET NO.
10