

1860 INVESTMENTS, LTD.
VOL. 4643, PG. 229
11.803 AC.

MATCH LINE STA. 169+50
N 7020043.7219, E 2601630.9022

1860 INVESTMENTS, LTD.
VOL. 4643, PG. 229
11.803 AC.

FURNISH & INSTALL
395 L.F. 30"
FORCE MAIN

N 7020278.7153
E 2601681.2029
P.I. STA. 172+42.77
 $\Delta = 59D31'46" RT.$


EXISTING
30" FORCE MAIN

N 7020335.3361
E 2601766.3151
STA. 173+45
REMOVE 30" PLUG
CONNECT TO 30"
FORCE MAIN


N 7020049.5241
E 2601693.8692
P.I. STA. 170+13.23
 $\Delta = 87'53'55" LT.$

THE CAMBRIDGE COMPANIES, INC.
VOL. 99, PG. 1022
120.989 AC.

This record drawing is a compilation of the sealed engineering drawing for this project, modified by addenda, change orders and information furnished by the contractor. The information shown on the record drawings that was provided by the contractor or others not associated with the design engineer cannot be verified for accuracy or completeness. This original sealed drawings are on file at the offices of Birkhoff, Hendricks & Carter, L.L.P.
BY PAC DATE 03/05/12

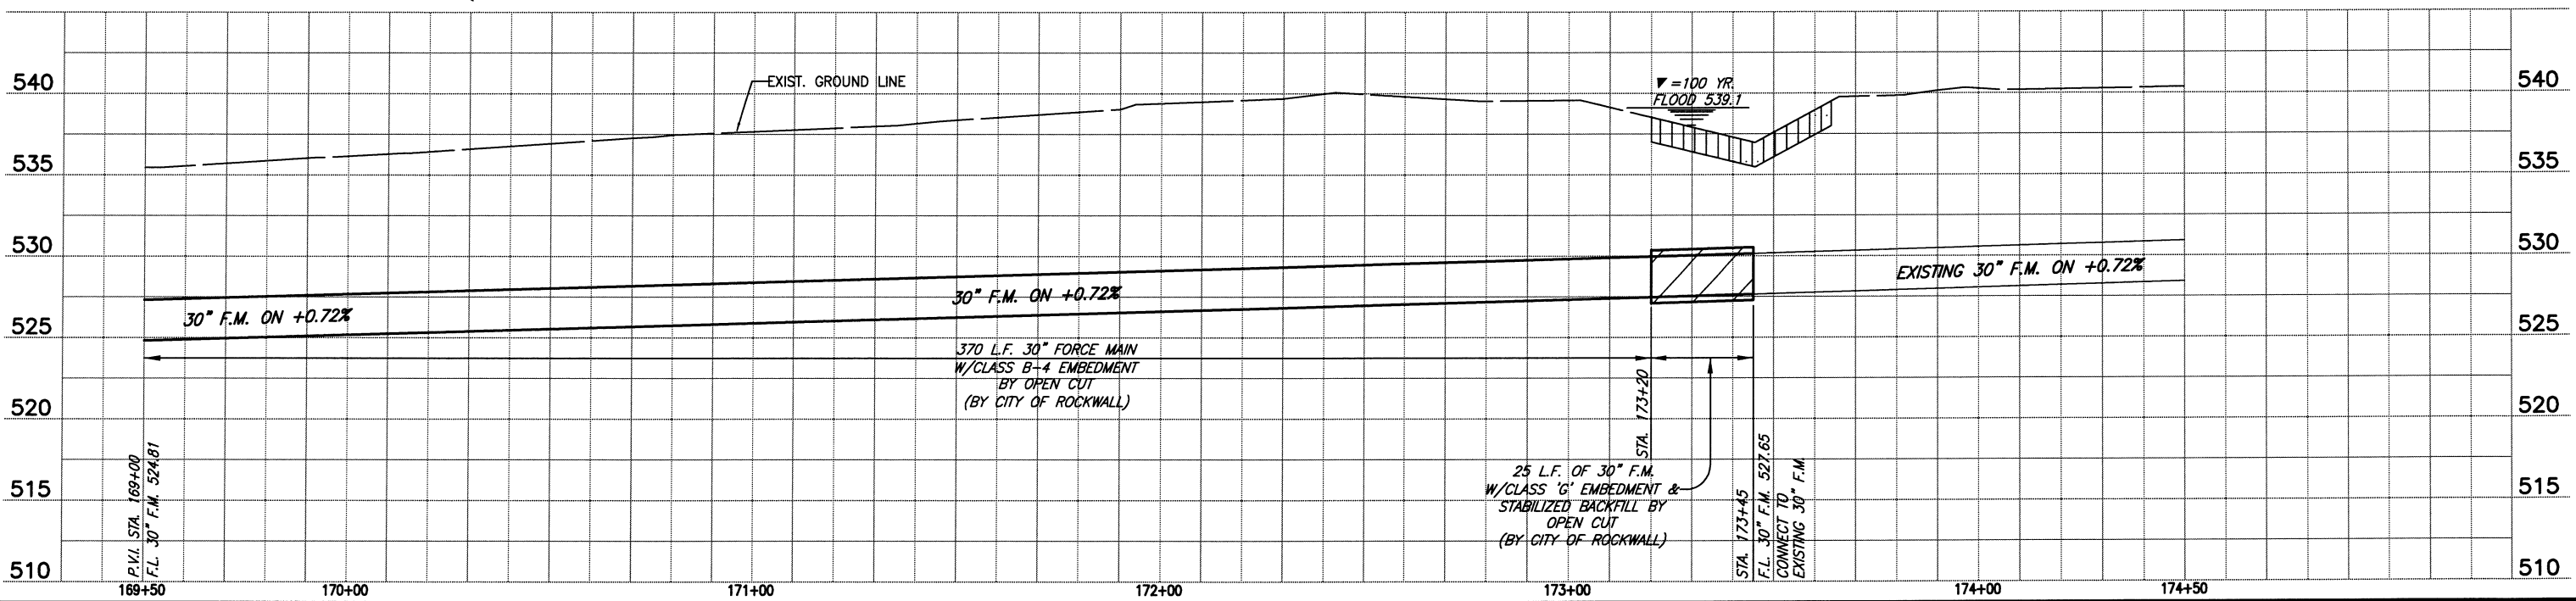

BIRKHOFF, HENDRICKS & CARTER, L.L.P.
PROFESSIONAL ENGINEERS
Texas Firm F526
11910 Greenville Ave., Suite 600
Dallas, Texas (214) 361-7900

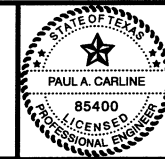

Signature
11/17/10

CITY OF ROCKWALL, TEXAS
SQUABBLE CREEK FORCE MAIN
PLAN AND PROFILE
STA. 169+50 TO STA. 173+45

BHC
PROJECT NO.
2007-110
November, 2010

SHEET NO.
21