
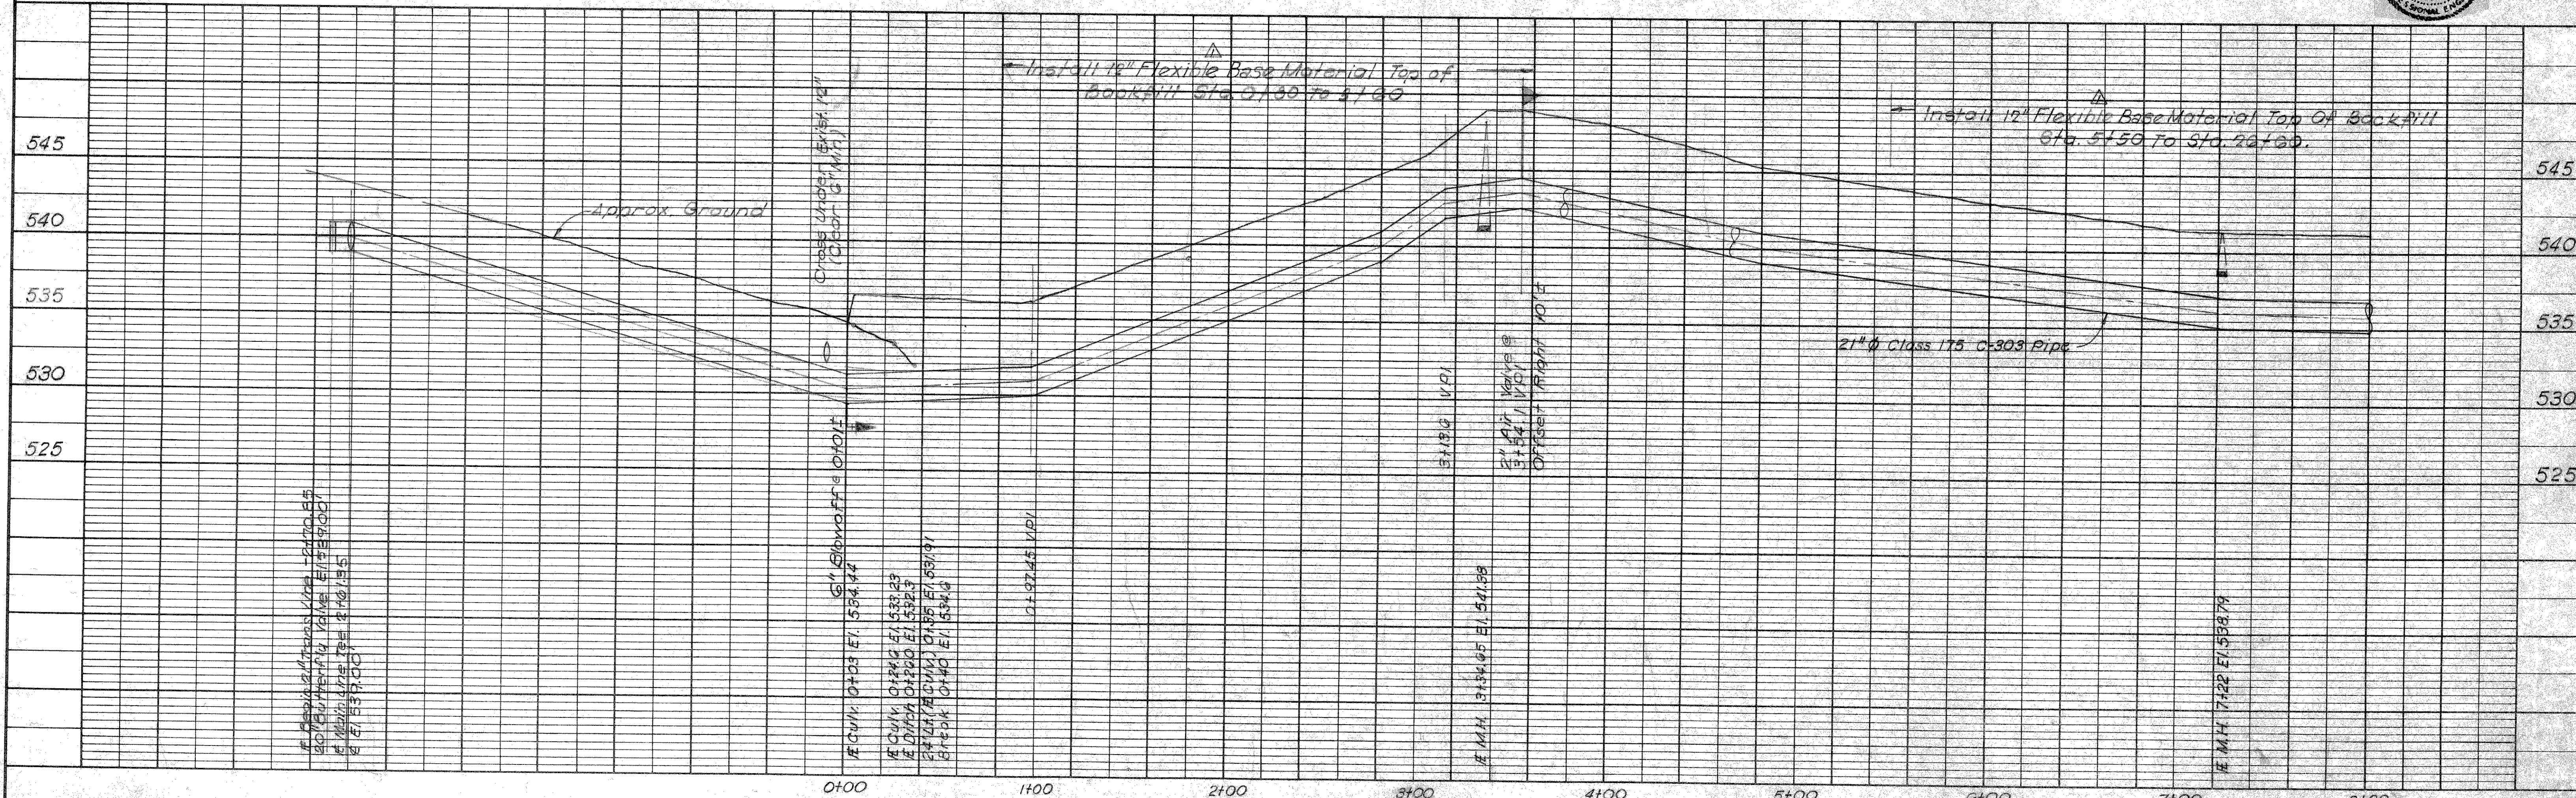


ROCK WALL STATION
WATER STORAGE
SITE

Note:
Apparent Property Lines
Shown Thus

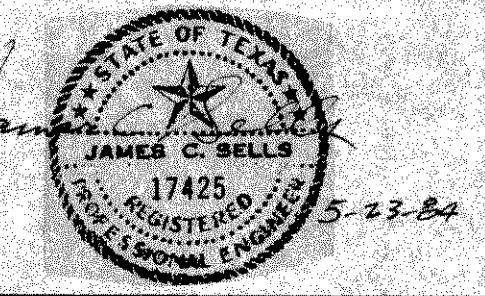

7-2-84 1-2-84 DATE	DESIGNED DRAWN TRACED CHECKED	JCS JCS JCS I.A.R.	JOB NO. DATE SCALE	NTD 83099B 1984 AS SHOWN	FRESE AND NICHOLS, INC. CONSULTING ENGINEERS FORT WORTH-AUSTIN, TEXAS	NORTH TEXAS MUNICIPAL WATER DISTRICT WATER TRANSMISSION SYSTEM	ROCKWALL STATION TO CASH PIPELINE PLAN AND PROFILE	SHEET 2 OF 11
--------------------------	--	-----------------------------	--------------------------	--------------------------------	---	---	---	------------------