



HORIZONTAL CONTROL DATA			
COORDINATES			
MH STATION	NORTH	EAST	DELTA
609+65.18	6997813.76	2596401.66	33° 31' 48" LT
614+33.24	6998002.80	2595973.47	48° 12' 03" RT

SURVEY CONTROL			
COORDINATES			
POINT NO	NORTH	EAST	ELEVATION
562	6997524.31	2596536.53	453.70

- NOTES:**
- SEE SHEET NO. 2 FOR GENERAL PROJECT NOTES.
 - FLOW LINE AT BUFFALO CREEK SHOWN FOR REFERENCE ONLY.

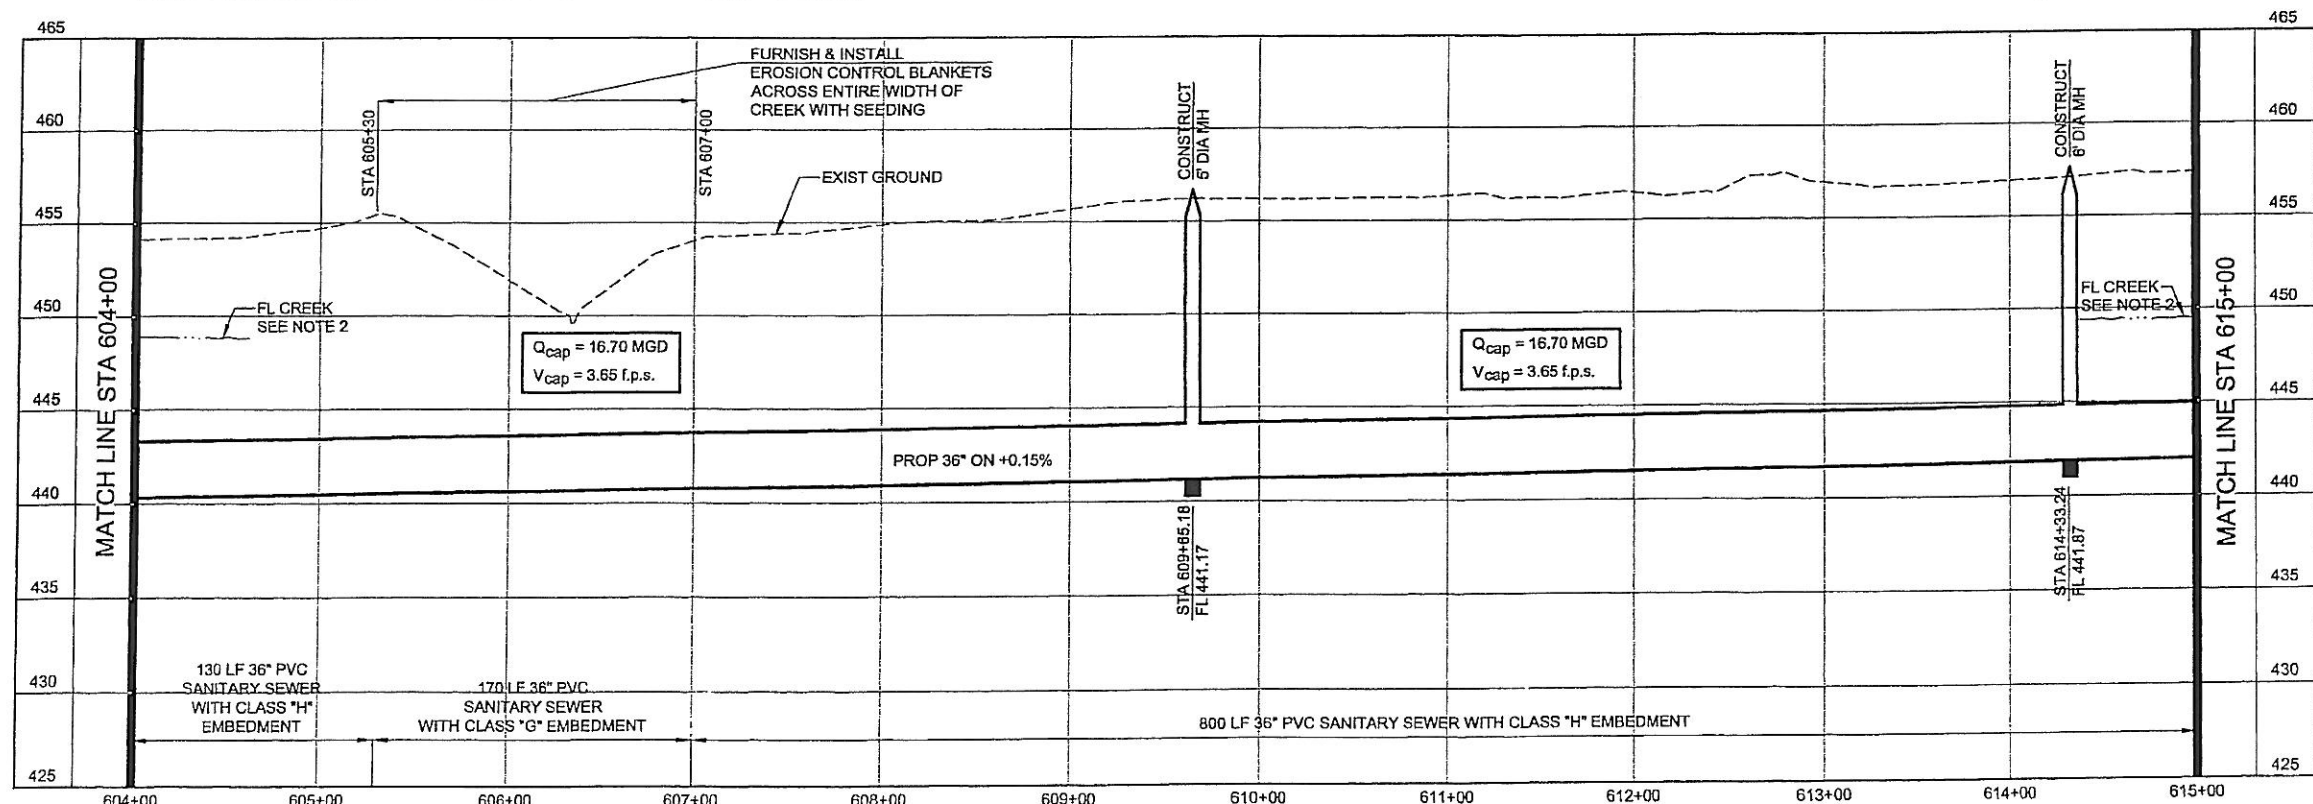

NORTH TEXAS MUNICIPAL WATER DISTRICT
ROCKWALL-HEATH TRANSFER SEWER RHC# 01-1, SECTION 2
SANITARY SEWER PLAN AND PROFILE 604+00 TO 615+00

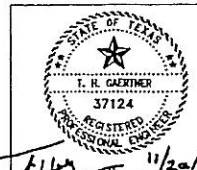

NO	DATE	REVISIONS	MADE/CKD	JOB NO.

DESIGNED	KBR	HORIZ. SCALE	1"=50'
DRAWN	KBR	VERT. SCALE	1"=5'
CHECKED	THG	DATE	SEPTEMBER 26, 2003