
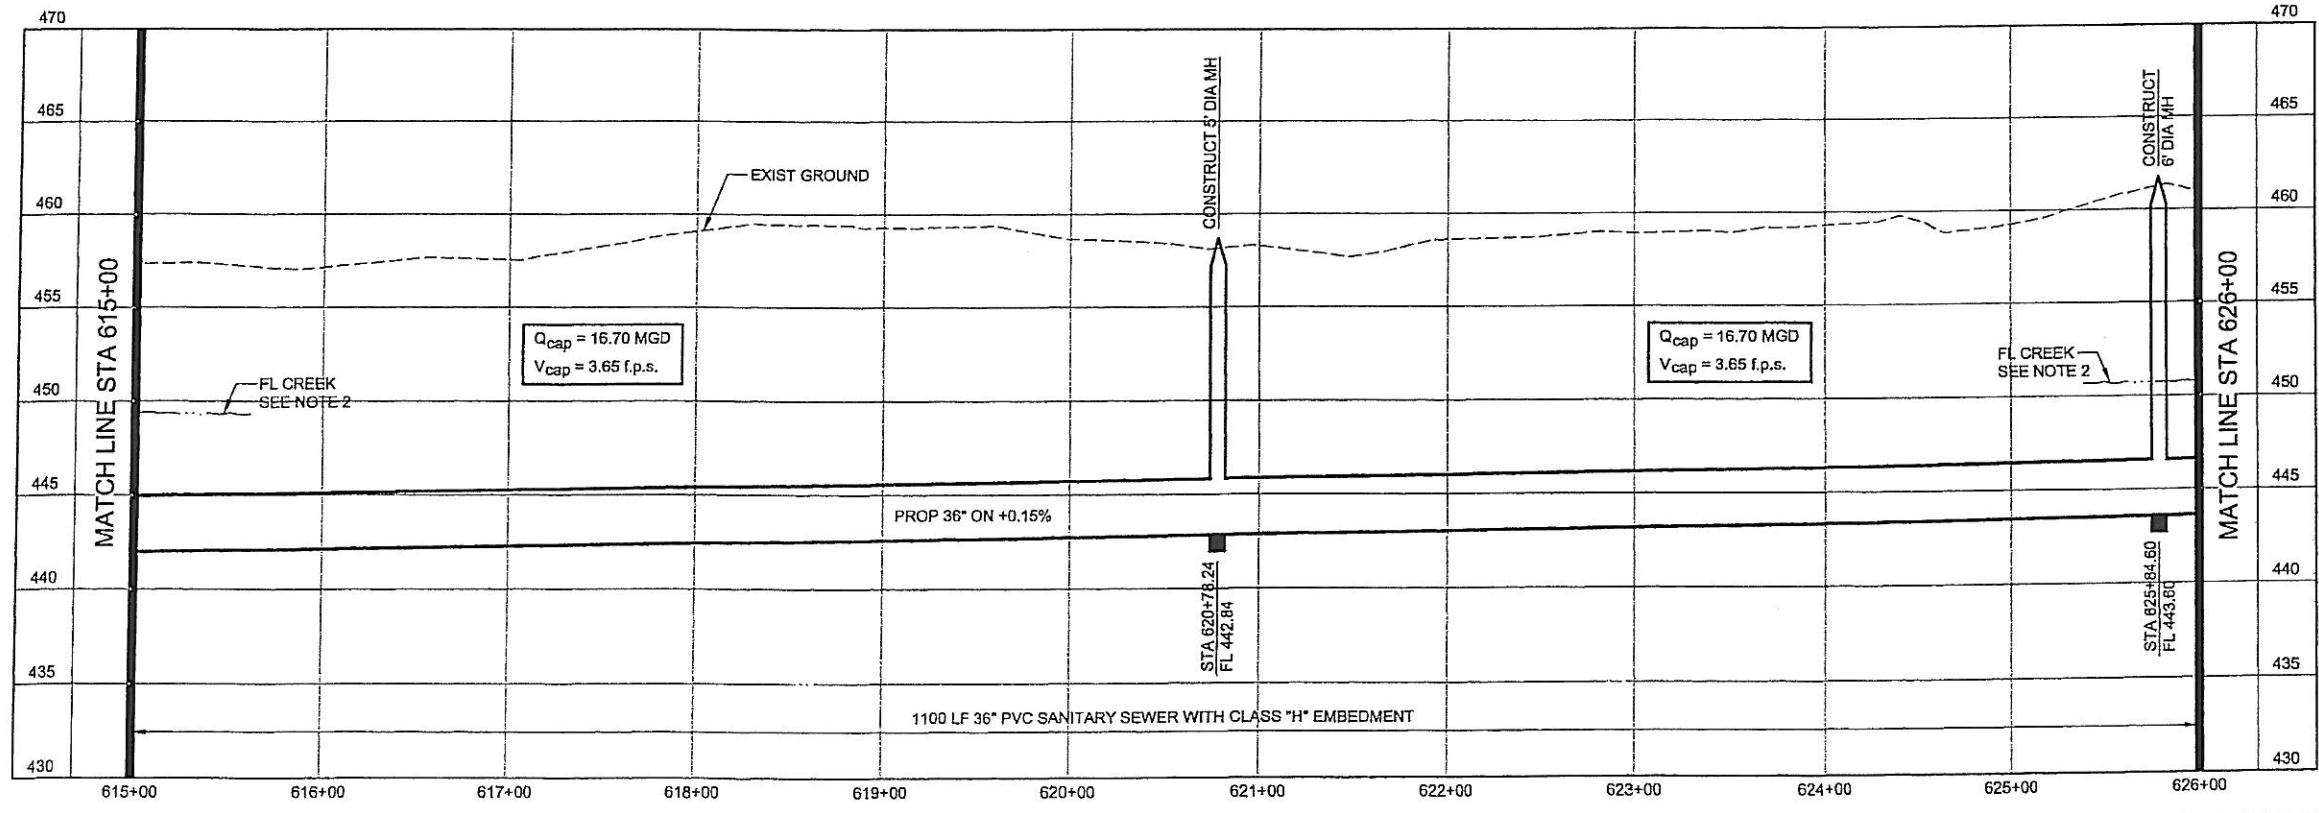


HORIZONTAL CONTROL DATA			
COORDINATES			
MH STATION	NORTH	EAST	DELTA
620+78.24	6998516.56	2595774.29	00° 00' 00"
625+84.60	6999097.94	2595618.09	62° 40' 34" RT

SURVEY CONTROL			
COORDINATES			
POINT NO	NORTH	EAST	ELEVATION
556	6998701.65	2595709.07	459.89
560	6998064.20	2595937.48	457.49


- NOTES:**
- SEE SHEET NO. 2 FOR GENERAL PROJECT NOTES.
 - FLOW LINE AT BUFFALO CREEK SHOWN FOR REFERENCE ONLY.

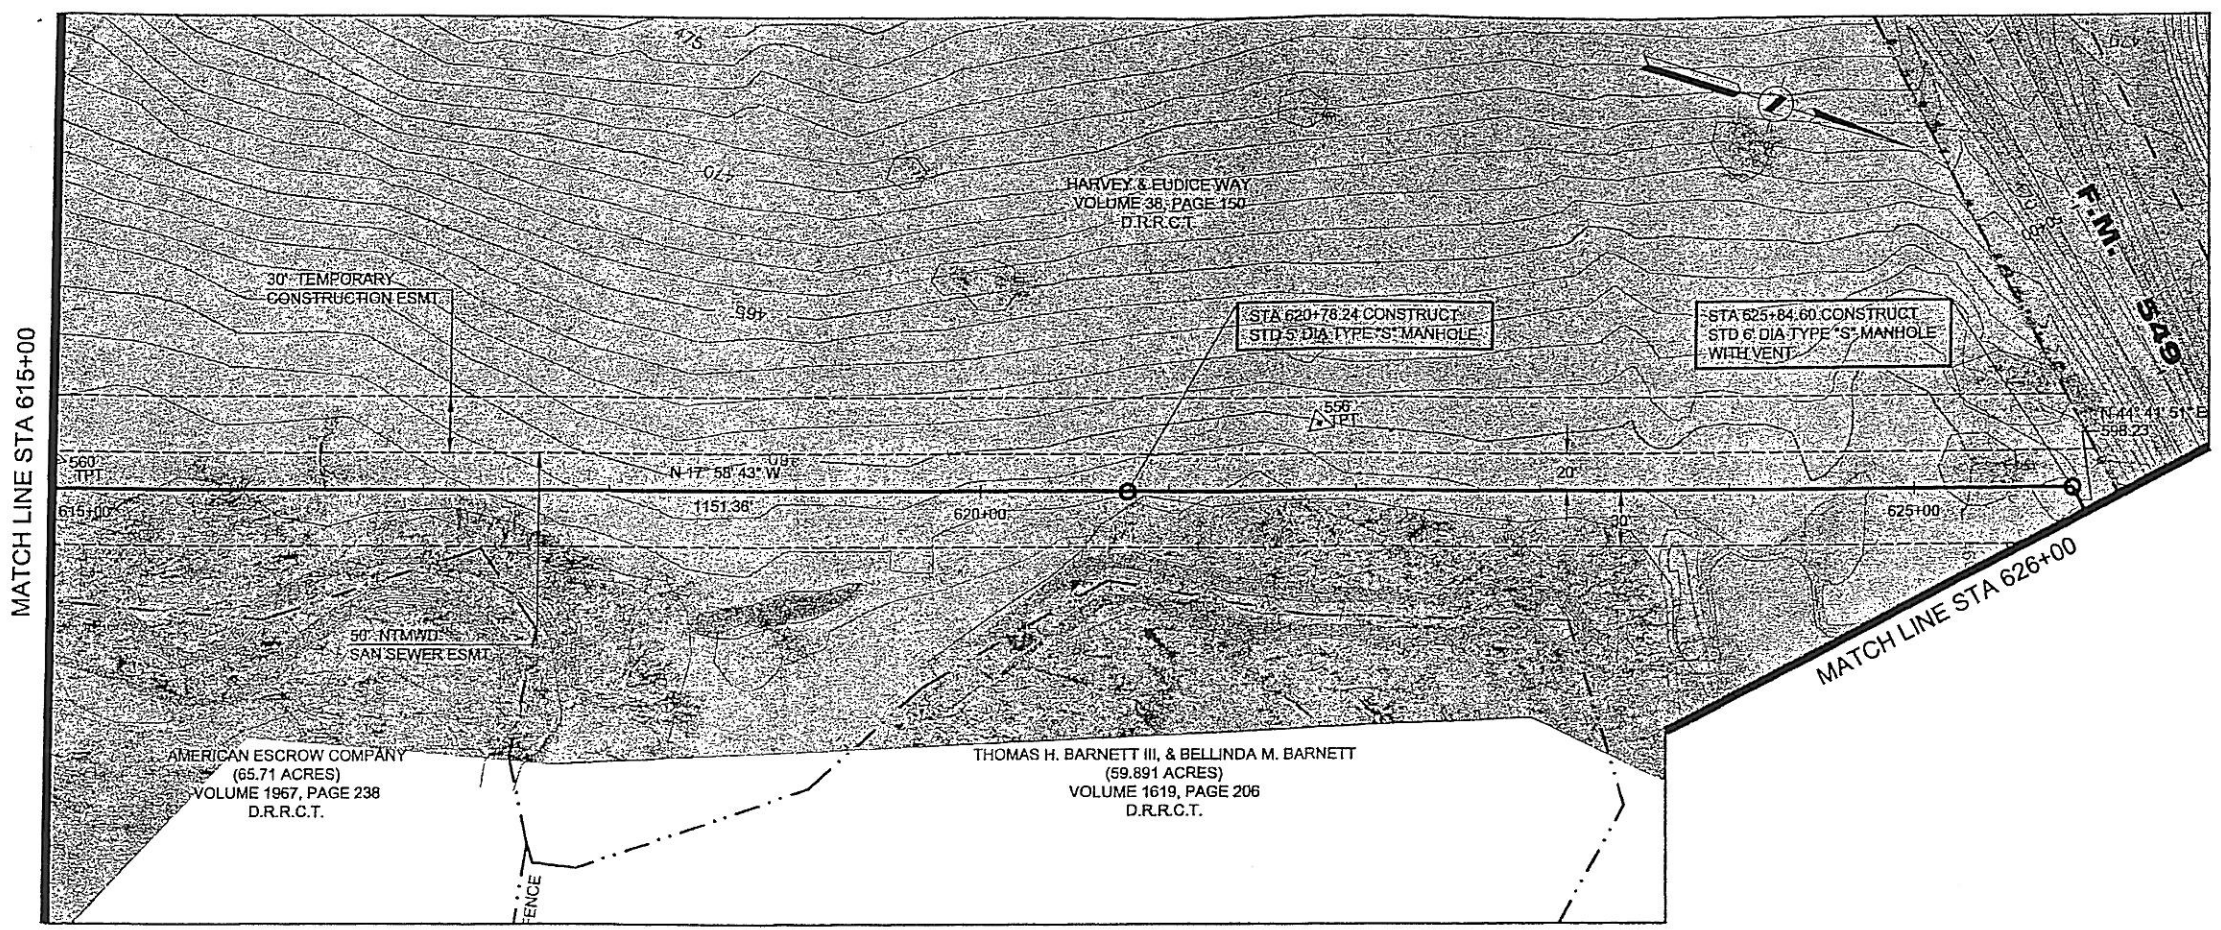

NORTH TEXAS MUNICIPAL WATER DISTRICT
ROCKWALL-HEATH TRANSFER SEWER RHC# 01-1, SECTION 2
SANITARY SEWER PLAN AND PROFILE 615+00 TO 626+00

KBR
 Kellogg Brown & Root, Inc.
 Engineered by KBR Technical Services, Inc.

DESIGNED:	KBR	HORIZ. SCALE:	1"=50'
DRAWN:	KBR	VERT. SCALE:	1"=5'
CHECKED:	THG	DATE:	SEPTEMBER 26, 2003
MADE/CKD:		JOB NO.:	CM-0148
		DWG. NO.:	15 OF 36

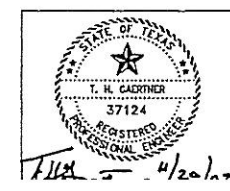

NO.	DATE	REVISIONS	MADE/CKD	JOB NO.	DWG. NO.