



HORIZONTAL CONTROL DATA			
COORDINATES			
MH STATION	NORTH	EAST	DELTA
650+95.21	7001111.05	2596480.51	68° 18' 36" LT
656+91.22	7001706.88	2596495.13	44° 02' 30" LT

SURVEY CONTROL			
COORDINATES			
POINT NO	NORTH	EAST	ELEVATION
542	7001737.18	2596426.32	465.99
546	7001154.67	2596541.43	465.32

- NOTES:**
- SEE SHEET NO. 2 FOR GENERAL PROJECT NOTES.
  - FLOW LINE AT BUFFALO CREEK SHOWN FOR REFERENCE ONLY.

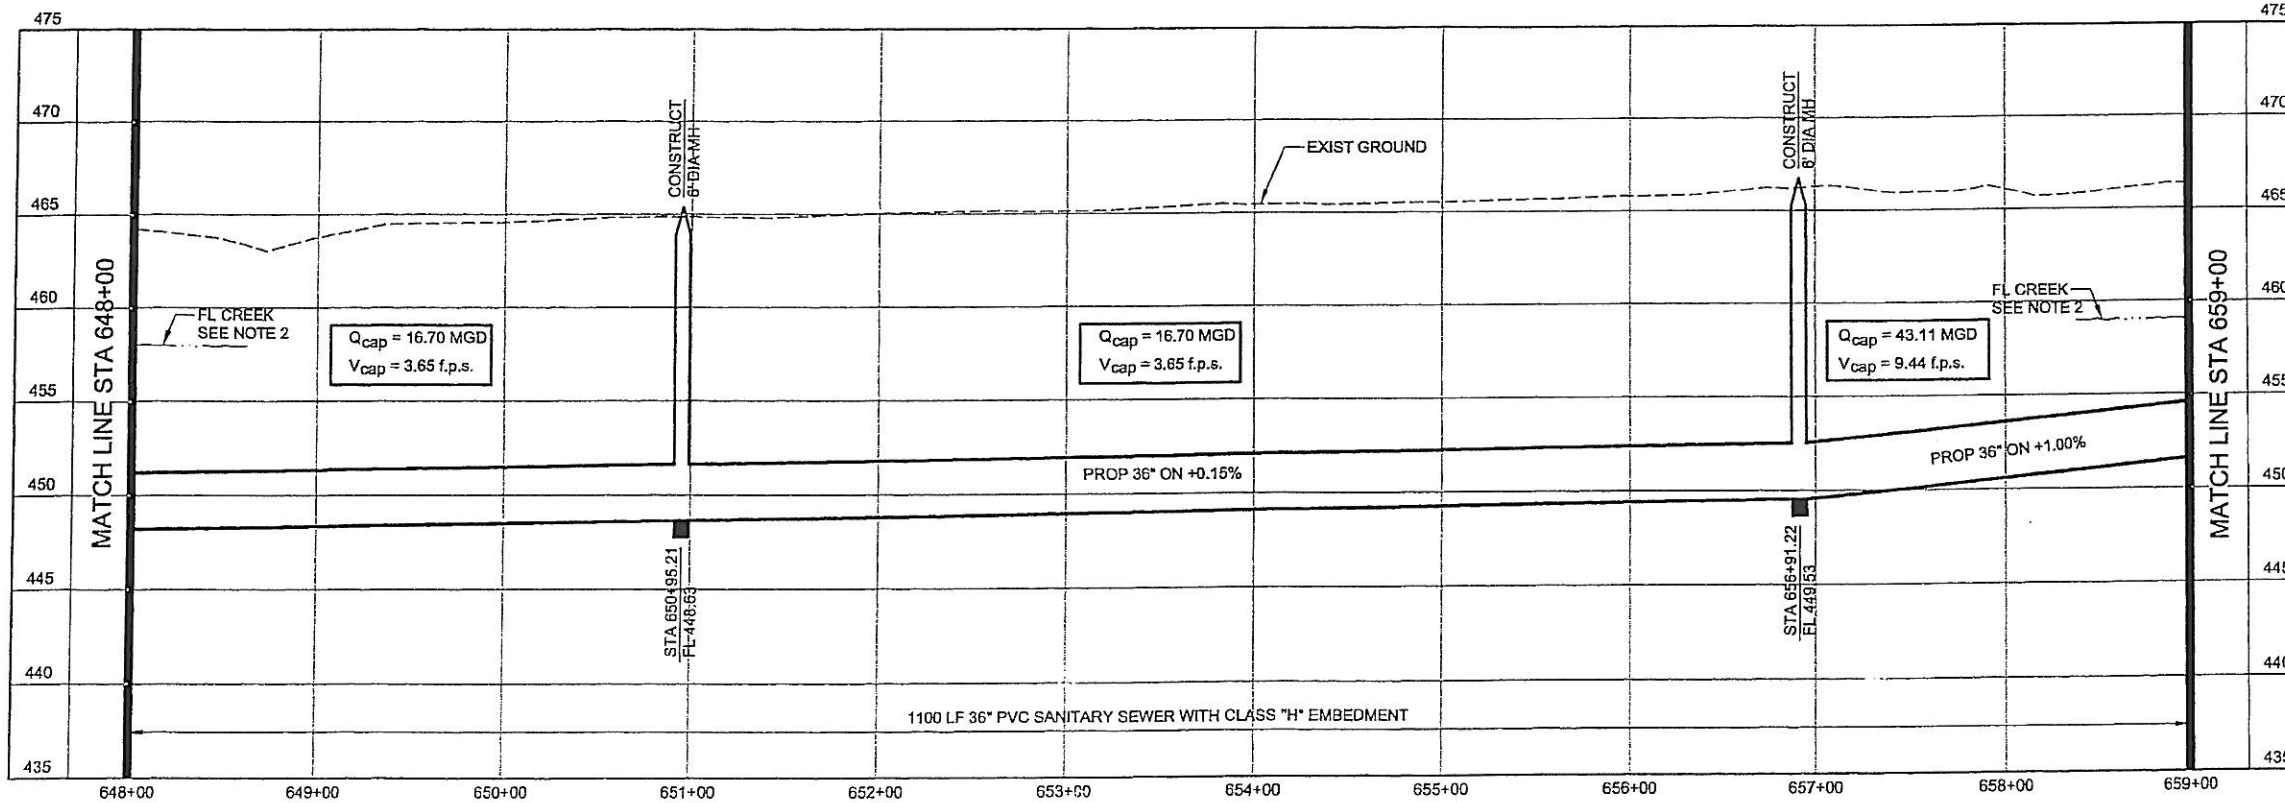

**NORTH TEXAS MUNICIPAL WATER DISTRICT**  
**ROCKWALL-HEATH TRANSFER SEWER RHC# 01-1, SECTION 2**  
**SANITARY SEWER PLAN AND PROFILE 648+00 TO 659+00**

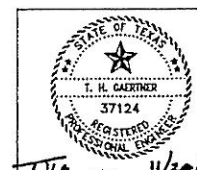

NO.	DATE	REVISIONS	MADE/CKD	JOB NO.	DWG. NO.

**KBR**  
 Kellogg Brown & Root, Inc.  
 Engineered by KBR Technical Services, Inc.

DESIGNED KBR HORIZ. SCALE 1"=50'  
 DRAWN KBR VERT. SCALE 1"=5'  
 CHECKED THG DATE SEPTEMBER 26, 2003

CM-0148 DWG. NO. 18 OF 36