



HORIZONTAL CONTROL DATA			
MH STATION	COORDINATES		
	NORTH	EAST	DELTA
661+81.41	7002067.50	2596163.11	11° 22' 00" RT
664+02.05	7002256.09	2596048.59	28° 26' 07" RT
667+97.53	7002551.08	2596029.04	25° 53' 46" LT

SURVEY CONTROL			
POINT NO	COORDINATES		
	NORTH	EAST	ELEVATION
538	7002668.17	2596008.76	473.16
540	7002310.76	2596059.81	467.58
1345	7002434.16	2596211.02	464.47
1365	7002030.31	2596239.28	466.70

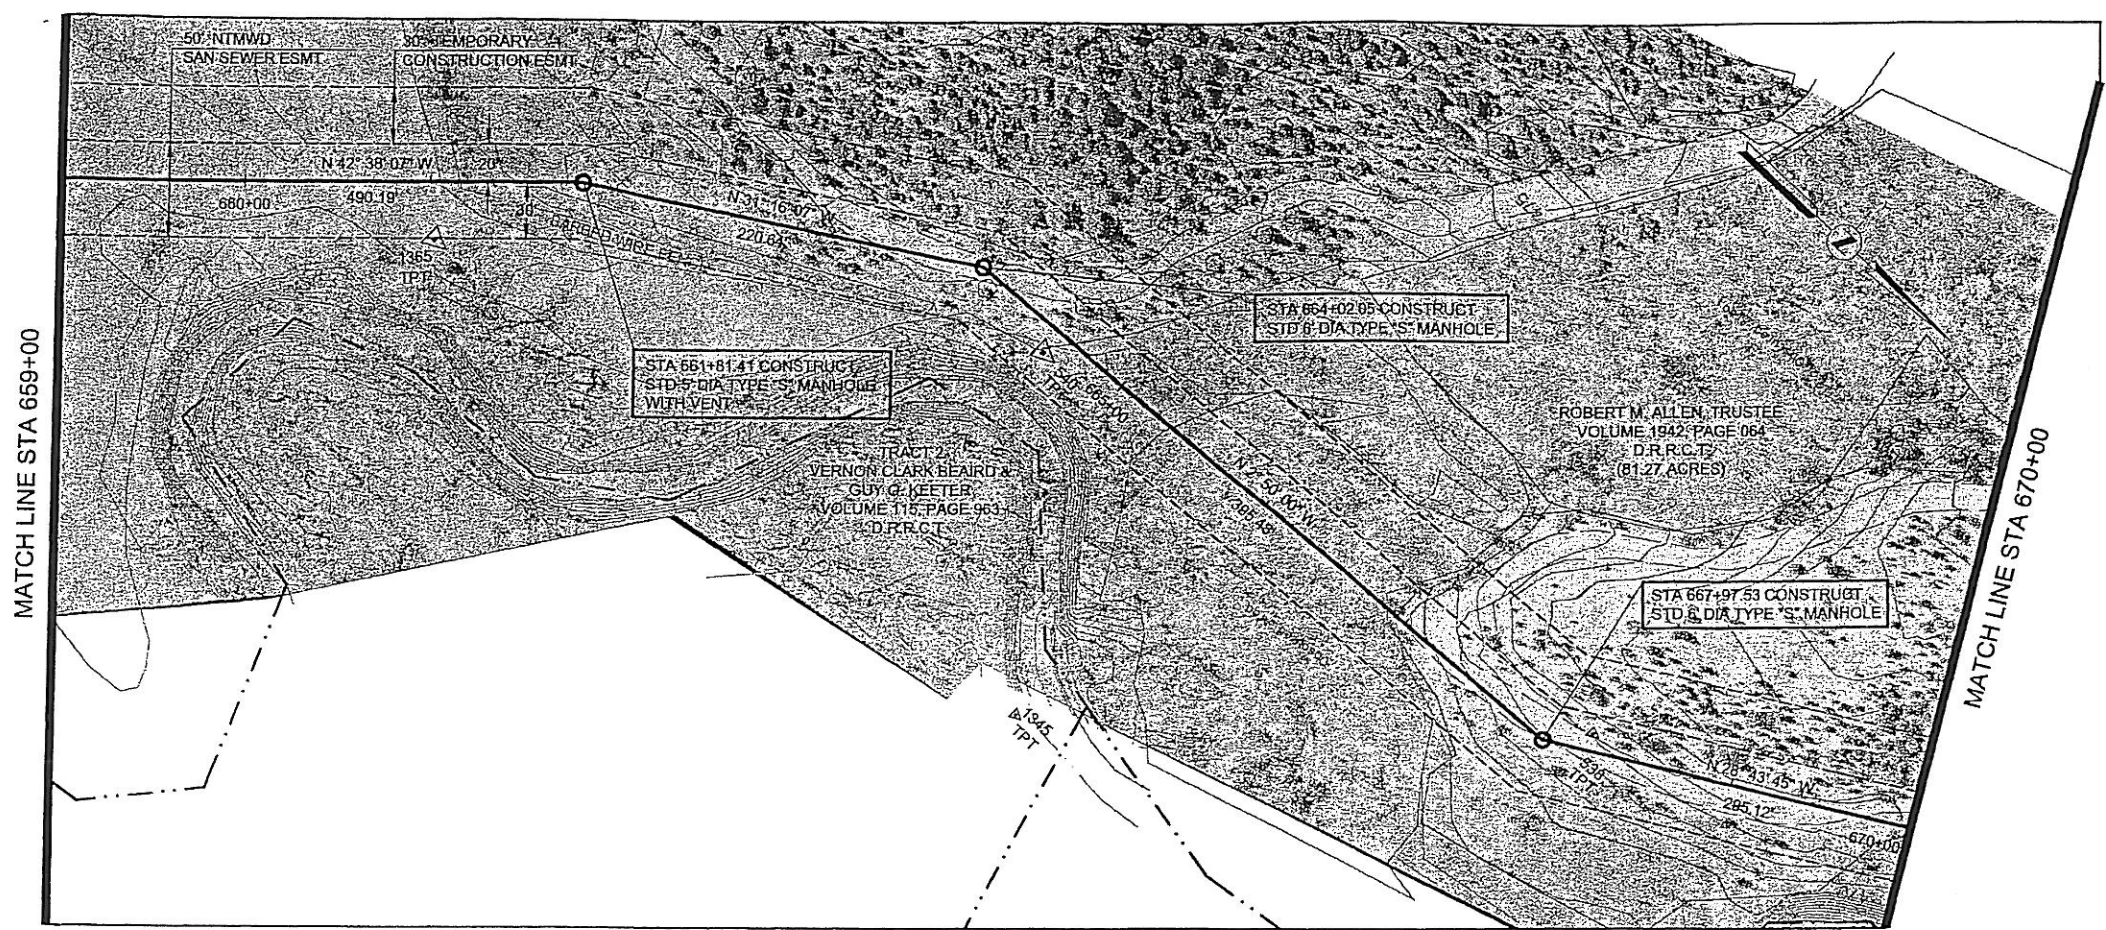

- NOTES:**
- SEE SHEET NO. 2 FOR GENERAL PROJECT NOTES.
 - FLOW LINE AT BUFFALO CREEK SHOWN FOR REFERENCE ONLY.

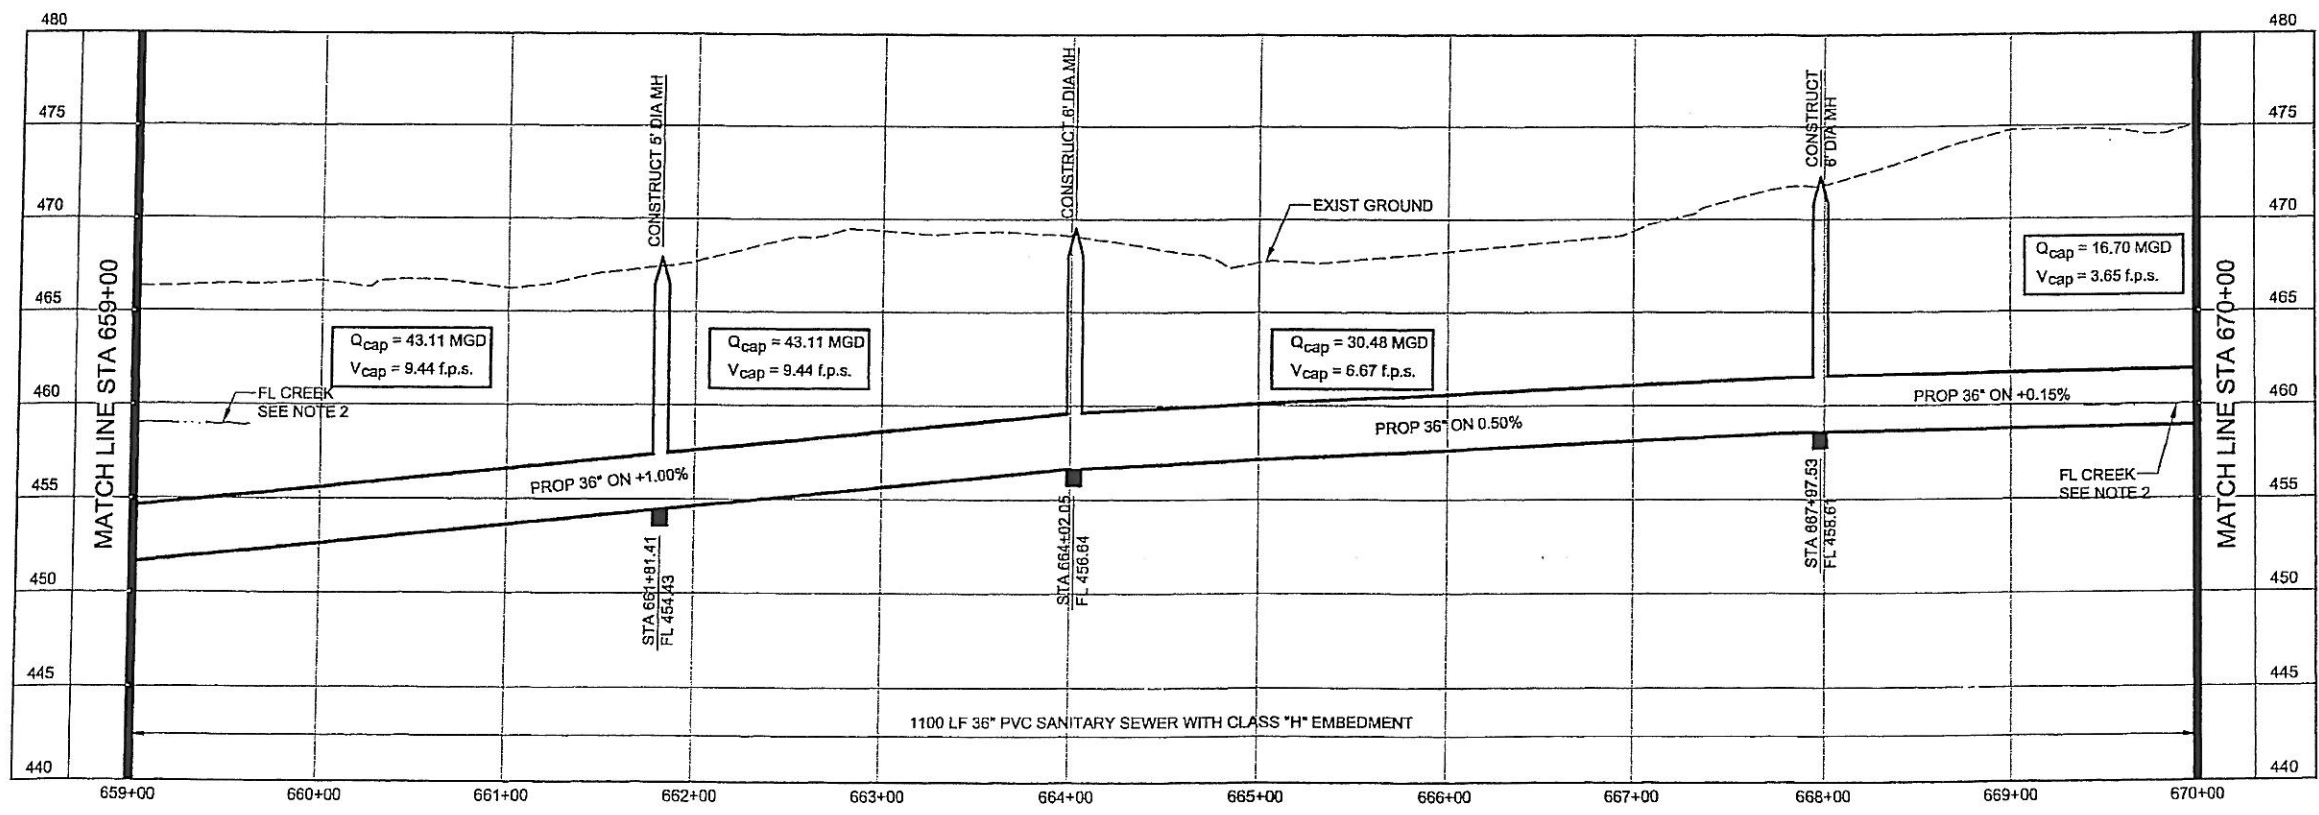

NORTH TEXAS MUNICIPAL WATER DISTRICT
ROCKWALL-HEATH TRANSFER SEWER RHC# 01-1, SECTION 2
SANITARY SEWER PLAN AND PROFILE 659+00 TO 670+00

KBR
 Kellogg Brown & Root, Inc.
 Engineered by KBR Technical Services, Inc.

DESIGNED	KBR	HORIZ. SCALE	1"=50'
DRAWN	KBR	VERT. SCALE	1"=5'
CHECKED	THG	DATE	SEPTEMBER 26, 2003
MADE/CKD		JOB NO.	CM-0148
		DWG. NO.	19 OF 36

