


HORIZONTAL CONTROL DATA			
COORDINATES			
MH STATION	NORTH	EAST	DELTA
670+92.65	7002909.87	2595687.19	06° 16' 49" LT
673+48.86	7003111.72	2595729.38	26° 05' 59" RT


SURVEY CONTROL			
COORDINATES			
POINT NO	NORTH	EAST	ELEVATION
534	7003574.69	2595673.64	473.79
536	7003109.45	2595730.93	479.76
1000	7003710.45	2595647.18	467.41

MATCH LINE STA 681+00

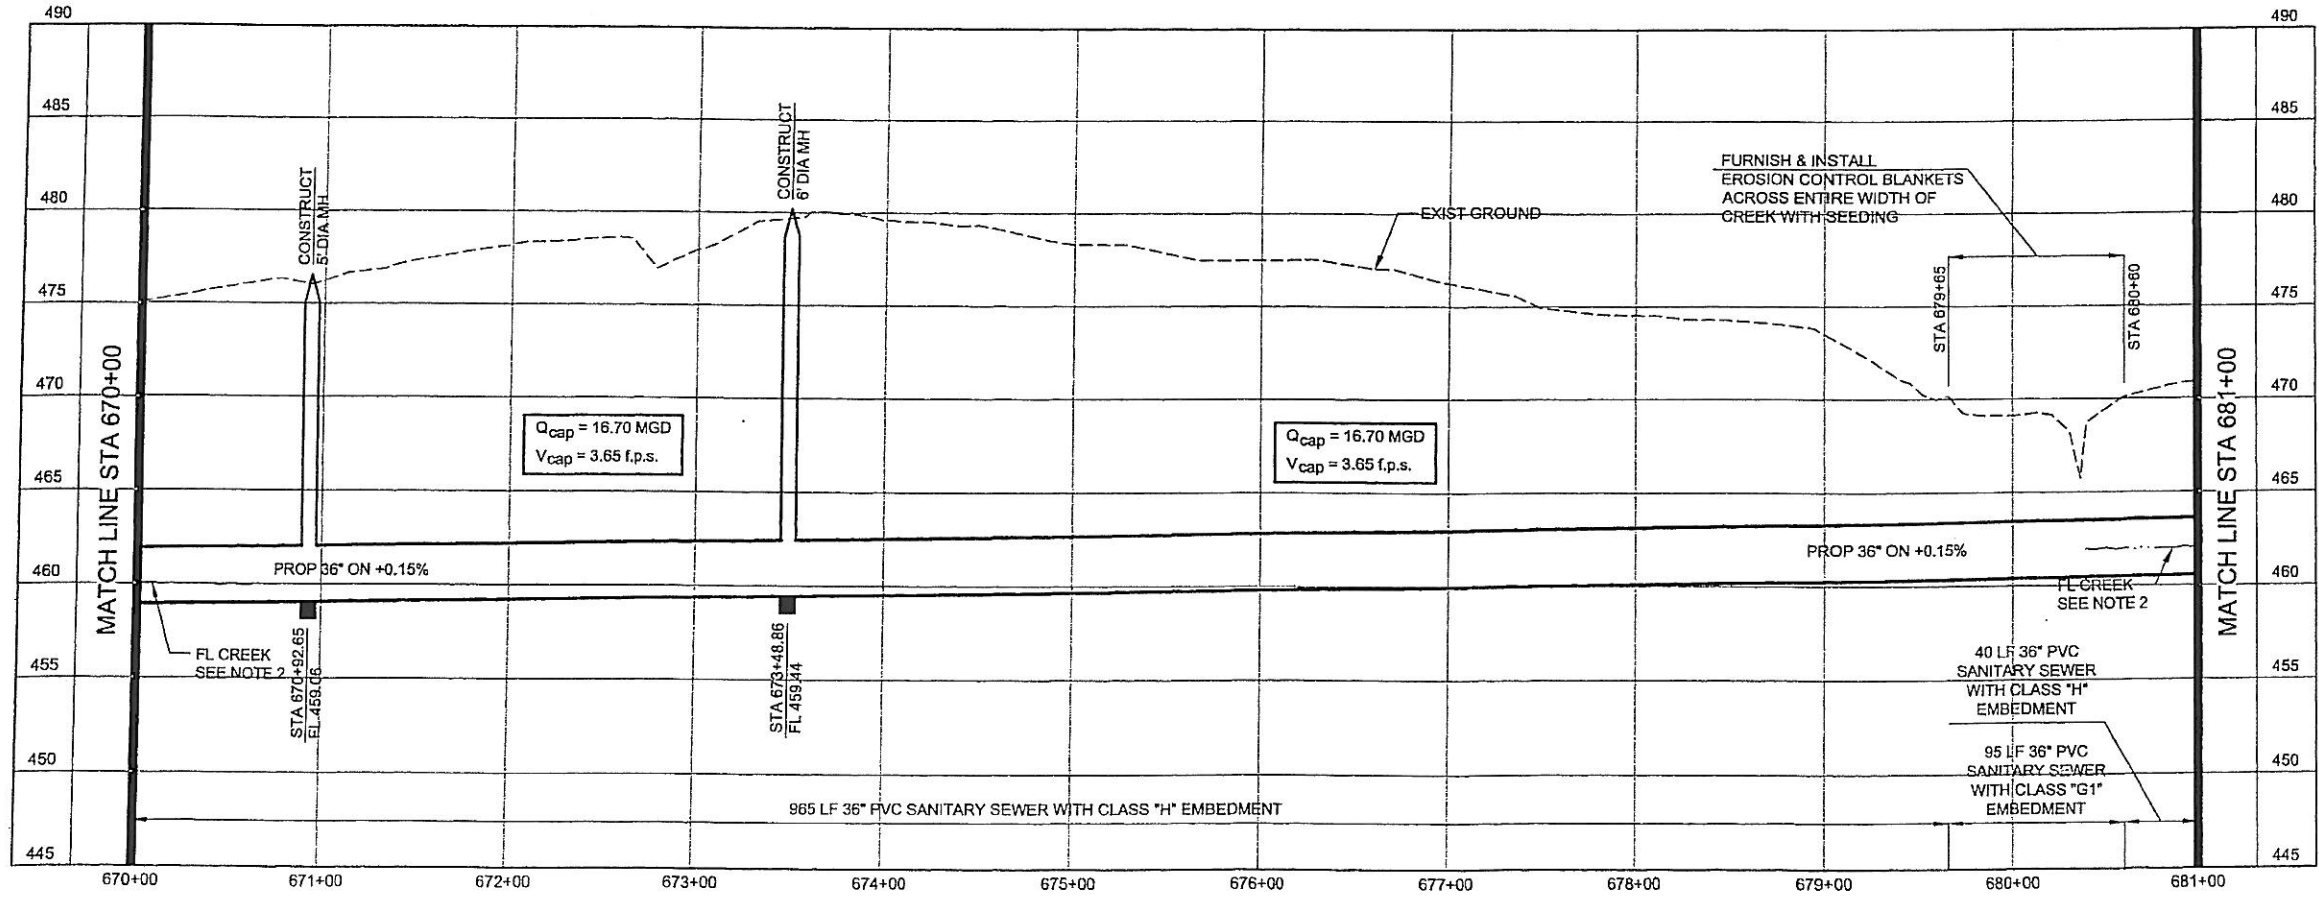

- NOTES:**
- SEE SHEET NO. 2 FOR GENERAL PROJECT NOTES.
 - FLOW LINE AT BUFFALO CREEK SHOWN FOR REFERENCE ONLY.

NORTH TEXAS MUNICIPAL WATER DISTRICT
ROCKWALL-HEATH TRANSFER SEWER RHC# 01-1, SECTION 2
SANITARY SEWER PLAN AND PROFILE 670+00 TO 681+00

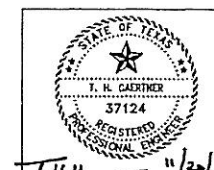

NO.	DATE	REVISIONS	MADE BY	CHKD BY	JOB NO.

KBR
Kellogg Brown & Root, Inc.
 Engineered by KBR Technical Services, Inc.

DESIGNED	KBR	HORIZ. SCALE	1"=50'
DRAWN	KBR	VERT. SCALE	1"=5'
CHECKED	THG	DATE	SEPTEMBER 26, 2003

CM-0148 | DWG. NO. 20 OF 36