


- LEGEND**
- (B) - BLOCK LABEL
 - (IN) - INLET NUMBER
 - (C) - CURVE NUMBER
 - - SANITARY SEWER
 - - WATER
 - - PROPOSED STORM SEWER
 - - EXISTING STORM SEWER

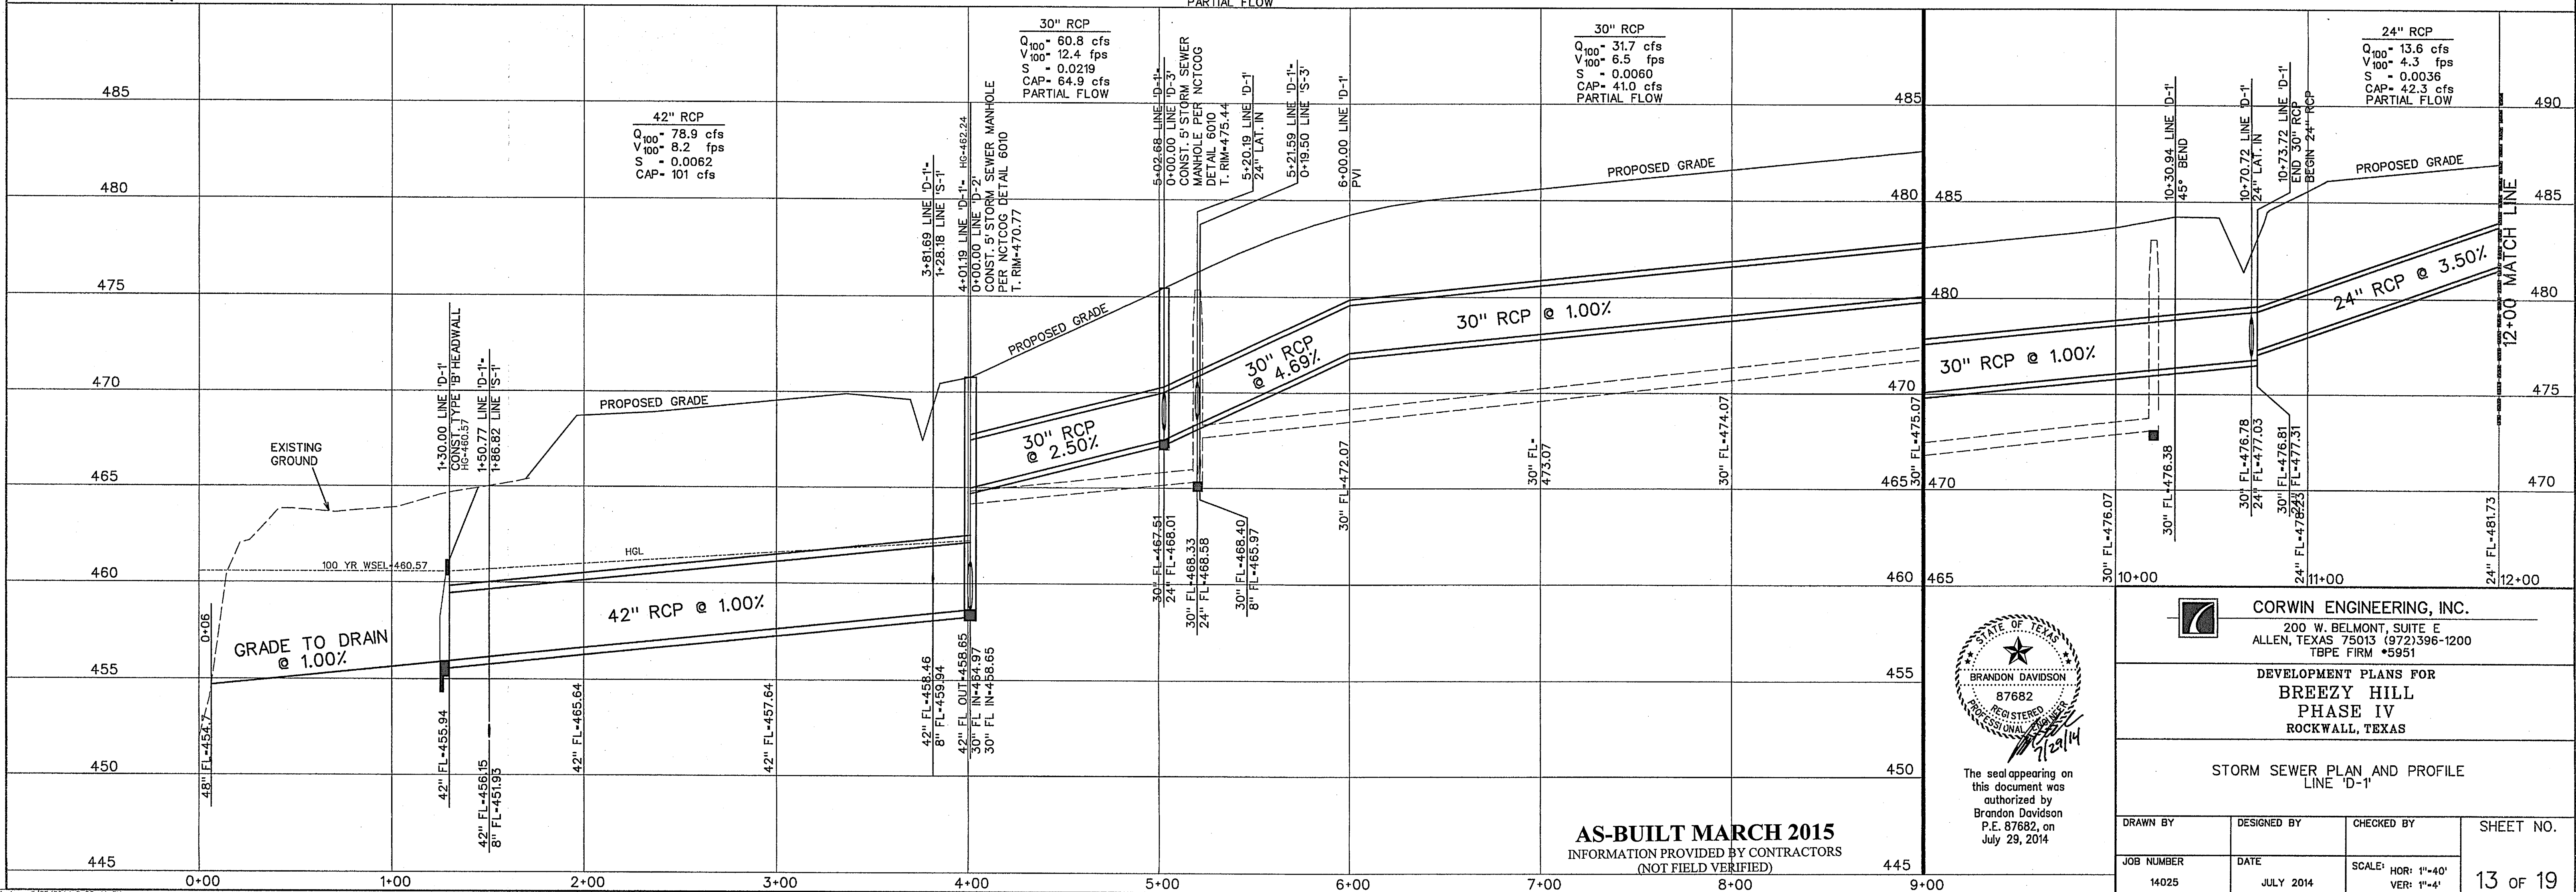

AS-BUILT MARCH 2015
INFORMATION PROVIDED BY CONTRACTORS
(NOT FIELD VERIFIED)



The seal appearing on this document was authorized by Brandon Davidson P.E. 87682, on July 29, 2014

CORWIN ENGINEERING, INC.
200 W. BELMONT, SUITE E
ALLEN, TEXAS 75013 (972)396-1200
TPE FIRM #5951

DEVELOPMENT PLANS FOR
**BREEZY HILL
PHASE IV**
ROCKWALL, TEXAS

STORM SEWER PLAN AND PROFILE
LINE 'D-1'

DRAWN BY	DESIGNED BY	CHECKED BY	SHEET NO.
JOB NUMBER	DATE	SCALE: HOR: 1"=40' VER: 1"=4'	13 of 19
14025	JULY 2014		