




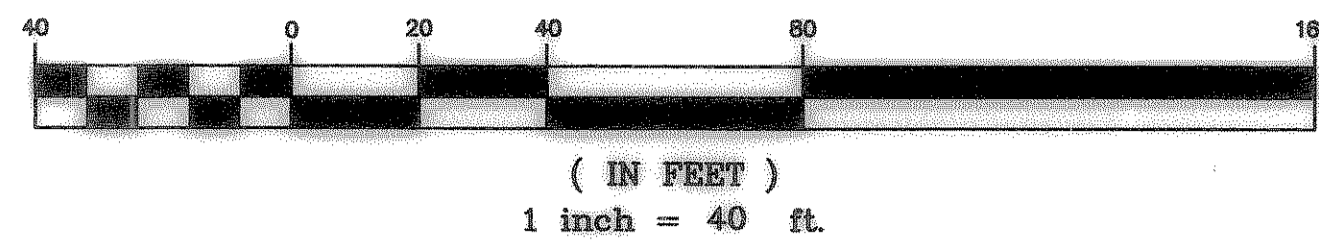

GRAPHIC SCALE

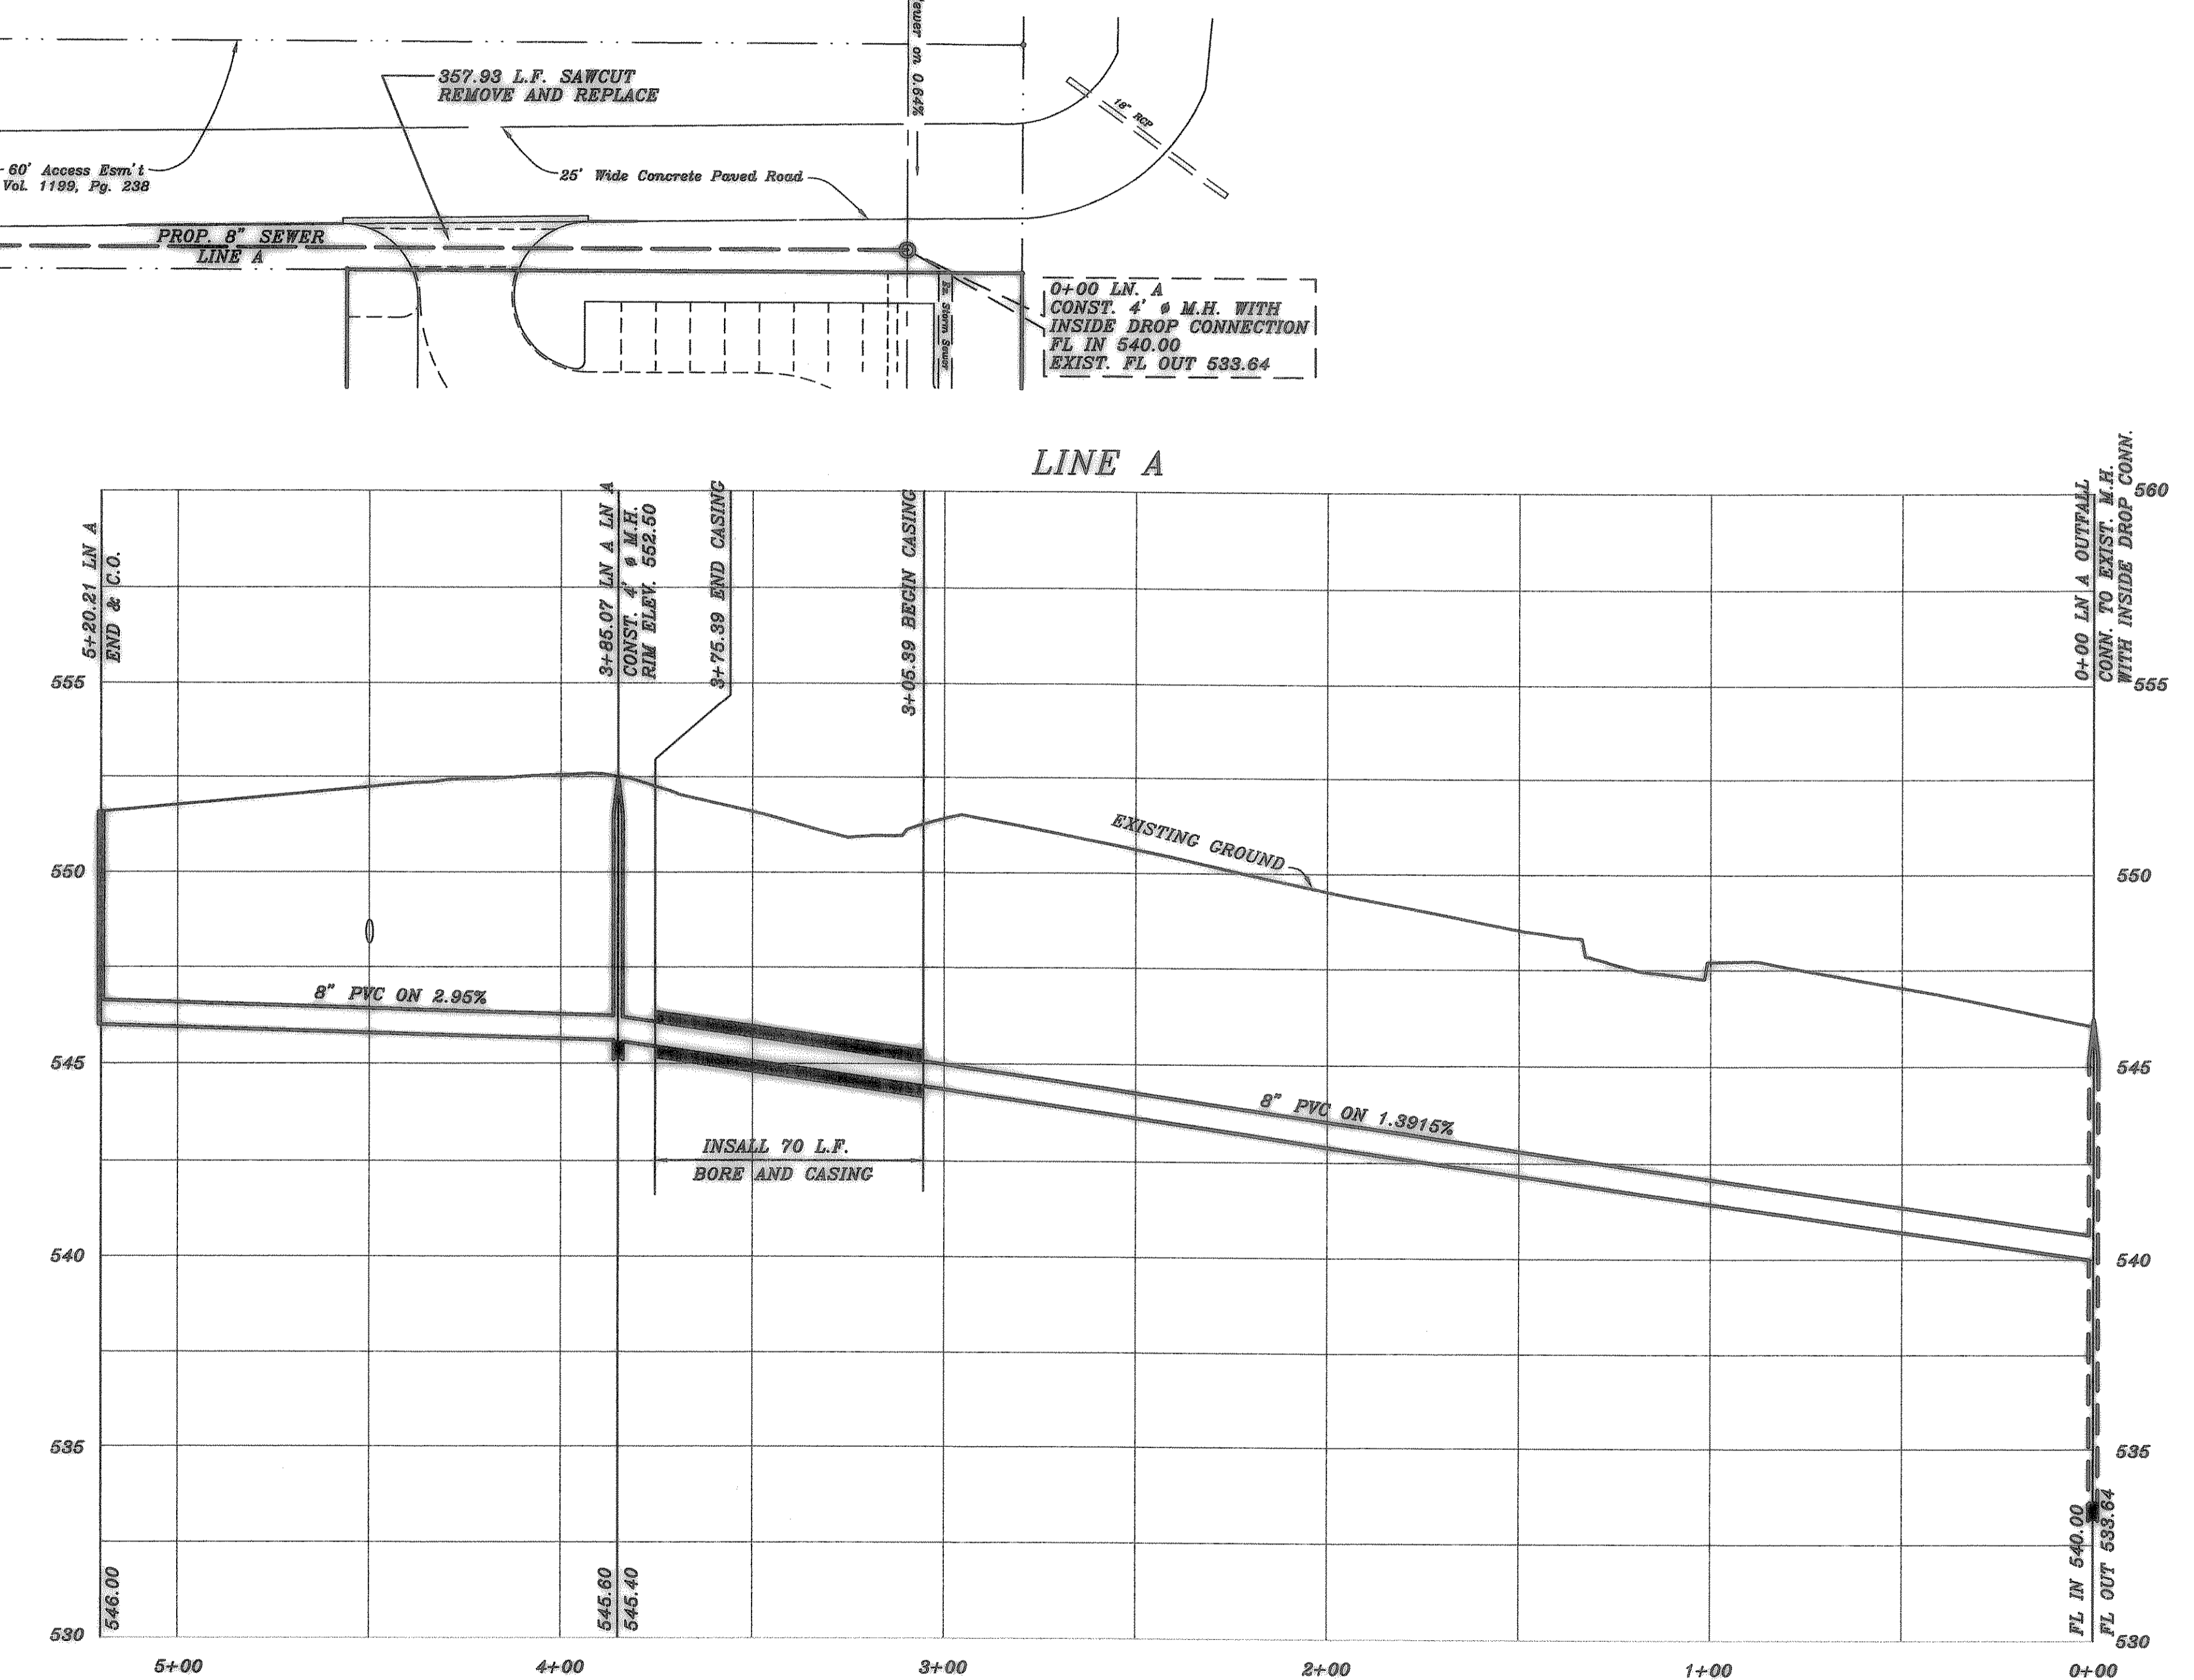


Sanitary Sewer Man Hole  
Top = 547.86  
F.L. In = 534.86  
F.L. Out = 534.76

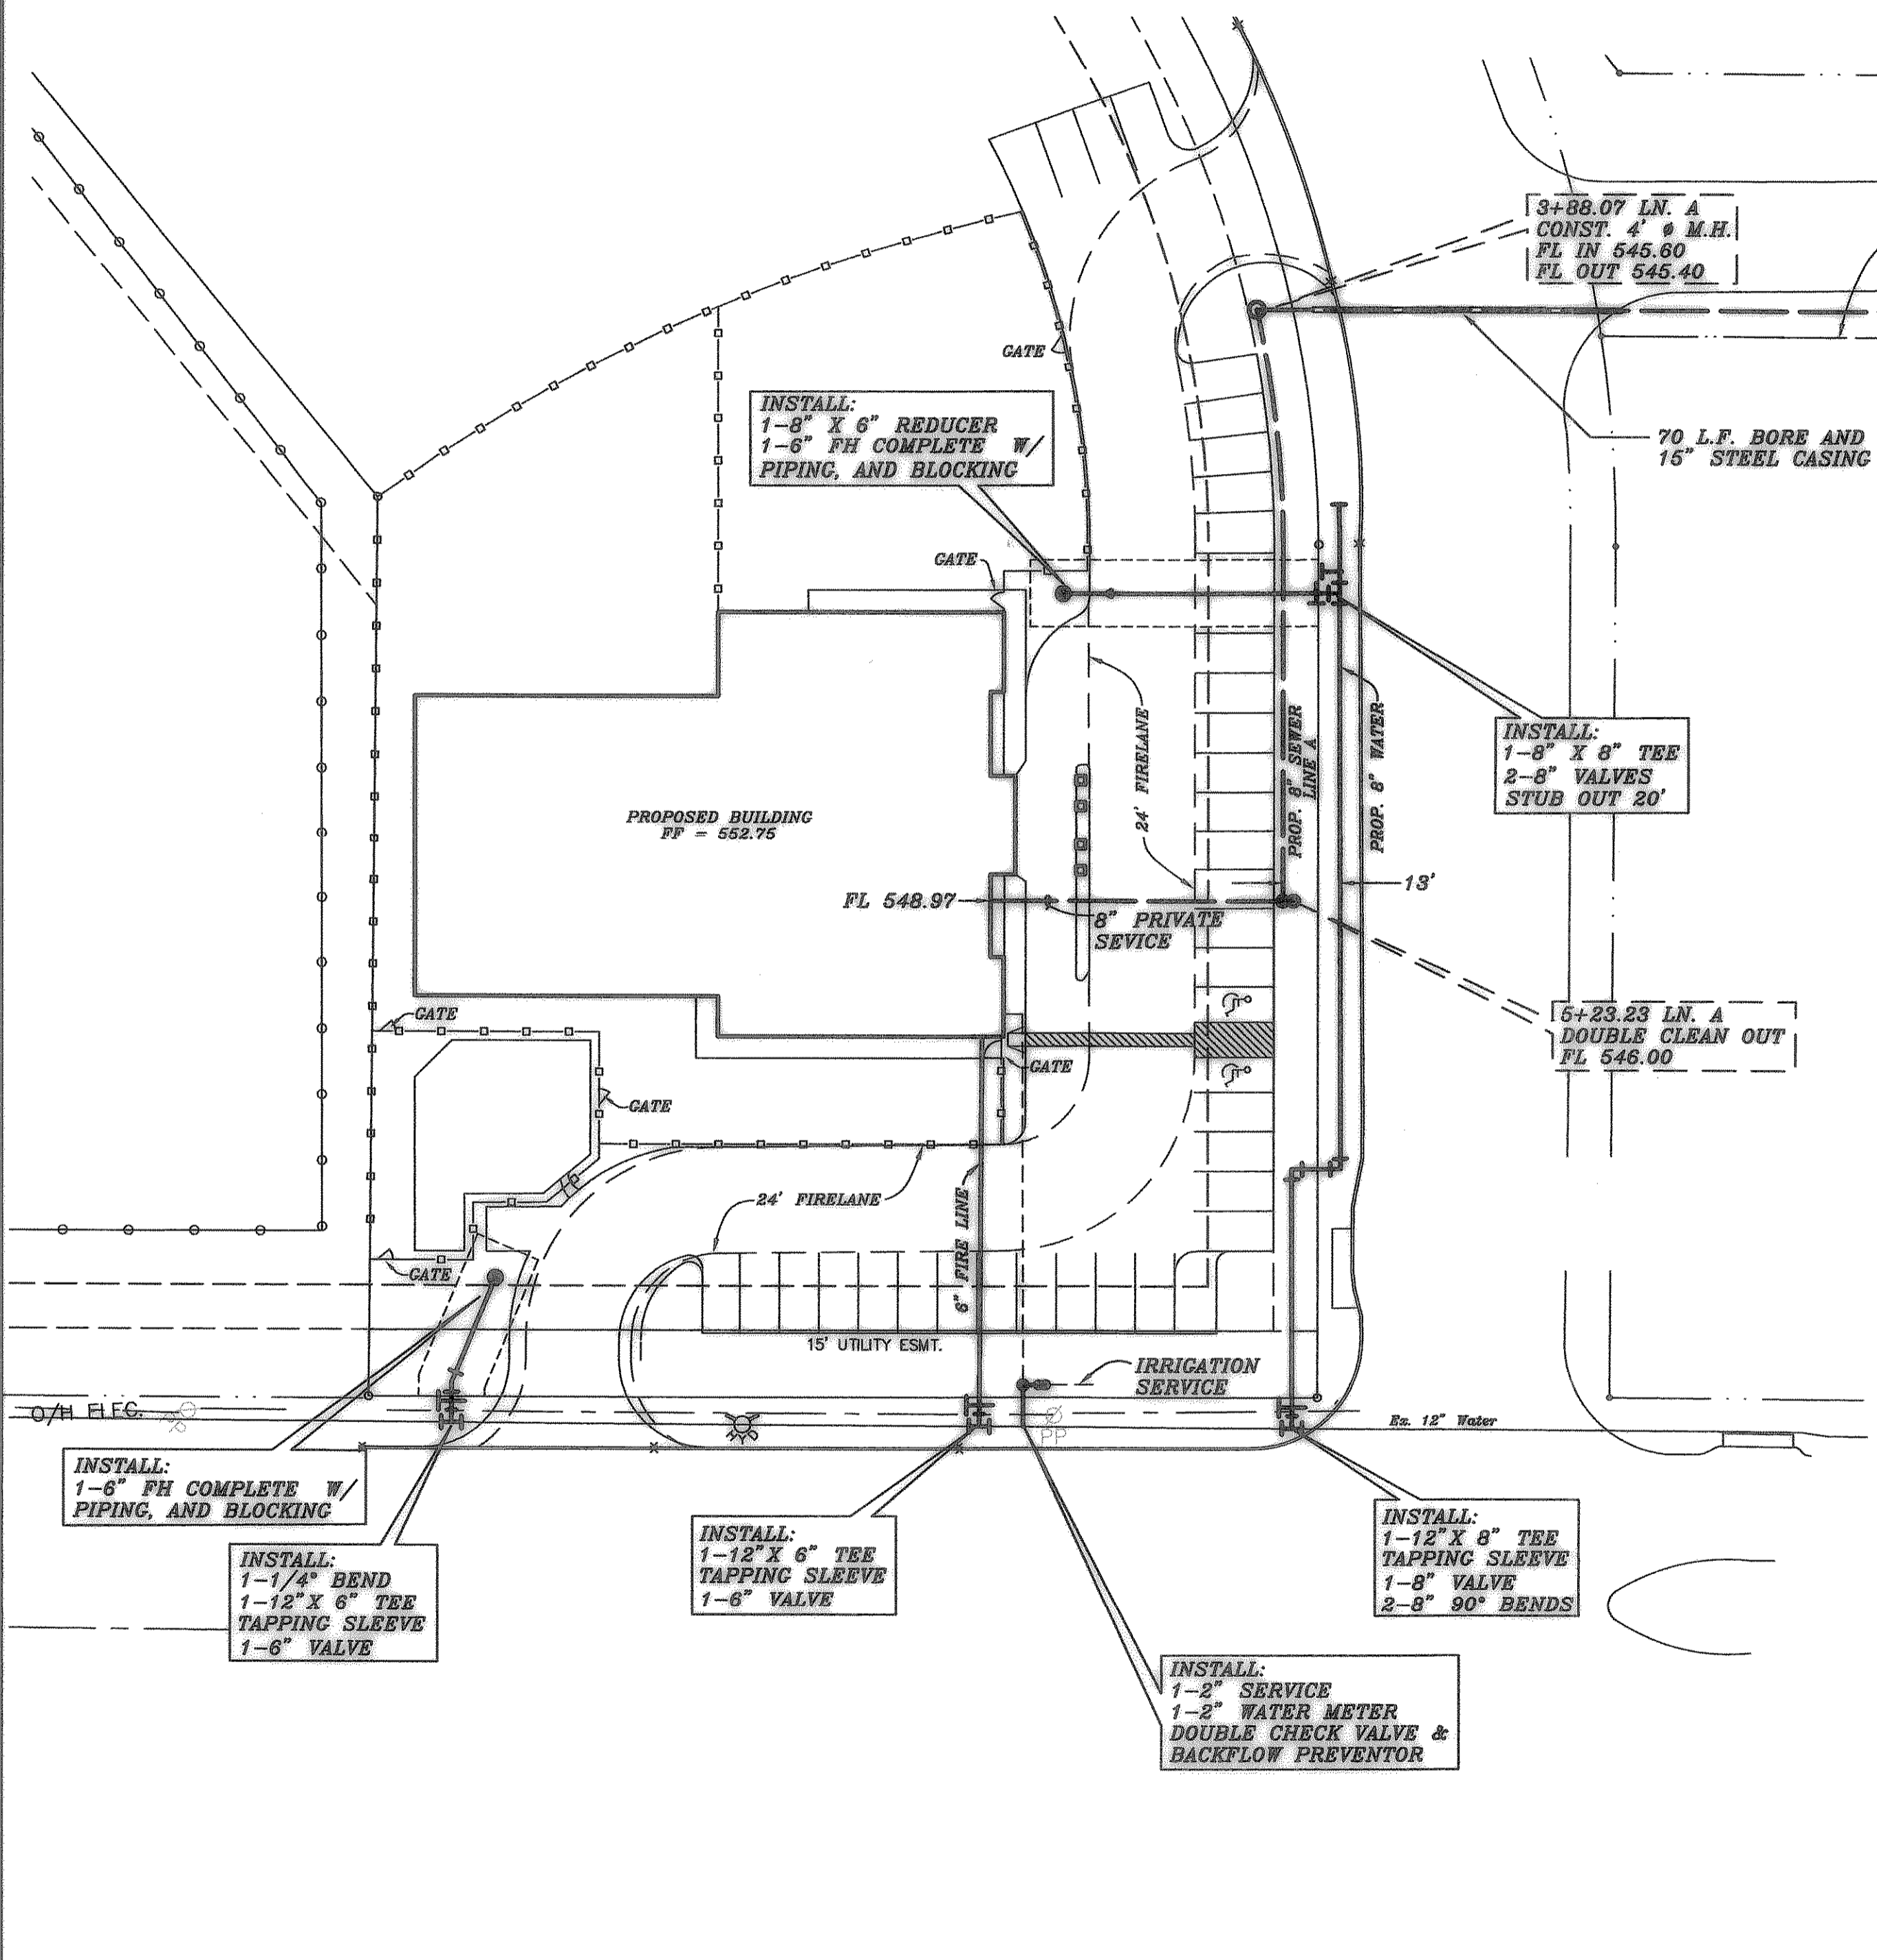

NOTE: 5' CLEARANCE AROUND ALL FIRE HYDRANTS.

AS BUILT

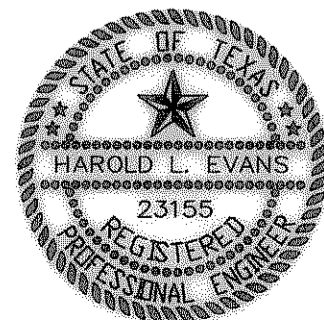

Handwritten signature and date: *Harold L. Evans*, 2/15/05

REVISION	DATE	SCALE	DESIGN	DRAWN
REVISION	1/17/05			
REVISION	1/27/05			
REVISION	2/15/05			
REVISION DESCRIPTION	12/8/04	1" = 30' 1" = 3'	H.L.E.	AC

**HAROLD L. EVANS**  
CONSULTING ENGINEER  
P.O. BOX 570365-76370  
2381 CUS THOMASSON ROAD, SUITE 102  
DALLAS, TEXAS 75228, ( 214 ) 328-8133

**UTILITY PLAN**  
**CHILDRENS PARK II**  
**STEGER TOWNE CROSSING, PHASE II**  
**CITY OF ROCKWALL**

SHEET NO.  
6  
7  
JOB NO.  
04053