

TEXAS LAND ENGINEERS, INC.
1201 SHEPHERD DRIVE
HOUSTON, TX 77007
PH: (281) 576-1085
FAX: (281) 576-1086


NO.	DATE	DESCRIPTION

CHILDRENS LIGHTHOUSE


3009 GOLIAD STREET

ROCKWALL, TEXAS


WATER LINE PLAN AND PROFILE

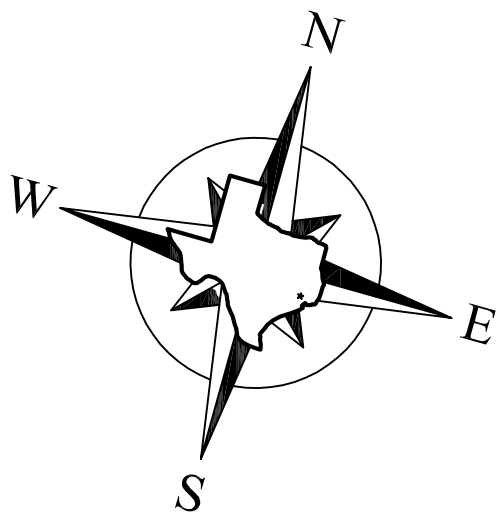

SCALE: 1"=20'

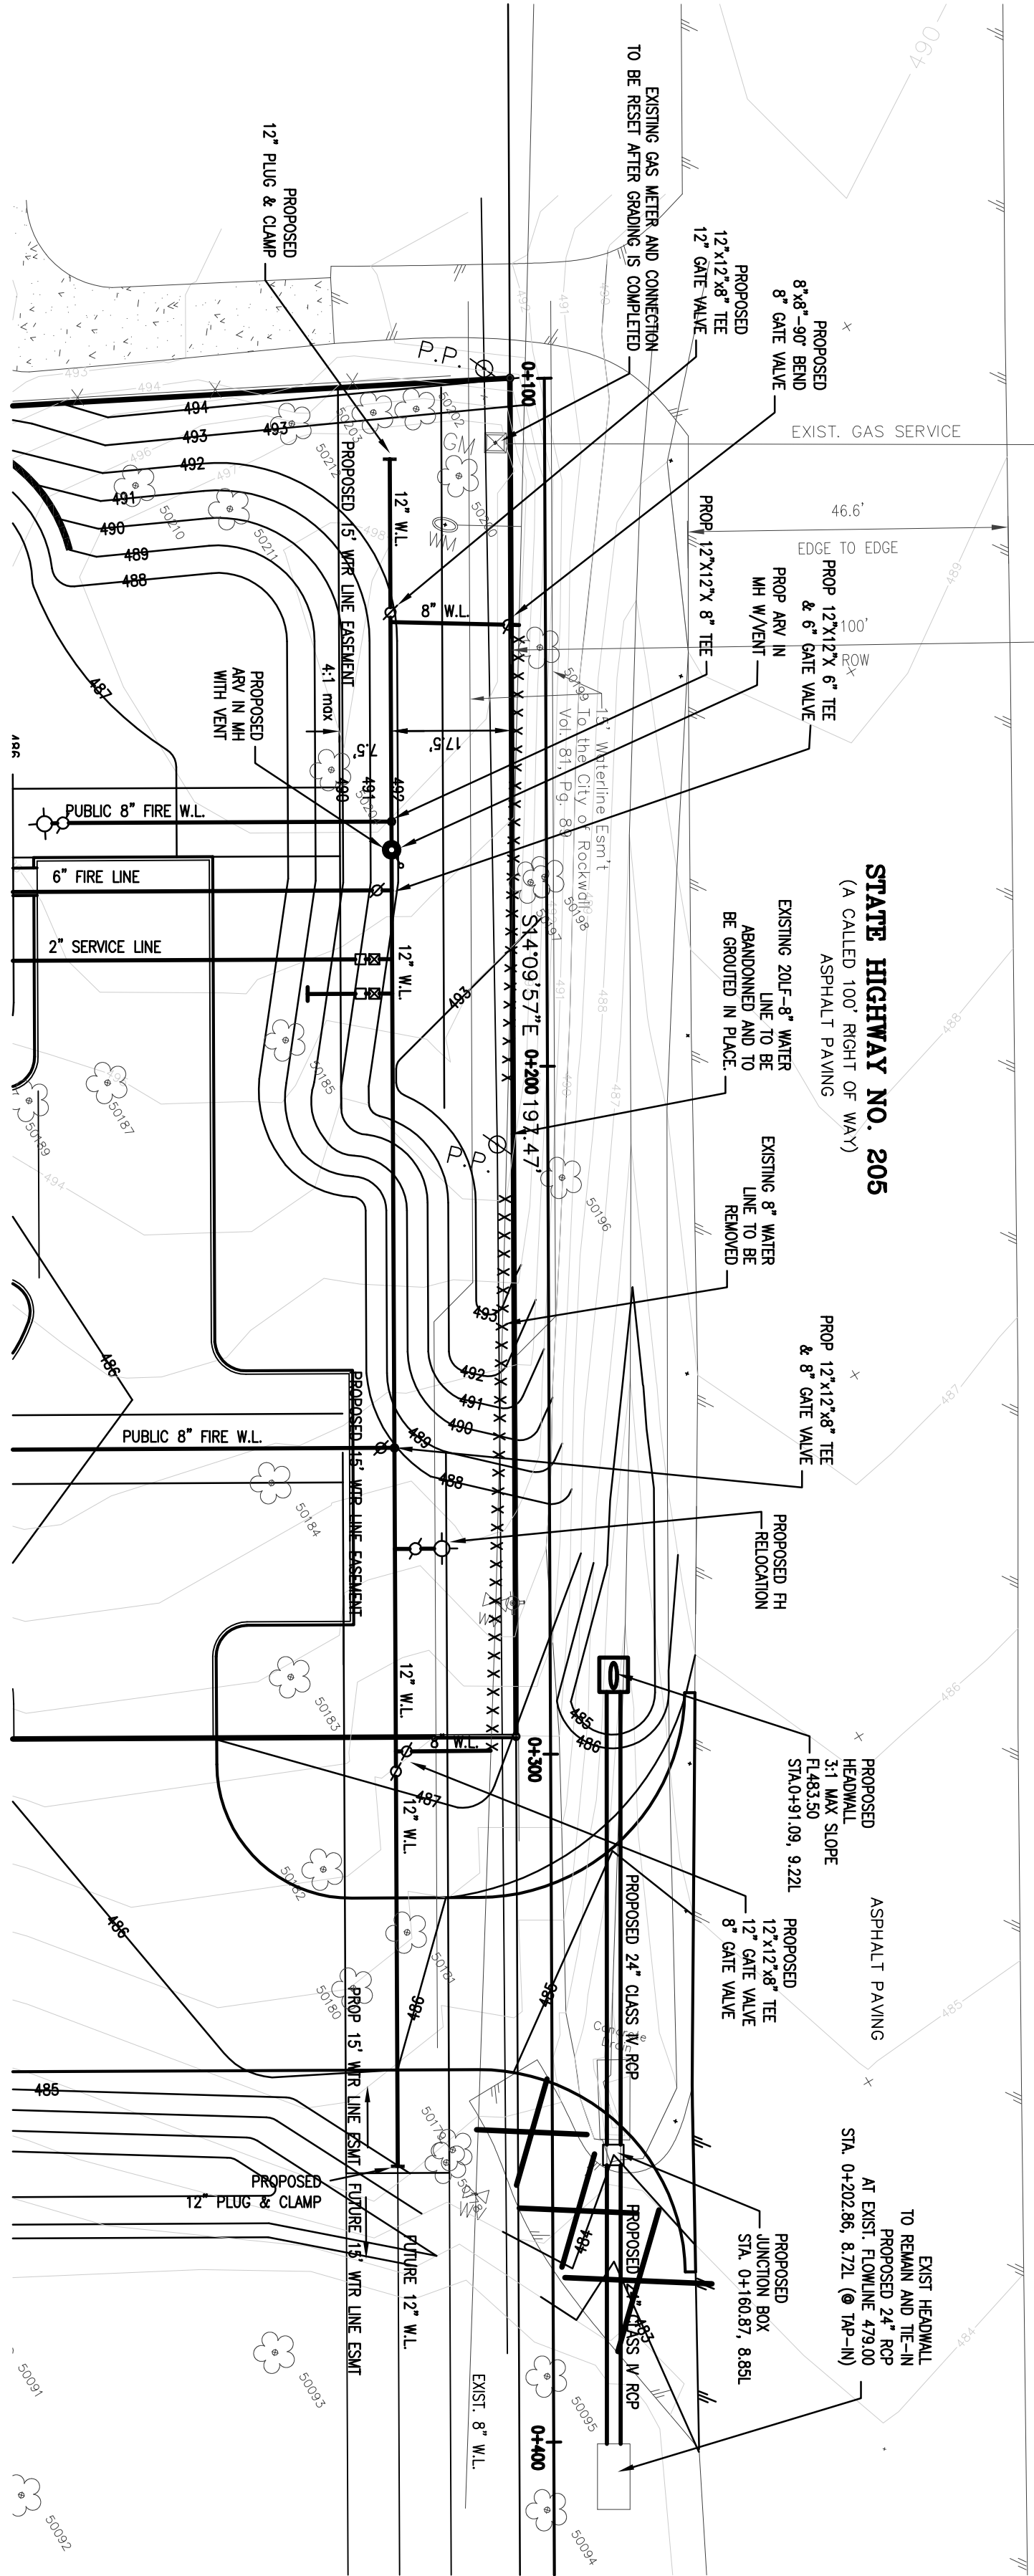

12" WATER LINE

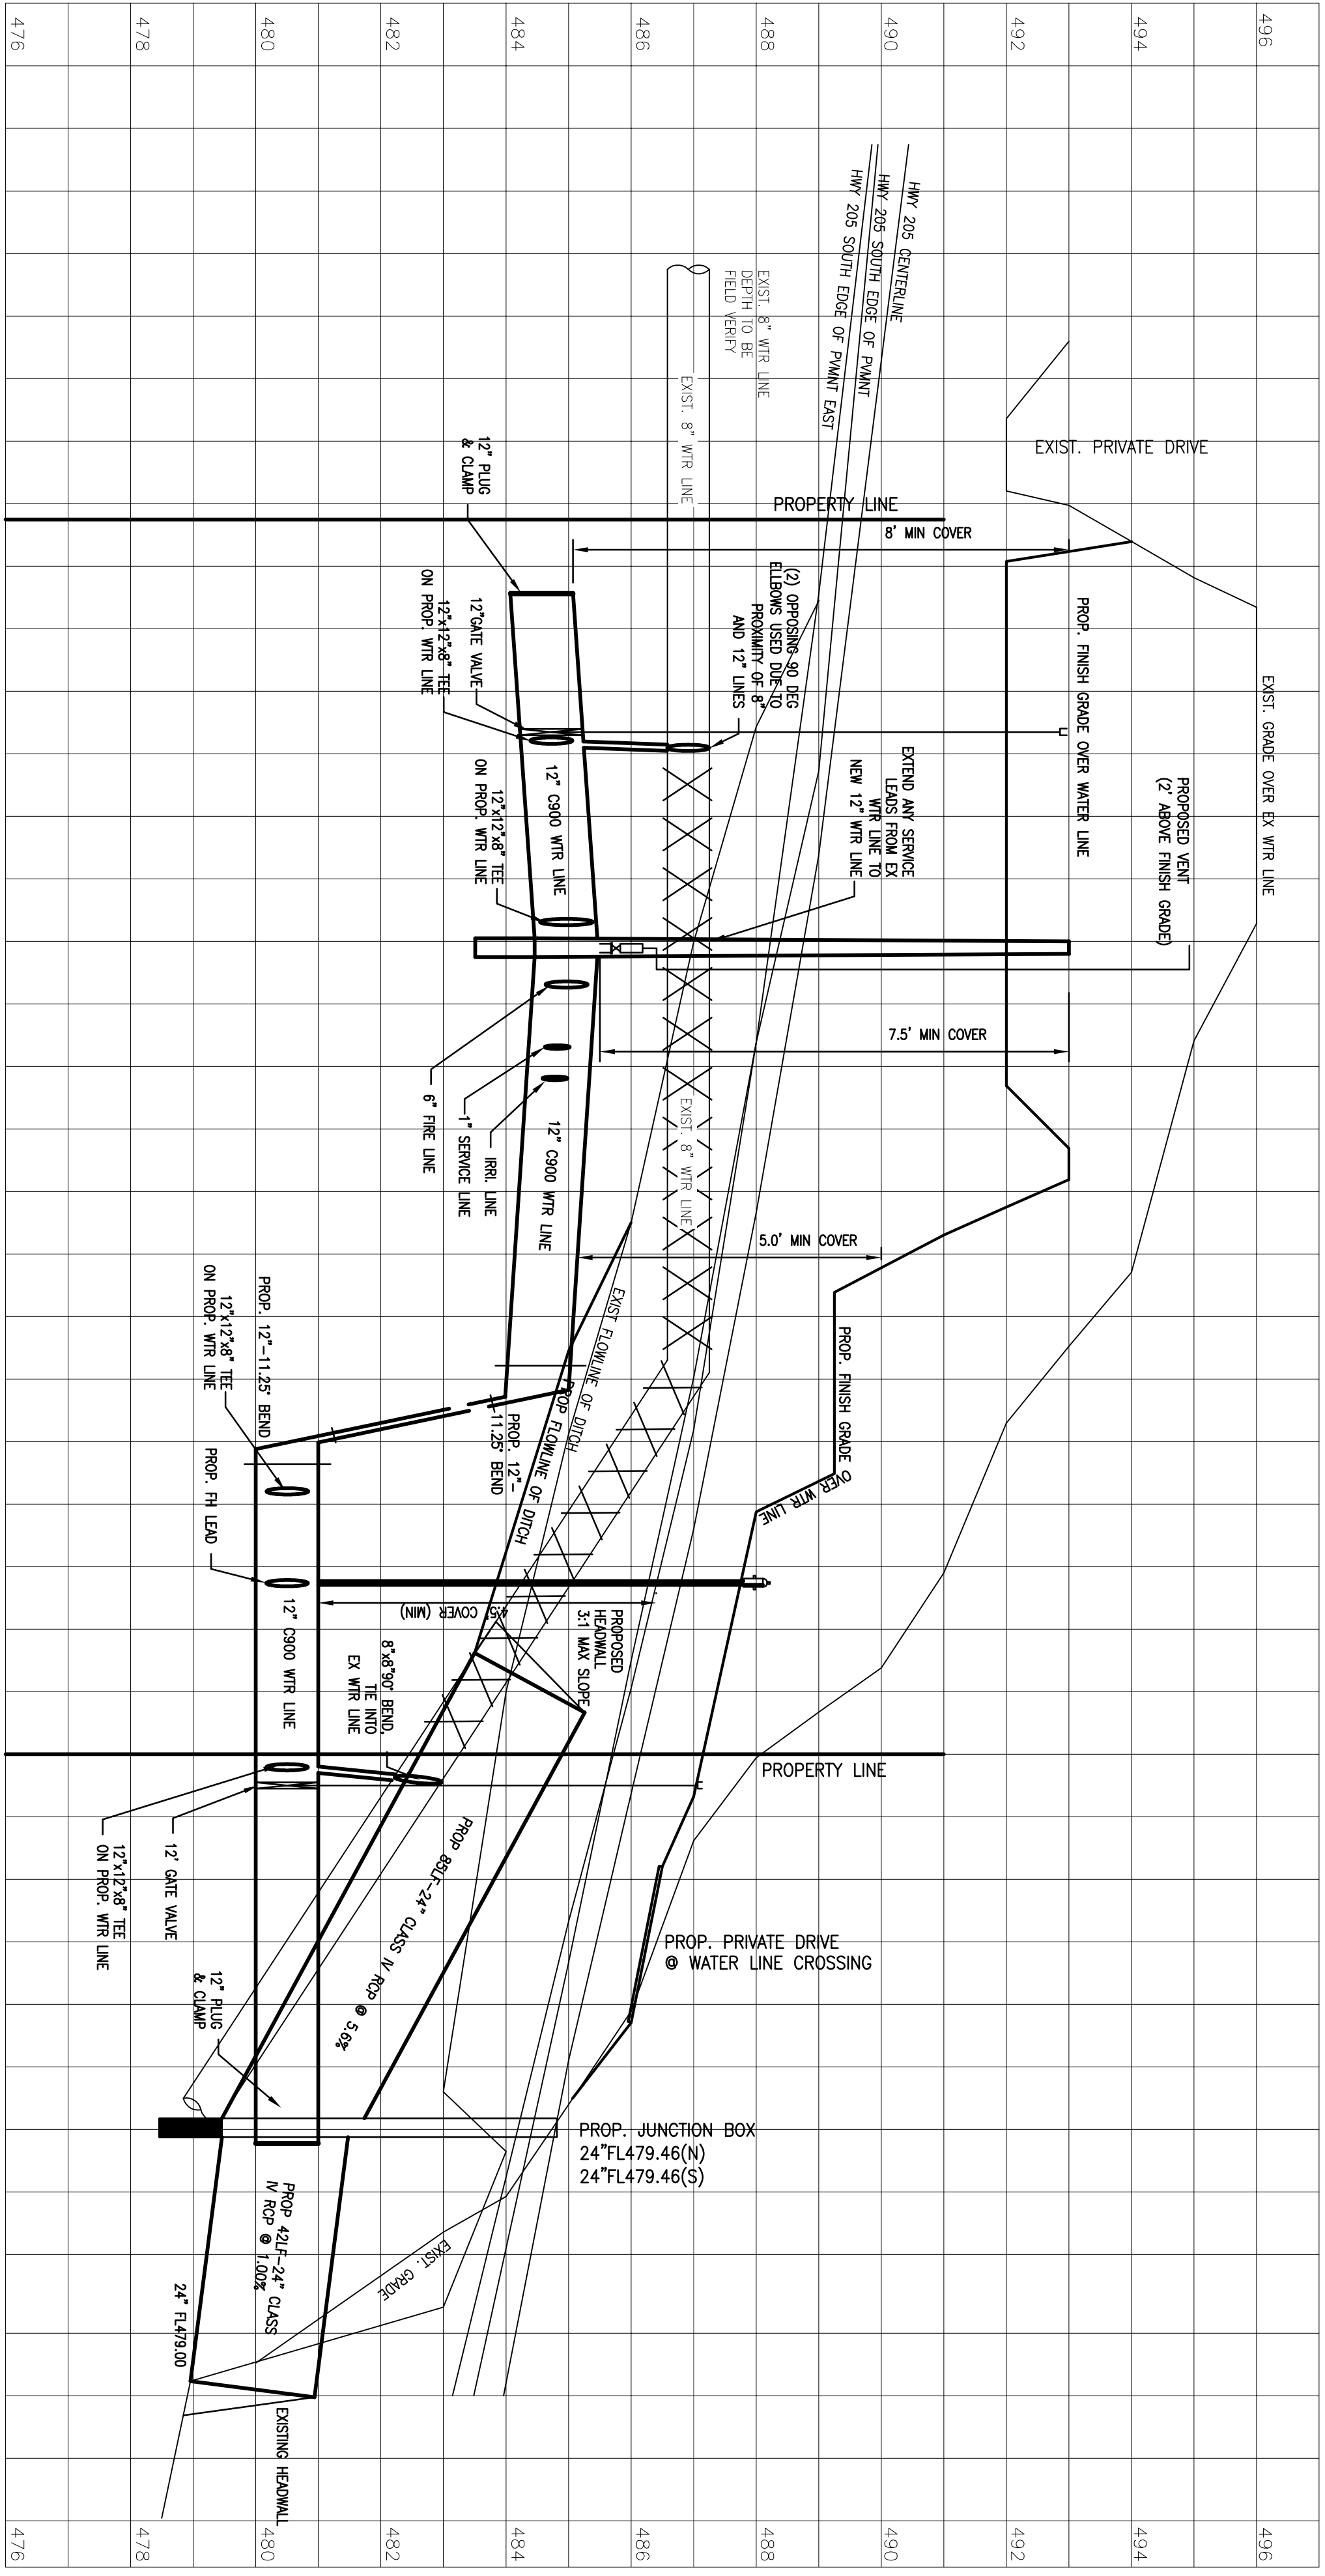

GENERAL NOTE

1. ALL WATER, FIRE LINES TO BE C900, DR-18, 200 PSI RATED.
2. ALL JOINTS AND BENDS TO BE RESTRAINED.
3. MINIMUM ALLOWABLE COVER OVER W.L. TO BE 4.5'.
4. LINES TO BE TESTED IN ACCORDANCE TO CITY OF ROCKWALL STANDARDS.

UTILITY LEGEND

SWR - SANITARY	ESMT - EXISTING
SNR - SEWER	PROP - PROPOSED
WL - WATER LINE	FF - FINISH FLOOR
WR - WATER	TO - TOP OF GATE
WM - WATER METER	TR - TOP OF RIM
RW - IRRIGATION WATER METER	FL - FLOW LINE
TS&V - TAP, SIZE & VALVE	AJ - ADJUST ELEVATION
RP - REDUCED PRESSURE BACKFLOW PREVENTOR	
STM - STORM	
MH - MANHOLE	
FI - FIRE HYDRANT	
UF - UNDER FEET	
CO - CLEAN OUT	

SCALE:

HORIZONTAL: 1"=20'
VERTICAL: 1"=2'

REGISTRATION NO. 1-9553
DATE: AUGUST 2009
DRAWN BY: DG
CHECKED BY: JG