

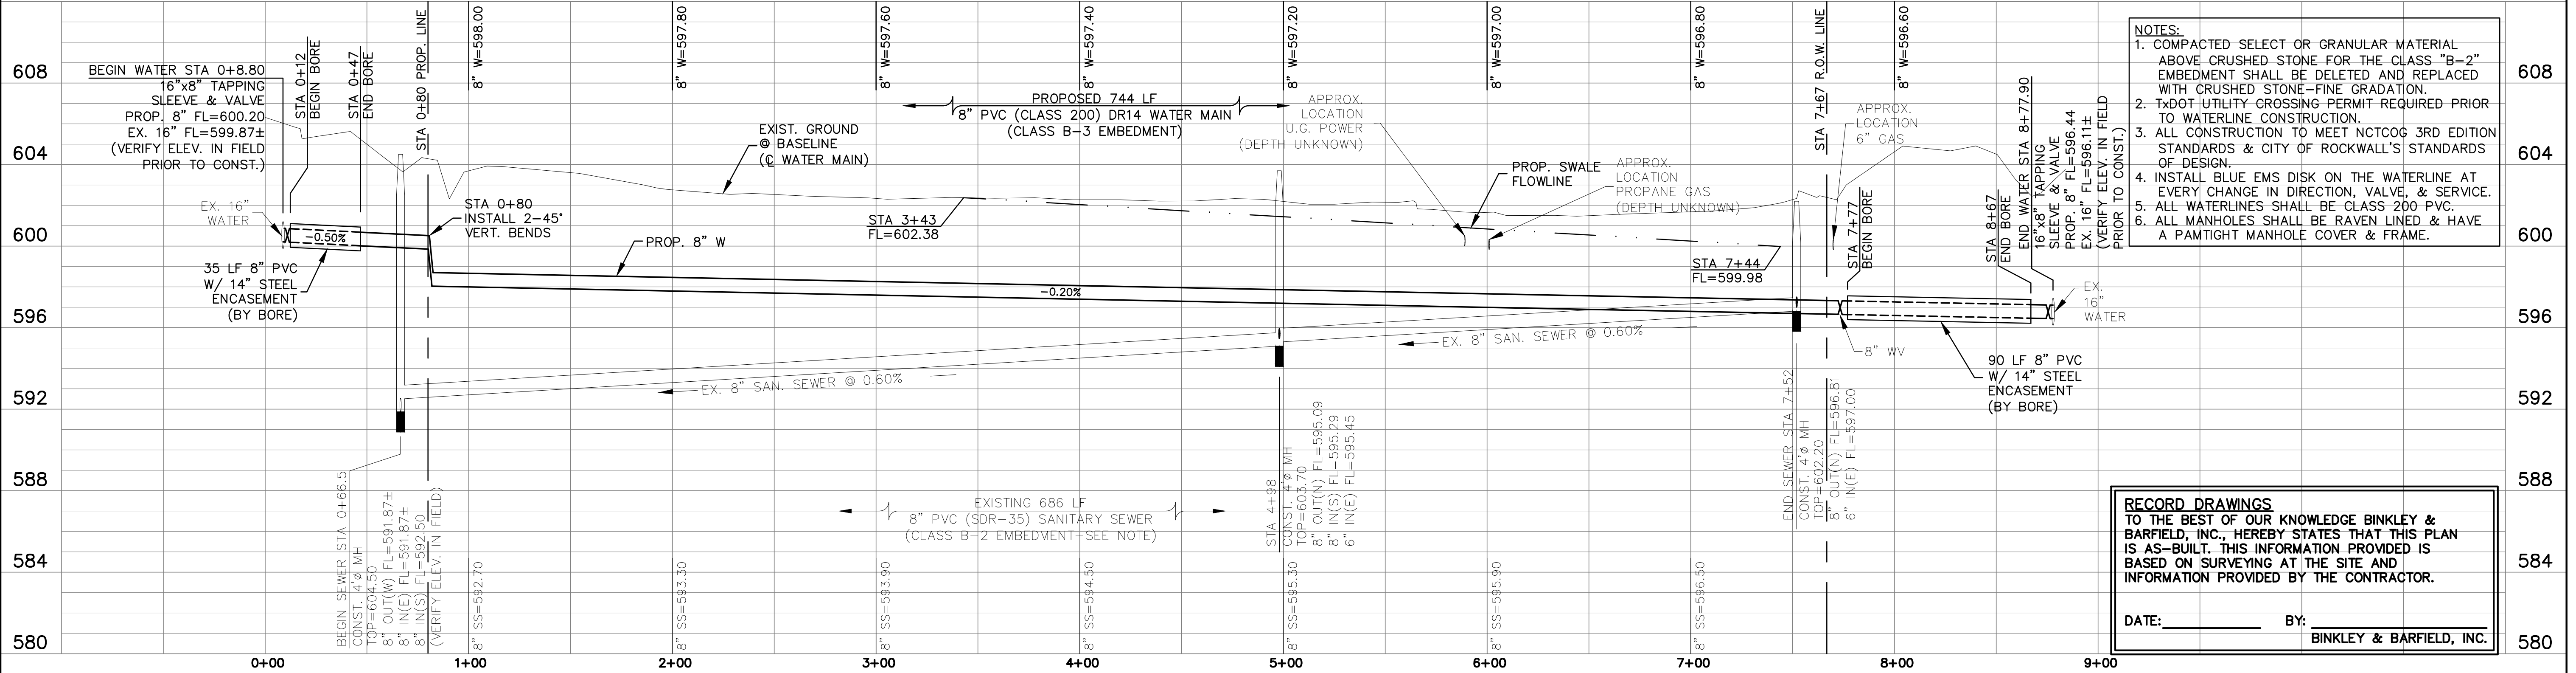


N:\BC14012 (DFW Insulation - Waterline)\05 CAD Files\C1-WATER_NEW.dwg-Model Plotted Apr 08, 2014 at 8:35am by konderson | Last Saved by: konderson

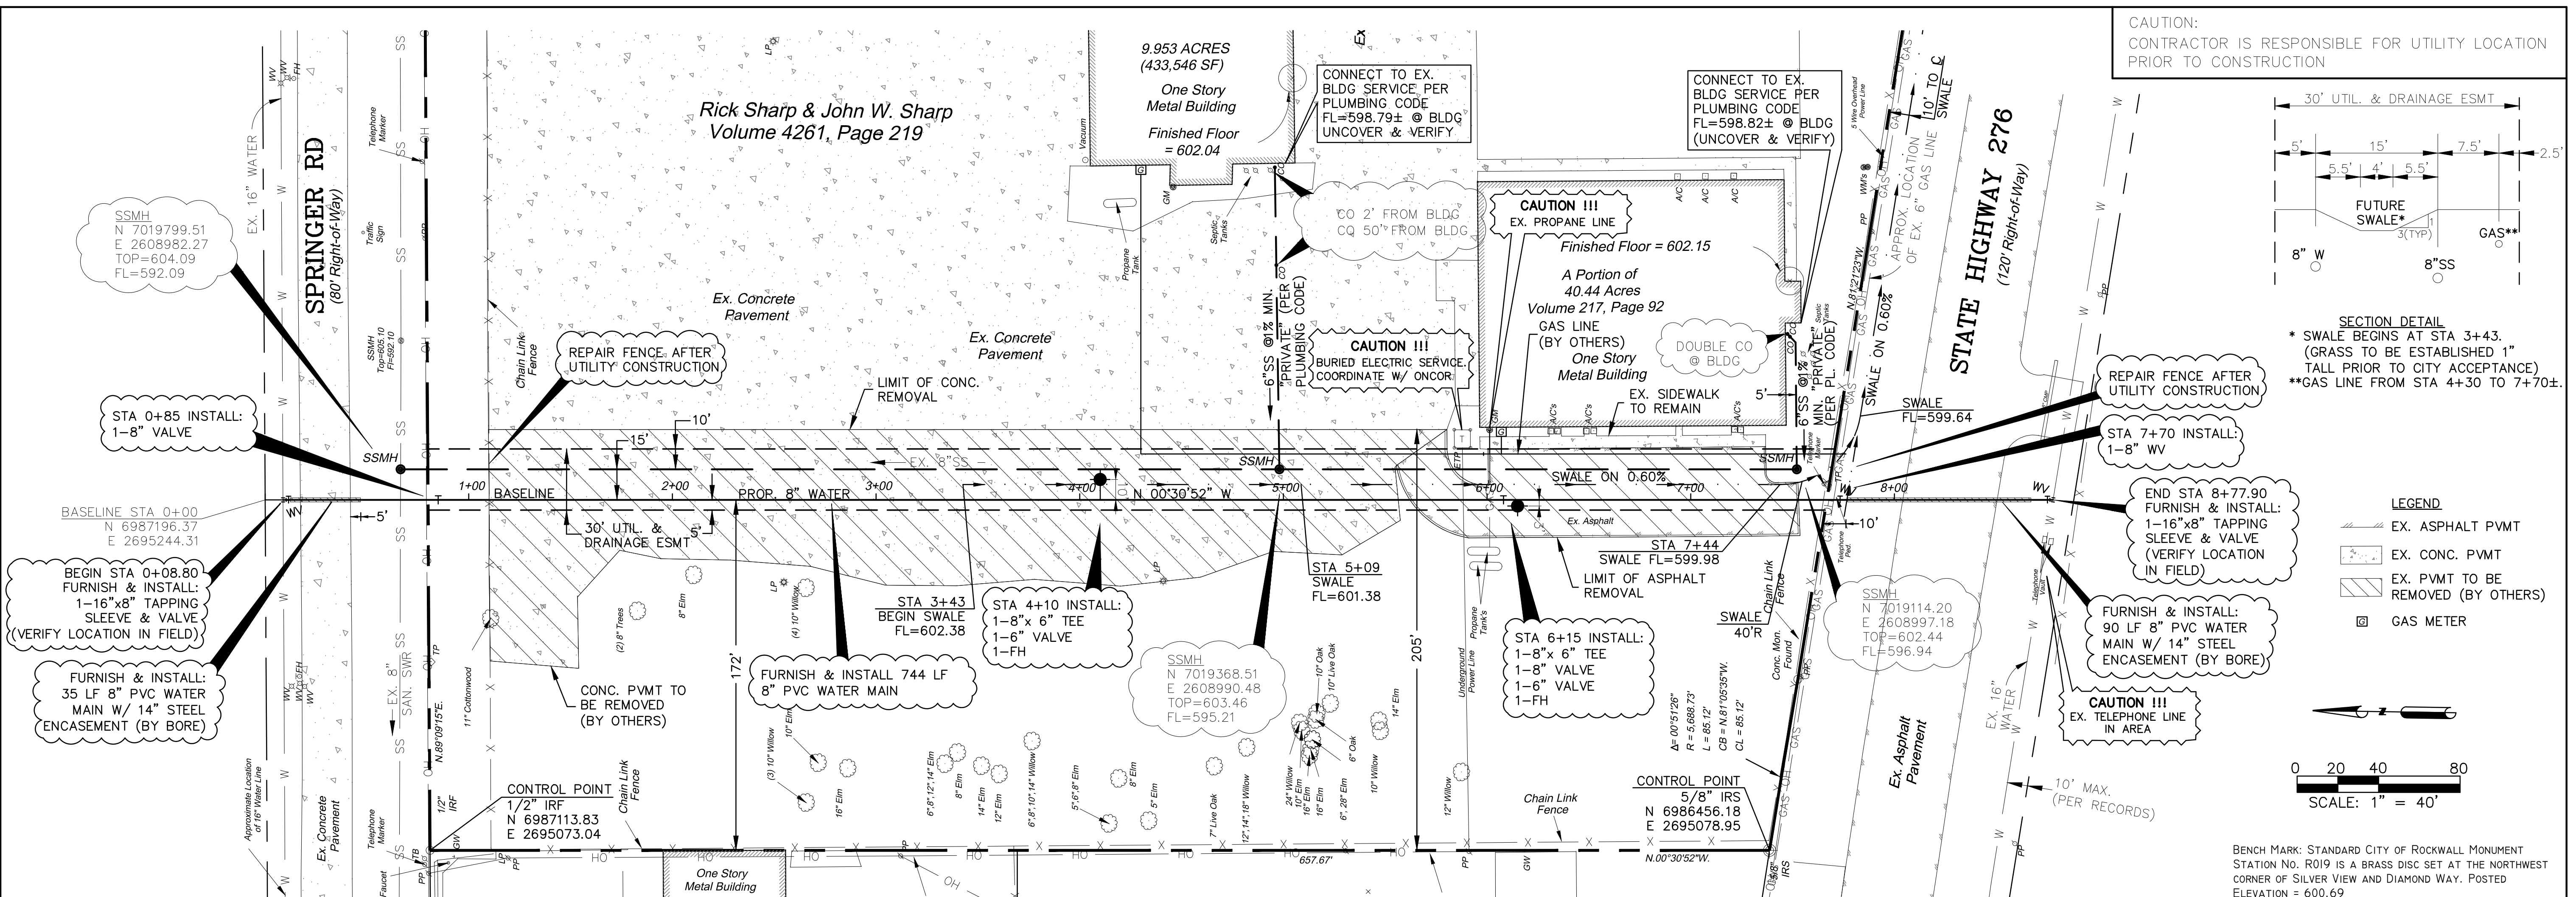

△				
△				
△				
△				
△				
Rev.	Date	Description	App.	Approved By:

Designed By: TPJ
Drawn By: JKA
Checked By: TPJ
Job No.: 14012
Date: 04/08/14
Scale: 1"=40'H(22"x34")
1"=4'V(22"x34")

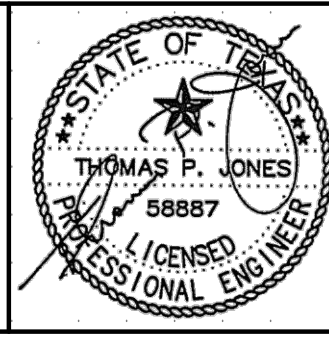

Binkley & Barfield | C&P
consulting engineers

DFW INSULATION
2578 HWY 276
ROCKWALL, TEXAS

SITE IMPROVEMENTS
UTILITY PLAN & PROFILE

Sheet No: **C1**
of _____