



1 SERVICE POLE DETAIL
NO SCALE

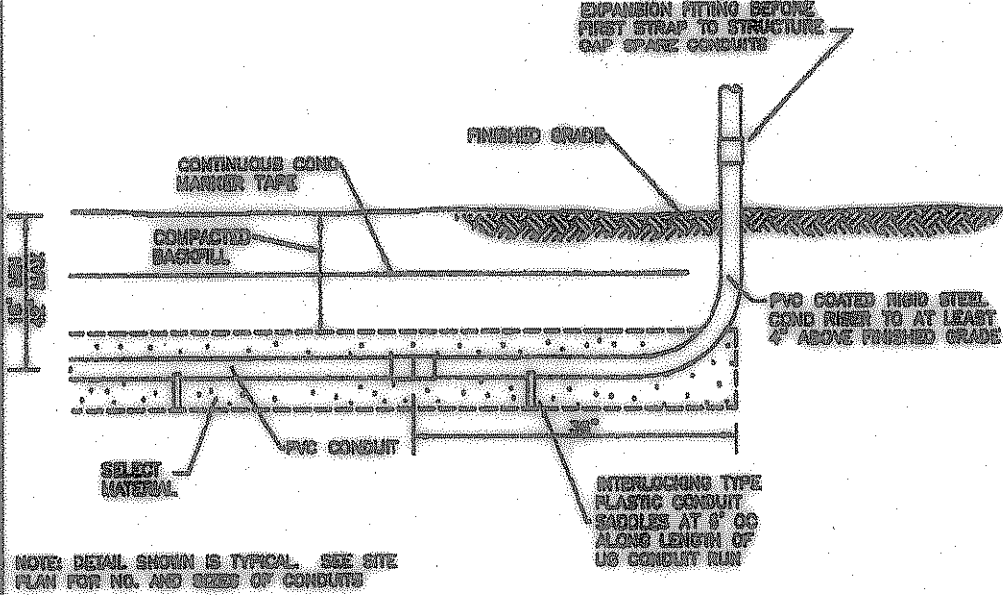


LONGITUDINAL SECTION

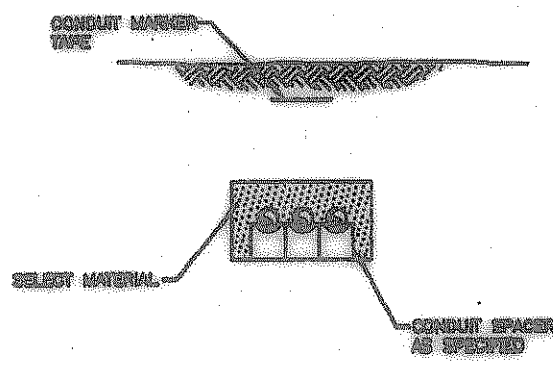


TRANSVERSE SECTION

2 UNDERGROUND CONDUIT RUN
NO SCALE

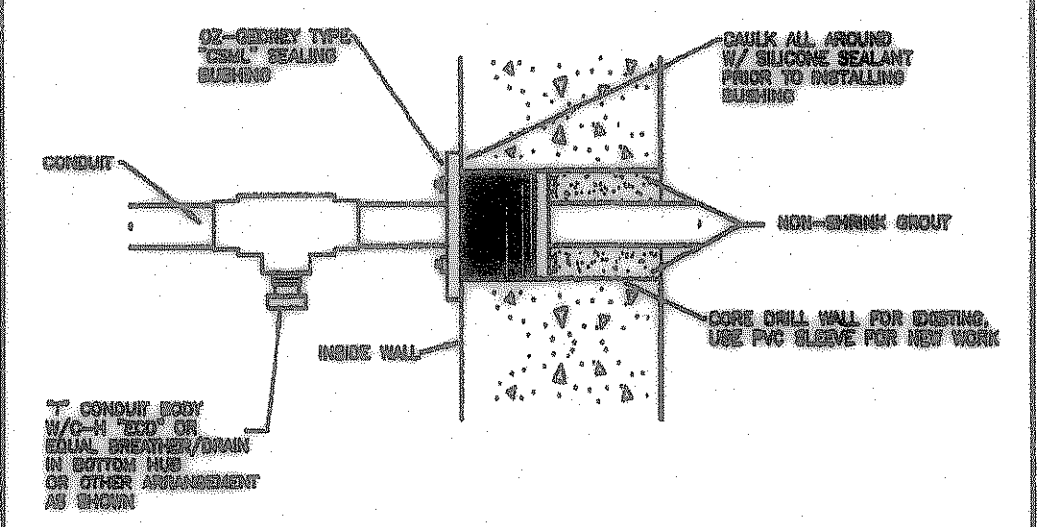

3 CONDUIT SEALING - BELOW GRADE
NO SCALE

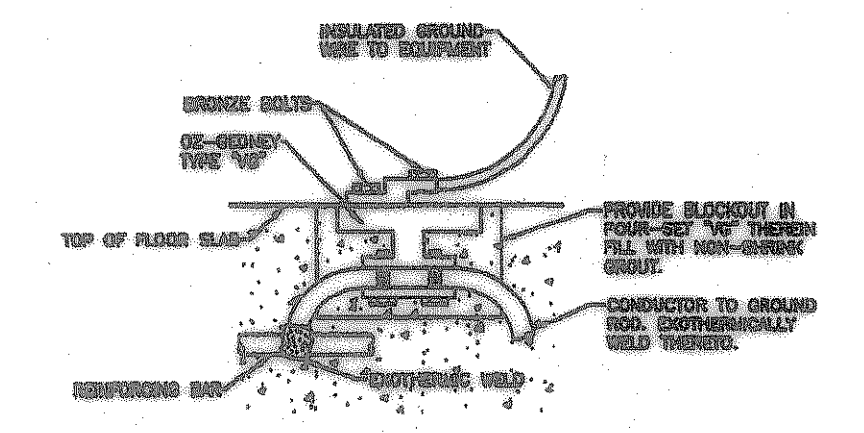

4 FLOOR GROUNDING CONNECTION DETAIL
NO SCALE

NO. DATE REVISION
BY

FONTANNA RANCH
FONTANNA LIFT STATION
LIFT STATION - ELECTRICAL DETAILS

STATE OF TEXAS
DANIEL LULLO
REGISTERED PROFESSIONAL ELECTRICAL ENGINEER
No. 08131
DATE: OCT. 2006
DESIGNED: DL
DRAWN: FJM
CHECKED: FJM
SHEET
L4
TOTAL SHEETS: 6

Lift Station Plan & Details
Fontanna Ranch
City of Rockwall, Rockwall County, Texas
Spring Haven Investments, Inc.
6700 Mineral Plaza Dr. • Suite 300 • Dallas, Texas 75269 • 972.384.3333
F.C. CUNY CORPORATION
22 Horizon Court • Heath, Texas 75032 • 409-402-7700
Drawn By: FJM Checked By: FJM Date: 10/10/06 Scale: As Noted Project No.: 08131 Sheet No.: 36 of 45