



CURVE DATA											
CY. NO.	Q	CV. NO.	Q	CV. NO.	Q	CV. NO.	Q	CV. NO.	Q	CV. NO.	Q
1	R 37'52.10'		2	R 37'41.07'		3	R 28'46.32'		4	R 28'36.54'	
	T 225.01'			T 225.01'			T 442.01'			T 328.50'	
	L 77.19'			L 76.78'			L 105.19'			L 77.70'	
	L 148.71'			L 147.99'			L 206.53'			L 152.59'	
5	R 34'41.09'		6	R 34'34.57'		7	R 18'35.50'		8	R 28'41.57'	
	T 328.50'			T 253.50'			T 153.60'			T 293.60'	
	L 102.59'			L 157.12'			L 22.38'			L 76.08'	
	L 158.87'			L 281.32'			L 44.45'			L 147.01'	
9	R 7'45.35'		10	R		11	R		12	R	
	T 213.91'			T			T			T	
	L 42.71'			L			L			L	

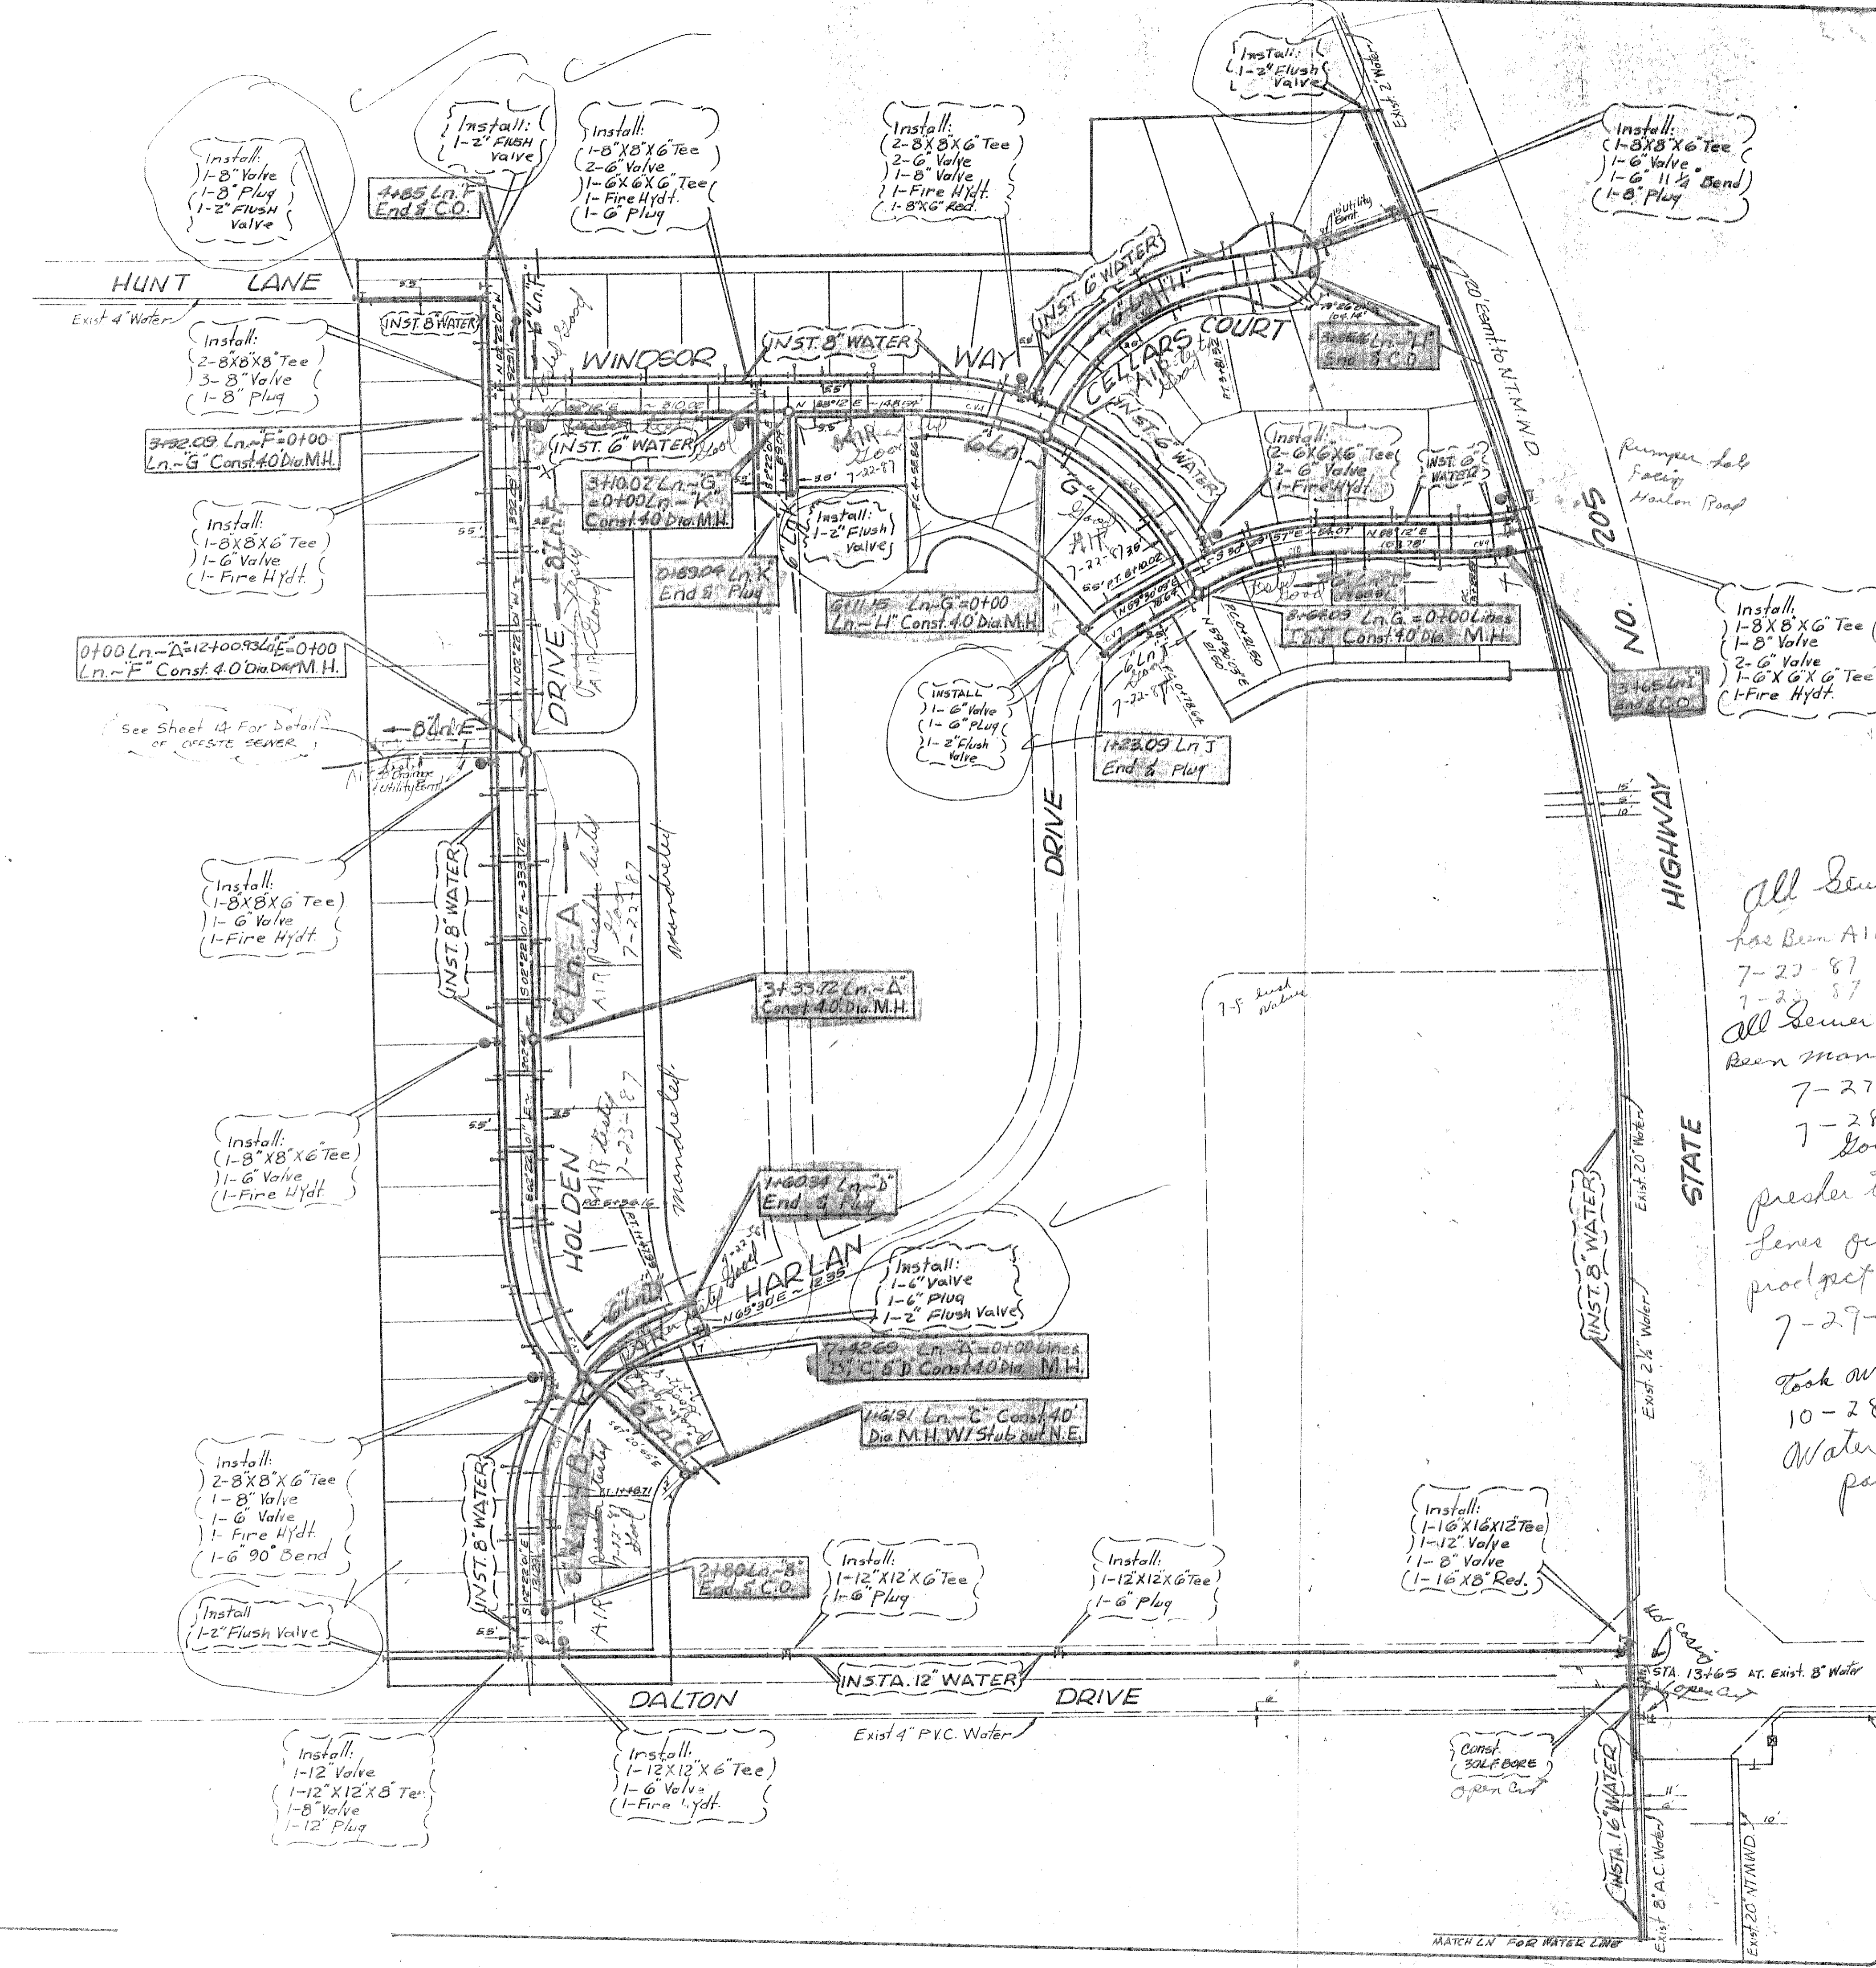

*All Sewer line  
has been AIR tested  
7-23-87 Good  
7-23-87  
All Sewer lines has  
been mandrelled  
7-27-87  
7-28-87  
Good  
pusher tested all water  
lines out fall and  
prodget tested Good  
7-29-87  
Took water samples  
10-28-87  
Water samples  
passed*

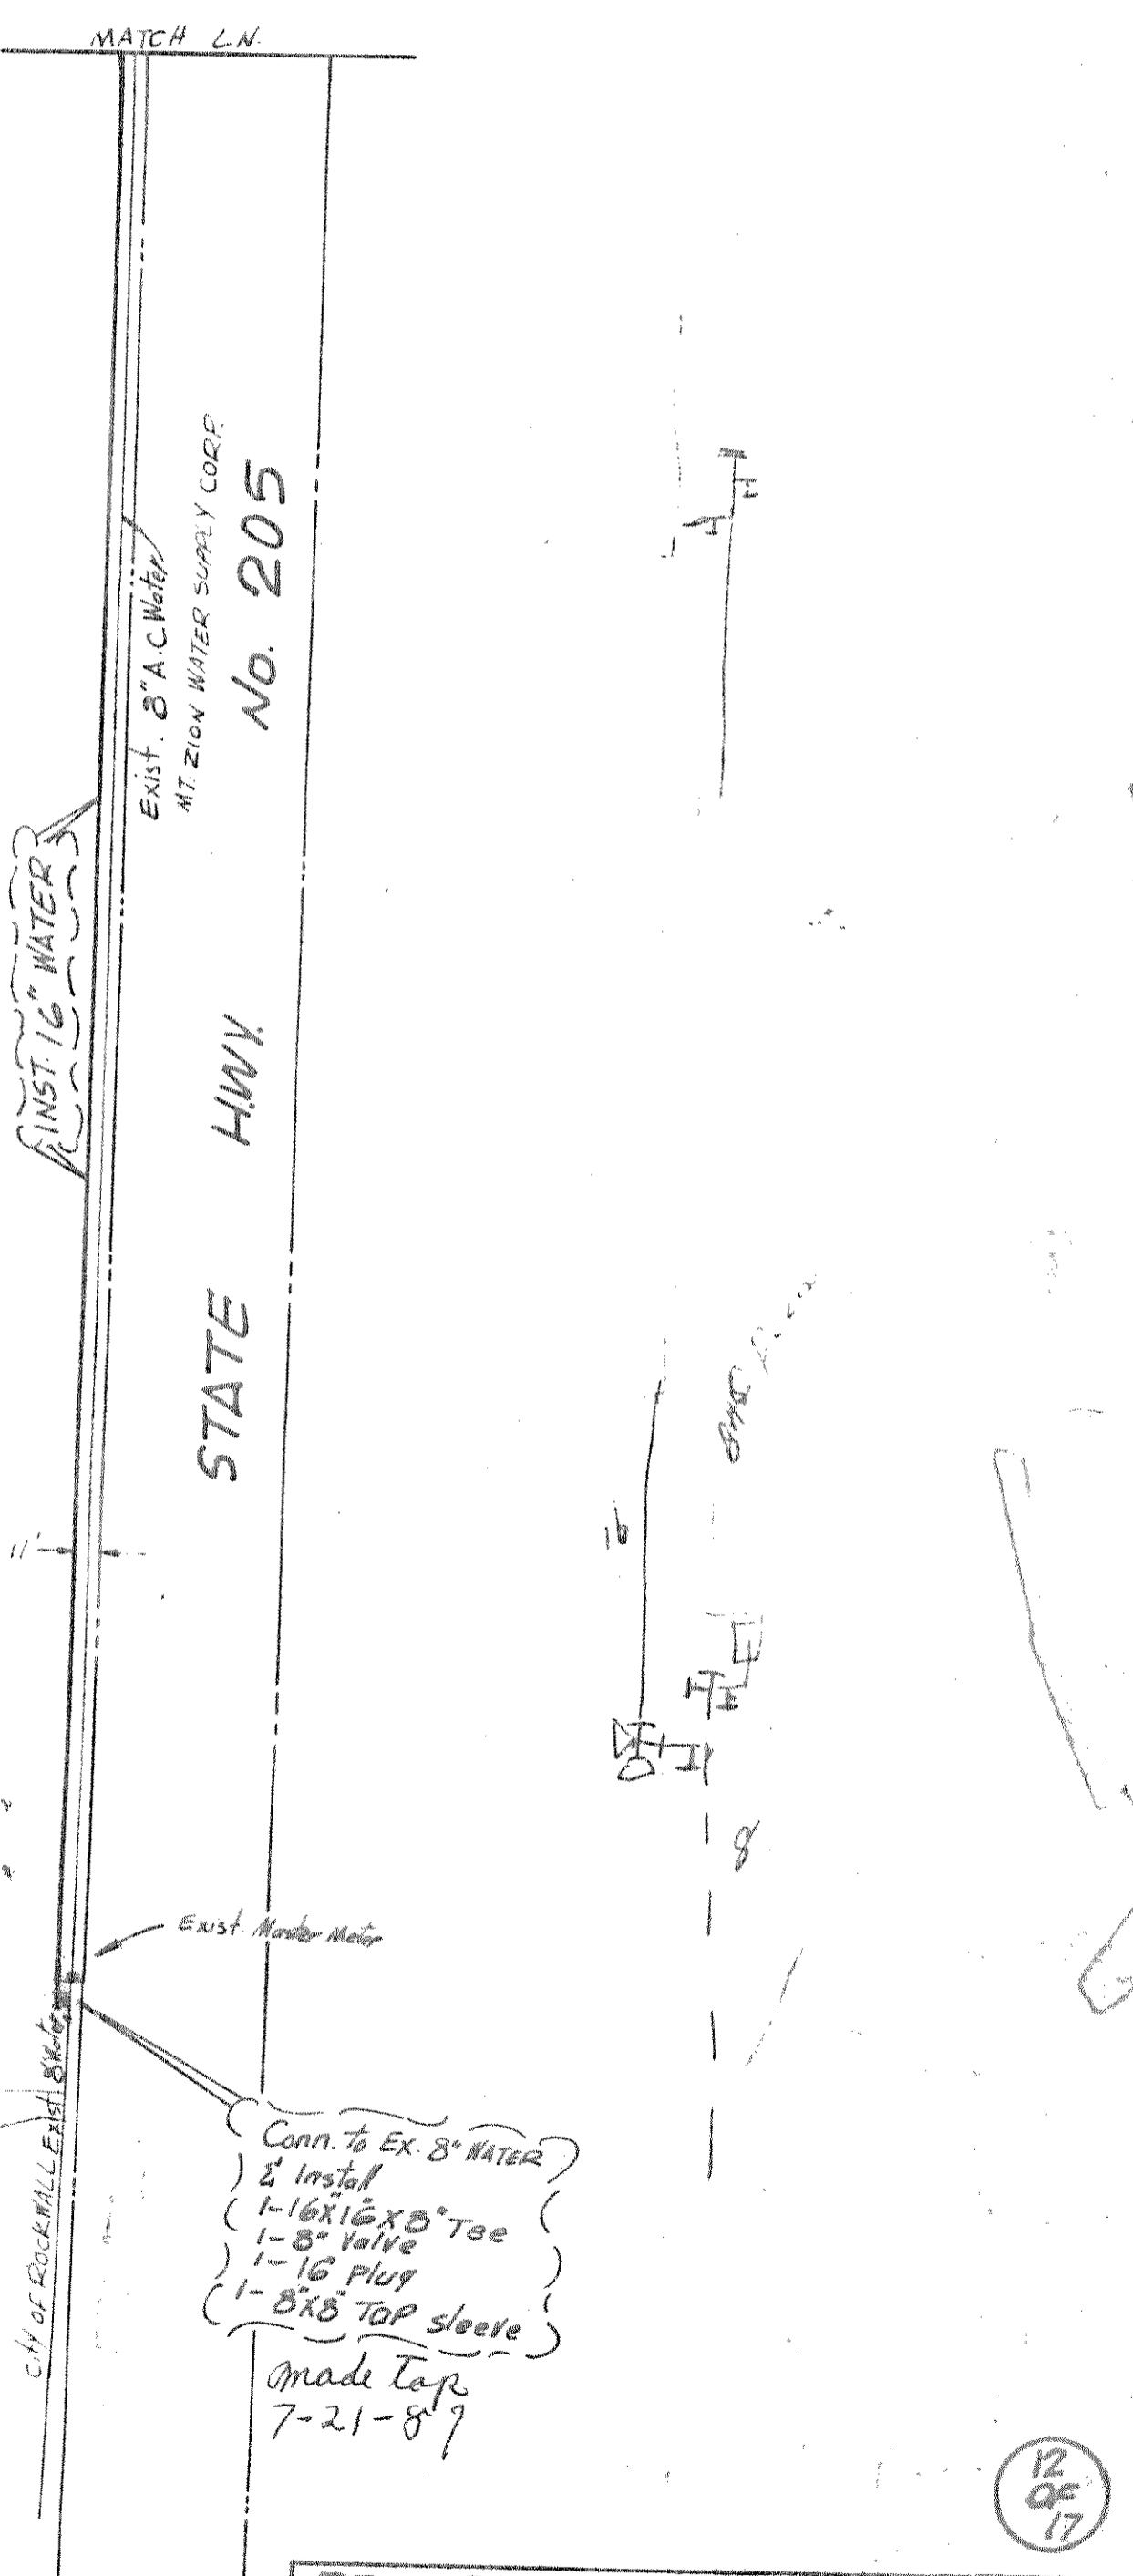

HAROLD L. EVANS CONSULTING ENGINEER 2331 GUS THOMASSON RD. SUITE 102 DALLAS, TEXAS 75228 PHONE (214) 328-8133			<b>UTILITY PLAN</b> <b>HARLAN PARK PHASE ONE</b> <b>CITY OF ROCKWALL</b> <b>ROCKWALL COUNTY, TEXAS</b>		
SCALE	DATE	JOB NO.			
1"=100'	3-25-84	83213			
Revised 1-17-85					